

โครงการปรับปรุงตึกโดมเพื่อเป็นศูนย์การเรียนรู้ มธ.ท่าพระจันทร์

นางวพระบรมมหาราชวัง เขตพระนคร
กรุงเทพมหานคร 1 รายการ (เฟส 3)

๔.๖



ออกแบบโดย ศูนย์วิศวกรรมทางออกแบบและวิจัย
คณะสถาปัตยกรรมศาสตร์และผังเมือง มหาวิทยาลัยธรรมศาสตร์ ศูนย์รังสิต จังหวัดปทุมธานี

๒

Handwritten signatures and initials at the bottom left of the page, including a signature that appears to be "GIR" and other initials.


NO	DESCRIPTION	UNIT	QTY	REMARKS
1	CEILING	Sq. M	100	
2	FLOOR	Sq. M	100	
3	WALL	Sq. M	100	
4	DOOR	No.	10	
5	WINDOW	No.	10	
6	ROOF	Sq. M	100	
7	STAIR	Sq. M	100	
8	LANDSCAPE	Sq. M	100	
9	PAVING	Sq. M	100	
10	CONCRETE	Sq. M	100	
11	BRICK	Sq. M	100	
12	STONE	Sq. M	100	
13	GLASS	Sq. M	100	
14	IRON	Sq. M	100	
15	STEEL	Sq. M	100	
16	ALUMINUM	Sq. M	100	
17	COPPER	Sq. M	100	
18	SILVER	Sq. M	100	
19	GOLD	Sq. M	100	
20	PLATINUM	Sq. M	100	
21	PALLADIUM	Sq. M	100	
22	RHODIUM	Sq. M	100	
23	PALADIUM	Sq. M	100	
24	OSMIUM	Sq. M	100	
25	IRIDIUM	Sq. M	100	
26	NEUTRON	Sq. M	100	
27	PROTON	Sq. M	100	
28	DEUTERON	Sq. M	100	
29	TRITON	Sq. M	100	
30	HELIUM	Sq. M	100	
31	LITHIUM	Sq. M	100	
32	BERYLLIUM	Sq. M	100	
33	BORON	Sq. M	100	
34	CARBON	Sq. M	100	
35	NITROGEN	Sq. M	100	
36	OXYGEN	Sq. M	100	
37	FLUORINE	Sq. M	100	
38	NEON	Sq. M	100	
39	SODIUM	Sq. M	100	
40	MAGNESIUM	Sq. M	100	
41	ALUMINUM	Sq. M	100	
42	SILICON	Sq. M	100	
43	PHOSPHORUS	Sq. M	100	
44	SULFUR	Sq. M	100	
45	CHLORINE	Sq. M	100	
46	ARGON	Sq. M	100	
47	POTASSIUM	Sq. M	100	
48	CALCIUM	Sq. M	100	
49	SCANDIUM	Sq. M	100	
50	TITANIUM	Sq. M	100	
51	VANADIUM	Sq. M	100	
52	CHROMIUM	Sq. M	100	
53	MANGANESE	Sq. M	100	
54	IRON	Sq. M	100	
55	COBALT	Sq. M	100	
56	NICKEL	Sq. M	100	
57	COPPER	Sq. M	100	
58	ZINC	Sq. M	100	
59	GERMANIUM	Sq. M	100	
60	ARSENIC	Sq. M	100	
61	SELENIUM	Sq. M	100	
62	BROMINE	Sq. M	100	
63	KRYPTON	Sq. M	100	
64	XENON	Sq. M	100	
65	CESIUM	Sq. M	100	
66	BARIUM	Sq. M	100	
67	LANTHANUM	Sq. M	100	
68	CERIUM	Sq. M	100	
69	PRASEODYMIUM	Sq. M	100	
70	NEODYMIUM	Sq. M	100	
71	PROMETHIUM	Sq. M	100	
72	SAMARIUM	Sq. M	100	
73	EUROPEUM	Sq. M	100	
74	GADOLINIUM	Sq. M	100	
75	TERBIUM	Sq. M	100	
76	DYSPROSIUM	Sq. M	100	
77	HOLOMIUM	Sq. M	100	
78	ERBIUM	Sq. M	100	
79	THULIUM	Sq. M	100	
80	YTERBIUM	Sq. M	100	
81	LUTETIUM	Sq. M	100	
82	HAFNIUM	Sq. M	100	
83	TANTALUM	Sq. M	100	
84	TUNGSTEN	Sq. M	100	
85	RHENIUM	Sq. M	100	
86	PALLADIUM	Sq. M	100	
87	RHODIUM	Sq. M	100	
88	PALADIUM	Sq. M	100	
89	OSMIUM	Sq. M	100	
90	IRIDIUM	Sq. M	100	
91	NEUTRON	Sq. M	100	
92	PROTON	Sq. M	100	
93	DEUTERON	Sq. M	100	
94	TRITON	Sq. M	100	
95	HELIUM	Sq. M	100	
96	LITHIUM	Sq. M	100	
97	BERYLLIUM	Sq. M	100	
98	BORON	Sq. M	100	
99	CARBON	Sq. M	100	
100	NITROGEN	Sq. M	100	

NO	DESCRIPTION	UNIT	QTY	REMARKS
1	CEILING	Sq. M	100	
2	FLOOR	Sq. M	100	
3	WALL	Sq. M	100	
4	DOOR	No.	10	
5	WINDOW	No.	10	
6	ROOF	Sq. M	100	
7	STAIR	Sq. M	100	
8	LANDSCAPE	Sq. M	100	
9	PAVING	Sq. M	100	
10	CONCRETE	Sq. M	100	
11	BRICK	Sq. M	100	
12	STONE	Sq. M	100	
13	GLASS	Sq. M	100	
14	IRON	Sq. M	100	
15	STEEL	Sq. M	100	
16	ALUMINUM	Sq. M	100	
17	COPPER	Sq. M	100	
18	SILVER	Sq. M	100	
19	GOLD	Sq. M	100	
20	PLATINUM	Sq. M	100	
21	PALLADIUM	Sq. M	100	
22	RHODIUM	Sq. M	100	
23	PALADIUM	Sq. M	100	
24	OSMIUM	Sq. M	100	
25	IRIDIUM	Sq. M	100	
26	NEUTRON	Sq. M	100	
27	PROTON	Sq. M	100	
28	DEUTERON	Sq. M	100	
29	TRITON	Sq. M	100	
30	HELIUM	Sq. M	100	
31	LITHIUM	Sq. M	100	
32	BERYLLIUM	Sq. M	100	
33	BORON	Sq. M	100	
34	CARBON	Sq. M	100	
35	NITROGEN	Sq. M	100	
36	OXYGEN	Sq. M	100	
37	FLUORINE	Sq. M	100	
38	NEON	Sq. M	100	
39	SODIUM	Sq. M	100	
40	MAGNESIUM	Sq. M	100	
41	ALUMINUM	Sq. M	100	
42	SILICON	Sq. M	100	
43	PHOSPHORUS	Sq. M	100	
44	SULFUR	Sq. M	100	
45	CHLORINE	Sq. M	100	
46	ARGON	Sq. M	100	
47	POTASSIUM	Sq. M	100	
48	CALCIUM	Sq. M	100	
49	SCANDIUM	Sq. M	100	
50	TITANIUM	Sq. M	100	
51	VANADIUM	Sq. M	100	
52	CHROMIUM	Sq. M	100	
53	MANGANESE	Sq. M	100	
54	IRON	Sq. M	100	
55	COBALT	Sq. M	100	
56	NICKEL	Sq. M	100	
57	COPPER	Sq. M	100	
58	ZINC	Sq. M	100	
59	GERMANIUM	Sq. M	100	
60	ARSENIC	Sq. M	100	
61	SELENIUM	Sq. M	100	
62	BROMINE	Sq. M	100	
63	KRYPTON	Sq. M	100	
64	XENON	Sq. M	100	
65	CESIUM	Sq. M	100	
66	BARIUM	Sq. M	100	
67	LANTHANUM	Sq. M	100	
68	CERIUM	Sq. M	100	
69	PRASEODYMIUM	Sq. M	100	
70	NEODYMIUM	Sq. M	100	
71	PROMETHIUM	Sq. M	100	
72	SAMARIUM	Sq. M	100	
73	EUROPEUM	Sq. M	100	
74	GADOLINIUM	Sq. M	100	
75	TERBIUM	Sq. M	100	
76	DYSPROSIUM	Sq. M	100	
77	HOLOMIUM	Sq. M	100	
78	ERBIUM	Sq. M	100	
79	THULIUM	Sq. M	100	
80	YTERBIUM	Sq. M	100	
81	LUTETIUM	Sq. M	100	
82	HAFNIUM	Sq. M	100	
83	TANTALUM	Sq. M	100	
84	TUNGSTEN	Sq. M	100	
85	RHENIUM	Sq. M	100	
86	PALLADIUM	Sq. M	100	
87	RHODIUM	Sq. M	100	
88	PALADIUM	Sq. M	100	
89	OSMIUM	Sq. M	100	
90	IRIDIUM	Sq. M	100	
91	NEUTRON	Sq. M	100	
92	PROTON	Sq. M	100	
93	DEUTERON	Sq. M	100	
94	TRITON	Sq. M	100	
95	HELIUM	Sq. M	100	
96	LITHIUM	Sq. M	100	
97	BERYLLIUM	Sq. M	100	
98	BORON	Sq. M	100	
99	CARBON	Sq. M	100	
100	NITROGEN	Sq. M	100	


LIST OF DRAWINGS					PAPER SIZE
DWG NO.	DESCRIPTION	SCALE	SHEET		
04-00-00	Cover	N/A	A1		
04-00-01	Interior Design Drawing List	N/A	A1		
04-00-04	New Year General Layout	N/A	A1		
04-00-05	General Specification (General)	N/A	A1		
04-00-06	General Specification (General)	N/A	A1		
04-00-09	INTERIOR LAYOUT	N/A	A1		
04-00-10	INTERIOR LAYOUT	N/A	A1		
04-00-13	WALL PLAN	N/A	A1		
04-00-14	DOOR & WINDOW PLAN	N/A	A1		
04-00-15	CARPENTRY FOR EXTERIOR	N/A	A1		
04-00-16	MECHA PLAN	N/A	A1		
Benchmarks					
04-00-19	PERIMETER LAYOUT	N/A	A1		
04-00-20	ELEVATION 1, 2, 3, 4	N/A	A1		
04-00-21	SECTION 1, 2, 3, 4	N/A	A1		
04-00-24	ROOF DETAIL, (Reference to roof plan)	N/A	A1		
04-00-25	ROOF DETAIL, (Reference to roof plan)	N/A	A1		
04-00-26	PERIMETER LAYOUT	N/A	A1		
04-00-27	ELEVATION 1, 2	N/A	A1		
04-00-28	SECTION 1, 2	N/A	A1		
04-00-29	PERIMETER LAYOUT	N/A	A1		
04-00-30	ROOF DETAIL, (Reference to roof plan)	N/A	A1		
04-00-31	ROOF DETAIL, (Reference to roof plan)	N/A	A1		
04-00-32	PERIMETER LAYOUT	N/A	A1		
04-00-33	ELEVATION 1	N/A	A1		
04-00-34	SECTION 1, 2, 3, 4	N/A	A1		
04-00-35	ROOF DETAIL, (Reference to roof plan)	N/A	A1		
04-00-36	ROOF DETAIL, (Reference to roof plan)	N/A	A1		
04-00-37	PERIMETER LAYOUT	N/A	A1		
04-00-38	ROOF DETAIL, (Reference to roof plan)	N/A	A1		
04-00-39	ROOF DETAIL, (Reference to roof plan)	N/A	A1		
04-00-40	PERIMETER LAYOUT	N/A	A1		
04-00-41	ELEVATION 1	N/A	A1		
04-00-42	SECTION 1, 2, 3, 4	N/A	A1		
04-00-43	ROOF DETAIL, (Reference to roof plan)	N/A	A1		
04-00-44	ROOF DETAIL, (Reference to roof plan)	N/A	A1		
04-00-45	PERIMETER LAYOUT	N/A	A1		
04-00-46	ROOF DETAIL, (Reference to roof plan)	N/A	A1		
04-00-47	ROOF DETAIL, (Reference to roof plan)	N/A	A1		
04-00-48	PERIMETER LAYOUT	N/A	A1		
04-00-49	ROOF DETAIL, (Reference to roof plan)	N/A	A1		
04-00-50	ROOF DETAIL, (Reference to roof plan)	N/A	A1		
04-00-51	PERIMETER LAYOUT	N/A	A1		
04-00-52	ROOF DETAIL, (Reference to roof plan)	N/A	A1		
04-00-53	ROOF DETAIL, (Reference to roof plan)	N/A	A1		
04-00-54	PERIMETER LAYOUT	N/A	A1		
04-00-55	ROOF DETAIL, (Reference to roof plan)	N/A	A1		
04-00-56	ROOF DETAIL, (Reference to roof plan)	N/A	A1		
04-00-57	PERIMETER LAYOUT	N/A	A1		
04-00-58	ROOF DETAIL, (Reference to roof plan)	N/A	A1		
04-00-59	ROOF DETAIL, (Reference to roof plan)	N/A	A1		
04-00-60	PERIMETER LAYOUT	N/A	A1		
04-00-61	ROOF DETAIL, (Reference to roof plan)	N/A	A1		
04-00-62	ROOF DETAIL, (Reference to roof plan)	N/A	A1		
04-00-63	PERIMETER LAYOUT	N/A	A1		
04-00-64	ROOF DETAIL, (Reference to roof plan)	N/A	A1		
04-00-65	ROOF DETAIL, (Reference to roof plan)	N/A	A1		
04-00-66	PERIMETER LAYOUT	N/A	A1		
04-00-67	ROOF DETAIL, (Reference to roof plan)	N/A	A1		
04-00-68	ROOF DETAIL, (Reference to roof plan)	N/A	A1		
04-00-69	PERIMETER LAYOUT	N/A	A1		
04-00-70	ROOF DETAIL, (Reference to roof plan)	N/A	A1		
04-00-71	ROOF DETAIL, (Reference to roof plan)	N/A	A1		
04-00-72	PERIMETER LAYOUT	N/A	A1		
04-00-73	ROOF DETAIL, (Reference to roof plan)	N/A	A1		
04-00-74	ROOF DETAIL, (Reference to roof plan)	N/A	A1		
04-00-75	PERIMETER LAYOUT	N/A	A1		
04-00-76	ROOF DETAIL, (Reference to roof plan)	N/A	A1		
04-00-77	ROOF DETAIL, (Reference to roof plan)	N/A	A1		
04-00-78	PERIMETER LAYOUT	N/A	A1		
04-00-79	ROOF DETAIL, (Reference to roof plan)	N/A	A1		
04-00-80	ROOF DETAIL, (Reference to roof plan)	N/A	A1		
04-00-81	PERIMETER LAYOUT	N/A	A1		
04-00-82	ROOF DETAIL, (Reference to roof plan)	N/A	A1		
04-00-83	ROOF DETAIL, (Reference to roof plan)	N/A	A1		
04-00-84	PERIMETER LAYOUT	N/A	A1		
04-00-85	ROOF DETAIL, (Reference to roof plan)	N/A	A1		
04-00-86	ROOF DETAIL, (Reference to roof plan)	N/A	A1		
04-00-87	PERIMETER LAYOUT	N/A	A1		
04-00-88	ROOF DETAIL, (Reference to roof plan)	N/A	A1		
04-00-89	ROOF DETAIL, (Reference to roof plan)	N/A	A1		
04-00-90	PERIMETER LAYOUT	N/A	A1		
04-00-91	ROOF DETAIL, (Reference to roof plan)	N/A	A1		
04-00-92	ROOF DETAIL, (Reference to roof plan)	N/A	A1		
04-00-93	PERIMETER LAYOUT	N/A	A1		
04-00-94	ROOF DETAIL, (Reference to roof plan)	N/A	A1		
04-00-95	ROOF DETAIL, (Reference to roof plan)	N/A	A1		
04-00-96	PERIMETER LAYOUT	N/A	A1		
04-00-97	ROOF DETAIL, (Reference to roof plan)	N/A	A1		
04-00-98	ROOF DETAIL, (Reference to roof plan)	N/A	A1		
04-00-99	PERIMETER LAYOUT	N/A	A1		
04-00-100	ROOF DETAIL, (Reference to roof plan)	N/A	A1		

3
1st FLOOR
WALL PLAN
SCALE 1:100

Architectural floor plan of a building, oriented vertically. The plan is overlaid with a grid system. The vertical axis is labeled with letters A through H at the top. The horizontal axis is labeled with numbers 1 through 16 along the right edge. The building layout includes a long central corridor (approximately between grid lines 4 and 14) with various rooms and service areas on either side. Rooms include what appear to be offices, a large open space (possibly a hall or auditorium) at the bottom, and several smaller rooms and restrooms. Handwritten notes on the left side of the plan include "N. 240 ft" and "N. 240 ft".


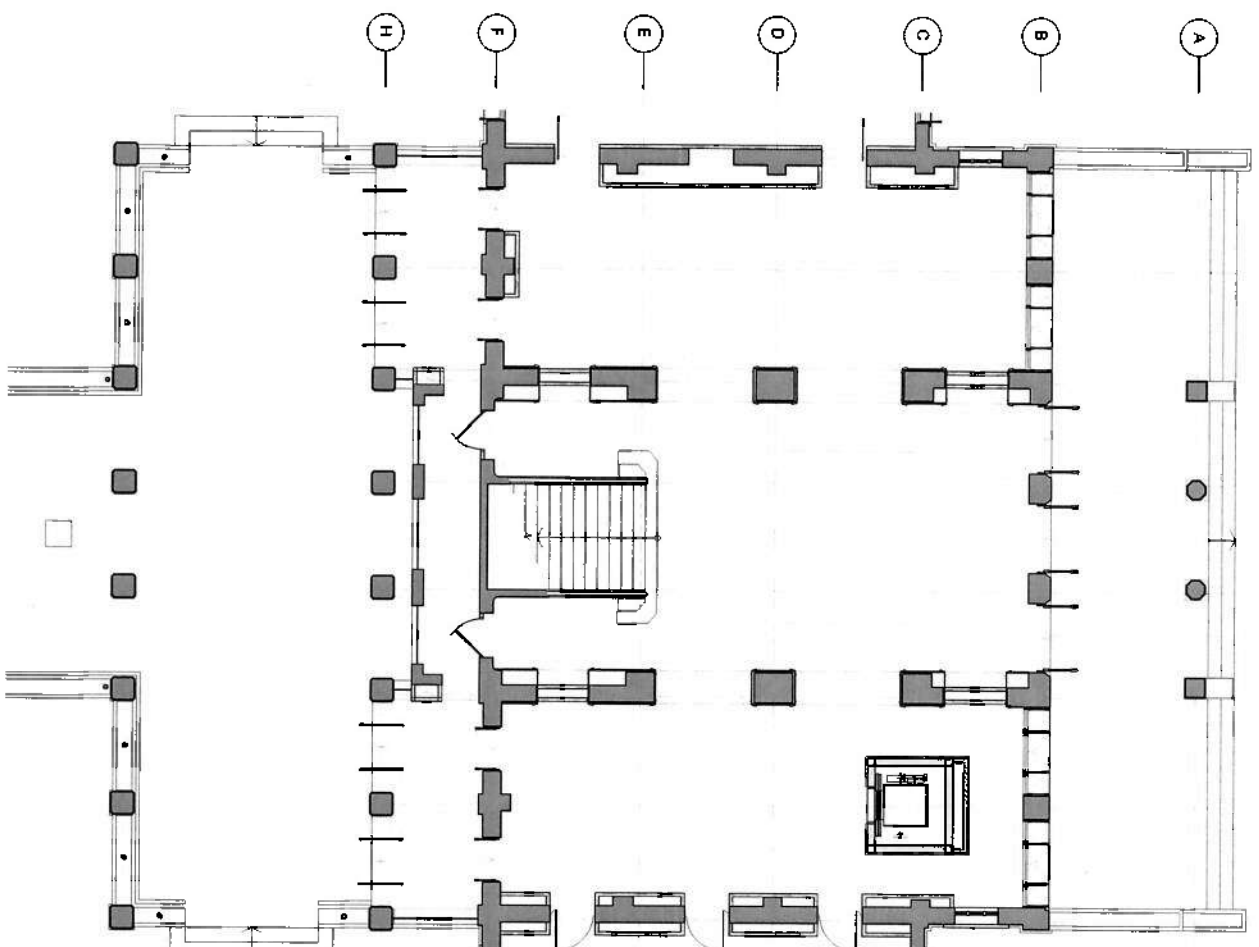


4 1st FLOOR
DOOR & WINDOW PLAN
SCALE 1:100

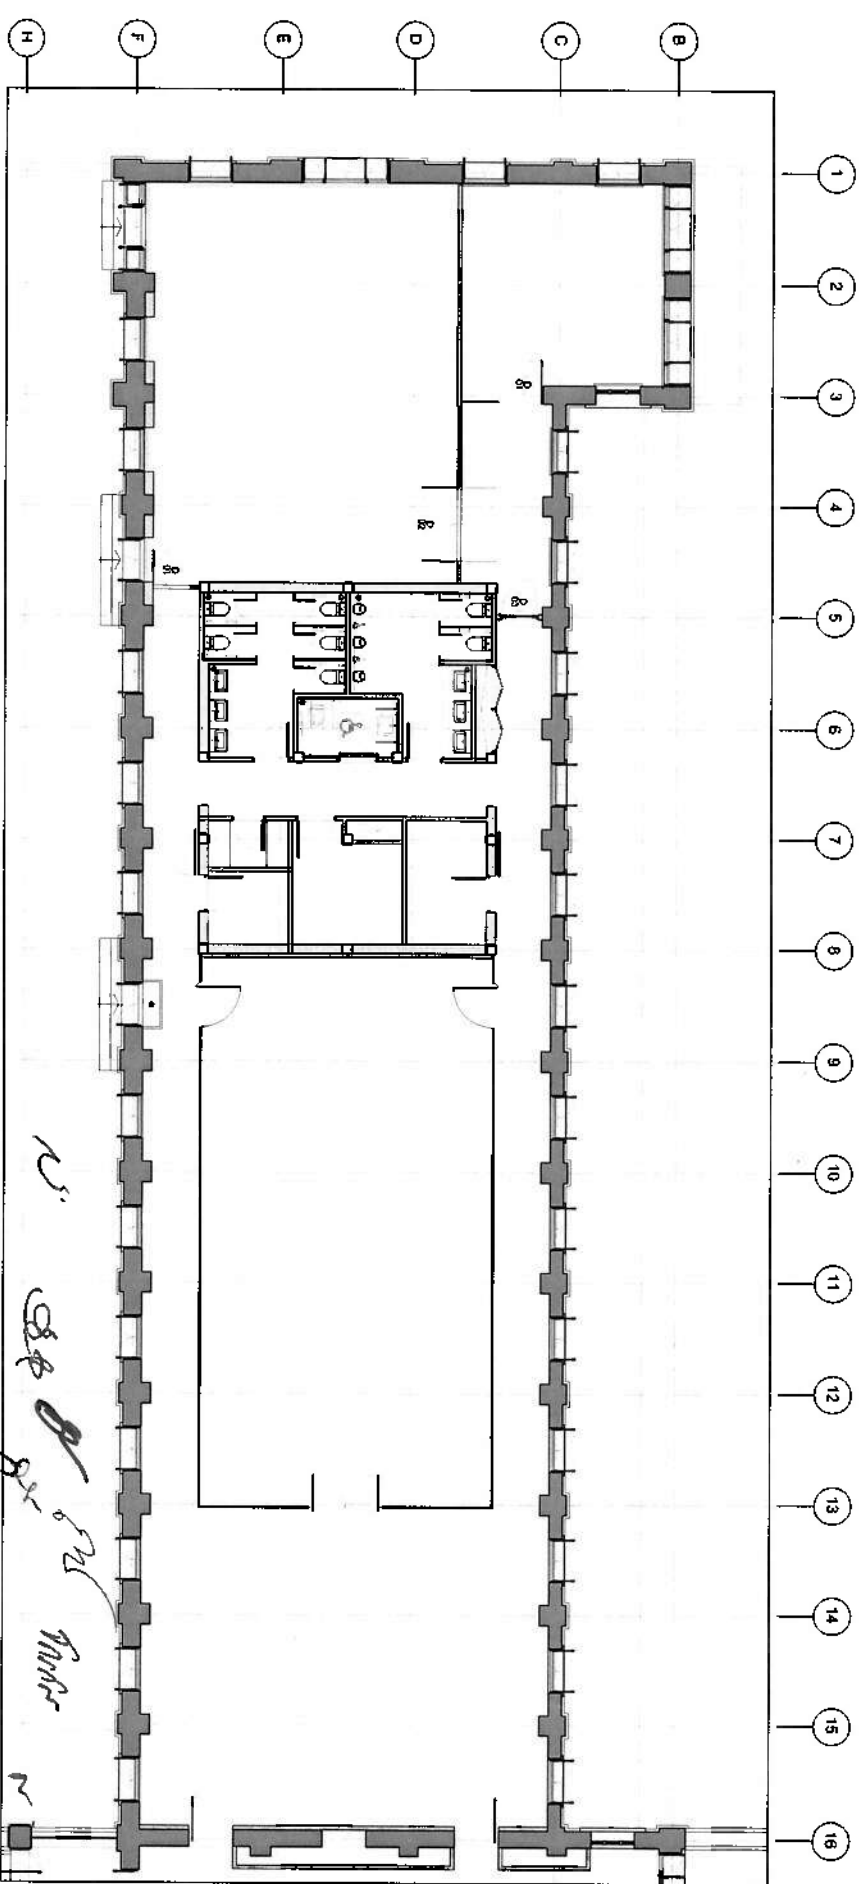


2. ~~23~~ 24 25 26 1050


- 16
- 17
- 18
- 19
- 20
- 21
- 22
- 23
- 24
- 25
- 26
- 27
- 28
- 29
- 30
- 31
- 32
- 33
- 34
- 35
- 36
- 37
- 38

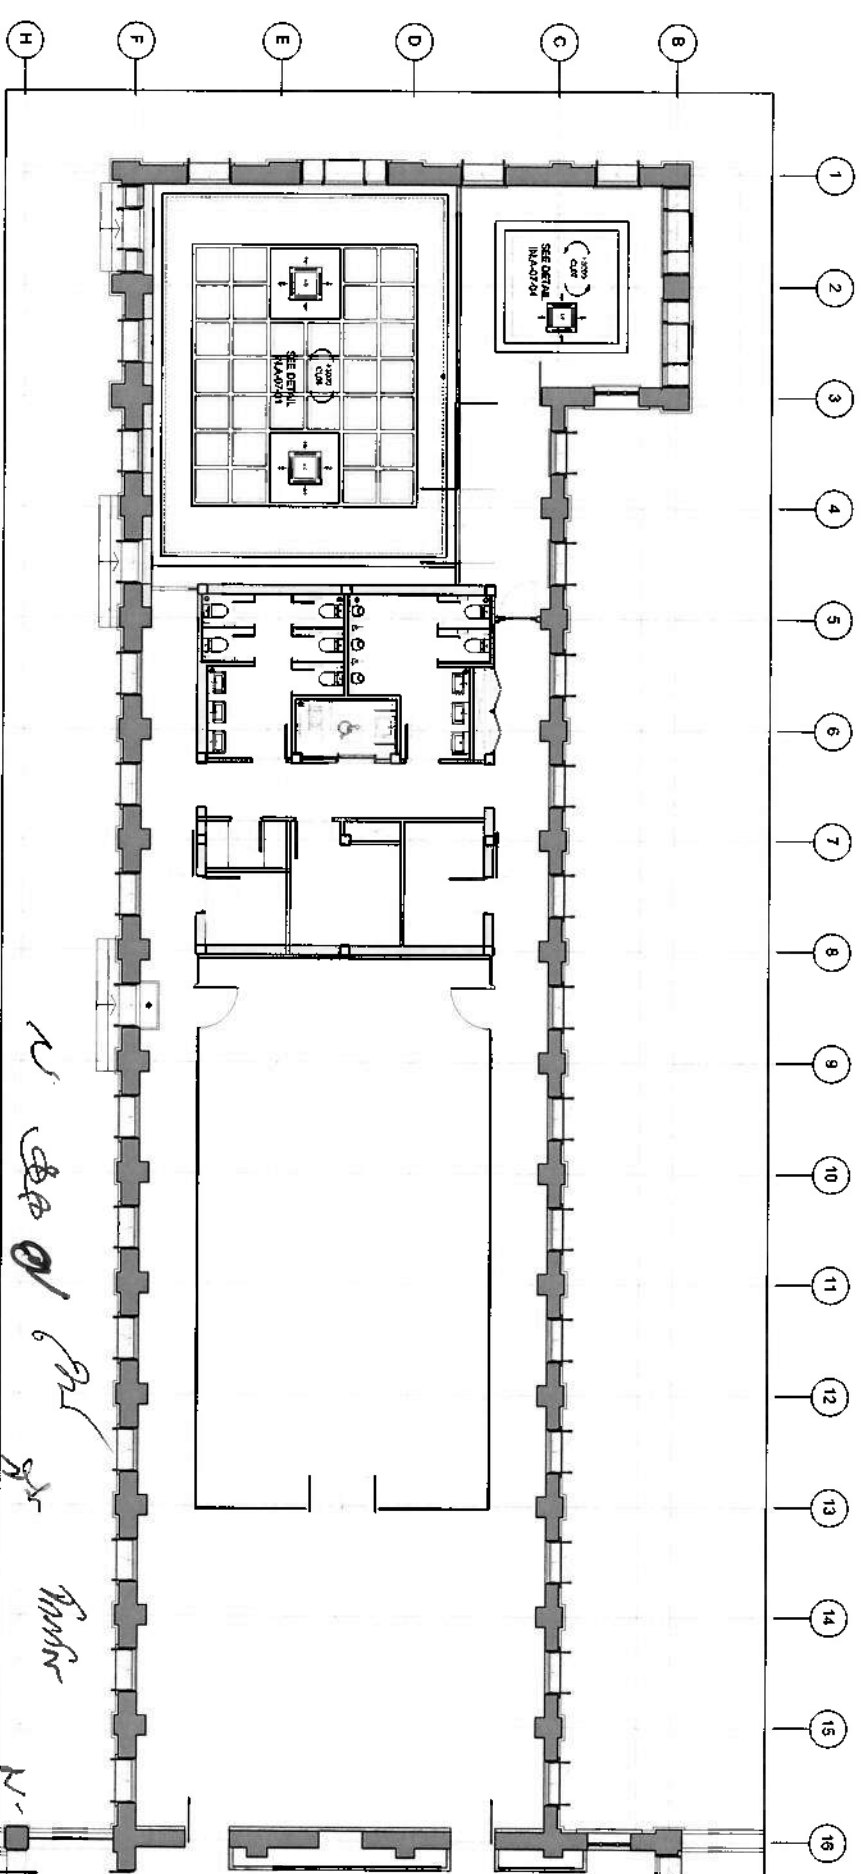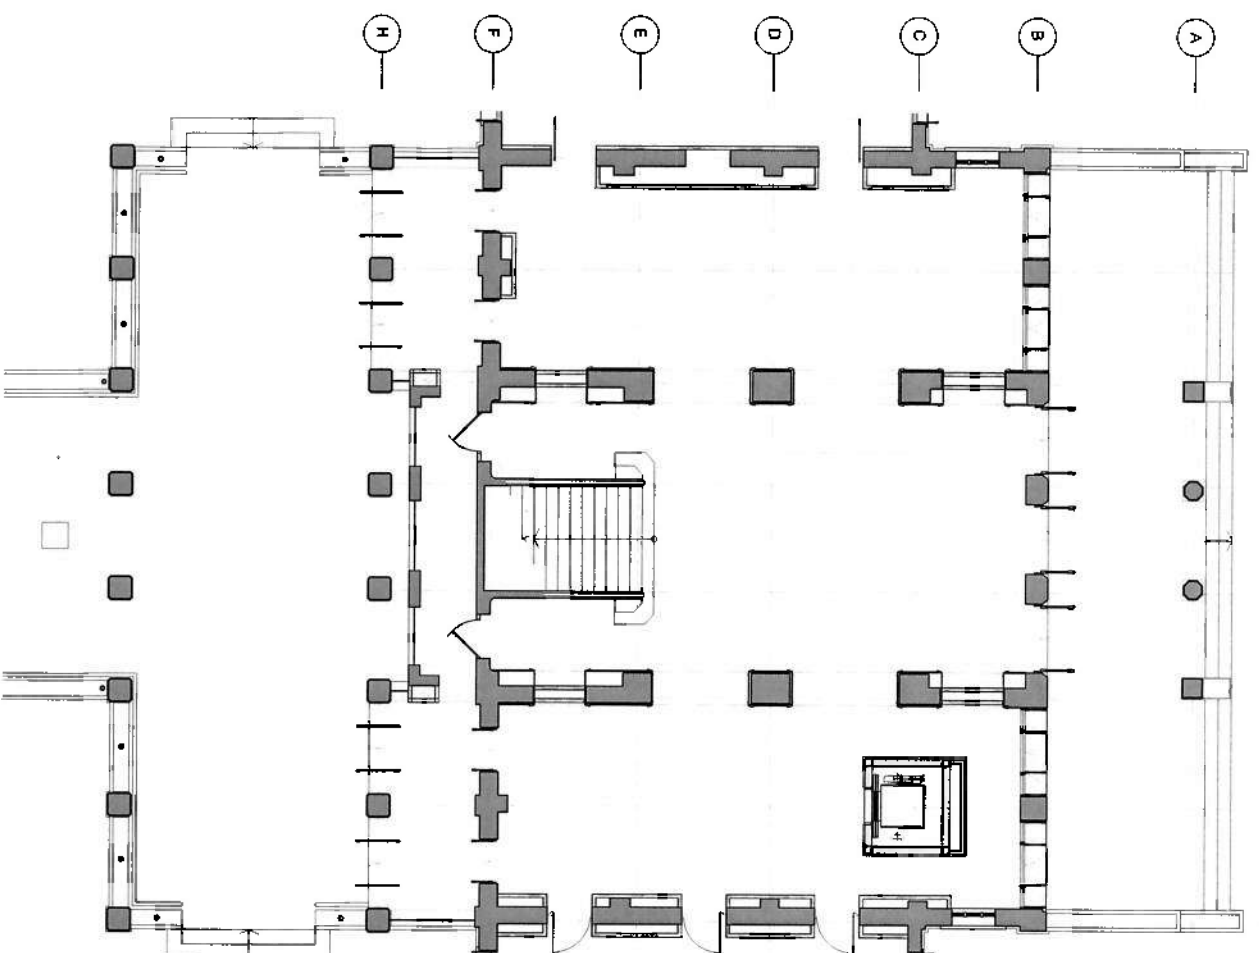


QIDR		PROJECT TITLE: 1ST FLOOR DOOR & WINDOW PLAN		REVISION: 1	
DRAWN BY: JPH		CHECKED BY: JPH		DATE: 10/10/04	
SCALE: 1/8"=1'-0"		SCALE: 1/8"=1'-0"		SCALE: 1/8"=1'-0"	
PROJECT NO.: IN-A-00-04		PROJECT NO.: IN-A-00-04		PROJECT NO.: IN-A-00-04	

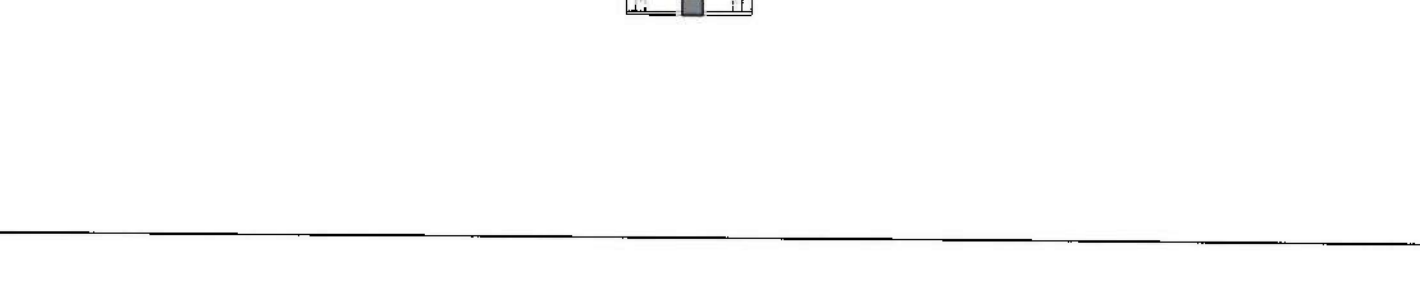[illegible]

- 16
- 17
- 18
- 19
- 20
- 21
- 22
- 23
- 24
- 25
- 26
- 27
- 28
- 29
- 30
- 31
- 32
- 33
- 34
- 35
- 36
- 37
- 38

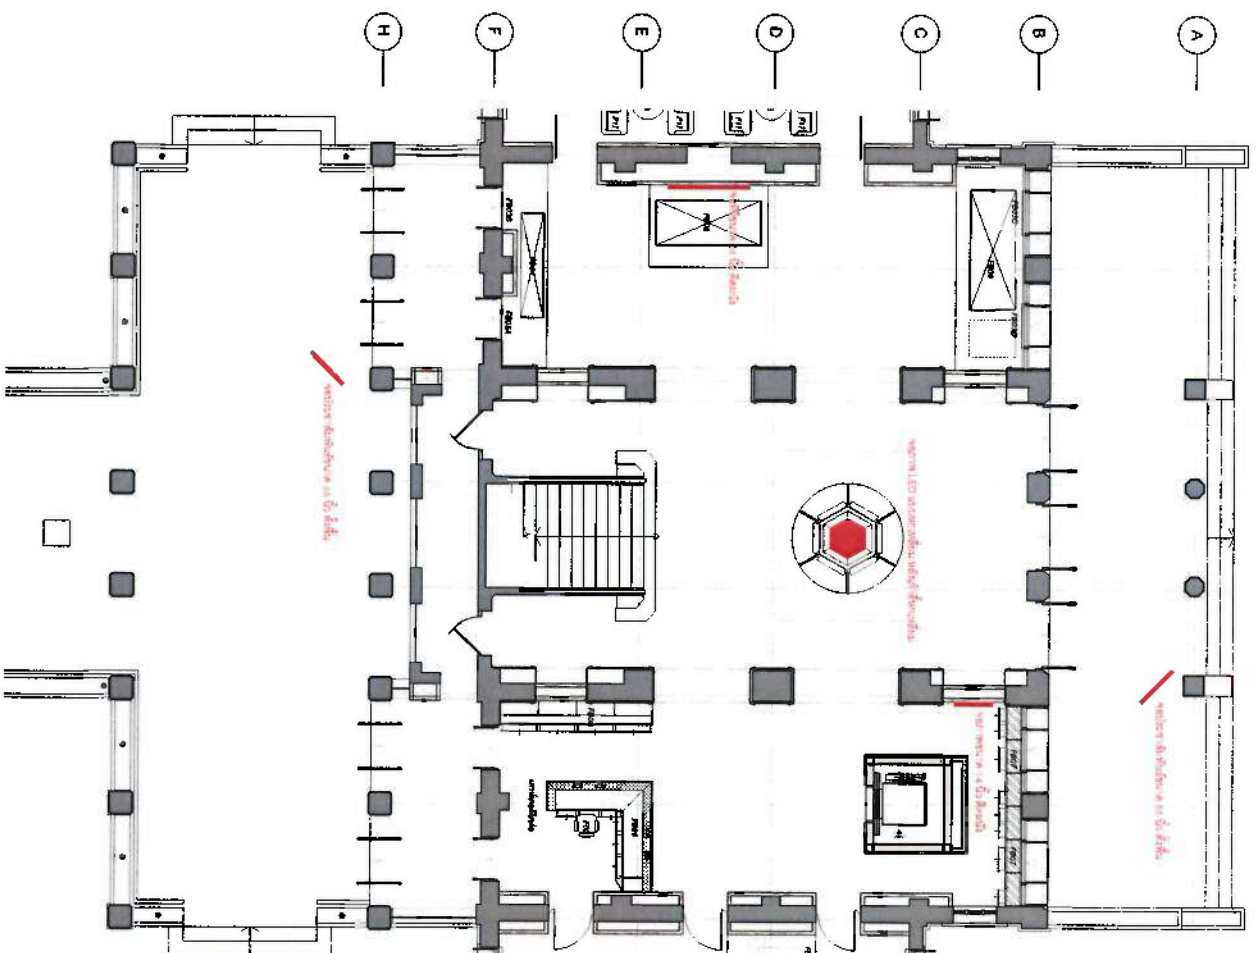






1st FLOOR
MEDIA PLAN
SCALE 1/100

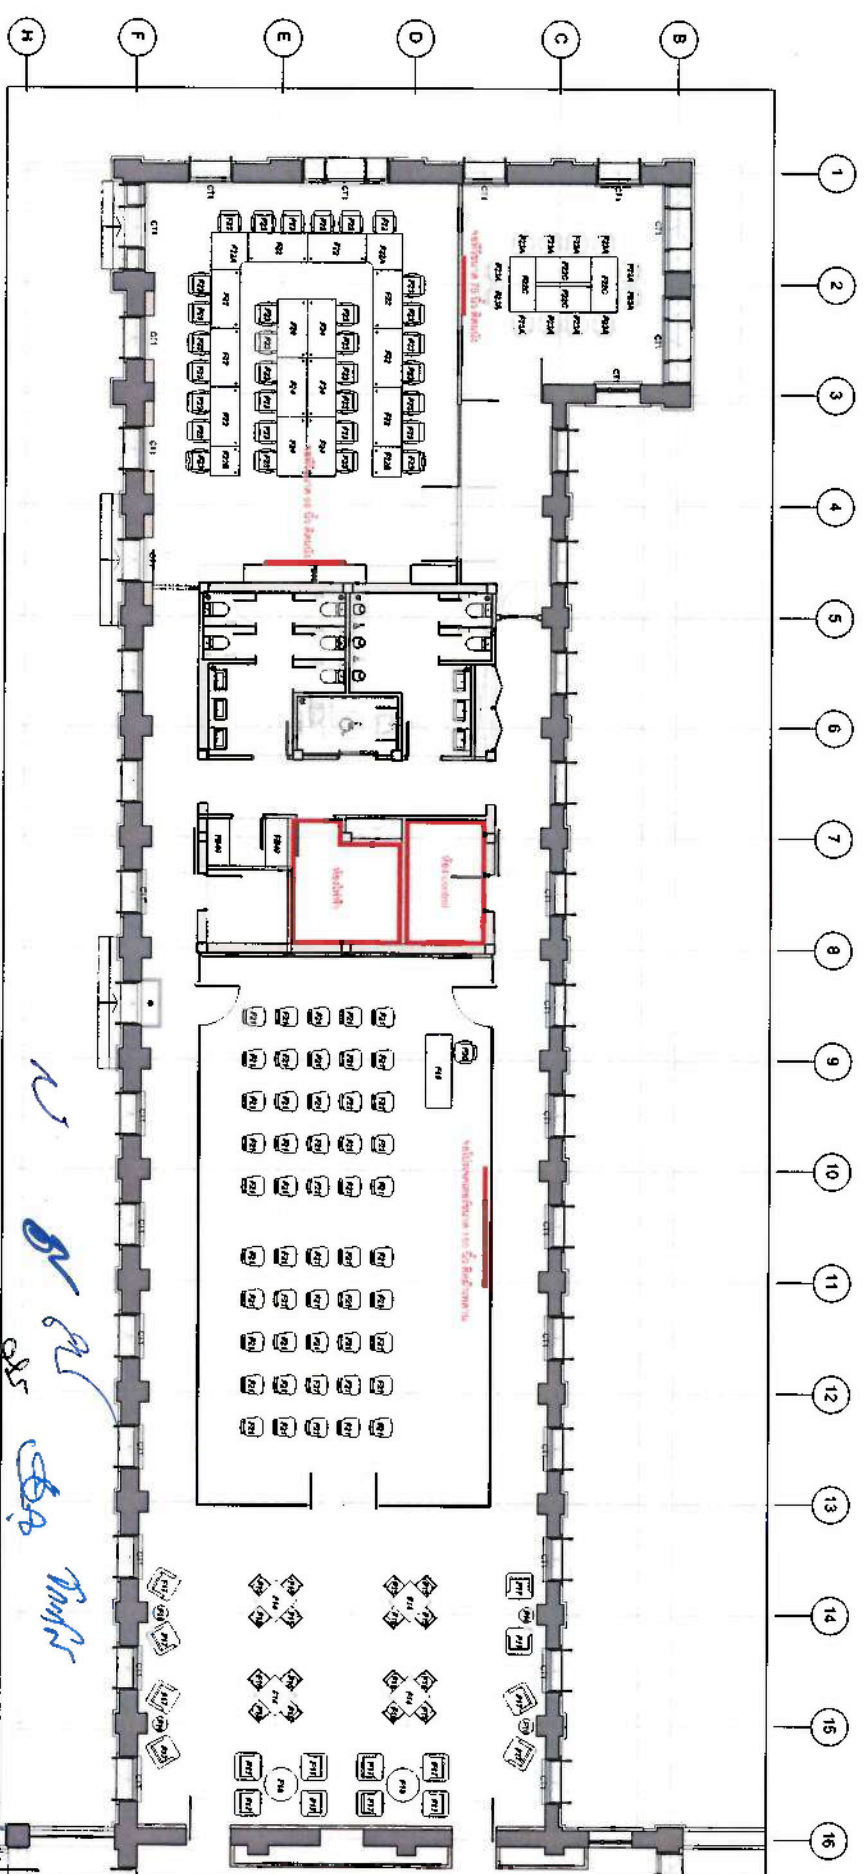


Handwritten notes in blue ink: "12", "B", "AL", "SBA", "Thur", "12/15".

QIDR QIDR CONSULTING 1000 10th Avenue, Suite 1000 San Francisco, CA 94103 Tel: 415.774.1000 Fax: 415.774.1001 Email: info@qidr.com		PROJECT NO.: 1000 PROJECT NAME: 1st Floor Media Plan PROJECT LOCATION: 1000 10th Avenue, Suite 1000, San Francisco, CA 94103 PROJECT DATE: 10/01/06	
DRAWING NO.: 1000-00-06 DRAWING TITLE: 1st Floor Media Plan DRAWING DATE: 10/01/06		DESIGNER: [Signature] CHECKED: [Signature] SCALE: 1/100 DRAWN: [Signature]	

[illegible][illegible]

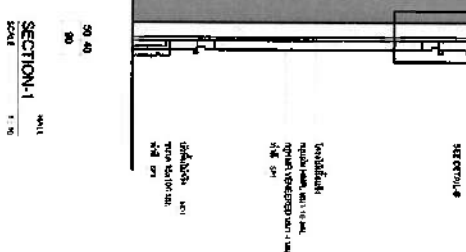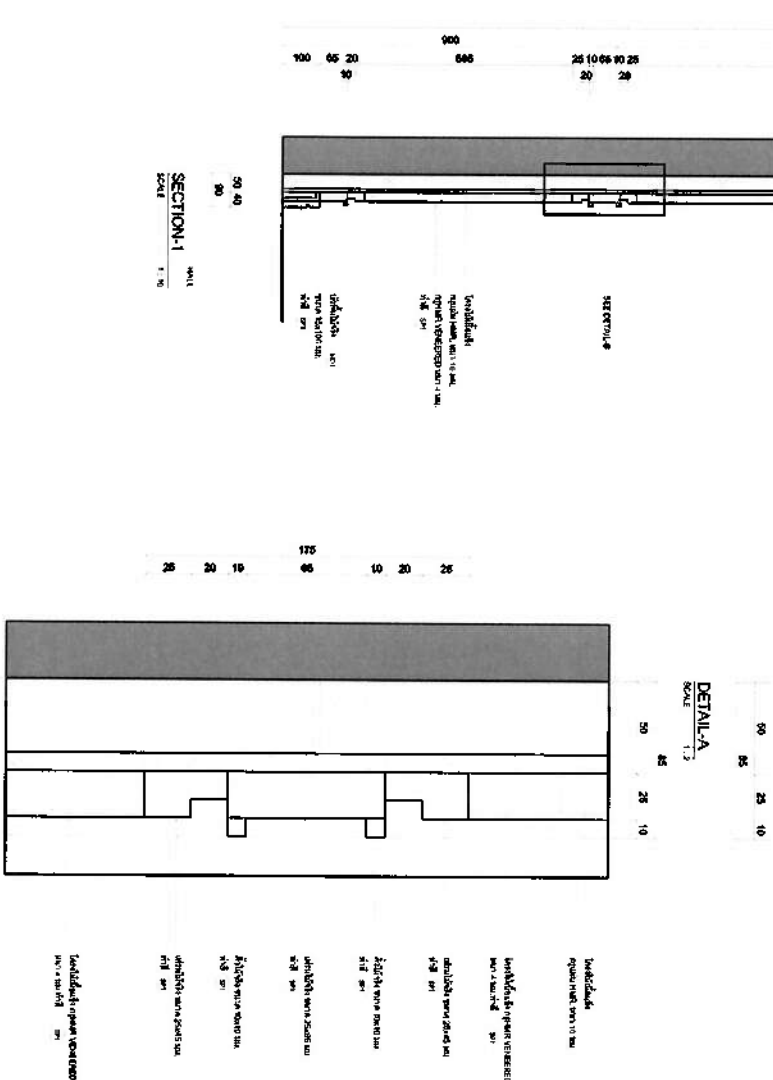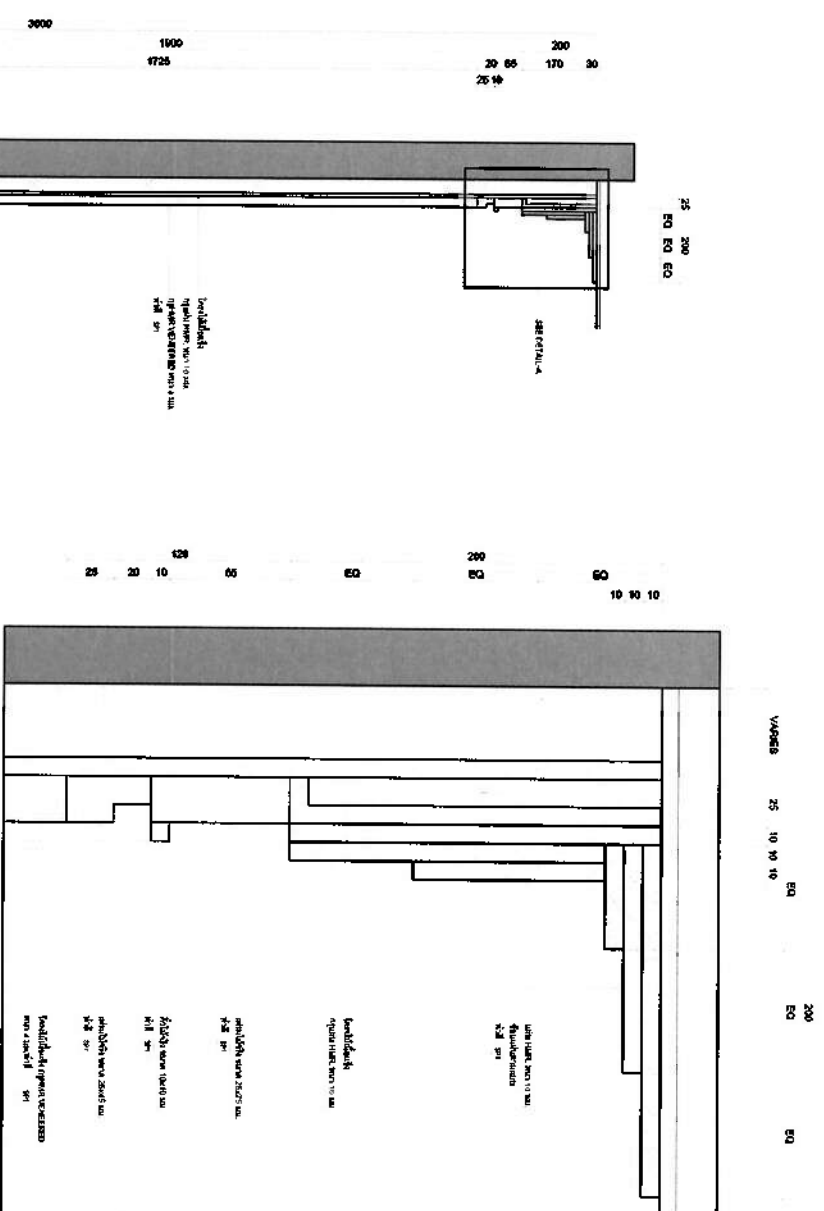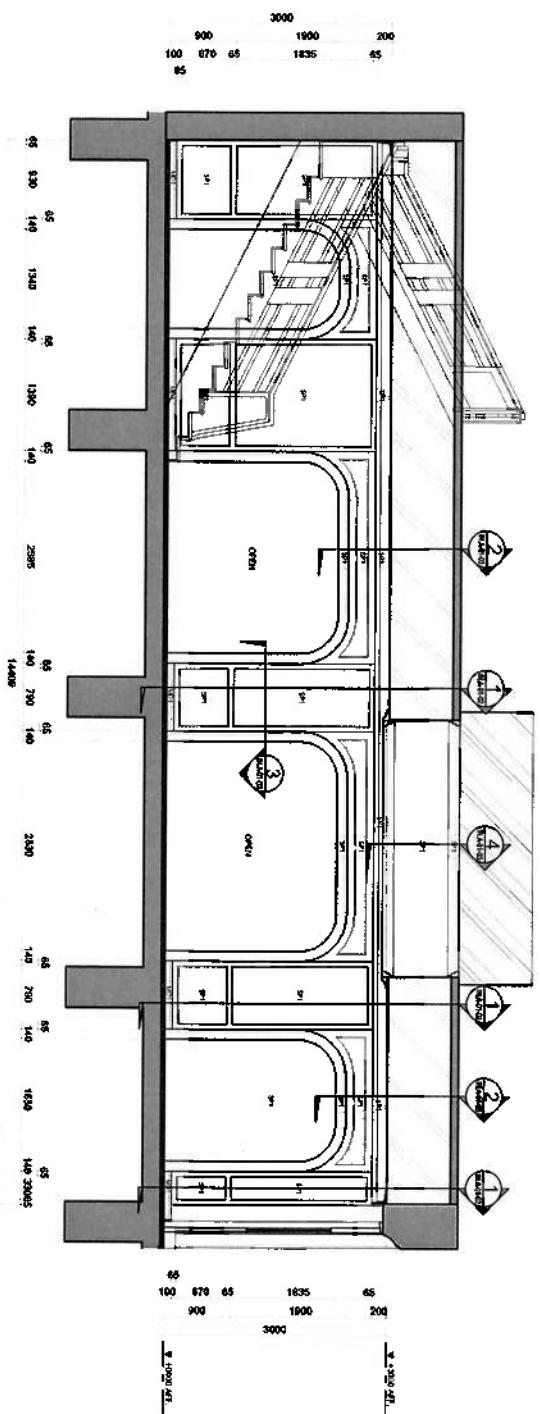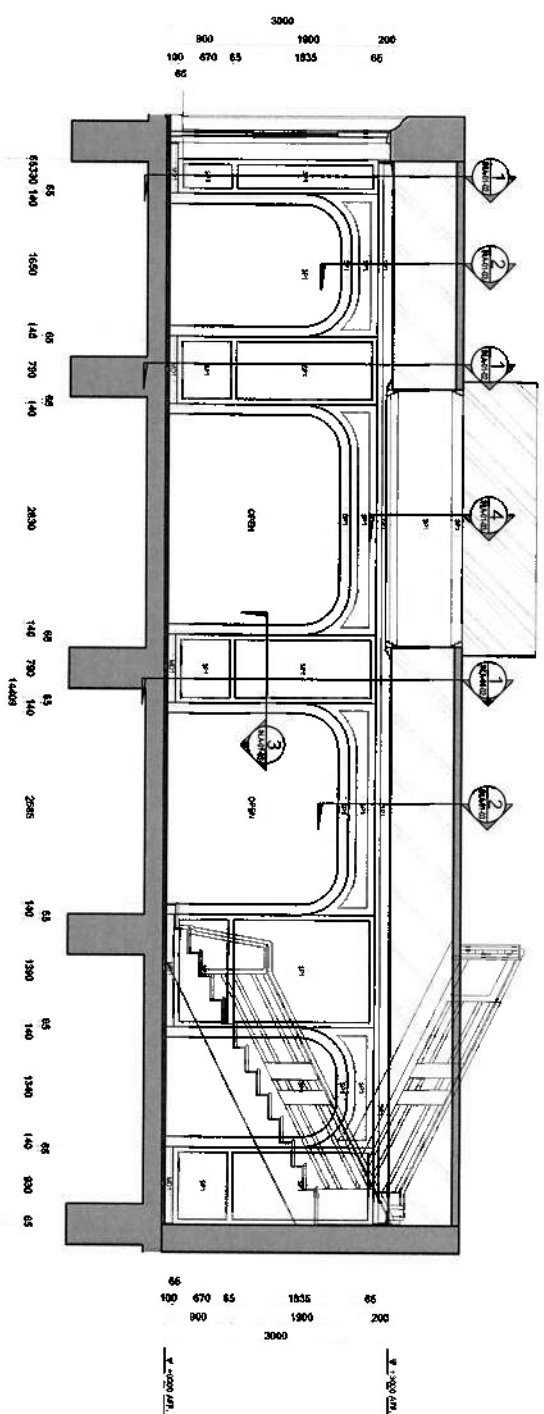


FB01 DETAIL (เก้าอี้สำนักงาน - การศึกษา)

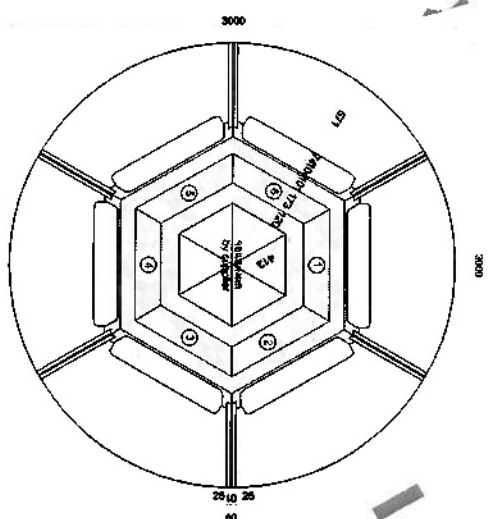

ขนาด 10 มม. ออฟฟิศ
ขนาด 10 มม. ออฟฟิศ
ขนาด 10 มม. ออฟฟิศ
ขนาด 10 มม. ออฟฟิศ
ขนาด 10 มม. ออฟฟิศ
ขนาด 10 มม. ออฟฟิศ


1. โครงสร้าง
2. เบาะนั่ง
3. เบาะหลัง
4. เบาะรองนั่ง
5. เบาะรองหลัง
6. เบาะรองเท้า

TOP VIEW (FB01 DETAIL)
SCALE 1:25

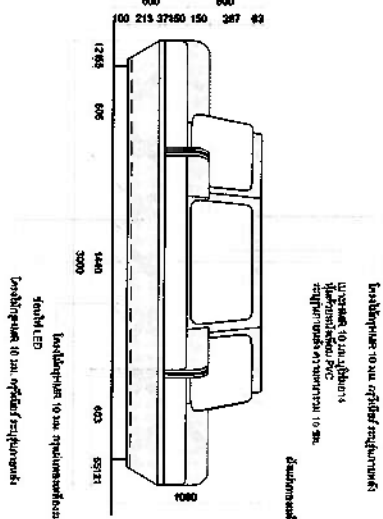


ขนาด 10 มม. ออฟฟิศ
ขนาด 10 มม. ออฟฟิศ
ขนาด 10 มม. ออฟฟิศ
ขนาด 10 มม. ออฟฟิศ
ขนาด 10 มม. ออฟฟิศ
ขนาด 10 มม. ออฟฟิศ

1 SIDE VIEW
SCALE 1:25

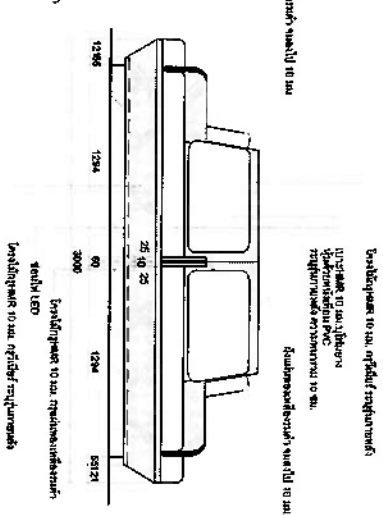


2 SIDE VIEW
SCALE 1:25

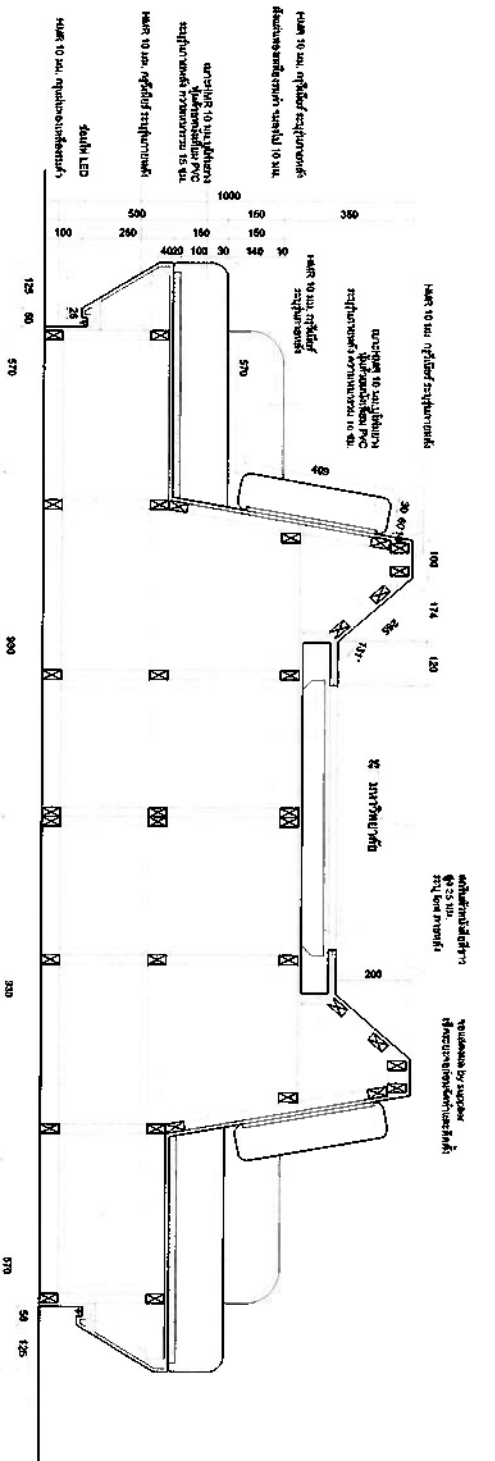


3 SECTION
SCALE 1:10

FB02 DETAIL (เก้าอี้สำนักงาน)

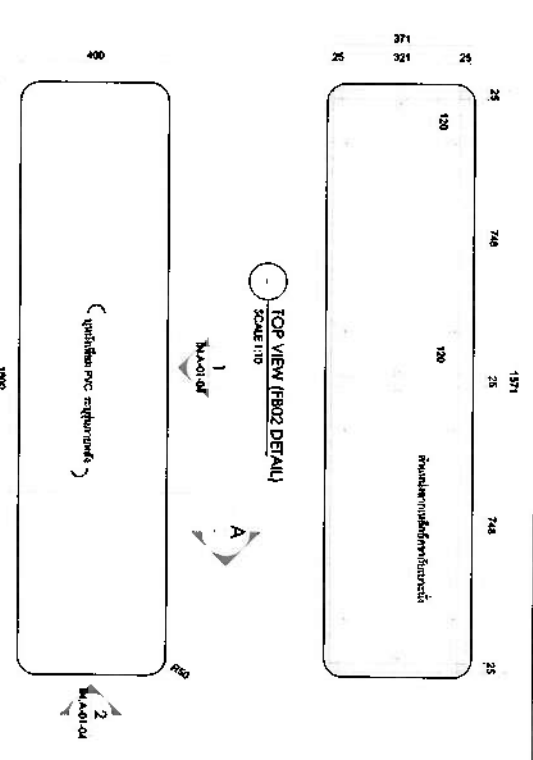


TOP VIEW (FB02 DETAIL)
SCALE 1:10


TOP VIEW (FB02 DETAIL)
SCALE 1:10

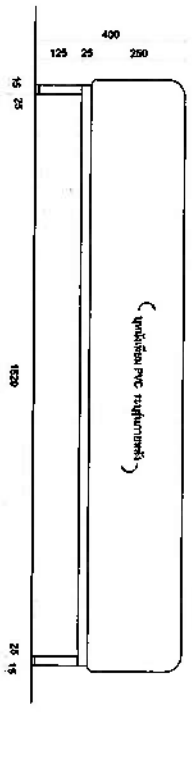

1 SIDE VIEW
SCALE 1:10

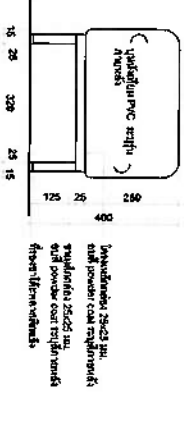




2 SIDE VIEW
SCALE 1:10

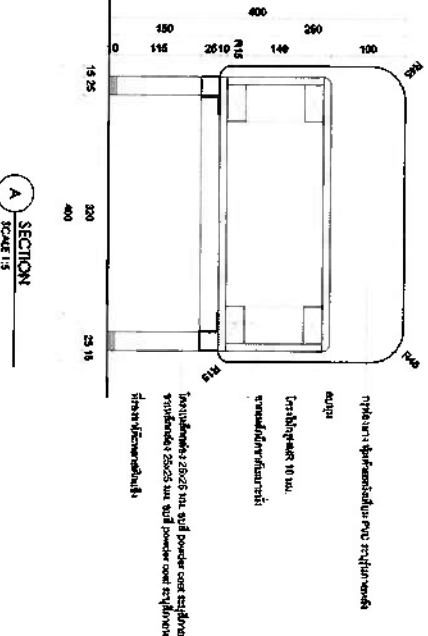


A SECTION
SCALE 1:5

		PROJECT TITLE : FB01 DETAIL (เก้าอี้สำนักงาน - การศึกษา)		DESIGNER : FB01 DETAIL (เก้าอี้สำนักงาน - การศึกษา)	
DATE : 15/01/2564		LOCATION : FB01 DETAIL (เก้าอี้สำนักงาน - การศึกษา)		SCALE : 1:10	
REVISION : NO. 1 15/01/2564		DATE : 15/01/2564		SCALE : 1:10	
PROJECT TITLE : FB02 DETAIL (เก้าอี้สำนักงาน)		DESIGNER : FB02 DETAIL (เก้าอี้สำนักงาน)		SCALE : 1:10	
DATE : 15/01/2564		LOCATION : FB02 DETAIL (เก้าอี้สำนักงาน)		SCALE : 1:10	
REVISION : NO. 1 15/01/2564		DATE : 15/01/2564		SCALE : 1:10	

 


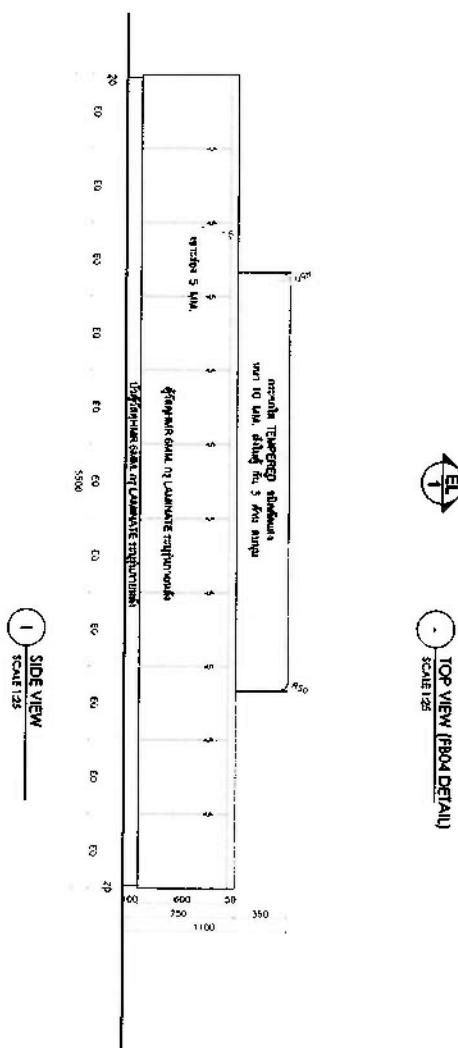
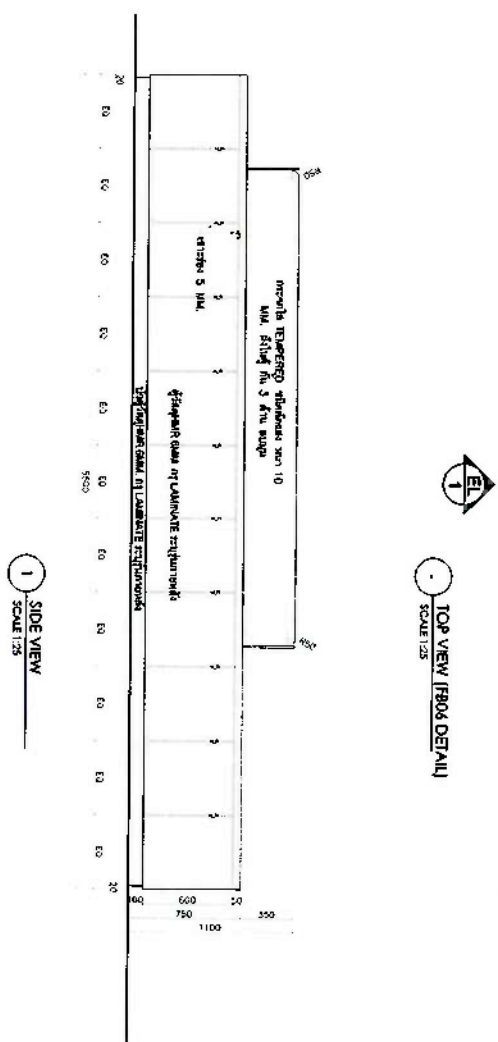
[illegible][illegible]

SECTION
SCALE 1:25



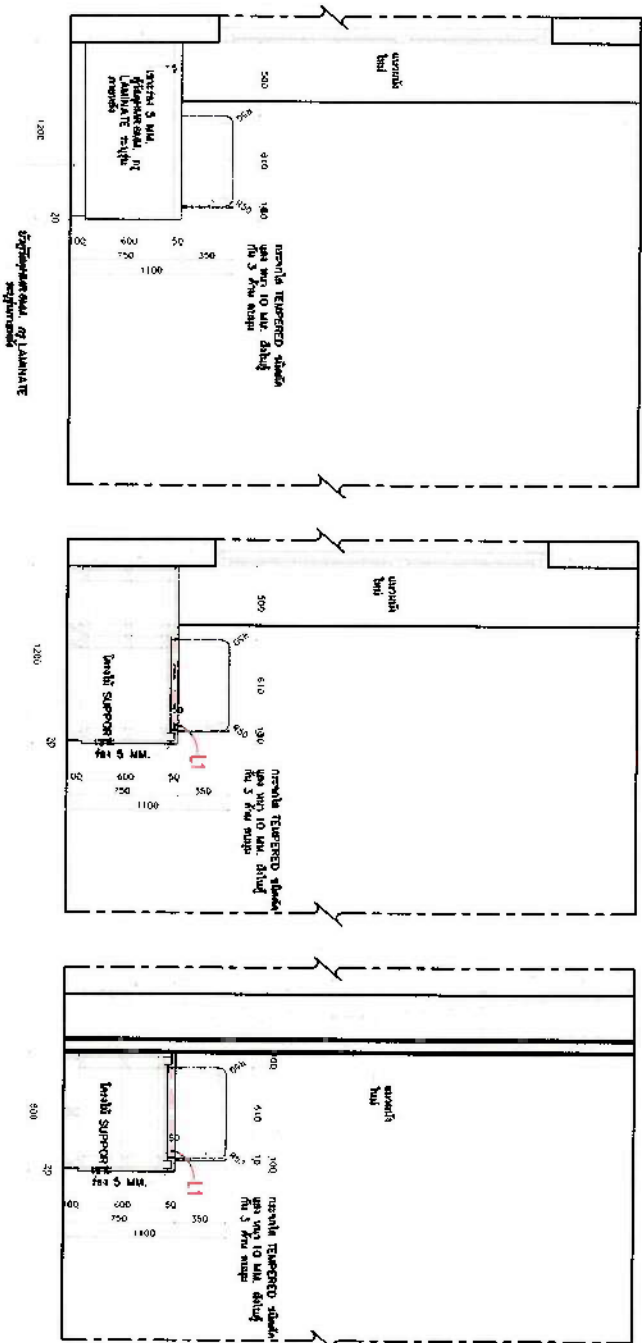


2 SIDE VIEW
SCALE 1:25

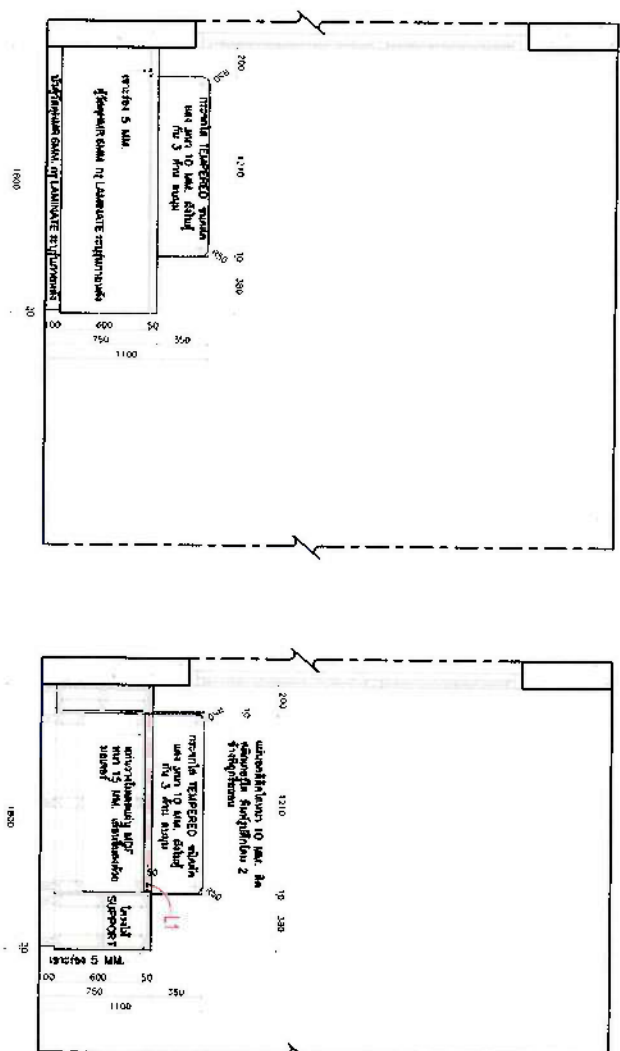

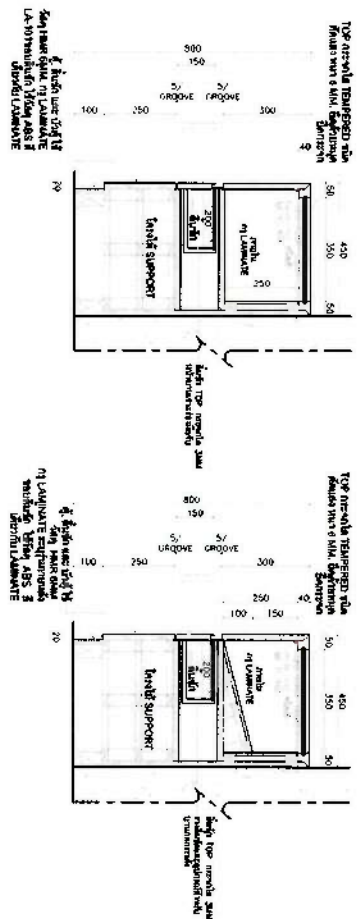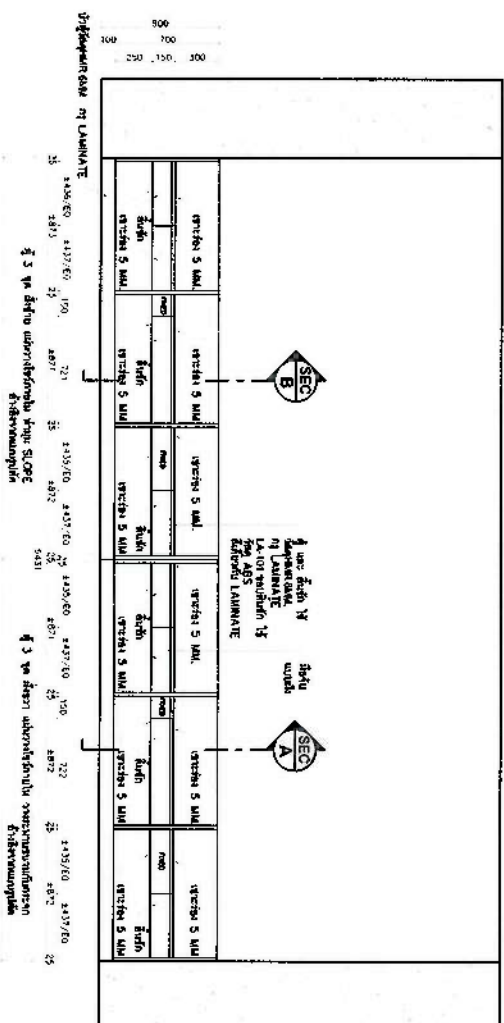
[illegible]

Year	1970	1971	1972	2100
1970	1971	1972	2100	

 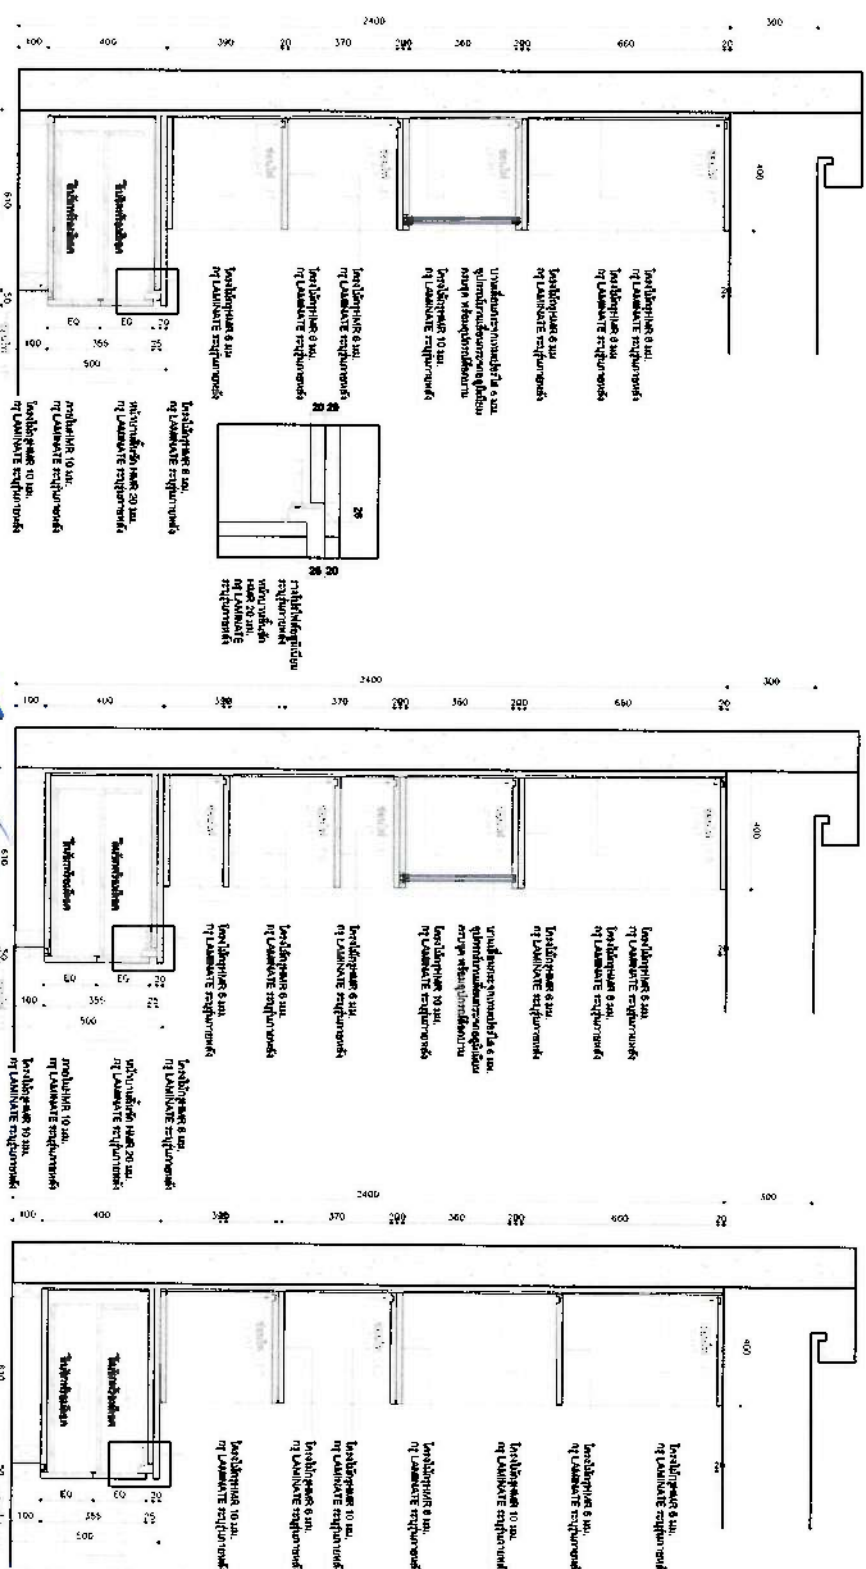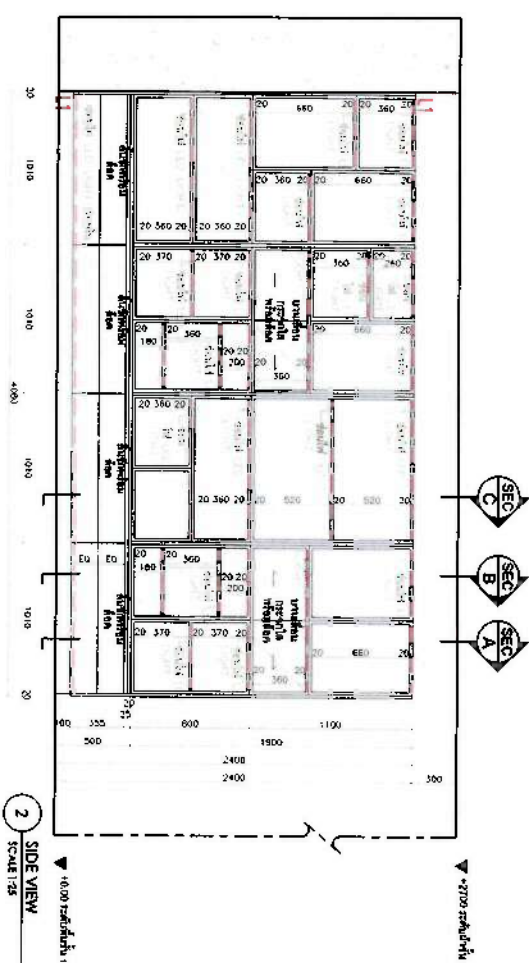


 QIDR QIDR Engineering, Inc. 10000 E. Highway 100, Suite 100 Denver, CO 80231 Phone: (303) 751-1000 Fax: (303) 751-1001 www.qidr.com	PROJECT TITLE: 1. PROJECT NO.: 2. DRAWING NO.:			PROJECT TITLE: 1. PROJECT NO.: 2. DRAWING NO.:		
	PROJECT LOCATION: 3. PROJECT DESCRIPTION: 4. PROJECT STATUS:			PROJECT LOCATION: 3. PROJECT DESCRIPTION: 4. PROJECT STATUS:		
	PROJECT OWNER: 5. PROJECT MANAGER: 6. PROJECT ENGINEER:			PROJECT OWNER: 5. PROJECT MANAGER: 6. PROJECT ENGINEER:		
	PROJECT DESIGNER: 7. PROJECT CHECKER: 8. PROJECT APPROVER:			PROJECT DESIGNER: 7. PROJECT CHECKER: 8. PROJECT APPROVER:		


FB09 DETAIL (ตามโครงสร้างอาคาร)

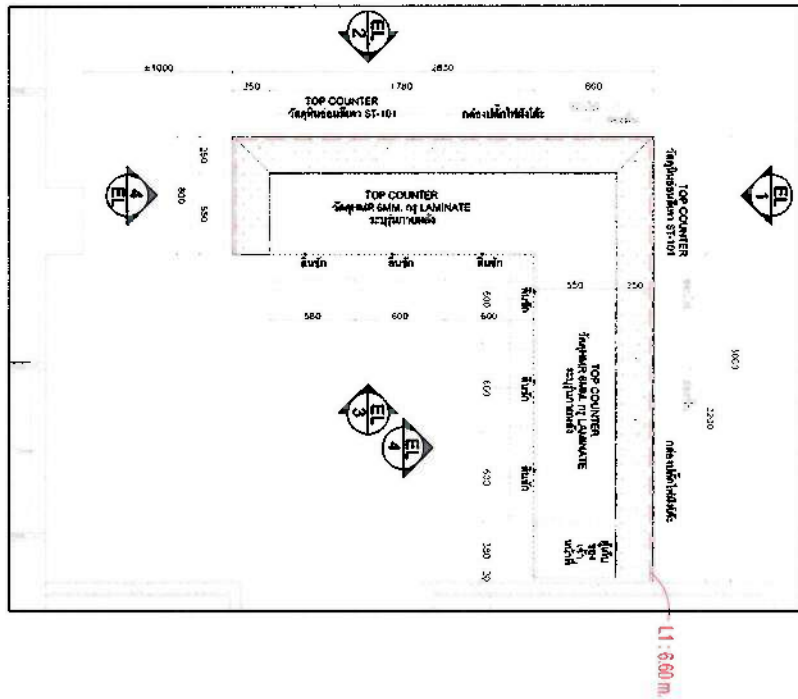


PLAN (FB08 / FB09 DETAIL)
SCALE 1:25

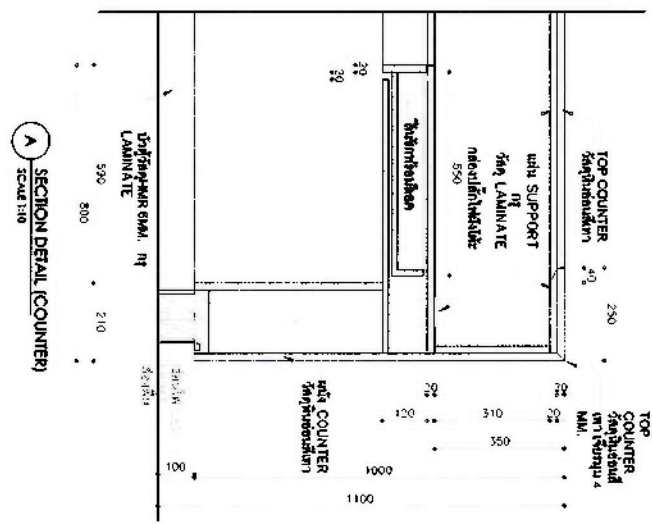


SECTION DETAIL (COUNTER)
SCALE 1:10

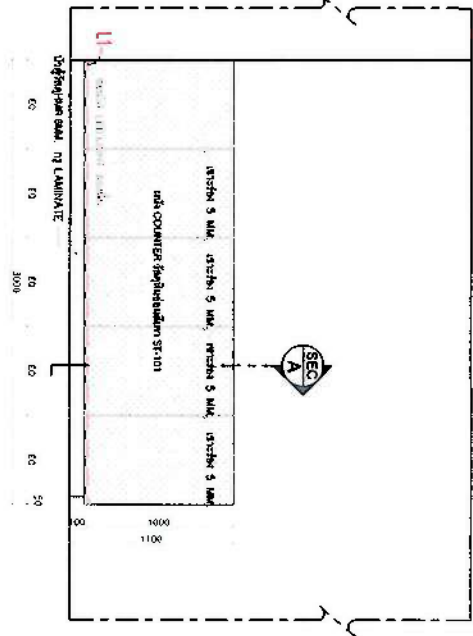


ELEVATION 1
SCALE 1:25

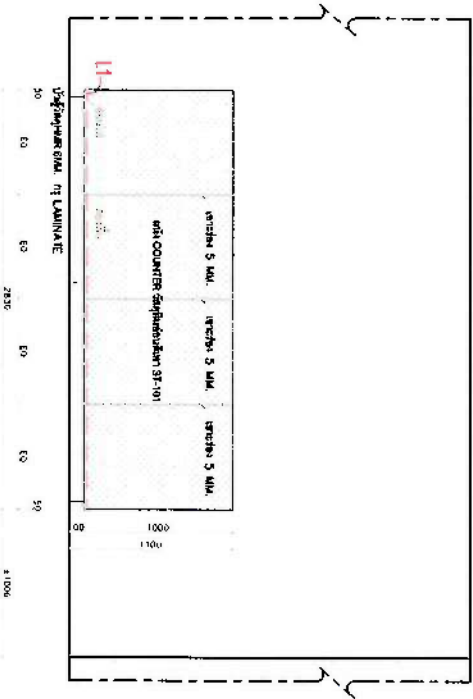

ELEVATION 2
SCALE 1:25


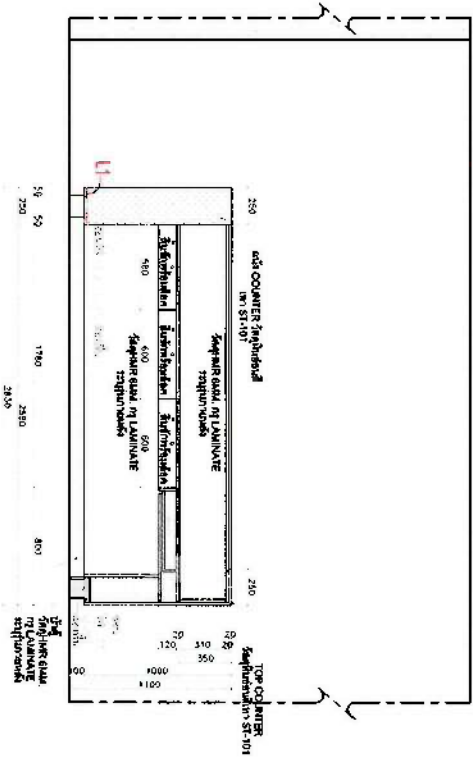


ELEVATION 3
SCALE 1:25

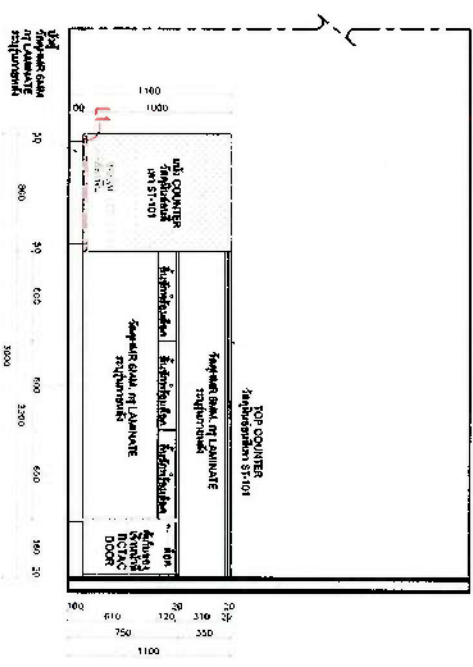

ELEVATION 4
SCALE 1:25







QIDAR		PROJECT TITLE: FB09 DETAIL (ตามโครงสร้างอาคาร)		DRAWING NO.: IN-A-03-03	
DATE: 10/10/2023	BY: [Signature]	DATE: 10/10/2023	BY: [Signature]	DATE: 10/10/2023	BY: [Signature]
REVISION:	NO.	DESCRIPTION:	SCALE:	DATE:	

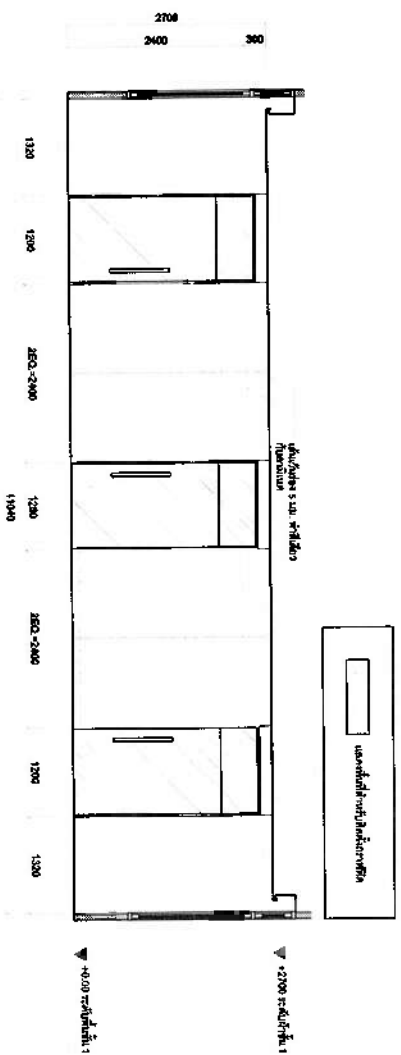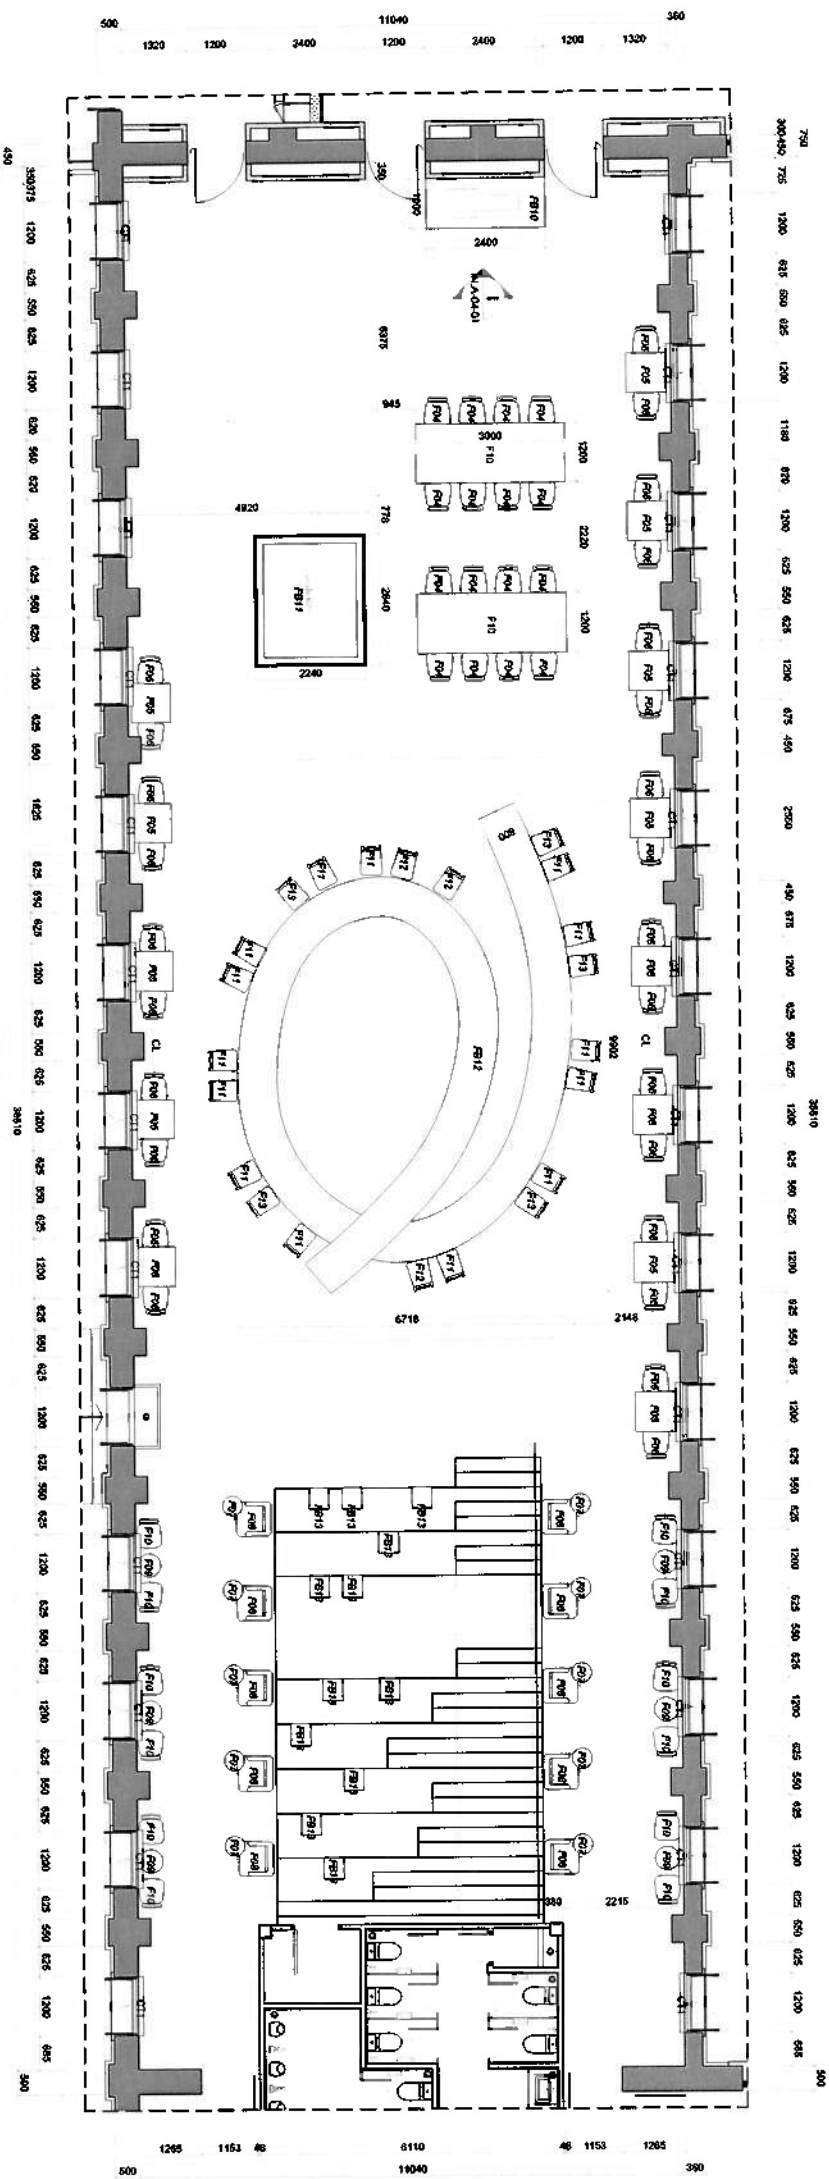


4 FURNITURE LAYOUT
SCALE 1/75

1 ELEVATION
SCALE 1/50


		PROJECT TITLE: MAINTENANCE BUILDING DRAWING NO.: IN-A-04-01	
CLIENT: MAINTENANCE BUILDING ARCHITECT: MAINTENANCE BUILDING		DRAWING NO.: IN-A-04-01 SCALE: 1/50	
PROJECT NO.: MAINTENANCE BUILDING DRAWING NO.: IN-A-04-01		DRAWING NO.: IN-A-04-01 SCALE: 1/50	

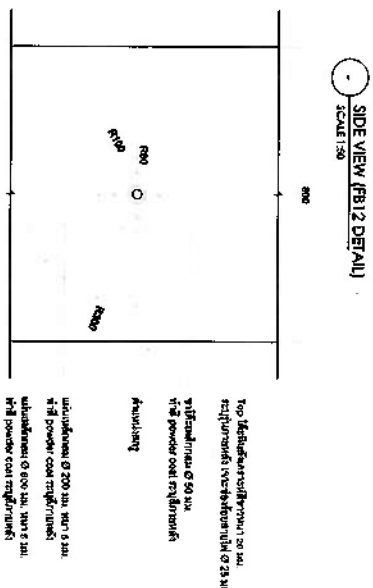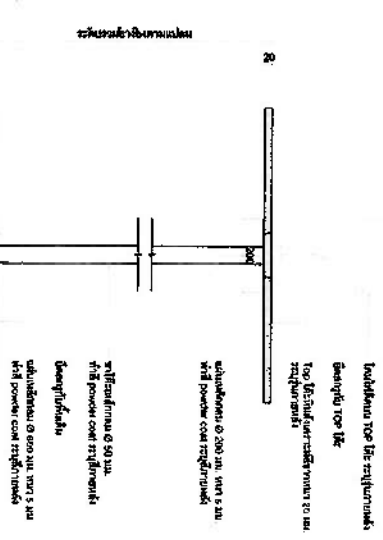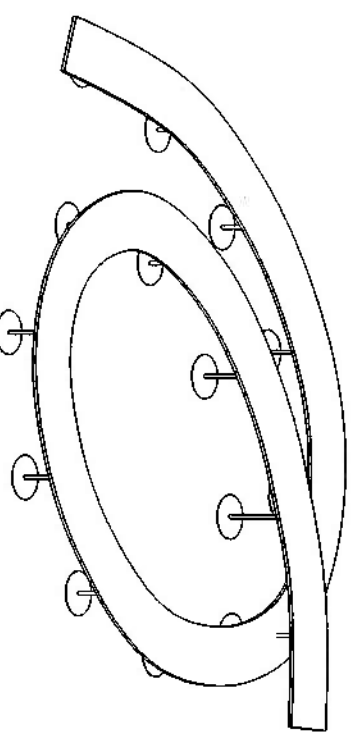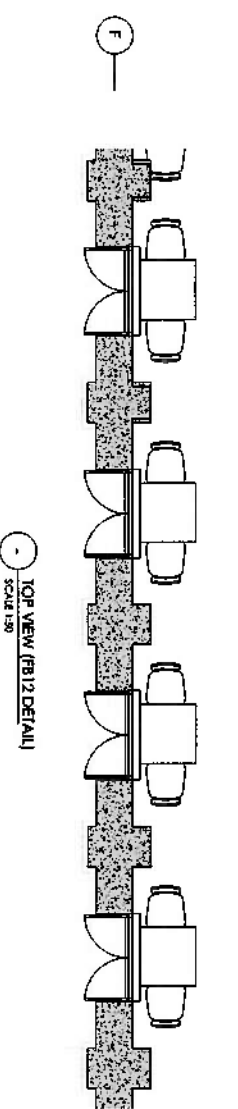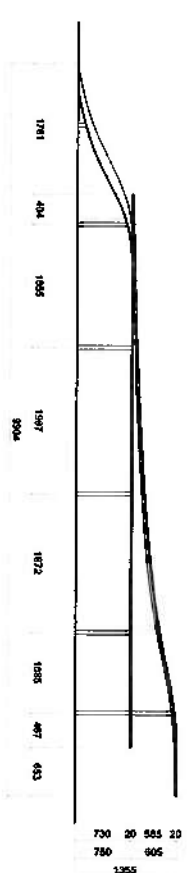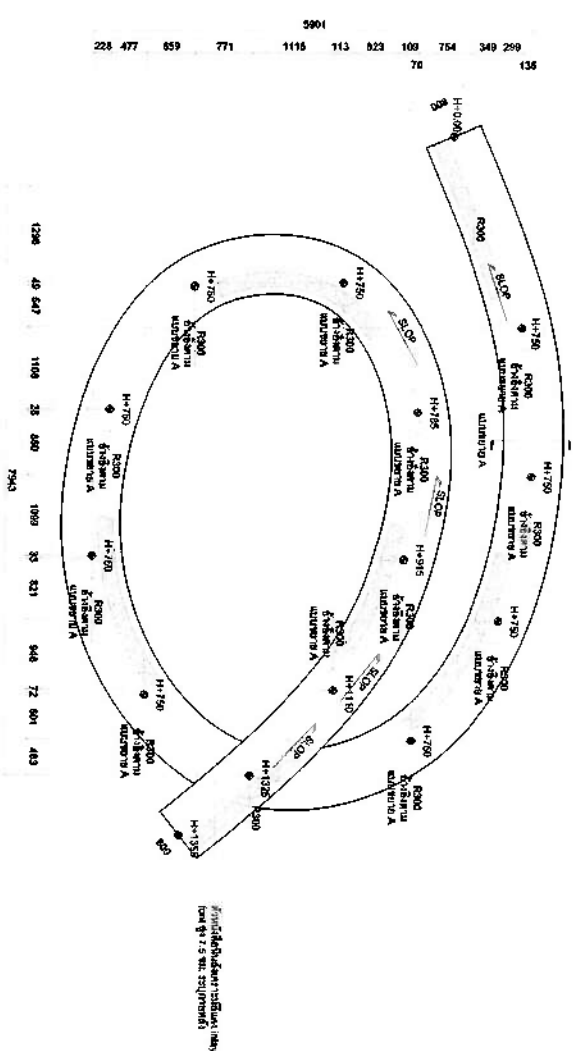


FB10 DETAIL (หน่วยผลิตแบบในรูป)

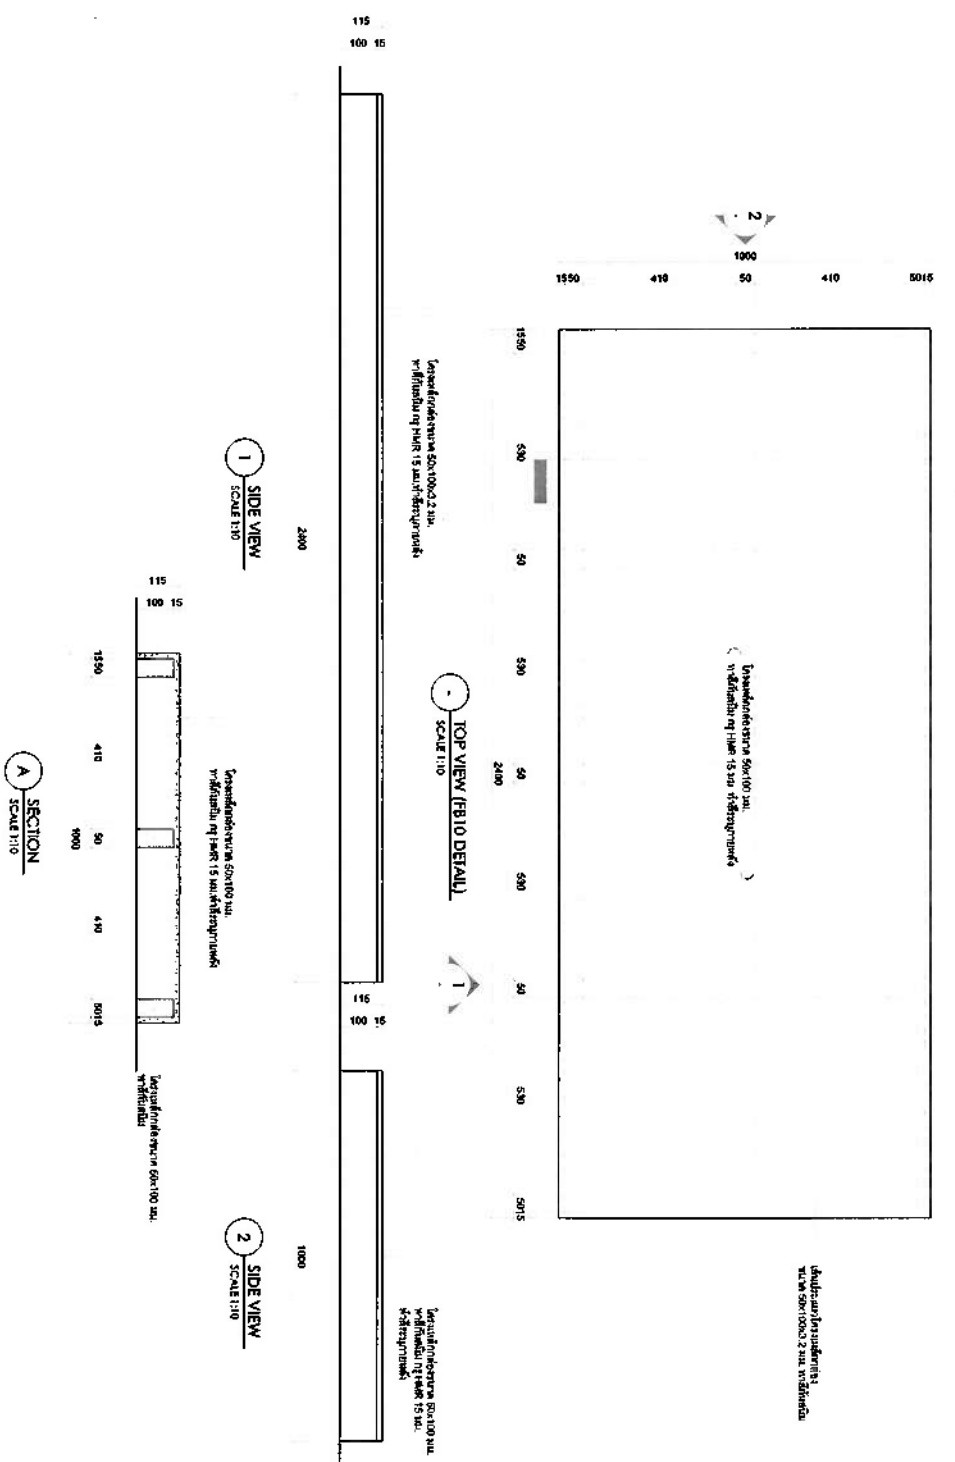


FB11 DETAIL (หน่วยผลิตแบบในรูป)

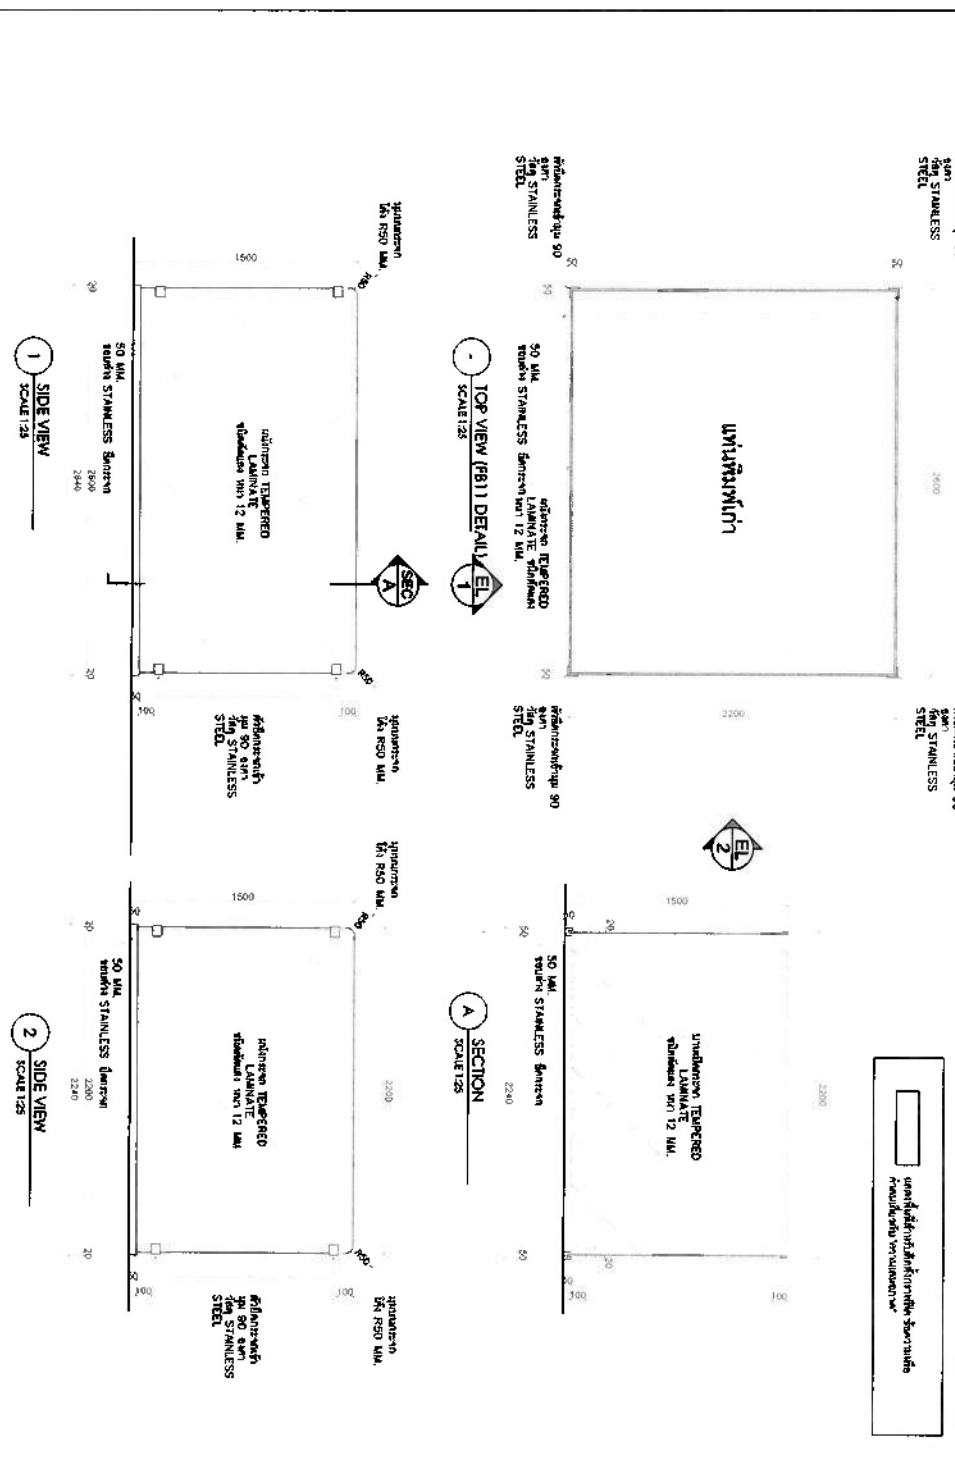


TOP VIEW (F11 DETAIL)

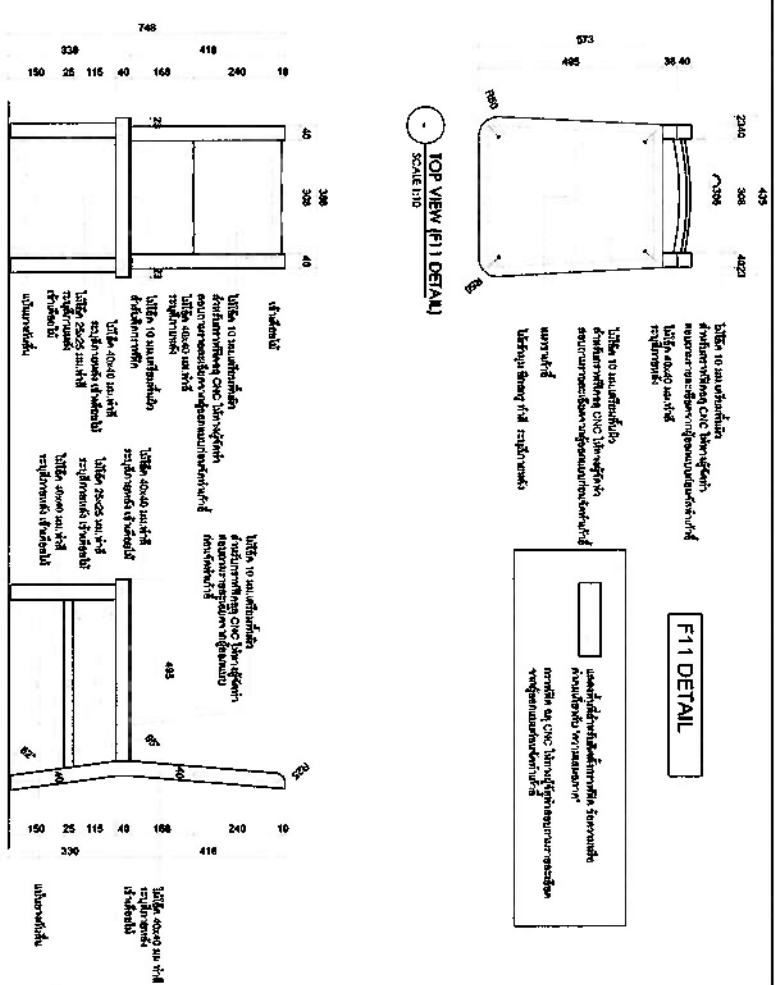

TOP VIEW (F12 DETAIL)

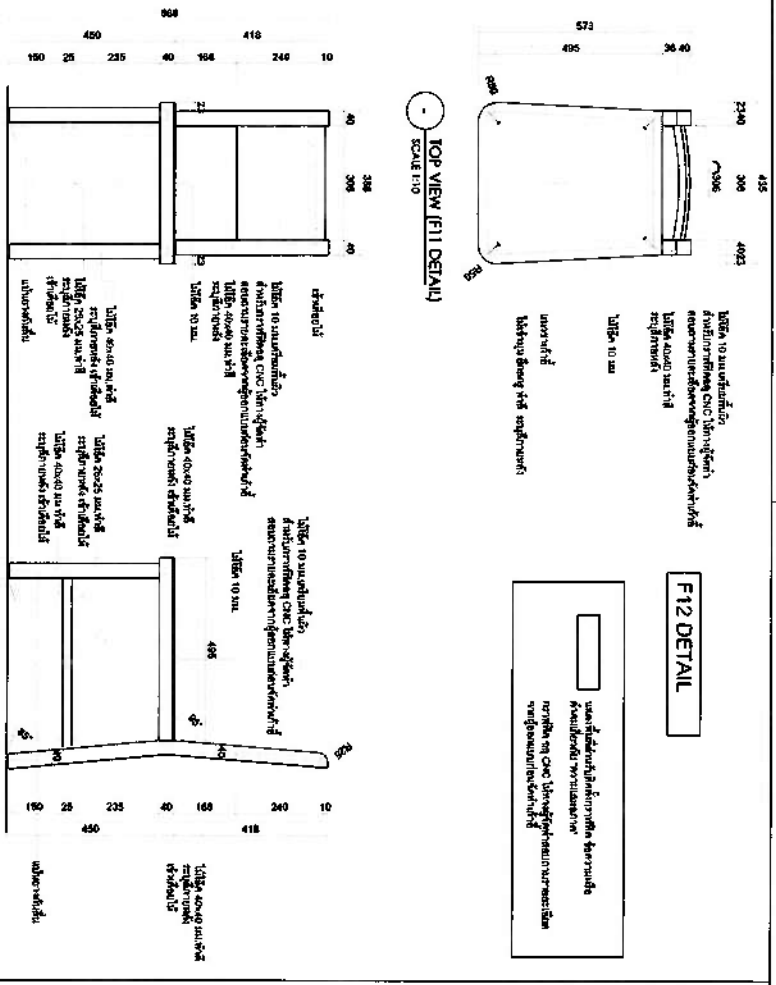

TOP VIEW (F13 DETAIL)

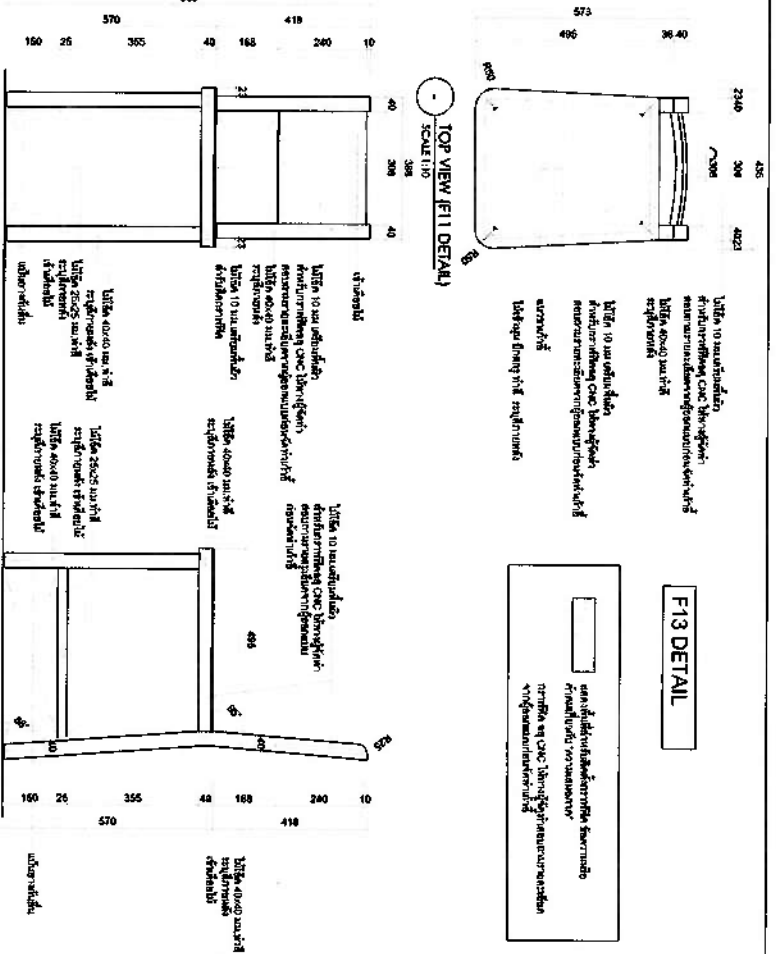

1 SIDE VIEW

2 SIDE VIEW



1 SIDE VIEW


2 SIDE VIEW

1 SIDE VIEW


2 SIDE VIEW

PROJECT TITLE		DRAWING TITLE	
FB10 DETAIL (หน่วยผลิตแบบในรูป)		FB11 DETAIL (หน่วยผลิตแบบในรูป)	
FB12 DETAIL (หน่วยผลิตแบบในรูป)		FB13 DETAIL (หน่วยผลิตแบบในรูป)	
DATE: 10/10/2023		DATE: 10/10/2023	
DRAWN BY: [Signature]		DRAWN BY: [Signature]	
CHECKED BY: [Signature]		CHECKED BY: [Signature]	
SCALE: 1:10		SCALE: 1:10	
PROJECT NO: 1000		PROJECT NO: 1000	
DRAWING NO: IN-A-04-04		DRAWING NO: IN-A-04-04	

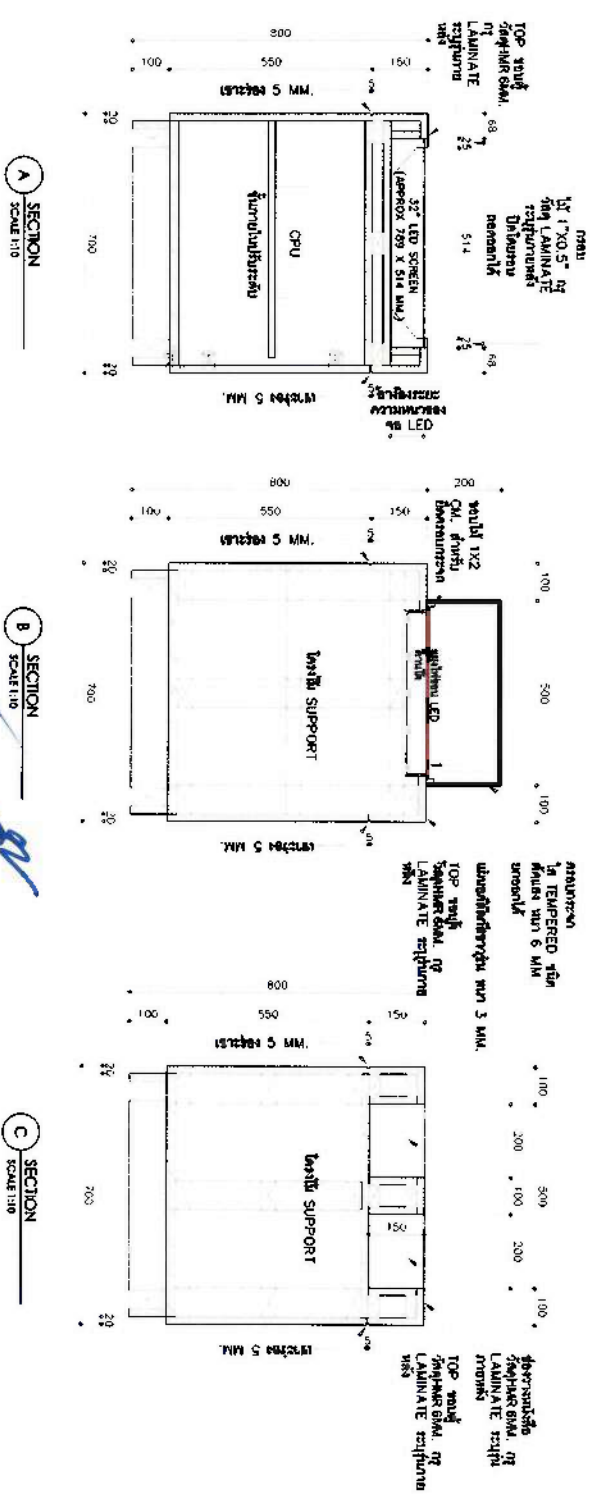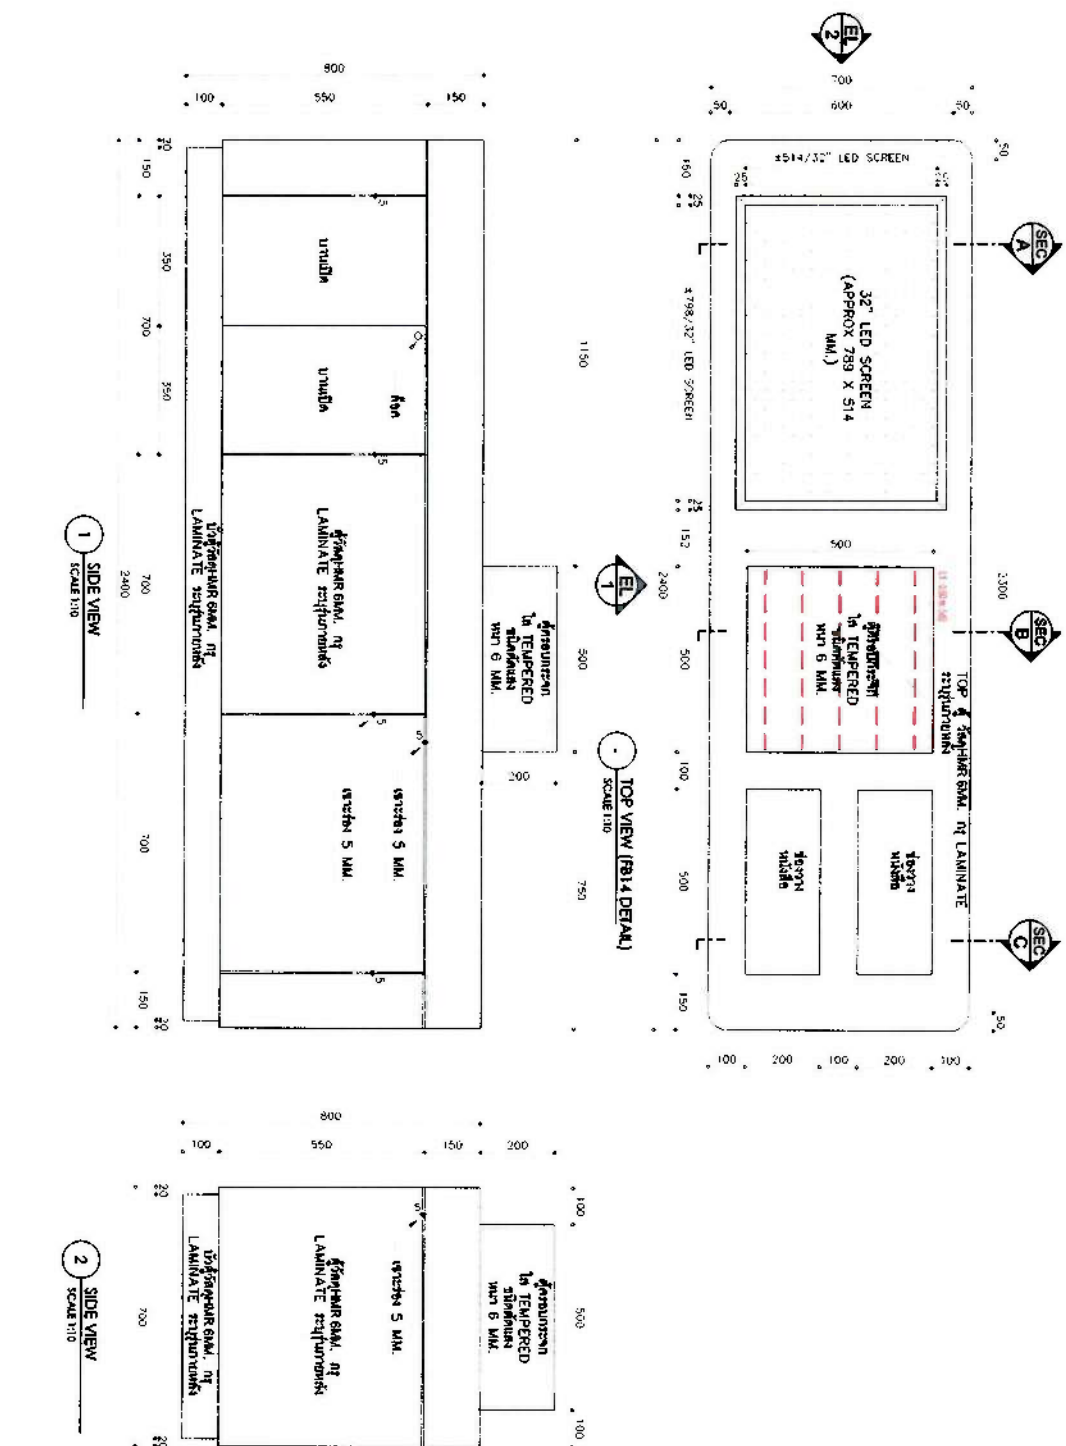
[illegible][illegible]

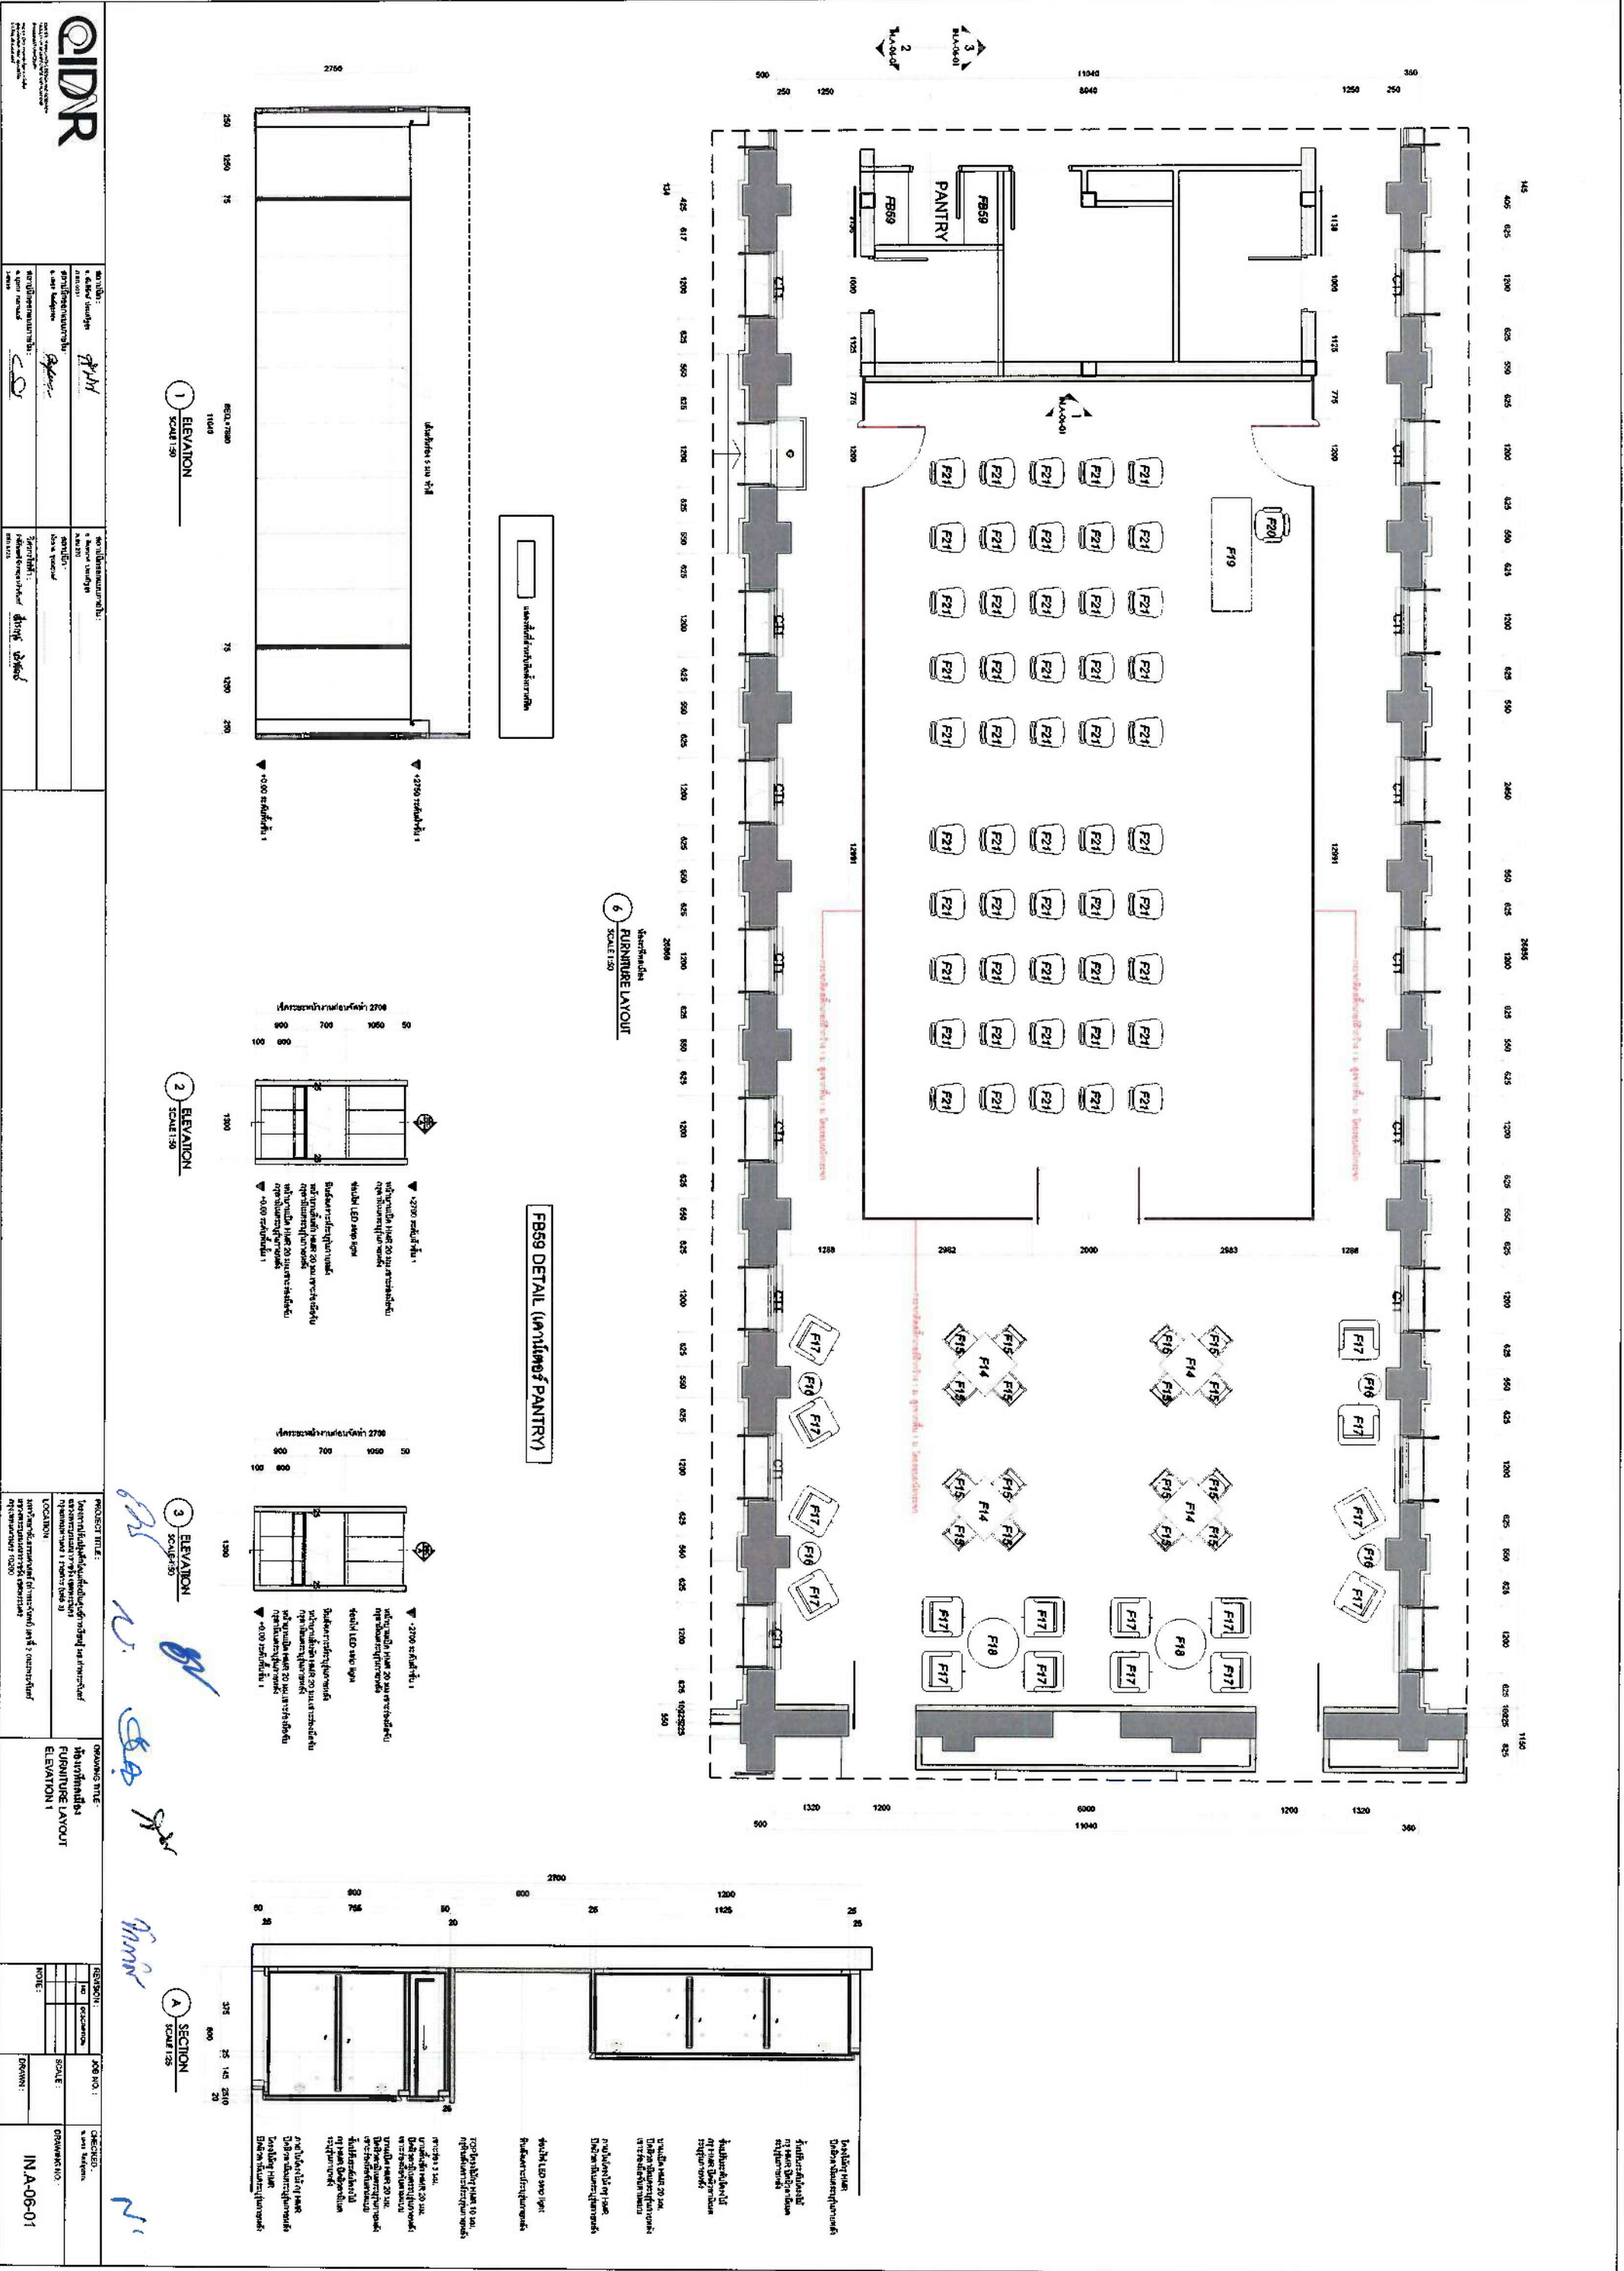


QIDAR	
PROJECT TITLE: FB59 DETAIL (KITCHEN OF PANTRY)	PROJECT NO.: IN-A-06-01
LOCATION: FB59	DATE: 2023-10-20
DESIGNER: QIDAR	CHECKED: QIDAR
DRAWN: QIDAR	SCALE: 1:50

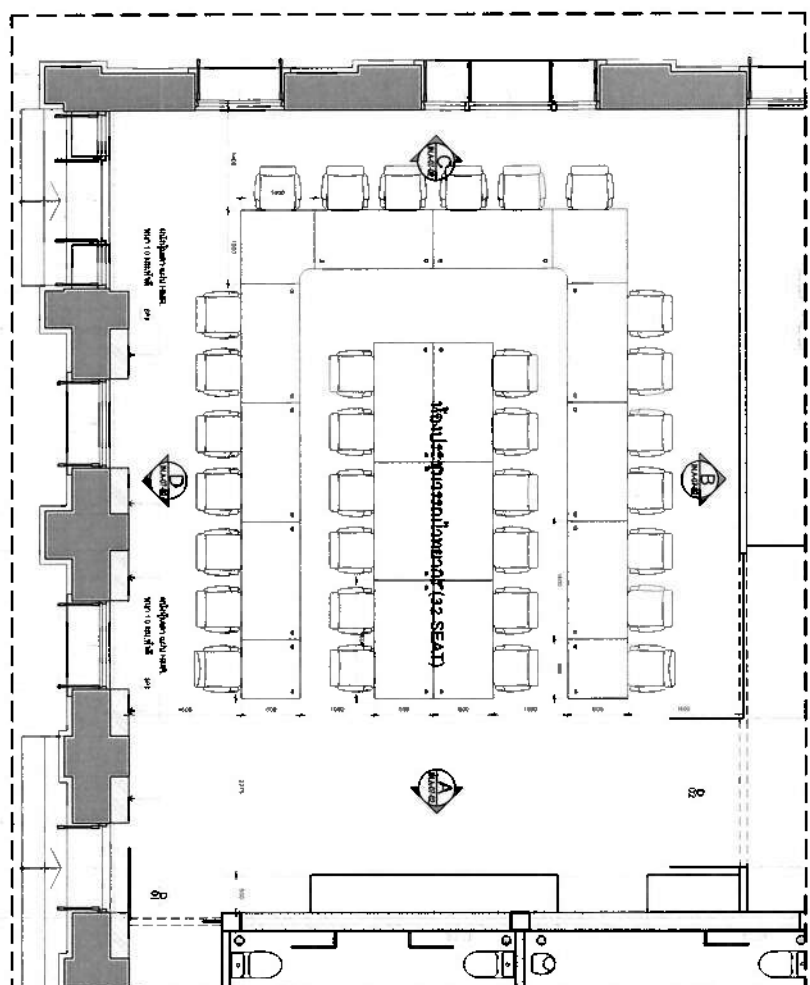

FURNITURE LAYOUT
SCALE 1:50

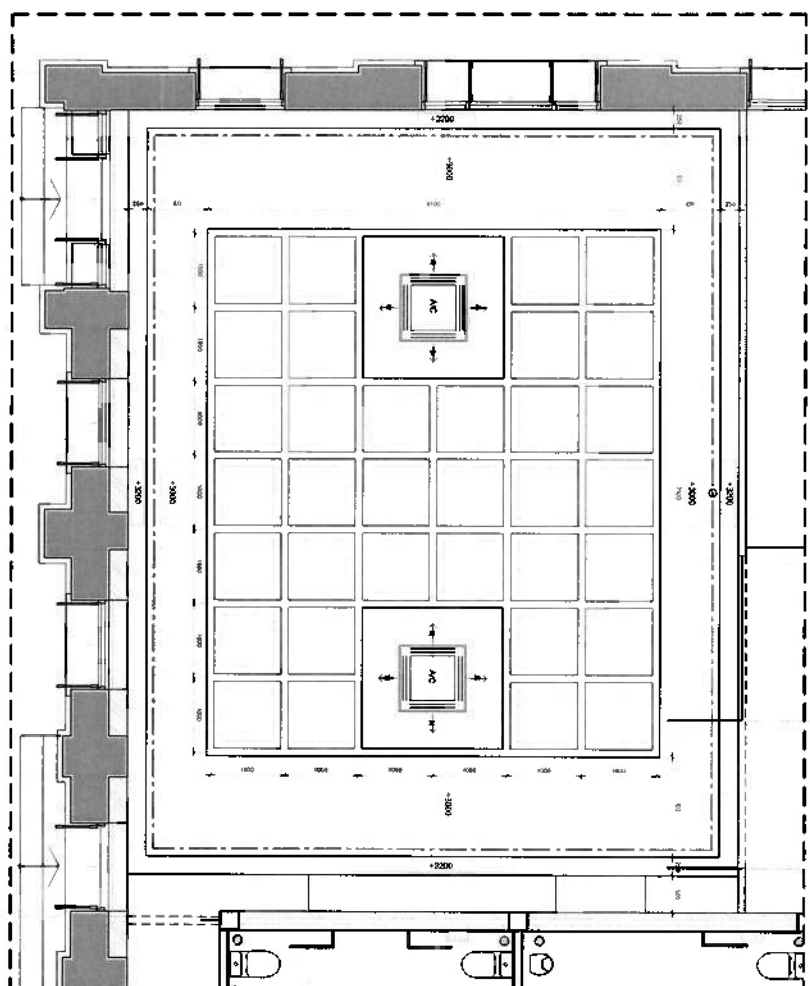


CEILING LIGHTING & AIR CONDITION LAYOUT
SCALE 1:50

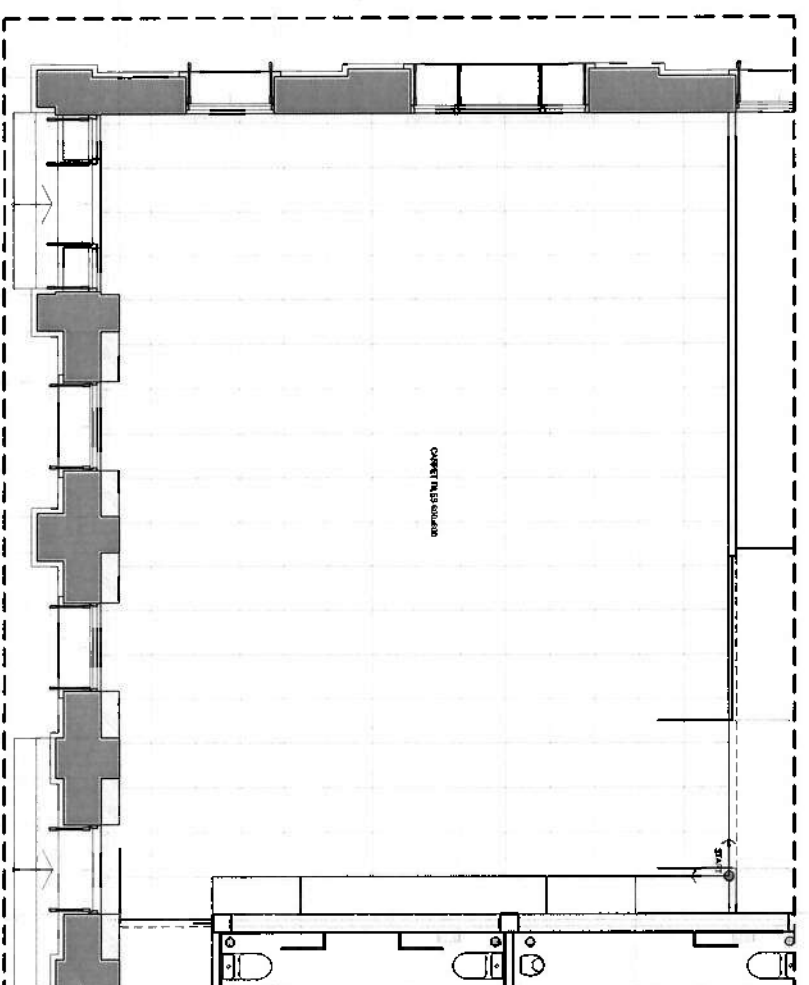


FLOOR FINISHED LAYOUT
SCALE 1:50


QIDAR QIDAR CONSULTING & DESIGN 100, 101, 102, 999, 1000		PROJECT TITLE: 1st FLOOR FURNITURE LAYOUT CEILING LIGHTING & AIR CONDITION LAYOUT FLOOR FINISHED LAYOUT	DRAWING NO.: IN/A-07-01
---	--	---	----------------------------

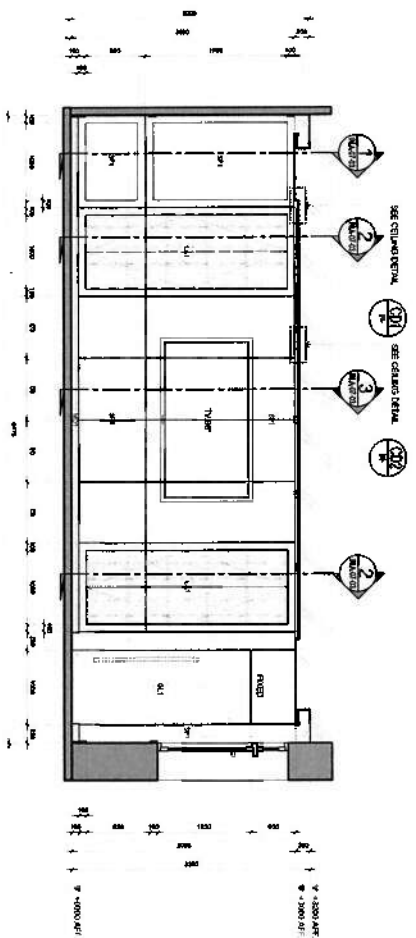


Architectural
ELEVATION-A
SCALE 1/8"

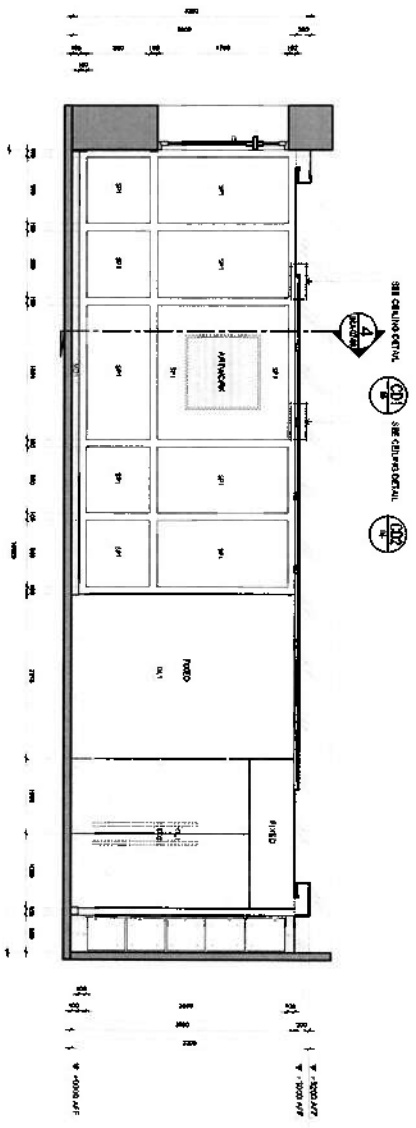


Architectural
ELEVATION-B
SCALE 1/8"

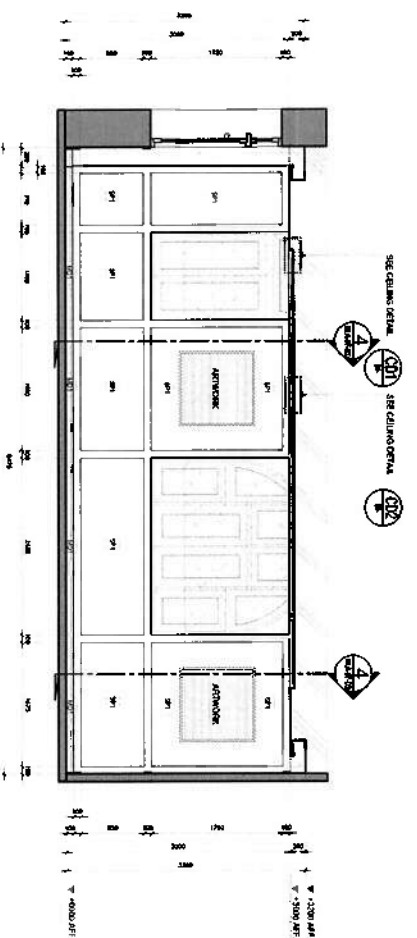


Architectural
ELEVATION-C
SCALE 1/8"

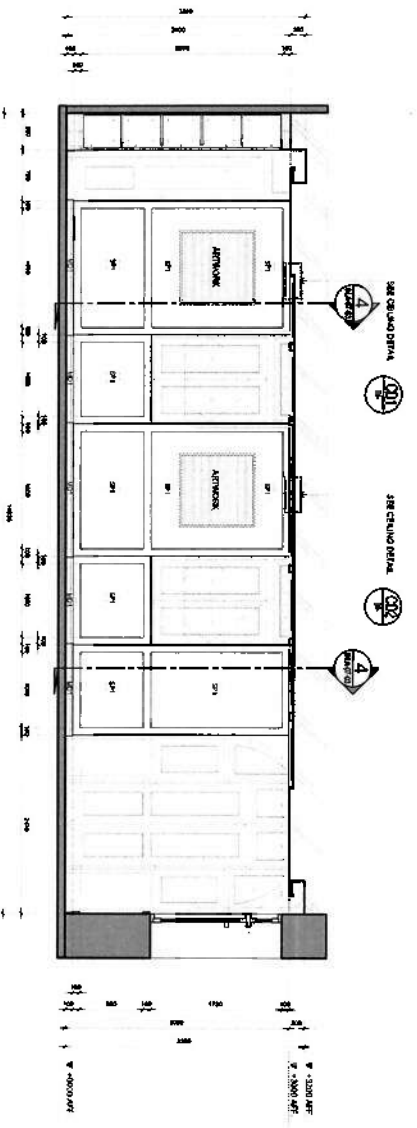

Architectural
ELEVATION-D
SCALE 1/8"

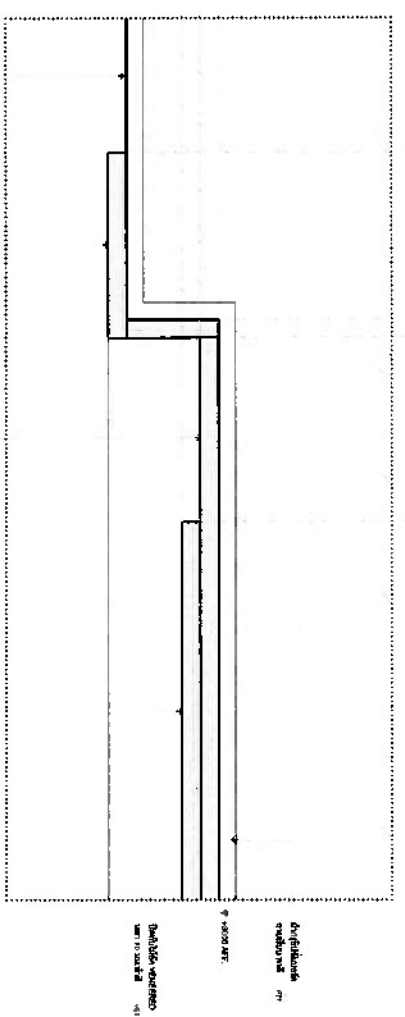

Architectural
CEILING DETAIL-CD1
SCALE 1/8"

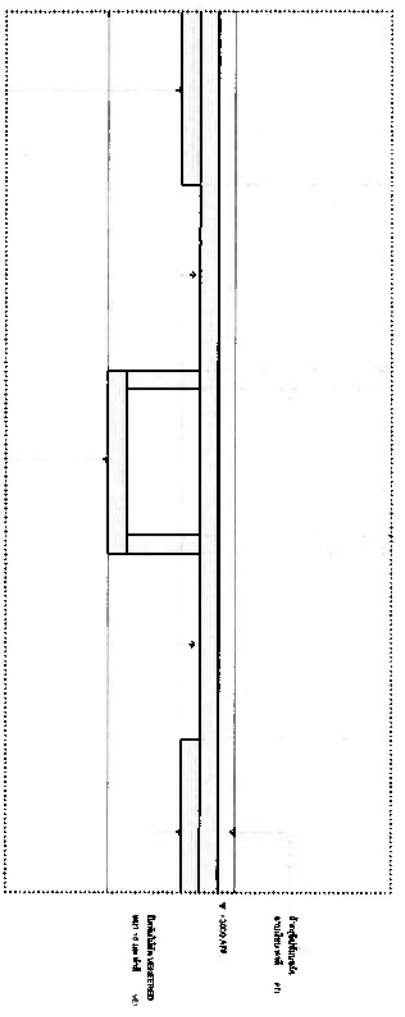

Architectural
CEILING DETAIL-CD2
SCALE 1/8"

		PROJECT TITLE: 1st FLOOR CEILING DETAIL-CD1, CD2	
ARCHITECT: CIDAR	PROJECT NO.: 15-A-07-02	DRAWING NO.: 15-A-07-02	SCALE: 1/8"
PROJECT LOCATION: 15-A-07-02	PROJECT DESCRIPTION: 1st FLOOR CEILING DETAIL-CD1, CD2	PROJECT DATE: 15-A-07-02	PROJECT STATUS: 15-A-07-02

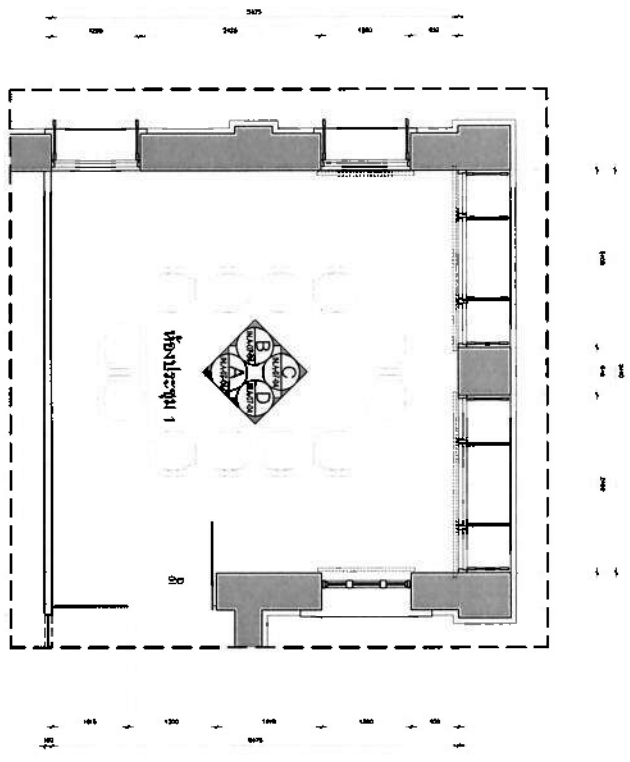


Fig. 1
FURNITURE LAYOUT
SCALE 1:50

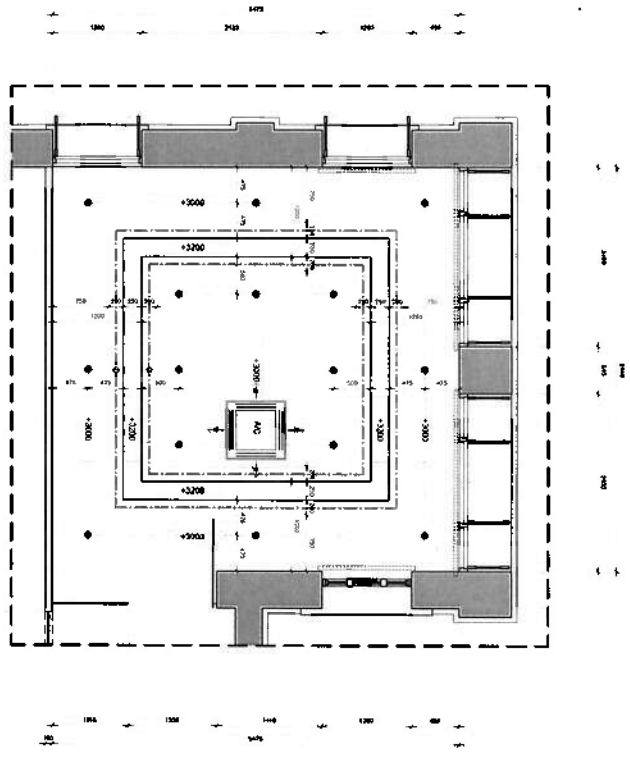


Fig. 2
CEILING & LIGHTING LAYOUT
SCALE 1:50

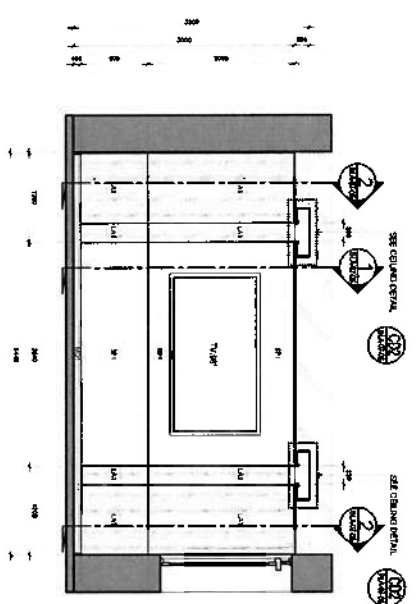


Fig. 3
ELEVATION A
SCALE 1:50

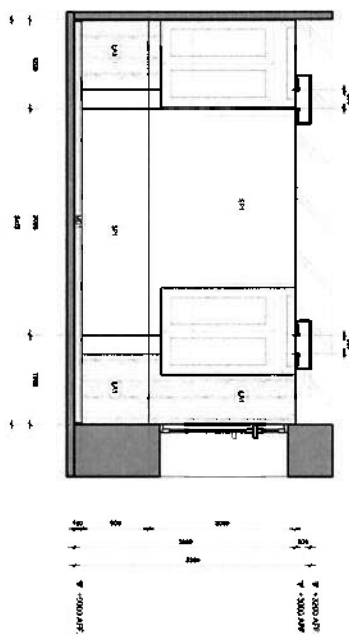


Fig. 4
ELEVATION B
SCALE 1:50

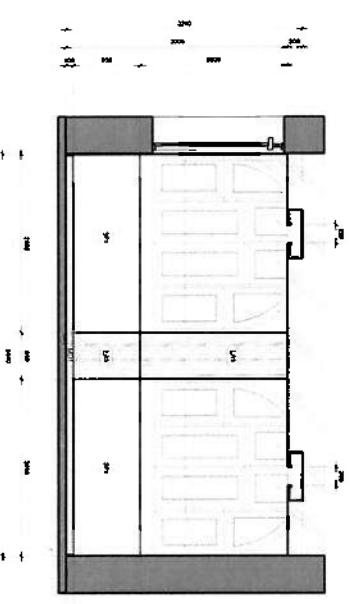


Fig. 5
ELEVATION C
SCALE 1:50



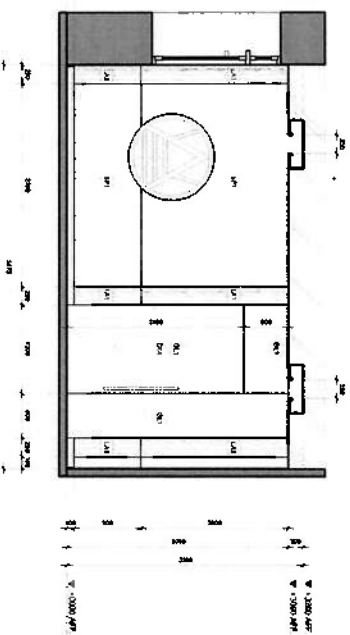


Fig. 6
ELEVATION D
SCALE 1:50




		PROJECT TITLE: Development of a new building for the Ministry of Education and Science		DRAWING TITLE: FURNITURE LAYOUT CEILING & LIGHTING LAYOUT ELEVATION A, B, C, D, E, F ELEVATION G, H	
CLIENT: Ministry of Education and Science		LOCATION: 1st floor, Room 101		DATE: 10.10.2024	
DESIGNER: CIDAR		CHECKED: IN.A-07-04		SCALE: 1:50	

DATE		SHEET NO.	
DRAWING NO.		PROJECT NAME	
SCALE		DESIGNED BY	
CHECKED BY		APPROVED BY	
NOTES			

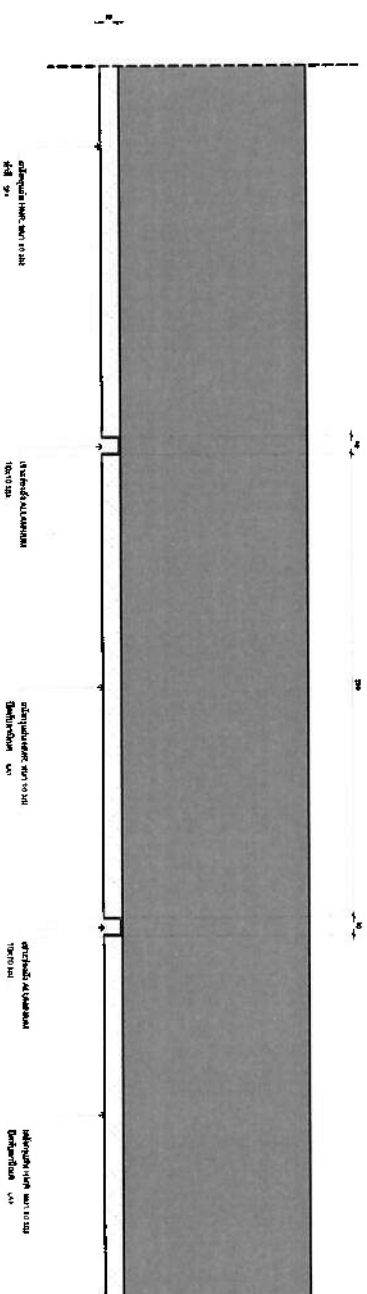
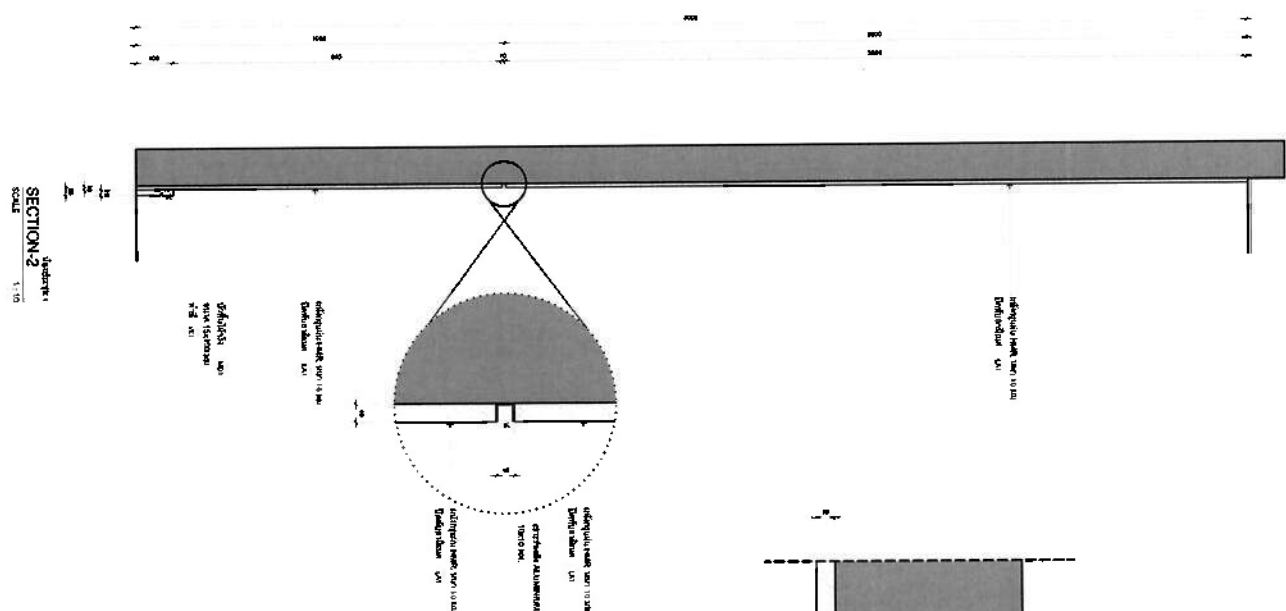


SECTION-3


[Handwritten signatures and marks]

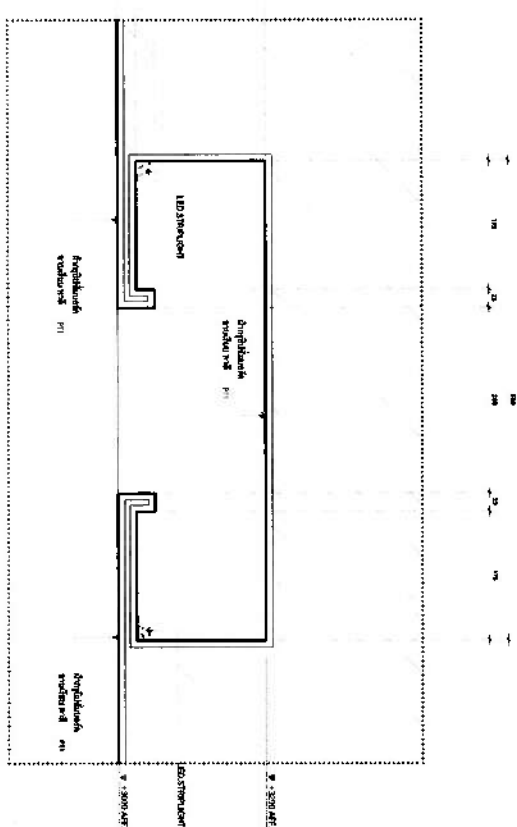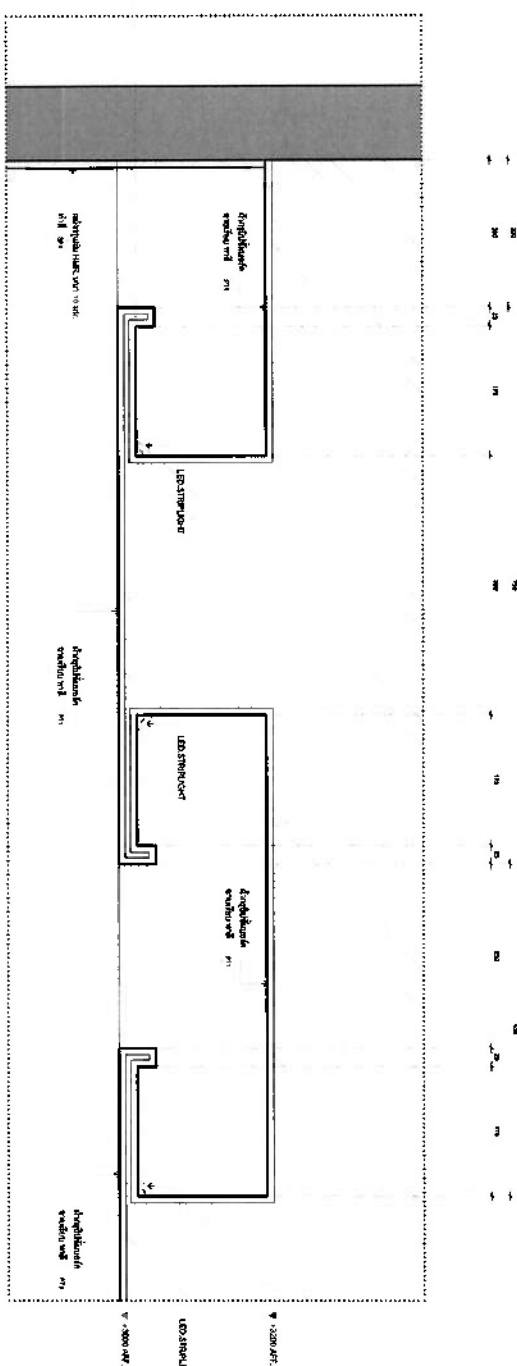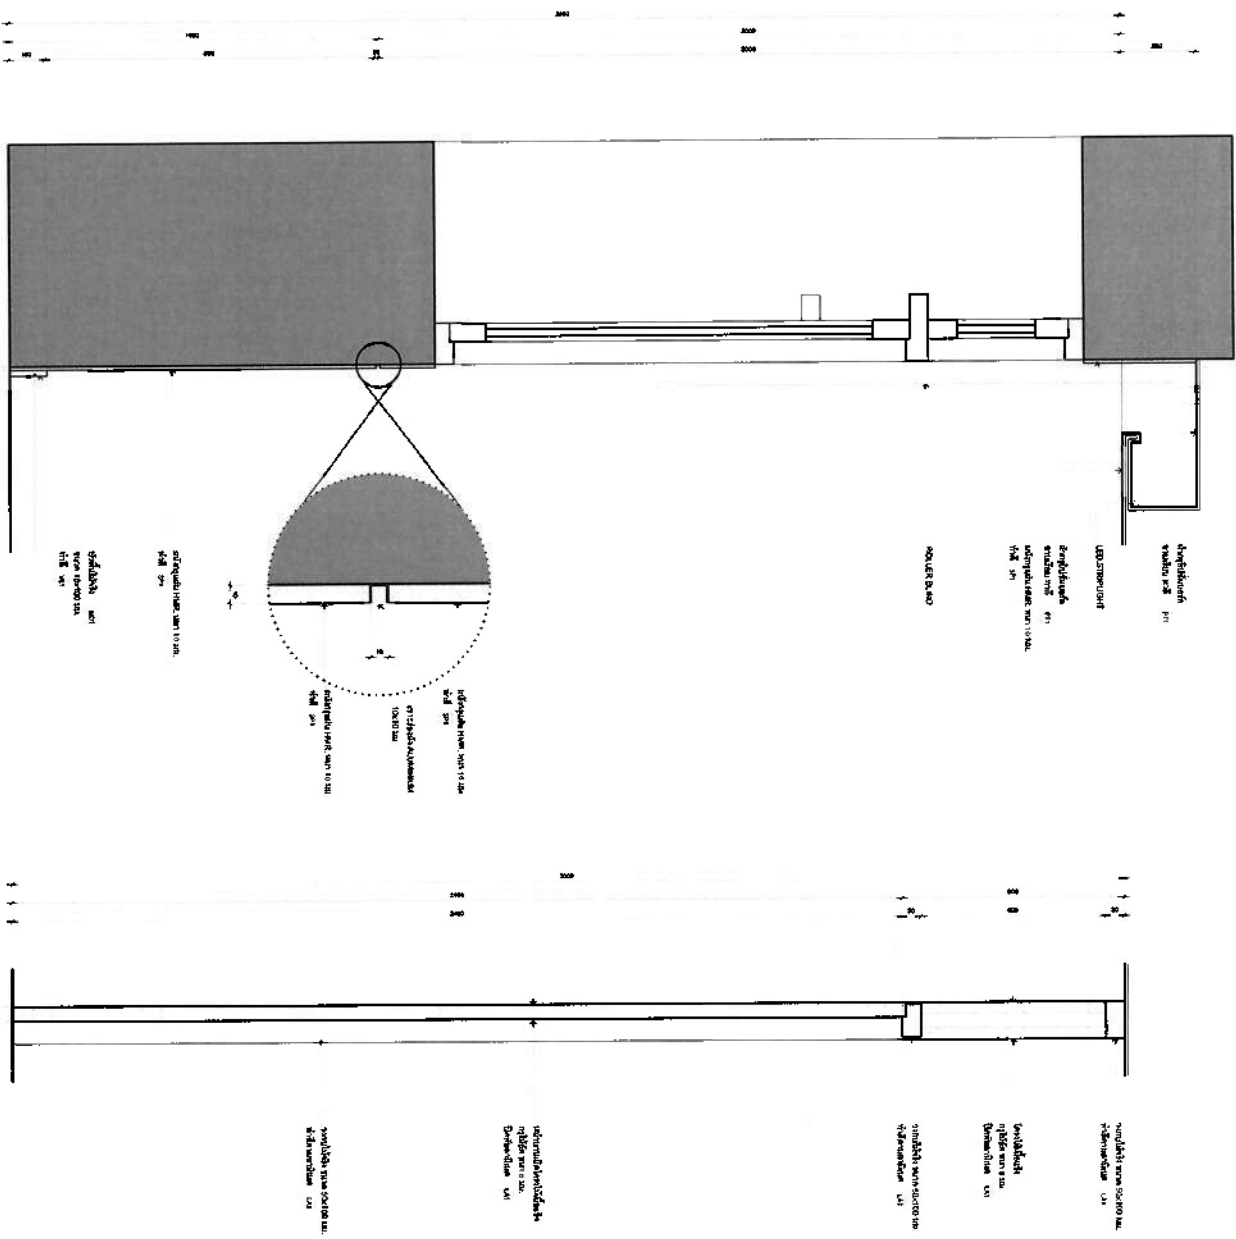

B
 2
 1
 2
 3
 524

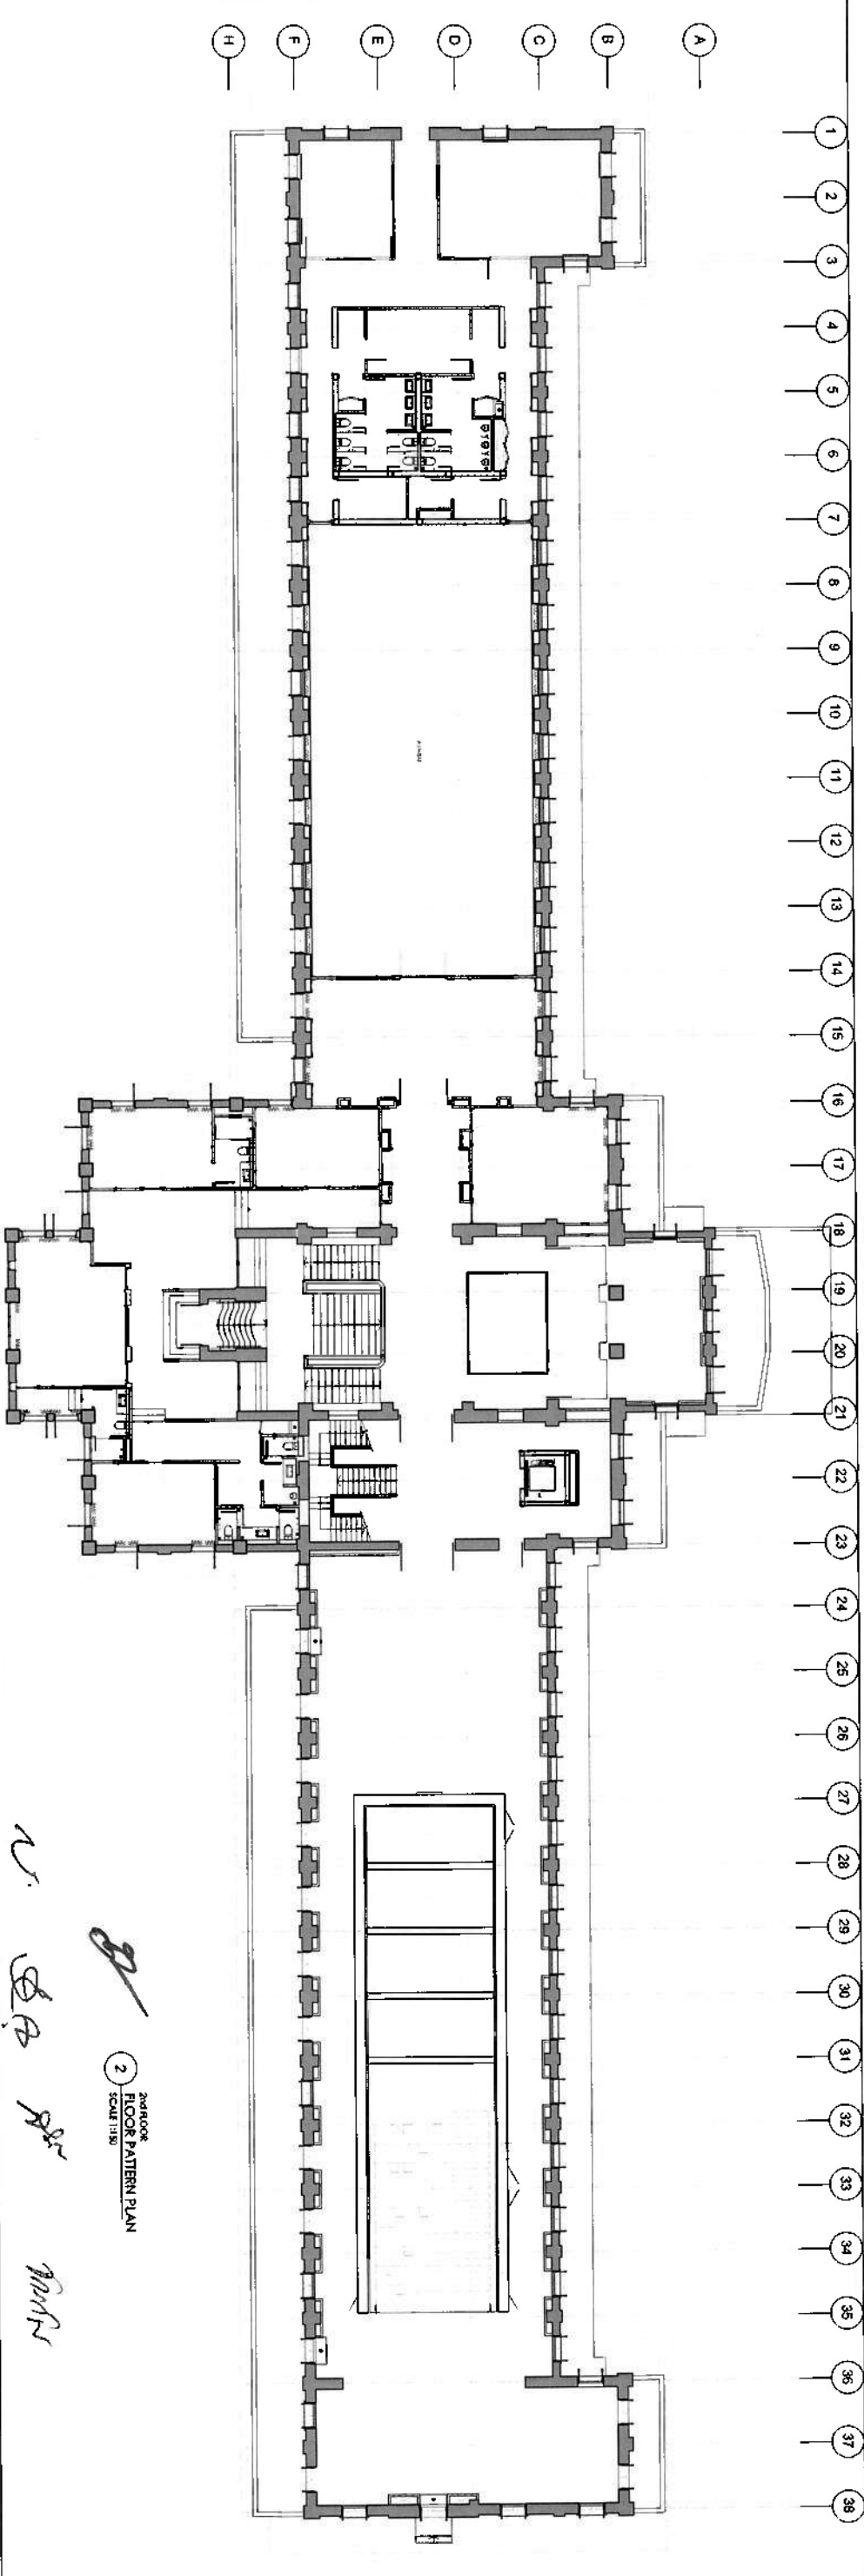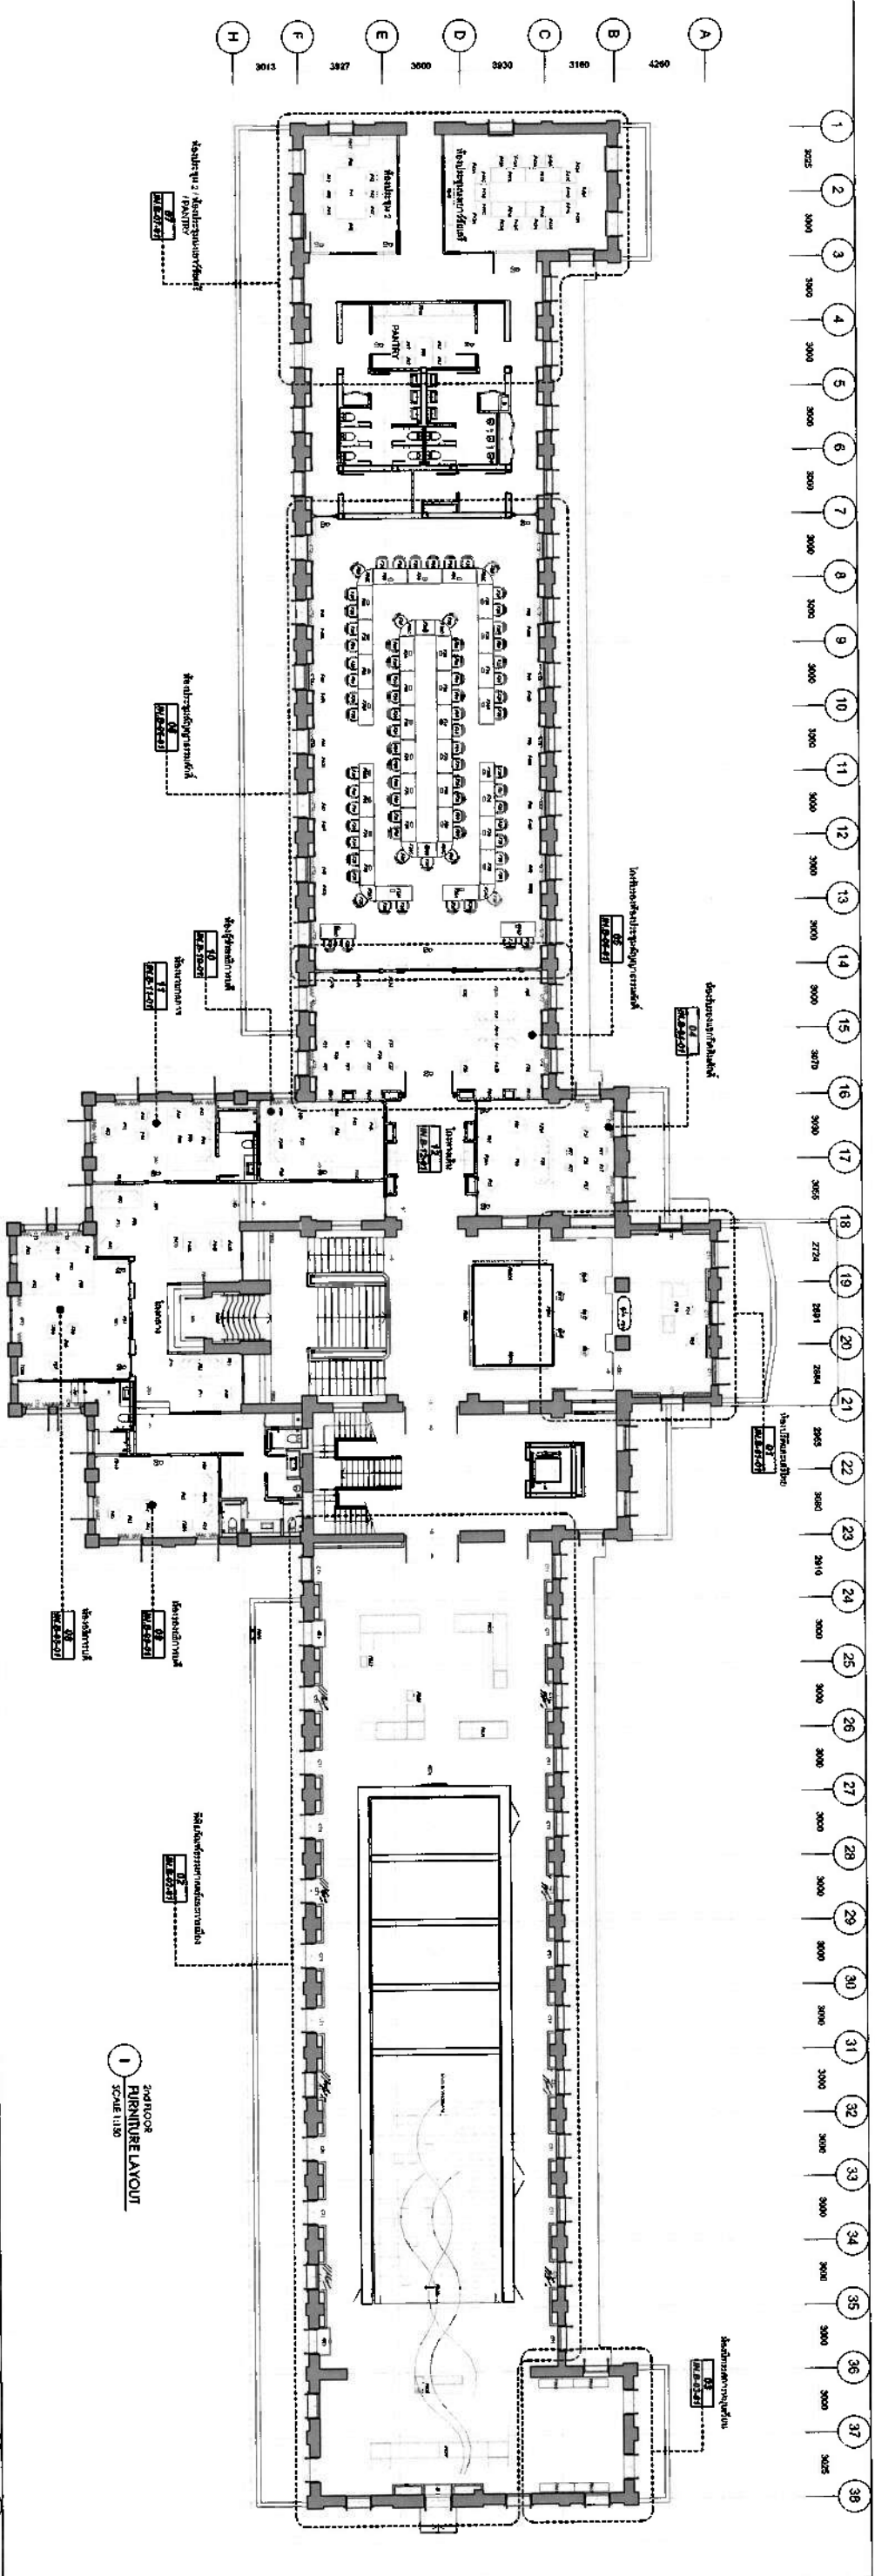


- 16
- 17
- 18
- 19
- 20
- 21
- 22
- 23
- 24
- 25
- 26
- 27
- 28
- 29
- 30
- 31
- 32
- 33
- 34
- 35
- 36
- 37
- 38

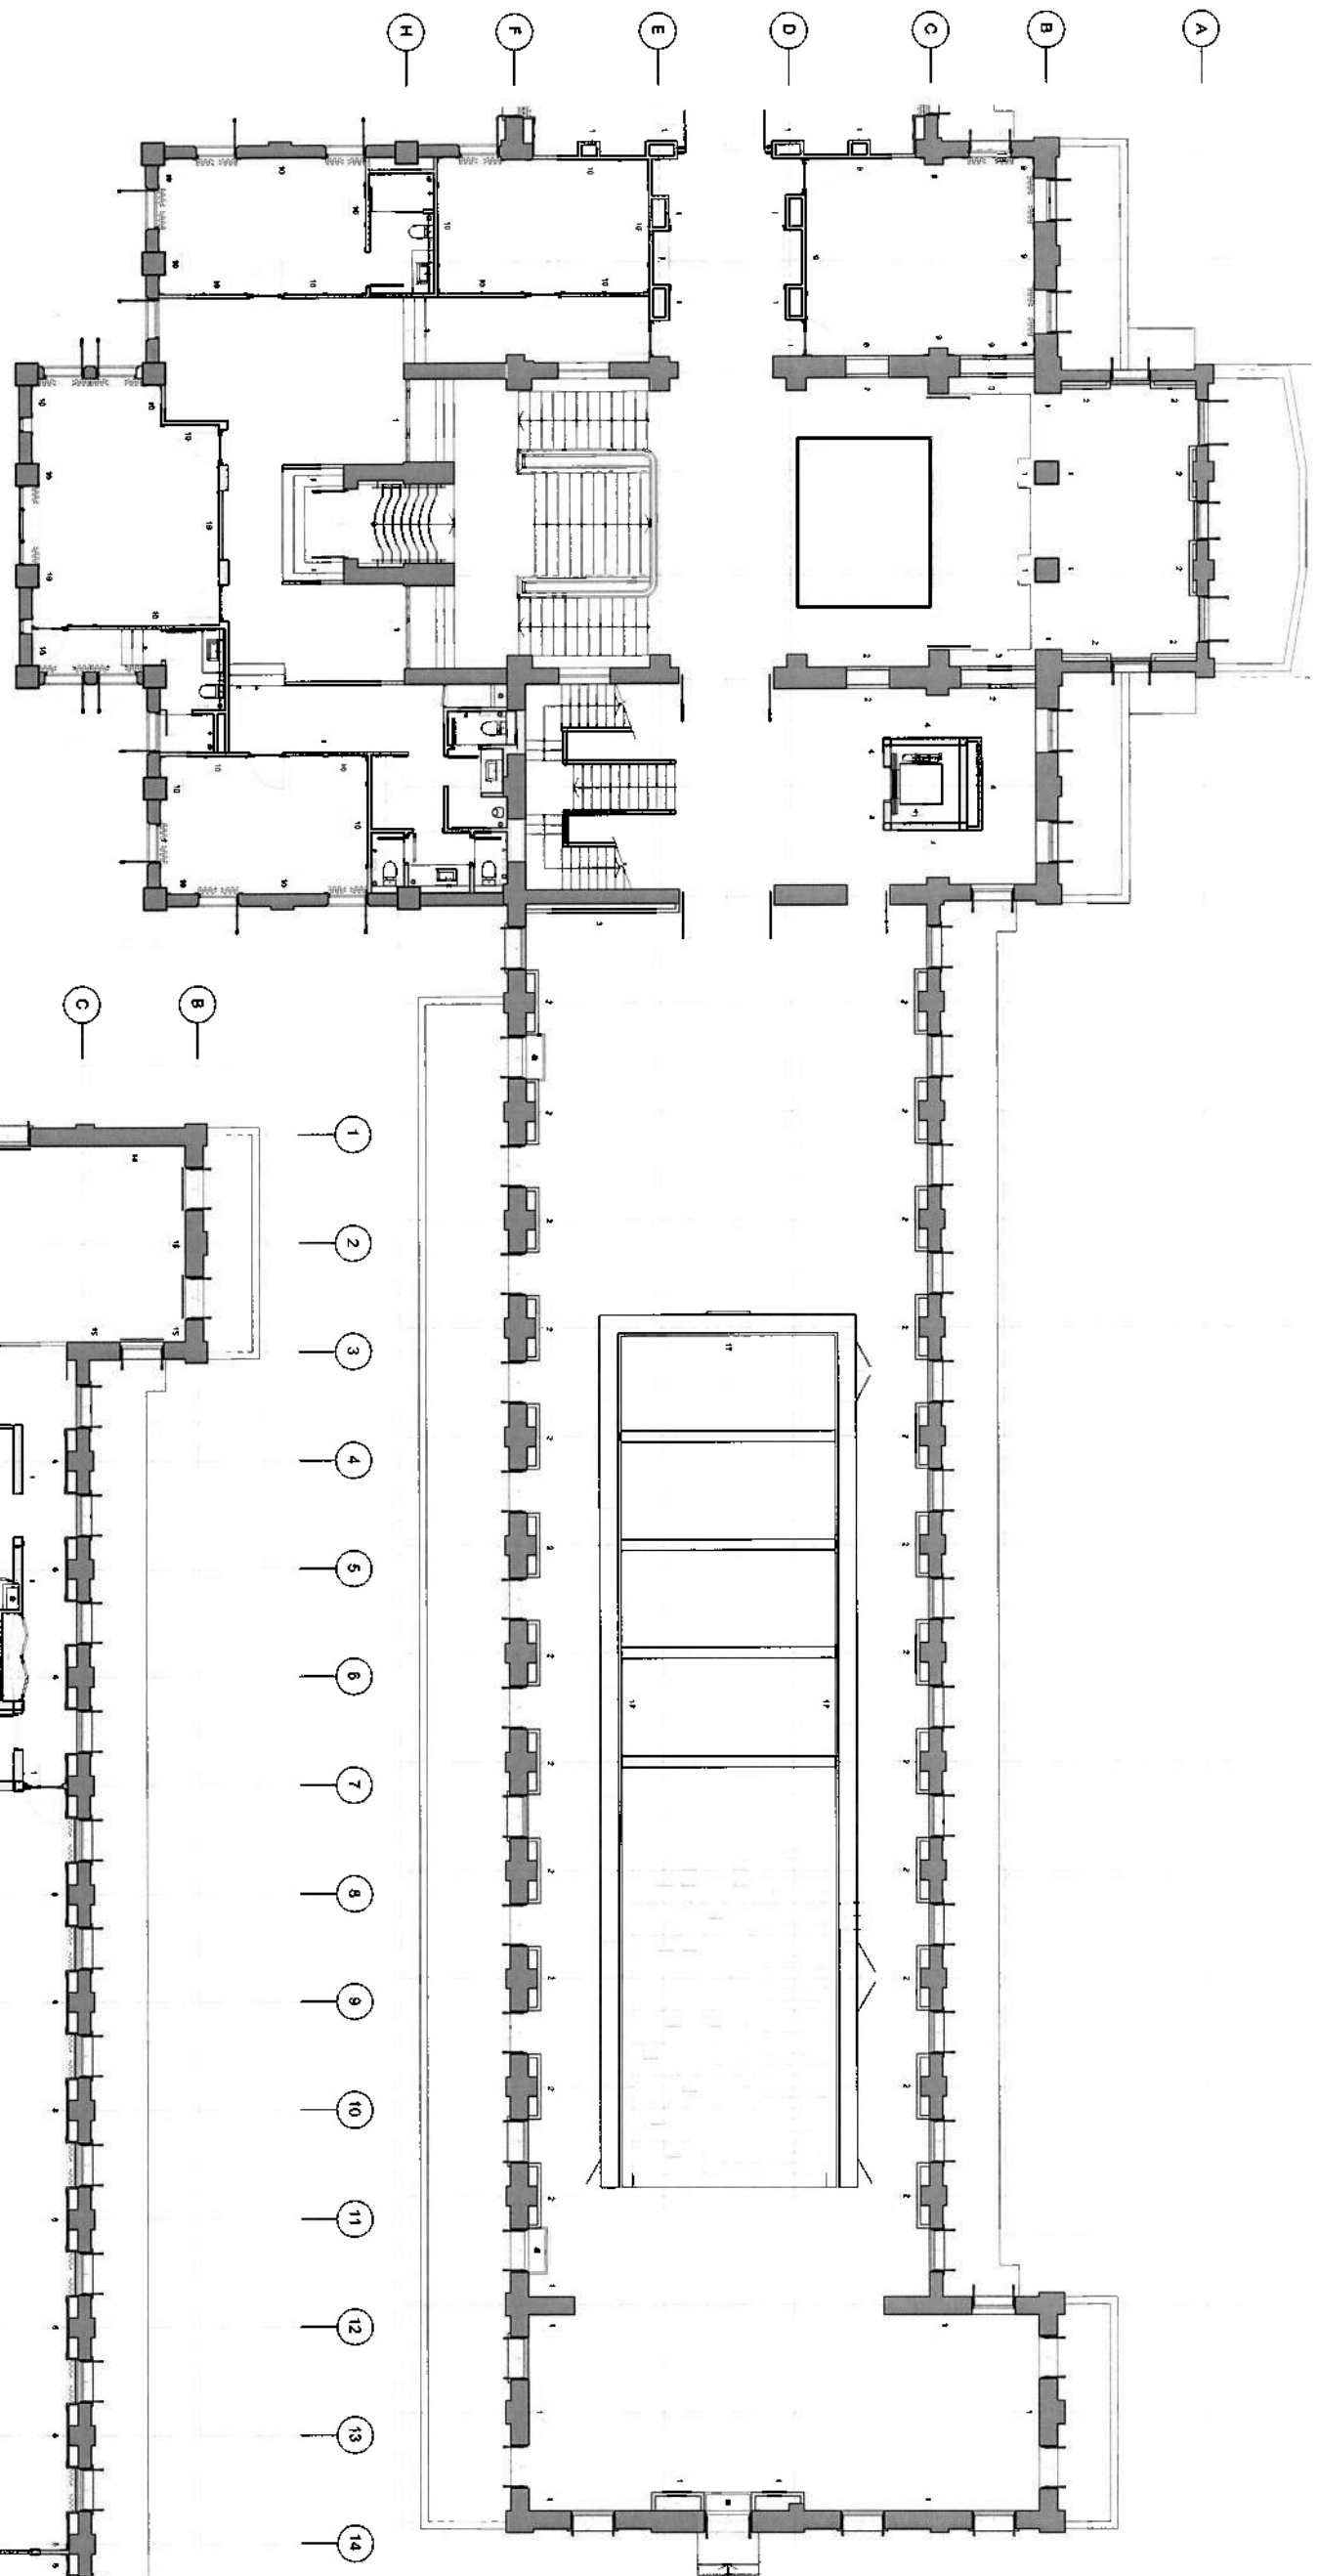


2nd FLOOR
WALL PLAN
3 SCALE 1:100

QIDAR		PROJECT TITLE: 2nd FLOOR WALL PLAN	
DRAWING NO: IN-B-00-02		LOCATION: 2nd FLOOR	
DATE: 10/20/2023		DRAWN BY: [Signature]	
CHECKED BY: [Signature]		APPROVED BY: [Signature]	
REVISION:		JOB NO:	
NO.		SCALE:	
DATE:		DRAWN:	
CHECKED:		APPROVED:	
DRAWING NO:		JOB NO:	
DATE:		SCALE:	
DRAWN BY:		CHECKED BY:	
APPROVED BY:		DATE:	

- 16
- 17
- 18
- 19
- 20
- 21
- 22
- 23
- 24
- 25
- 26
- 27
- 28
- 29
- 30
- 31
- 32
- 33
- 34
- 35
- 36
- 37
- 38

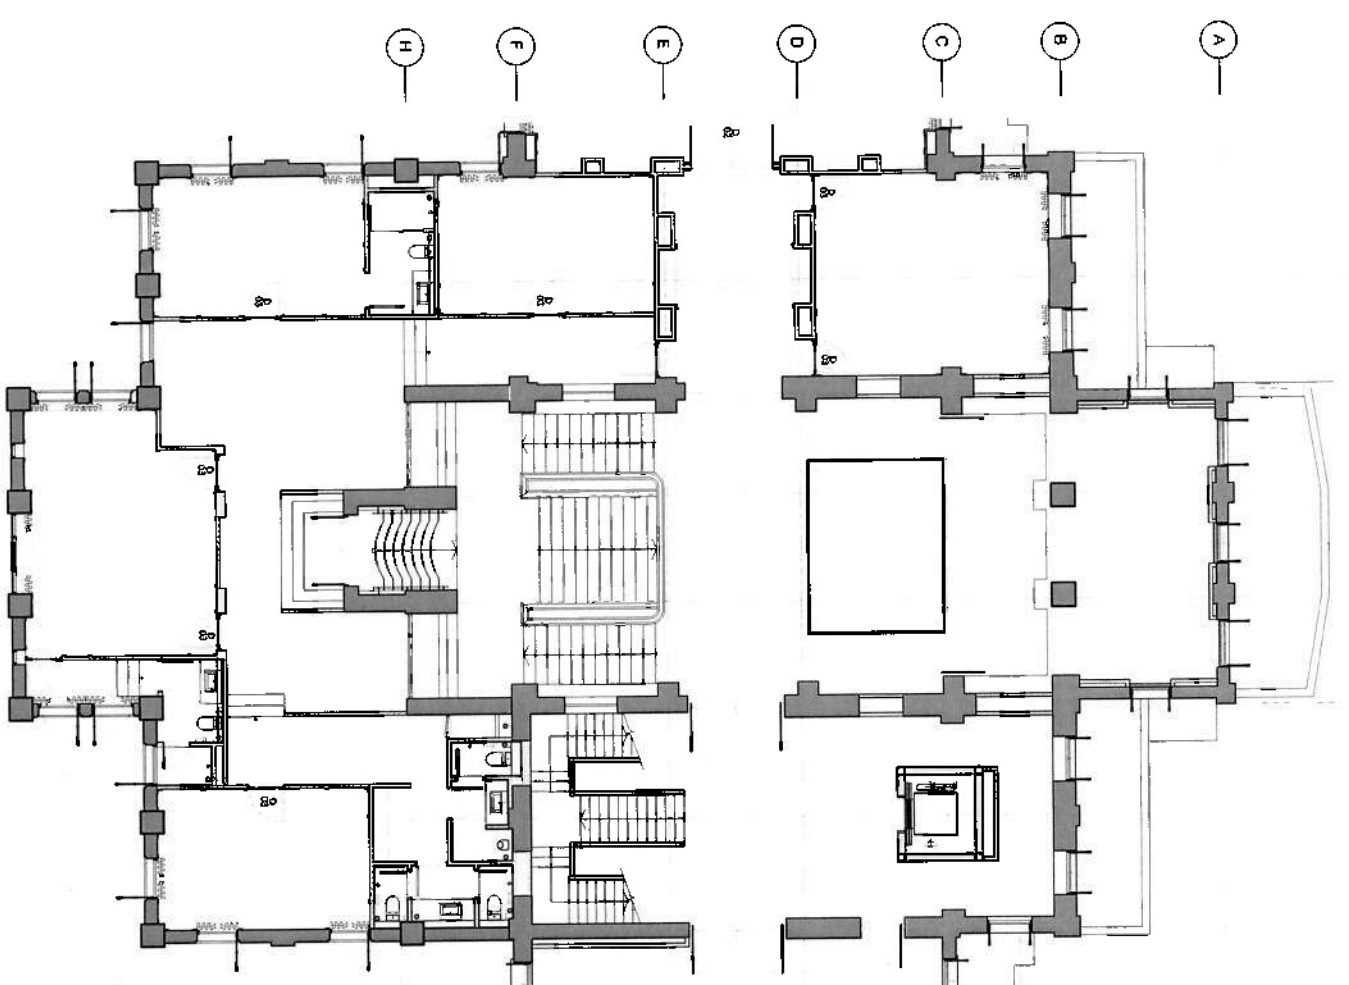


2nd FLOOR
DOOR & WINDOW PLAN
SCALE 1:100

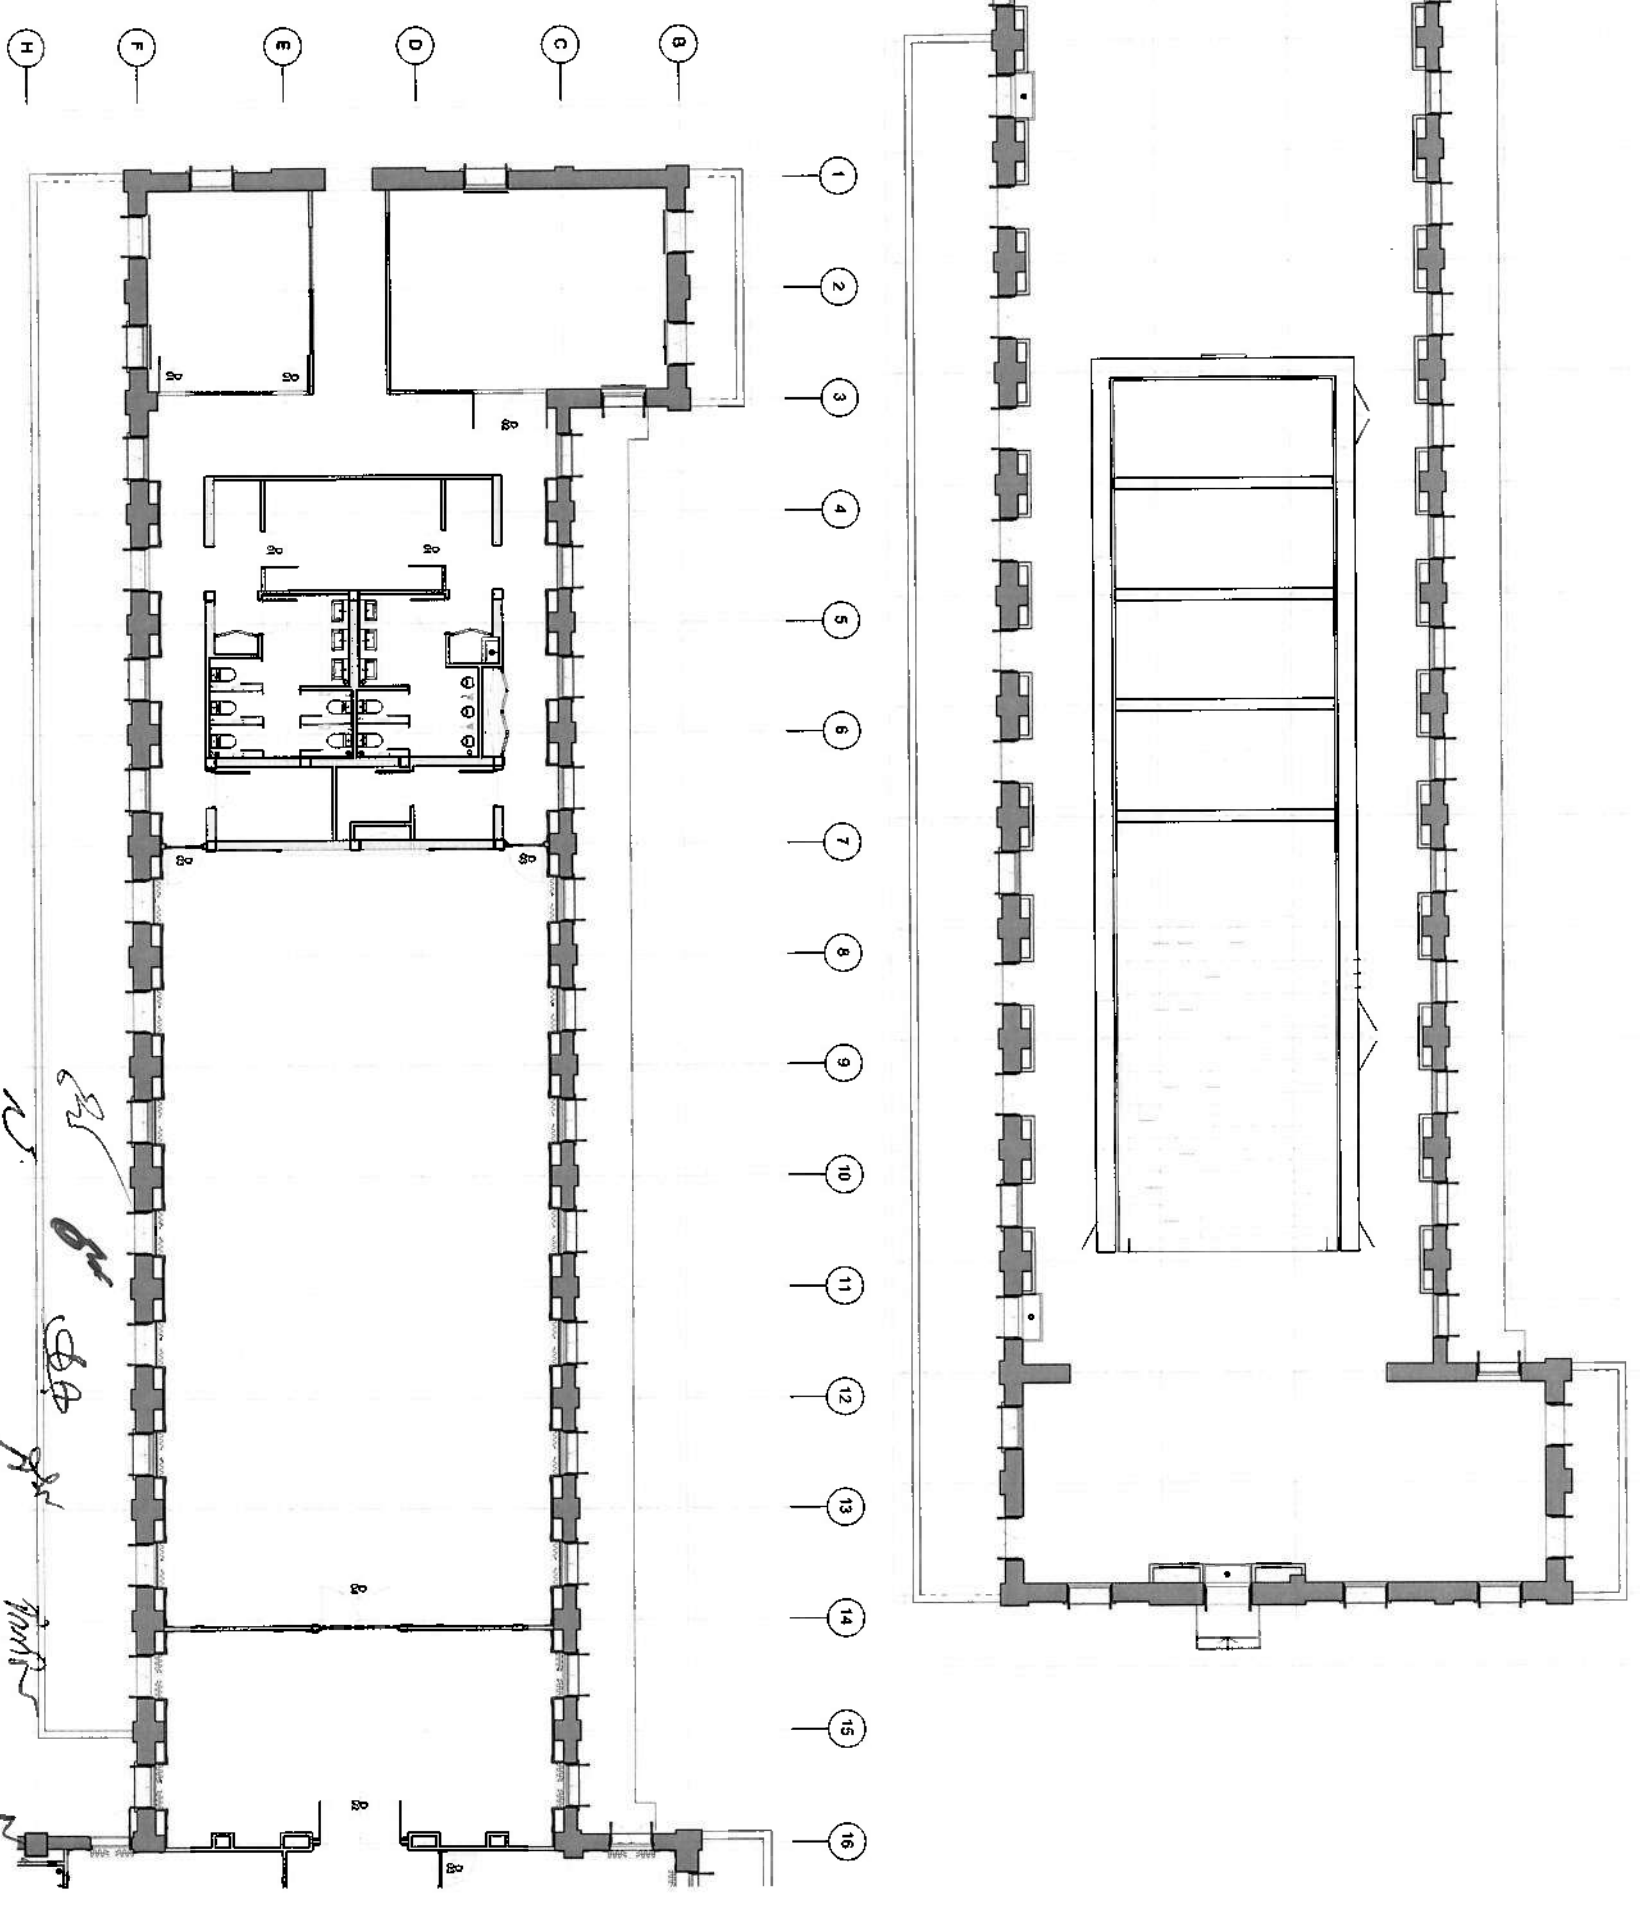


PROJECT TITLE	2nd FLOOR DOOR & WINDOW PLAN
PROJECT NO.	IN-B-00-03
DATE	
DESIGNED BY	
CHECKED BY	
NOTED BY	
DRAWN BY	

- 16
- 17
- 18
- 19
- 20
- 21
- 22
- 23
- 24
- 25
- 26
- 27
- 28
- 29
- 30
- 31
- 32
- 33
- 34
- 35
- 36
- 37
- 38

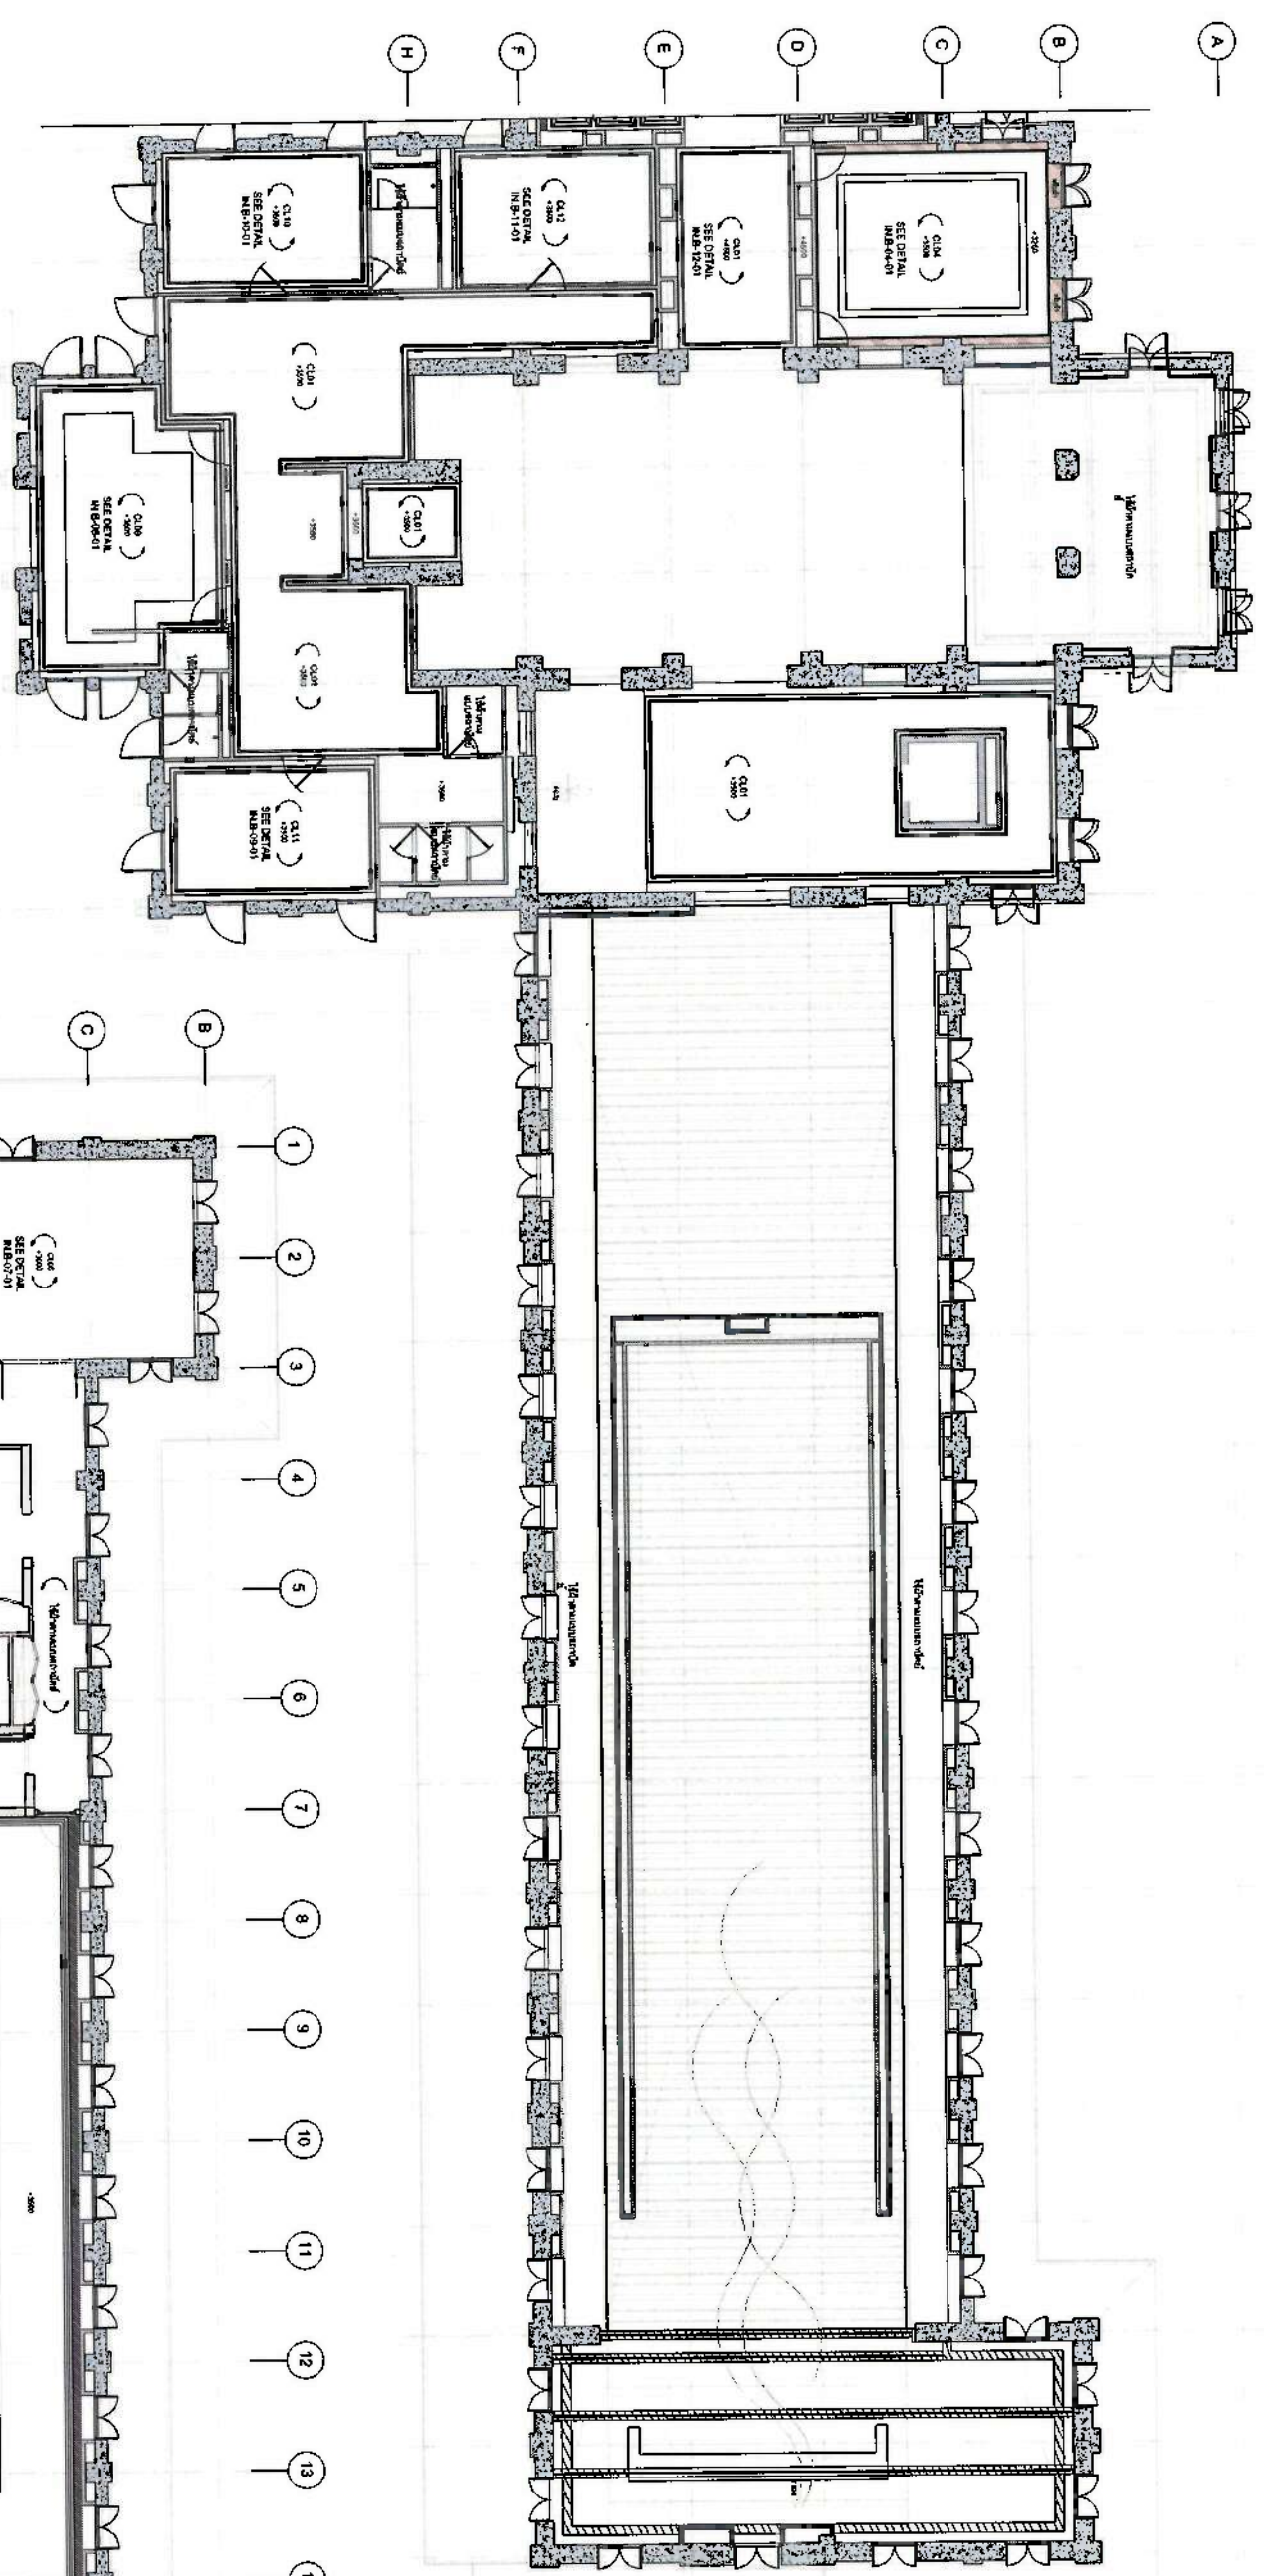


3rd FLOOR
CEILING PLAN
SCALE 1/8" = 1'-0"

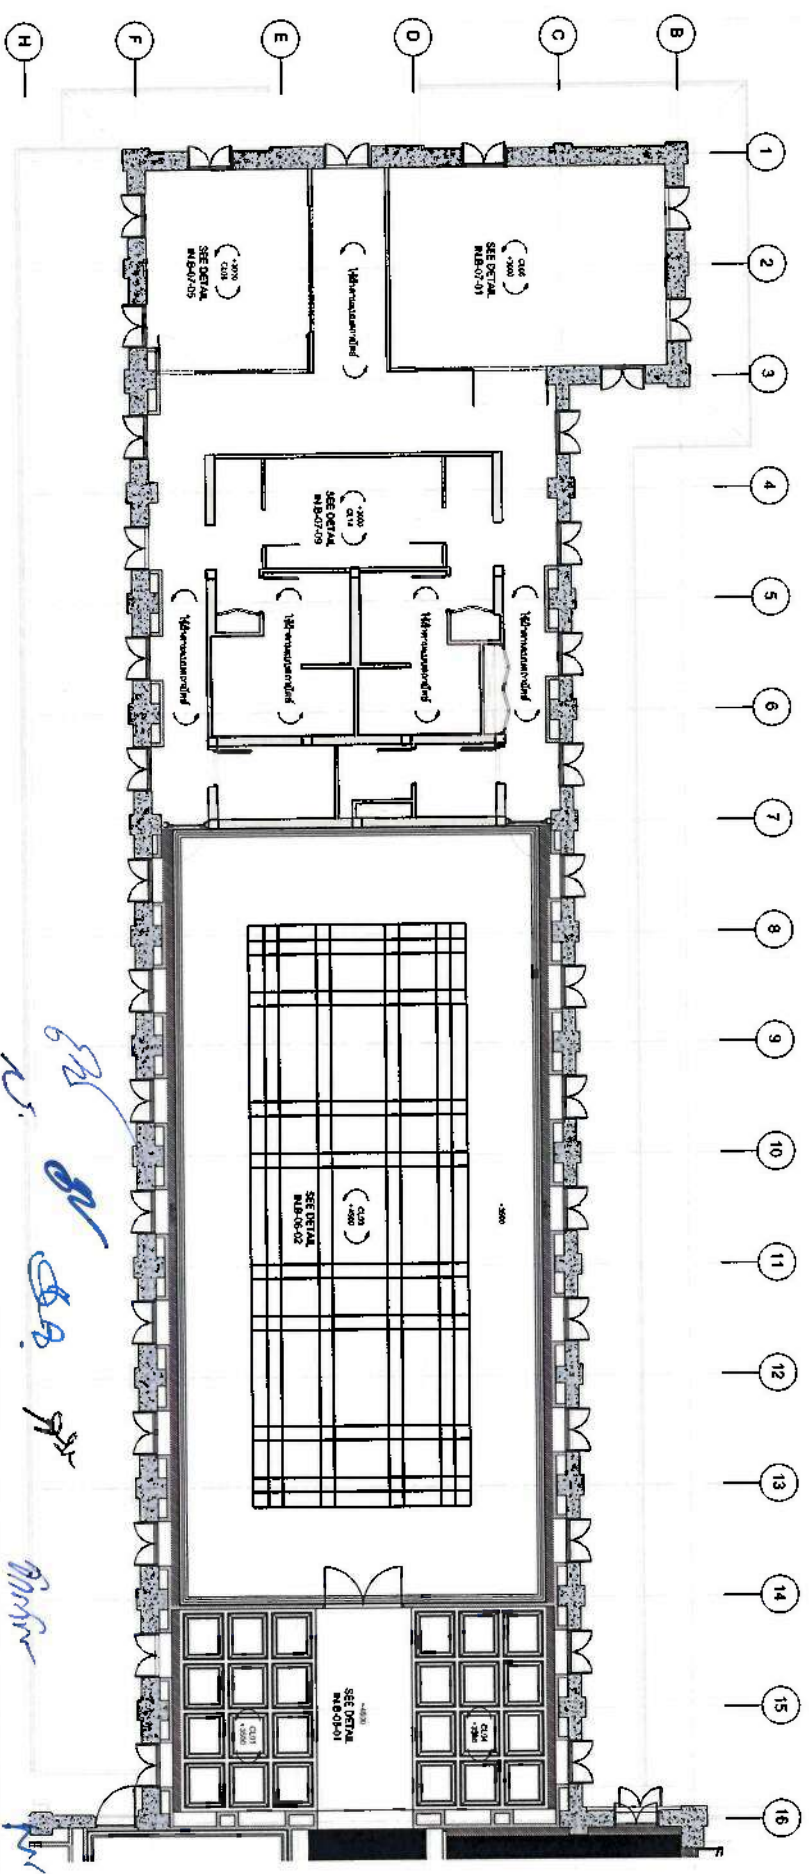

2nd FLOOR
CEILING PLAN

QIDAR QIDAR CONSULTING & DESIGN 10000 1st Avenue, Suite 100, San Diego, CA 92121 Tel: (619) 594-1000 Fax: (619) 594-1001 www.qidar.com		PROJECT NO.: DRAWING NO.: DATE:	
CLIENT: QIDAR PROJECT: QIDAR LOCATION: QIDAR DRAWN BY: QIDAR CHECKED BY: QIDAR SCALE: QIDAR DATE: QIDAR		PROJECT TITLE: 2nd FLOOR CEILING PLAN DRAWN BY: QIDAR CHECKED BY: QIDAR SCALE: QIDAR DATE: QIDAR	

16 17 18 19 20 21 22 23 24 25 26 27 28 29 30 31 32 33 34 35 36 37 38

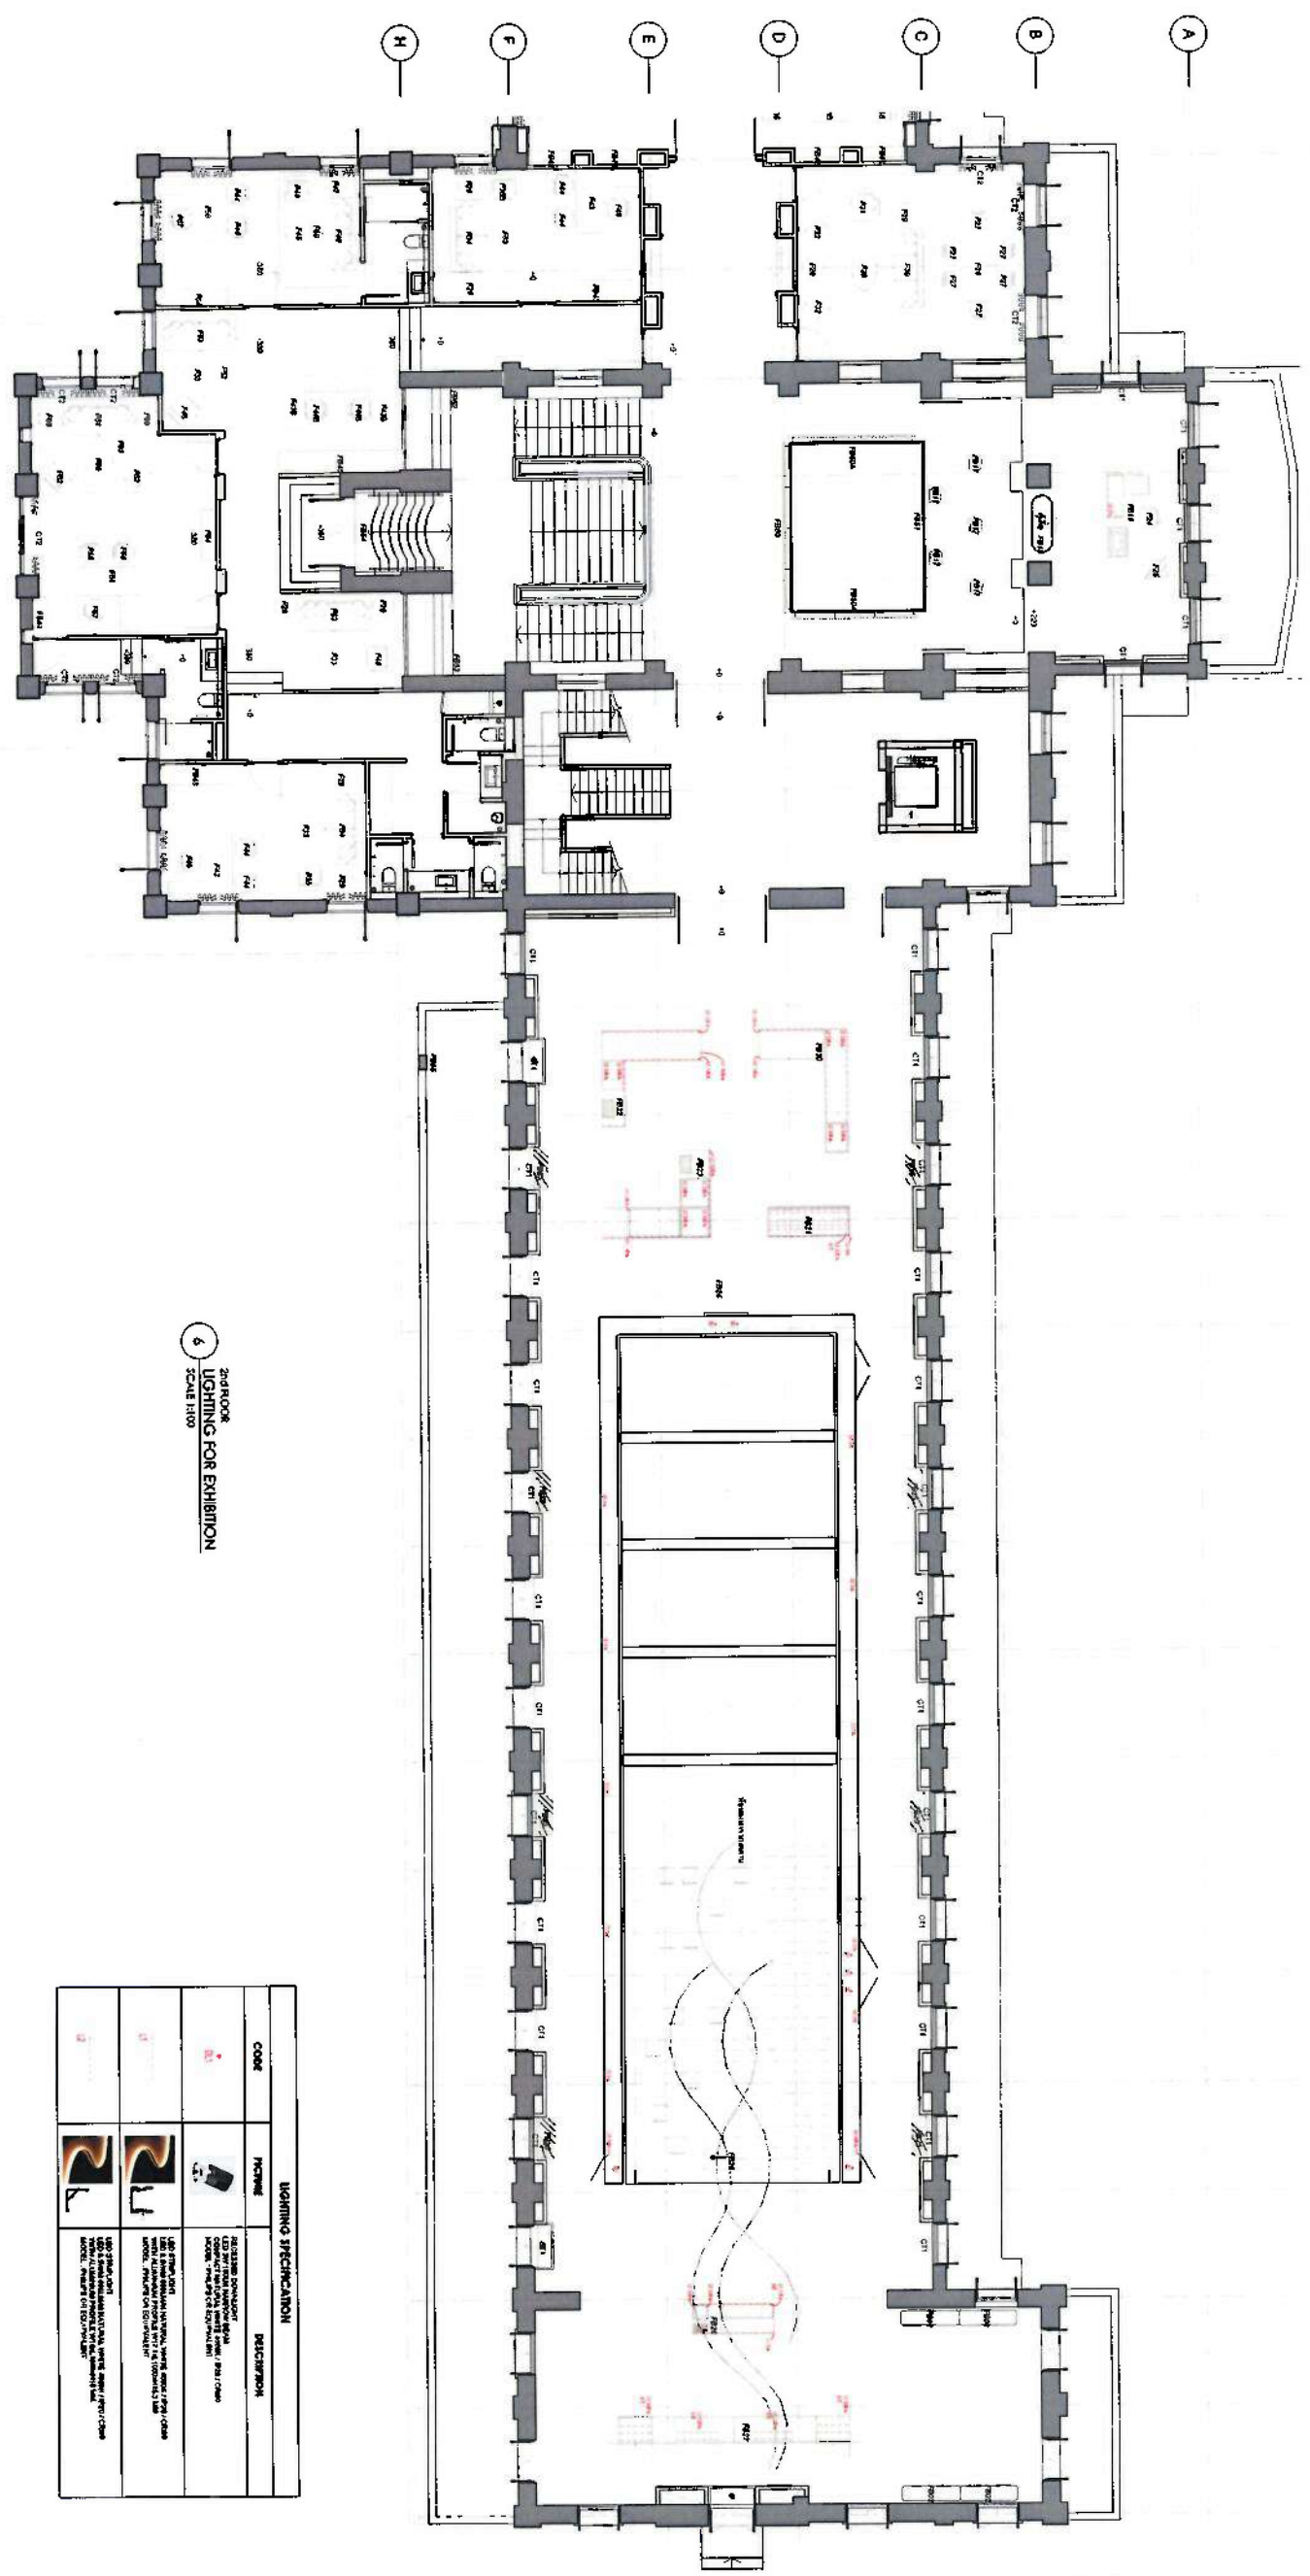


2nd FLOOR
LIGHTING FOR EXHIBITION
SCALE 1:100

CODE	NAME	DESCRIPTION
1	1	1
2	2	2
3	3	3


		PROJECT TITLE: 2nd FLOOR LIGHTING FOR EXHIBITION		DRAWING NO.: IN-B-00-05	
CLIENT: QIDAR		PROJECT NO.: 2nd FLOOR LIGHTING FOR EXHIBITION		DRAWING NO.: IN-B-00-05	
DESIGNER: QIDAR		PROJECT NO.: 2nd FLOOR LIGHTING FOR EXHIBITION		DRAWING NO.: IN-B-00-05	
DATE: 2023		PROJECT NO.: 2nd FLOOR LIGHTING FOR EXHIBITION		DRAWING NO.: IN-B-00-05	

- 16
- 17
- 18
- 19
- 20
- 21
- 22
- 23
- 24
- 25
- 26
- 27
- 28
- 29
- 30
- 31
- 32
- 33
- 34
- 35
- 36
- 37
- 38

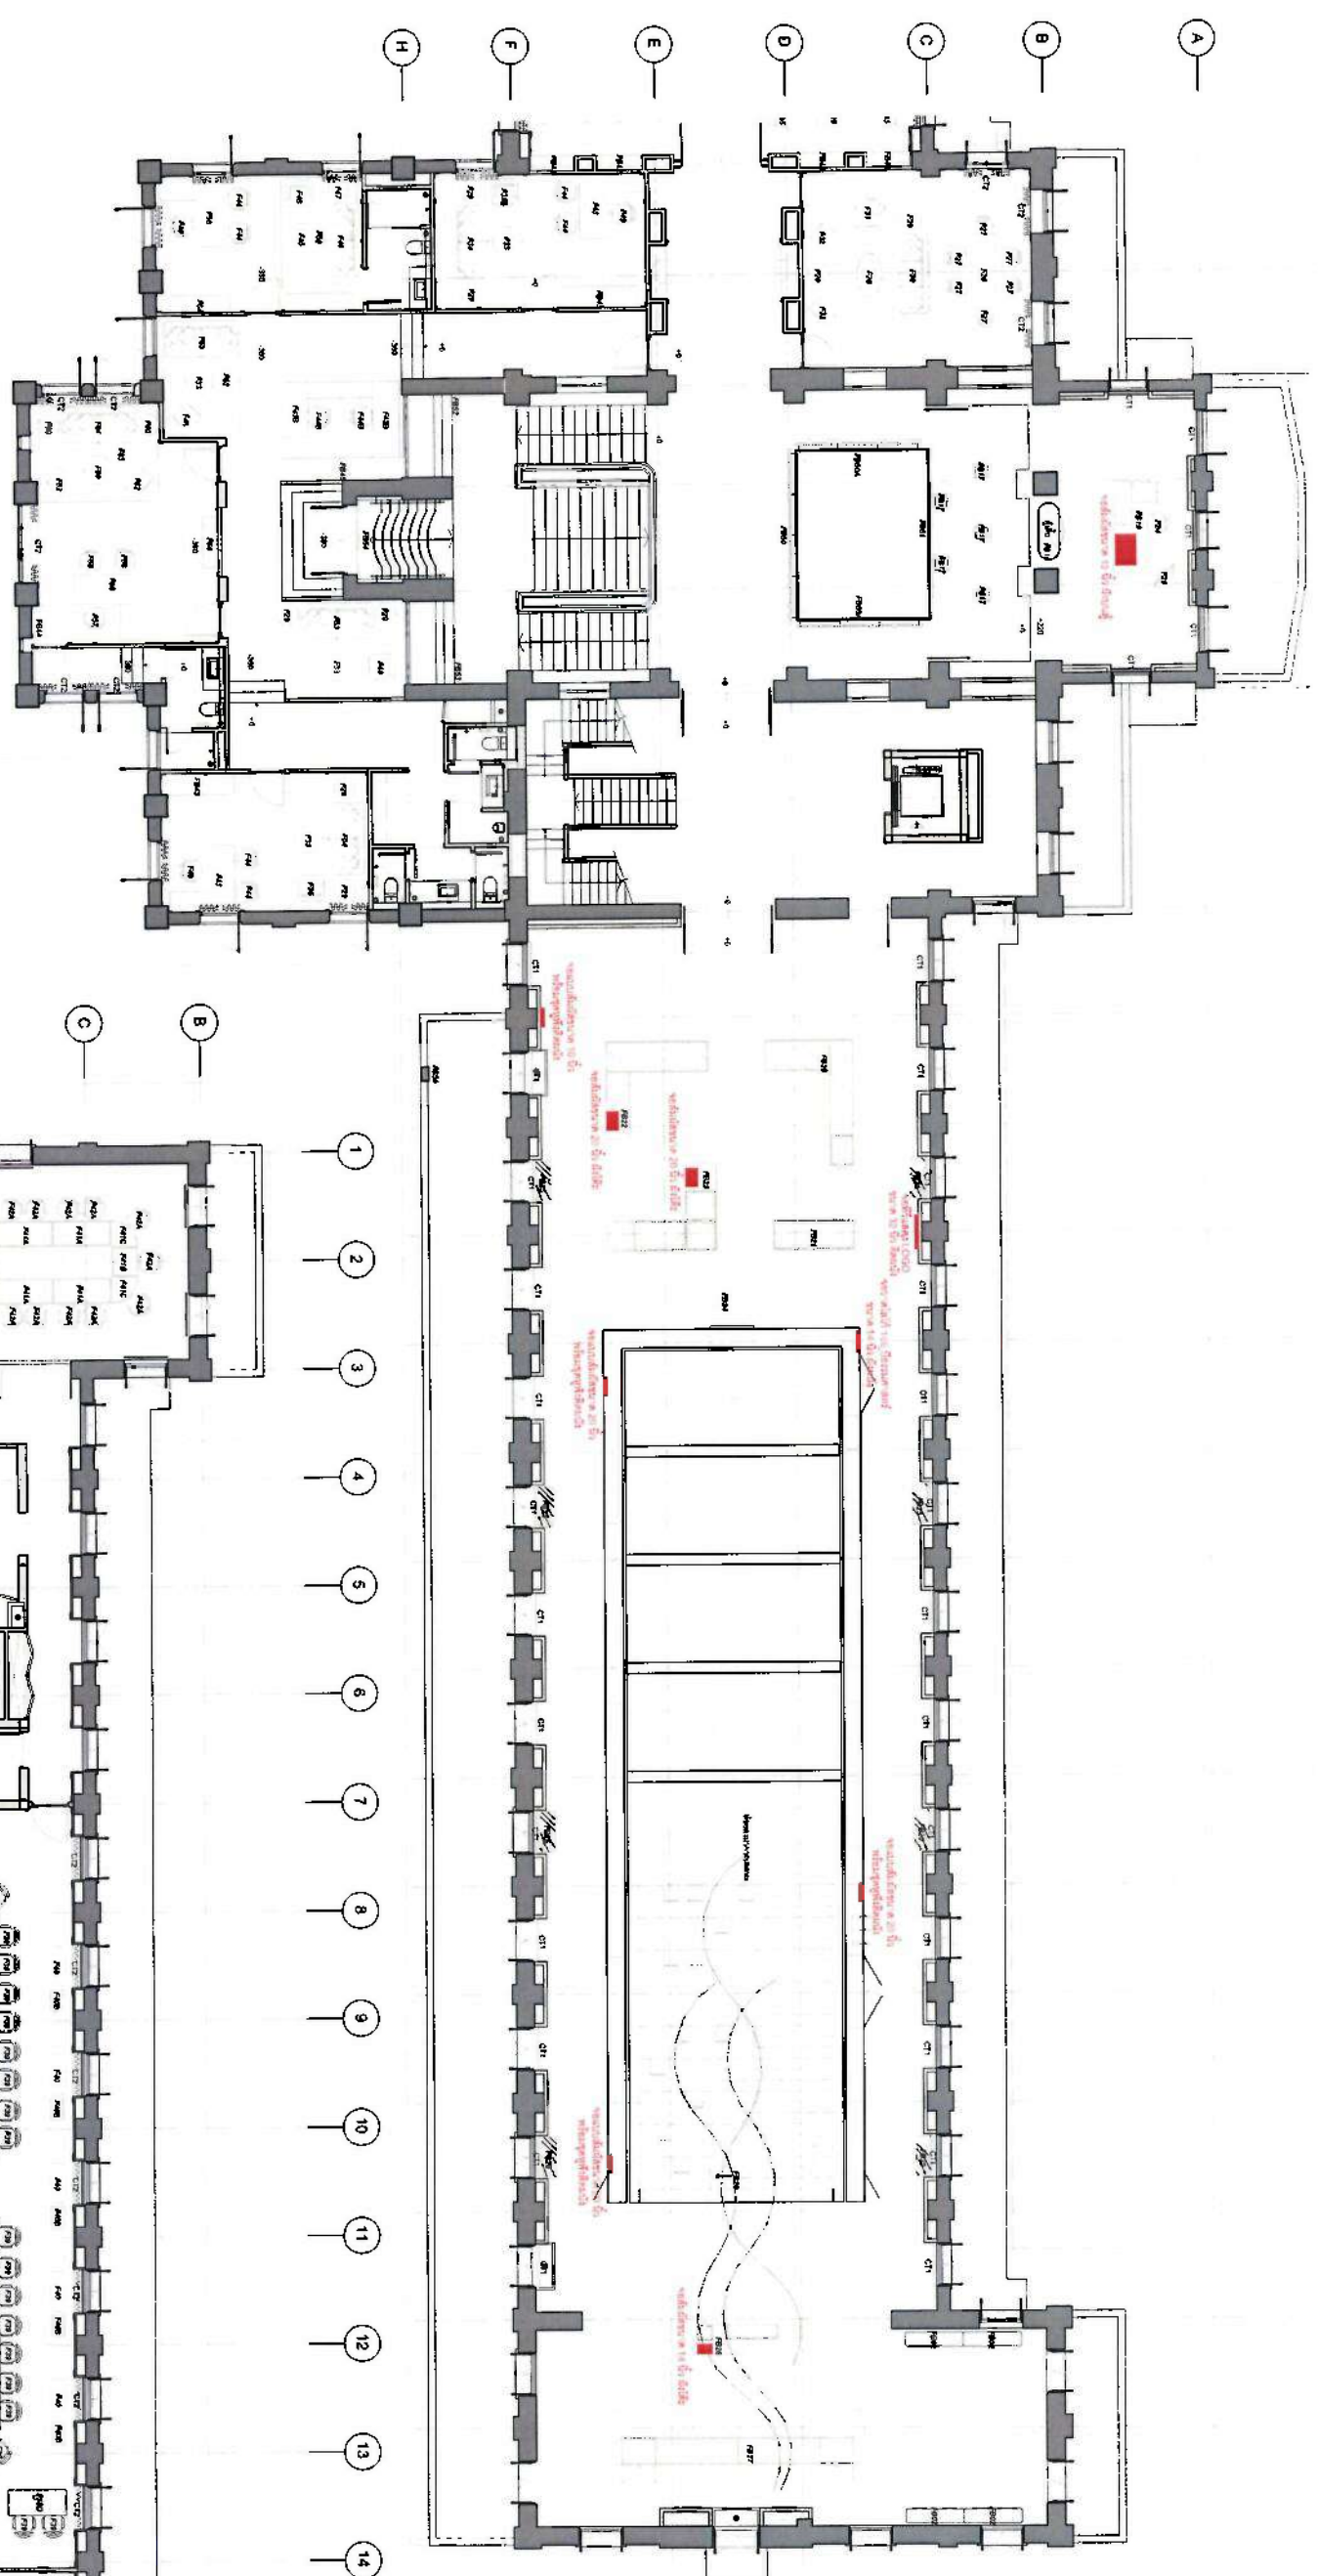


2nd FLOOR
MEDIA PLAN
SCALE: 1/80


QIDAR		PROJECT TITLE: 2nd FLOOR MEDIA PLAN	
DRAWING NO.: IN-B-00-06		CHECKED: [Signature]	
DATE: 10/10/2020		SCALE: 1/80	
DRAWN: [Signature]		DATE: 10/10/2020	
PROJECT NO.: 101010101		PROJECT NAME: 2nd FLOOR MEDIA PLAN	
PROJECT LOCATION: [Address]		PROJECT DESCRIPTION: [Description]	
PROJECT OWNER: [Owner Name]		PROJECT MANAGER: [Manager Name]	
PROJECT ARCHITECT: [Architect Name]		PROJECT ENGINEER: [Engineer Name]	
PROJECT CONSULTANT: [Consultant Name]		PROJECT CONTRACTOR: [Contractor Name]	
PROJECT SCHEDULE: [Schedule]		PROJECT BUDGET: [Budget]	
PROJECT STATUS: [Status]		PROJECT RISK: [Risk]	
PROJECT NOTES: [Notes]		PROJECT COMMENTS: [Comments]	

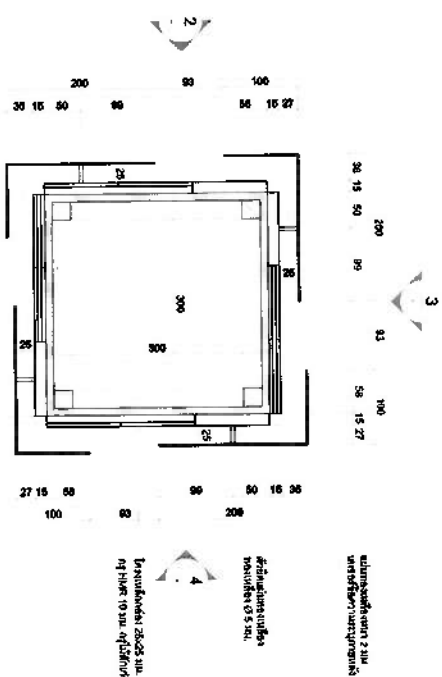

TOP VIEW
SCALE 1:5

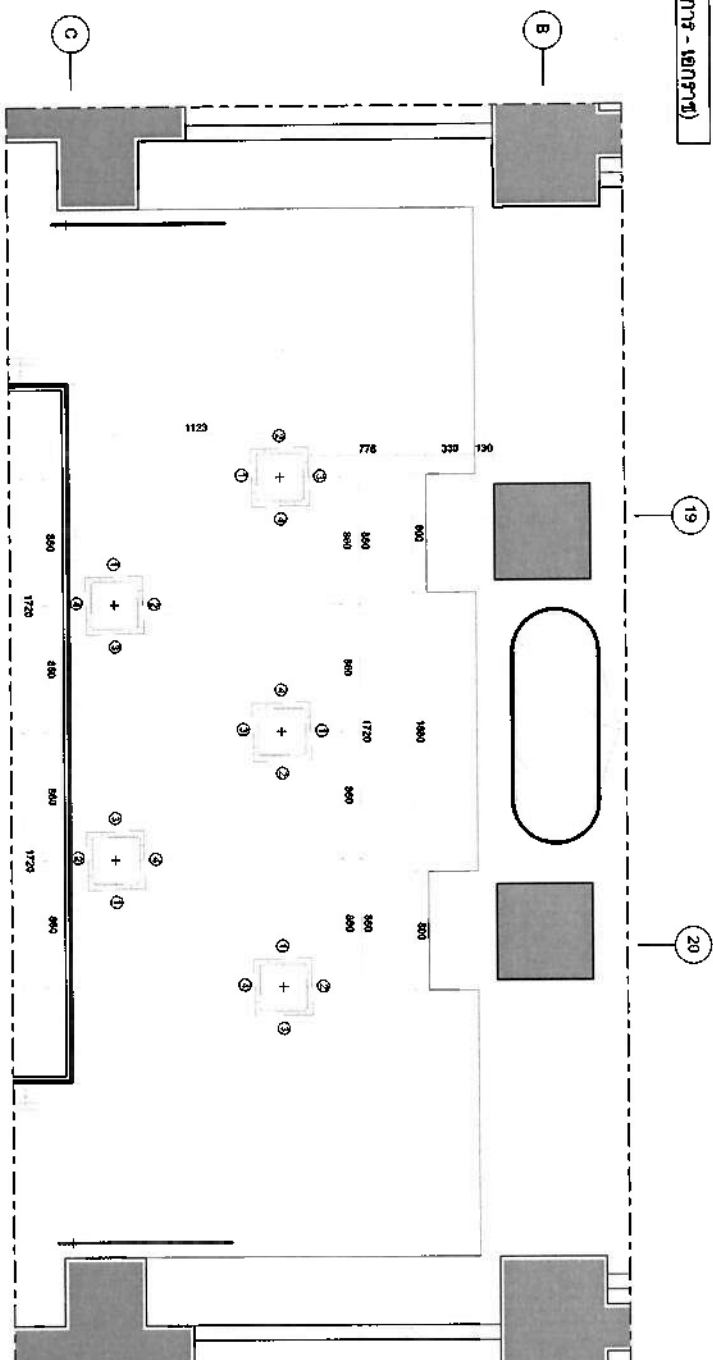

1 PLAN (B17 DETAIL)
SCALE 1/25

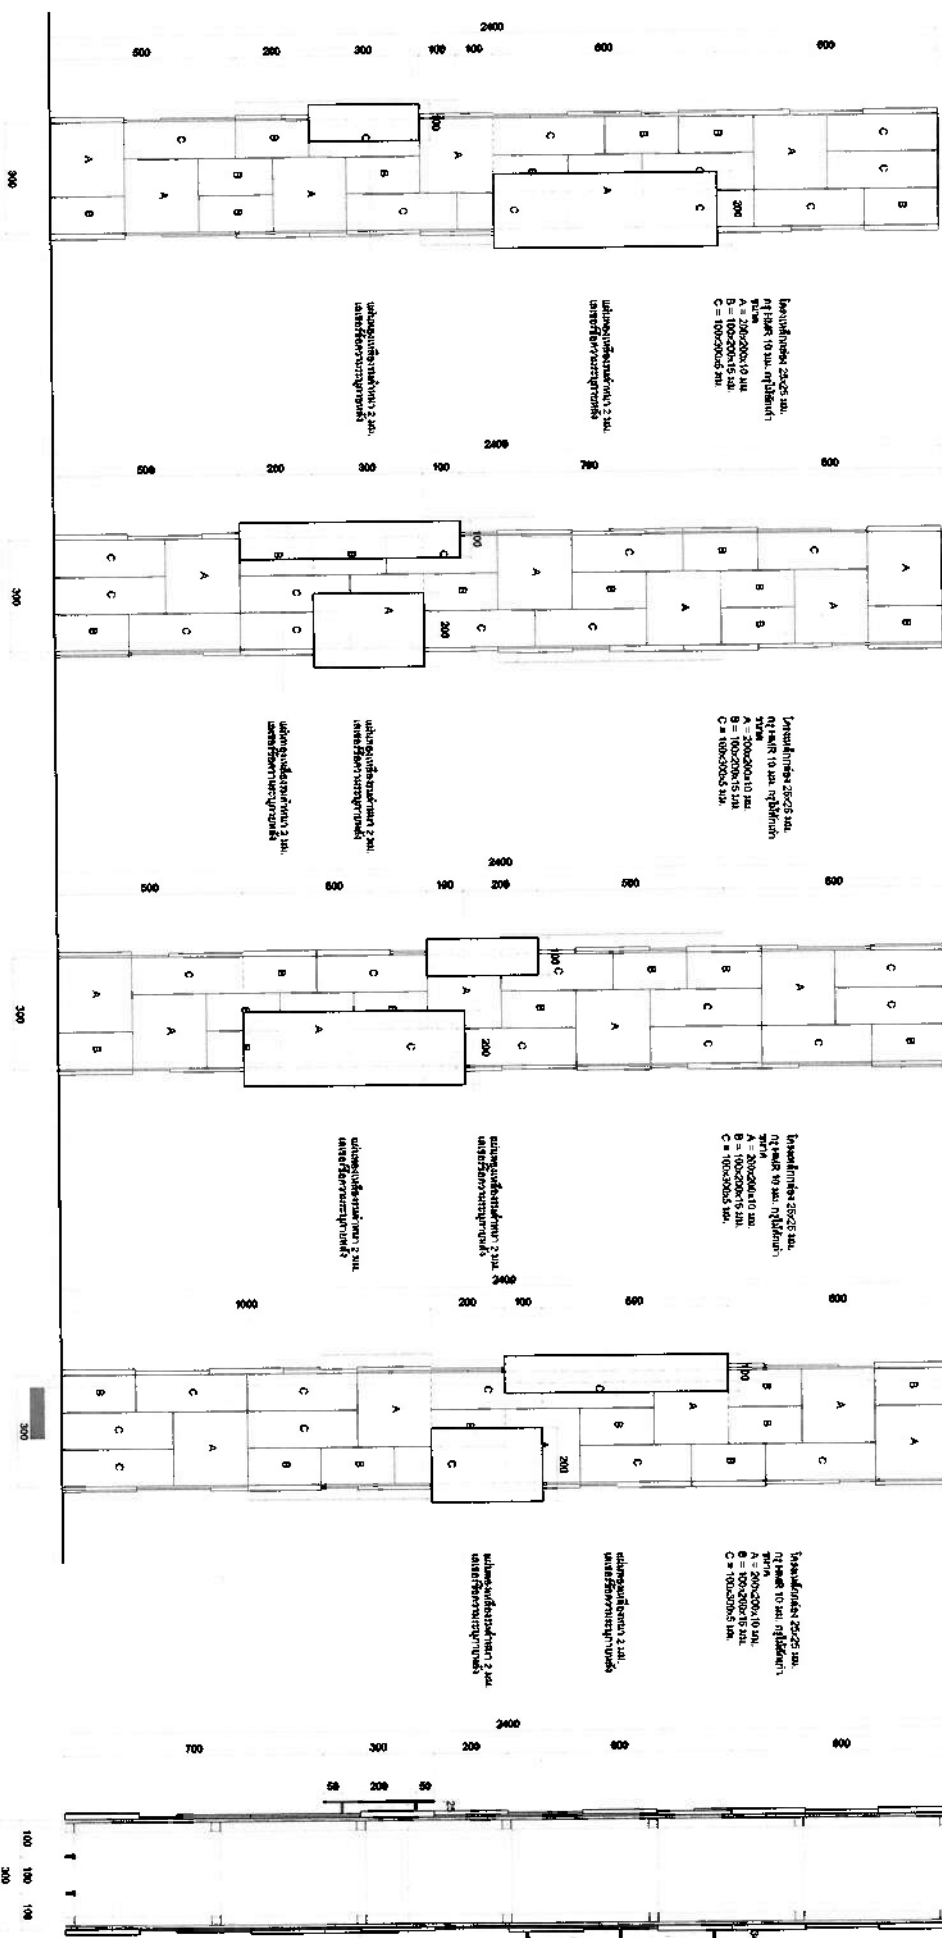


1 TOP VIEW
SCALE 1:10

2 TOP VIEW
SCALE 1:10

3
TOP VIEW
SCALE 1:10

4
TOP VIEW
SCALE 1:10

SECTION
SCALE 1:10

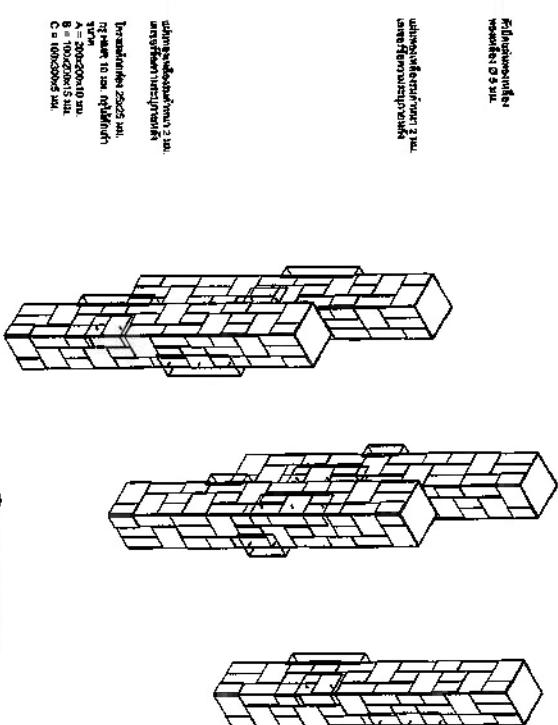

1 ISOMETRIC FB171
SCALE 1:25

QIDOR

©1997 by International Publishing Corporation
All rights reserved. No part of this publication
may be reproduced without permission in
writing from the publisher.

[illegible]


LOCATION
 10000 Highway 101, Suite 100, San Diego, CA 92108
 Phone: (619) 594-1000

Model Number: 1000
F617 DETAIL (continued) - (cont'd)


DATE: _____ DRAWN BY: _____ CHECKED BY: _____ APPROVED BY: _____	SCALE:	DRAWING NO.: IN-B-01-02
	NOTE:	
	DRAWN:	

[illegible]


FB18 DETAIL (หน้าตัด)

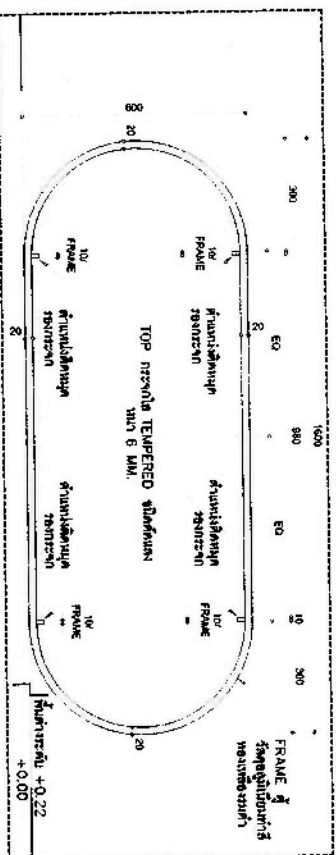

TOP VIEW (FB18 DETAIL)
SCALE 1:10

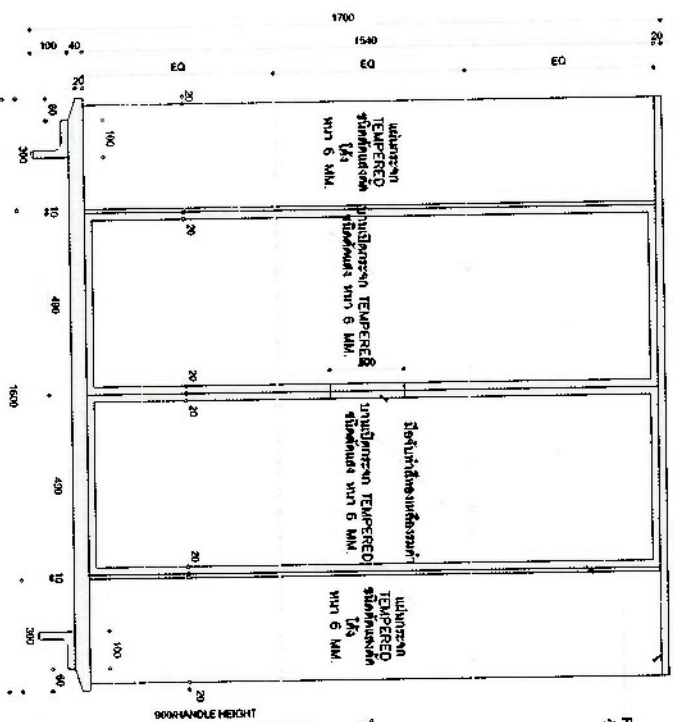


1 SIDE VIEW (FB18 DETAIL)
SCALE 1:10

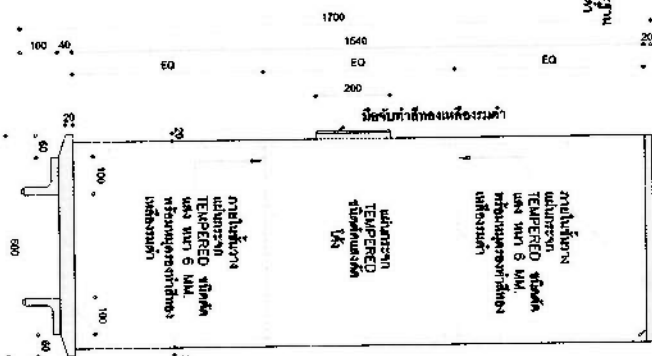


2 SIDE VIEW (FB18 DETAIL)
SCALE 1:10


FB19 DETAIL (หน้าตัด)

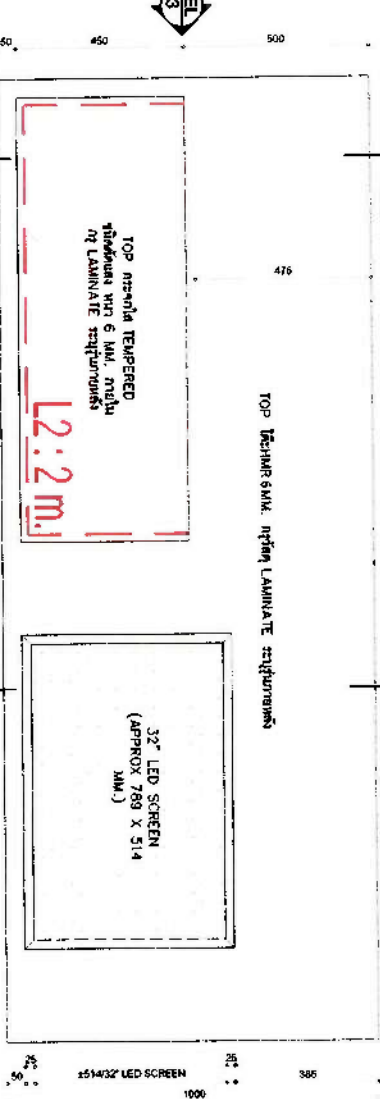


TOP VIEW (FB19 DETAIL)
SCALE 1:10

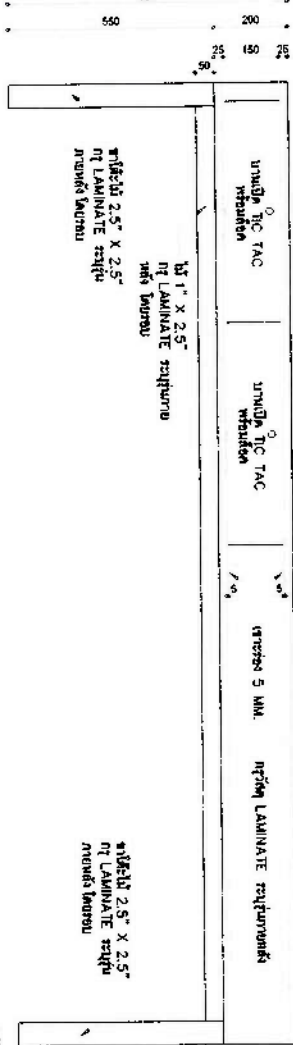


1 SIDE VIEW (FB19 DETAIL)
SCALE 1:10

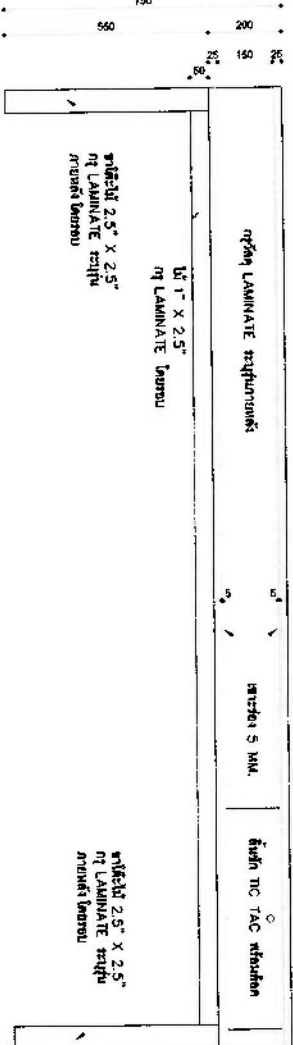

2 SIDE VIEW (FB19 DETAIL)
SCALE 1:10

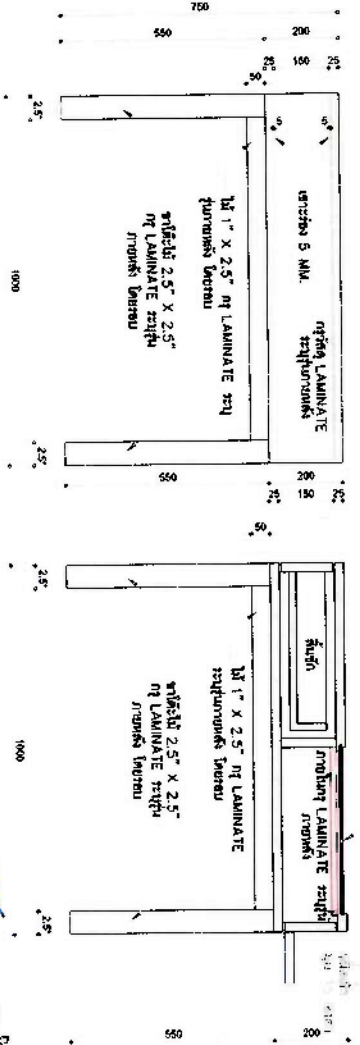


3.4 SIDE VIEW (FB19 DETAIL)
SCALE 1:10

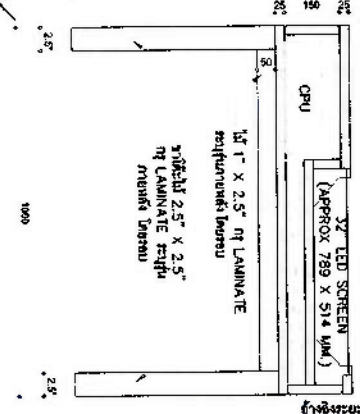


SECTION
SCALE 1:10

		PROJECT TITLE: FB18 DETAIL (หน้าตัด) DRAWING NO.: IN-B-01-03	
DESIGNER: สมชาย ใจดี CHECKED: สมชาย ใจดี DATE: 10/10/2563	PROJECT NO.: FB18 DETAIL (หน้าตัด) DRAWING NO.: IN-B-01-03	PROJECT TITLE: FB19 DETAIL (หน้าตัด) DRAWING NO.: IN-B-01-03	PROJECT NO.: FB19 DETAIL (หน้าตัด) DRAWING NO.: IN-B-01-03



FB50 DETAIL (จากทั้งหมด ๔ รายการ)

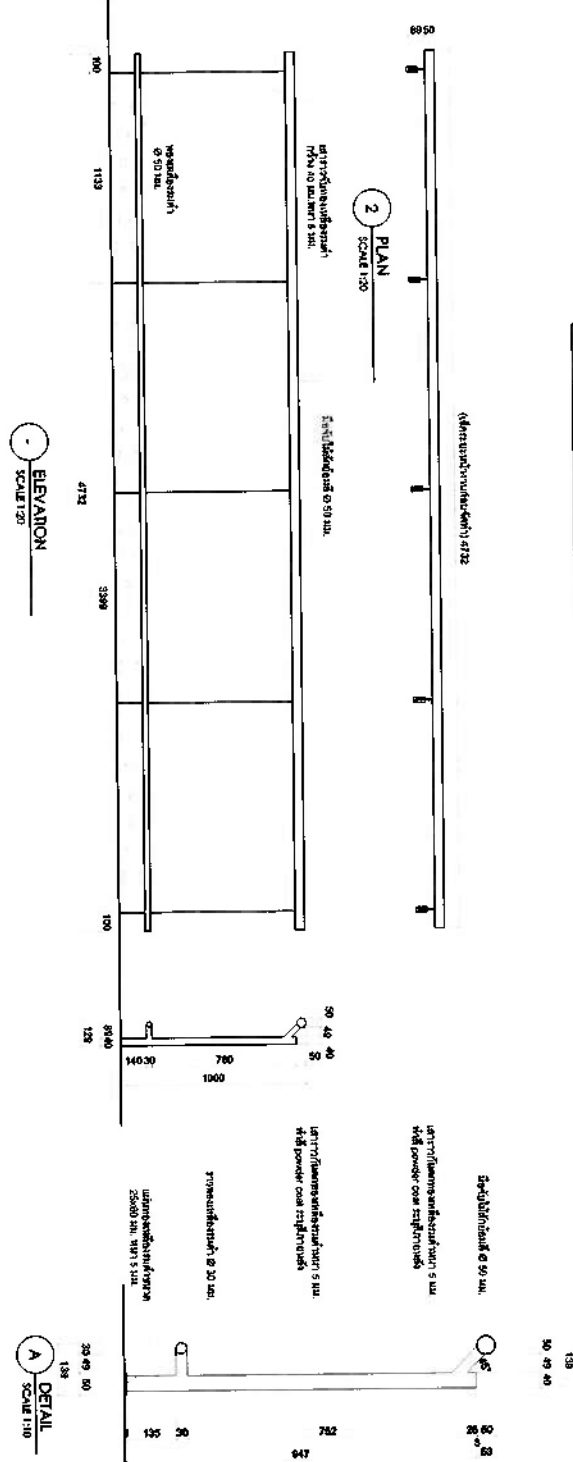


FB50A DETAIL (จากทั้งหมด ๔ รายการ)


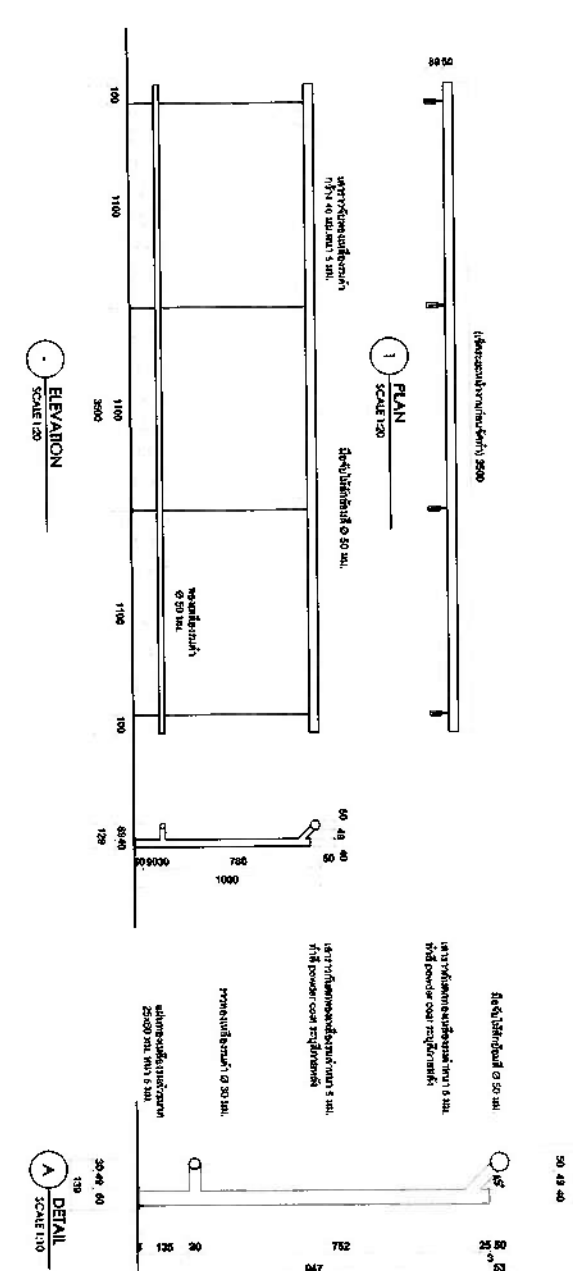


FB61 DETAIL (ทั้งหมด ๑ รายการ)

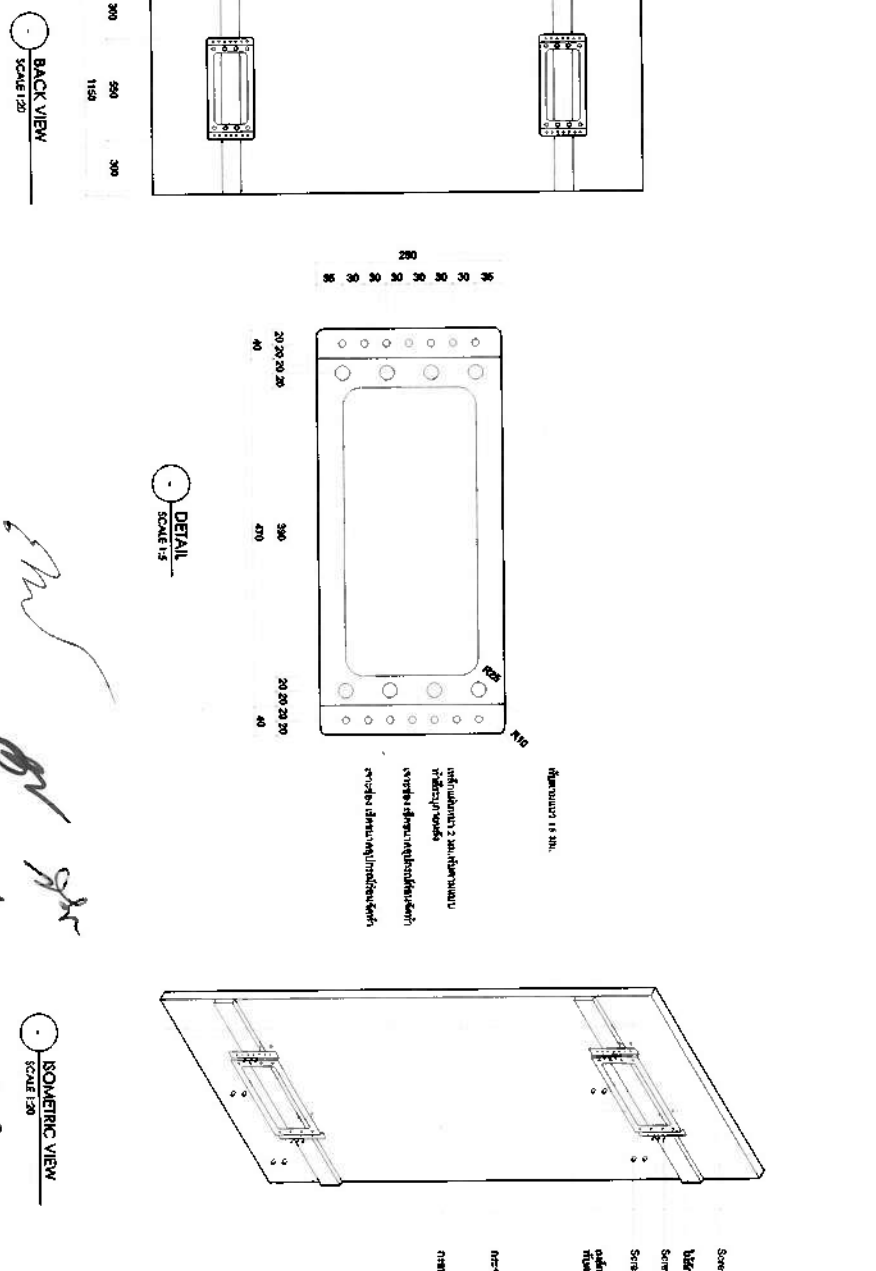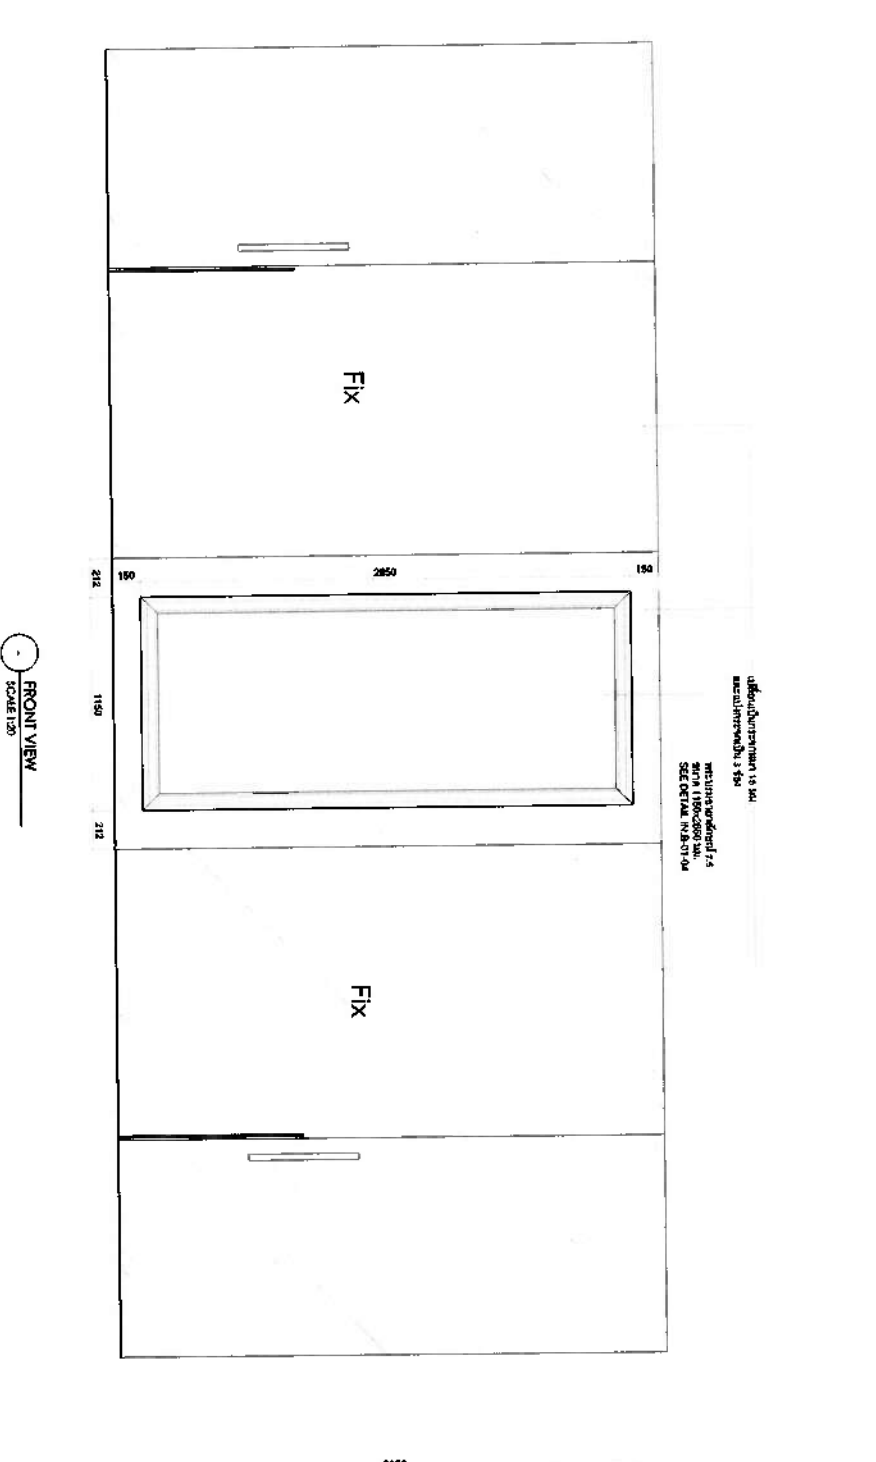


		PROJECT TITLE: FB61 DETAIL (ทั้งหมด ๑ รายการ) DRAWING NO.: IN-B-01-04	
DESIGNER: <i>[Signature]</i> CHECKED: <i>[Signature]</i> DATE: 11/01/2564	PROJECT NO.: <i>[Signature]</i> SCALE: 1:20 DRAWN: <i>[Signature]</i>	PROJECT NO.: <i>[Signature]</i> SCALE: 1:20 DRAWN: <i>[Signature]</i>	PROJECT NO.: <i>[Signature]</i> SCALE: 1:20 DRAWN: <i>[Signature]</i>

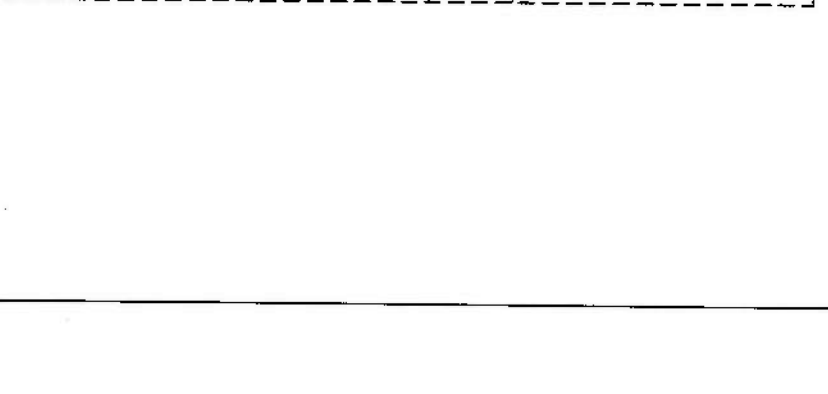


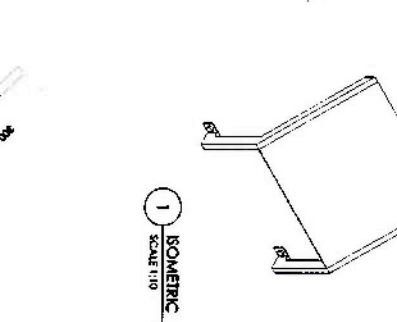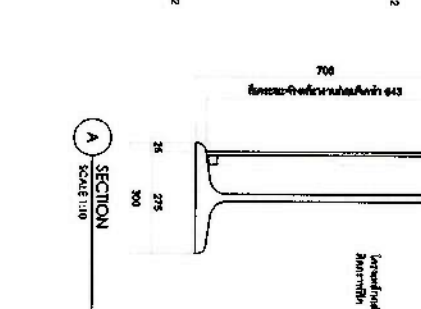


5

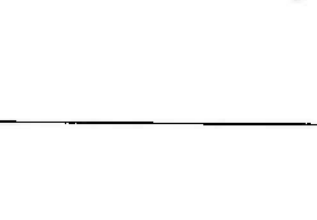

FB24 DETAIL (ທີ່ນັດສະໜອງ)

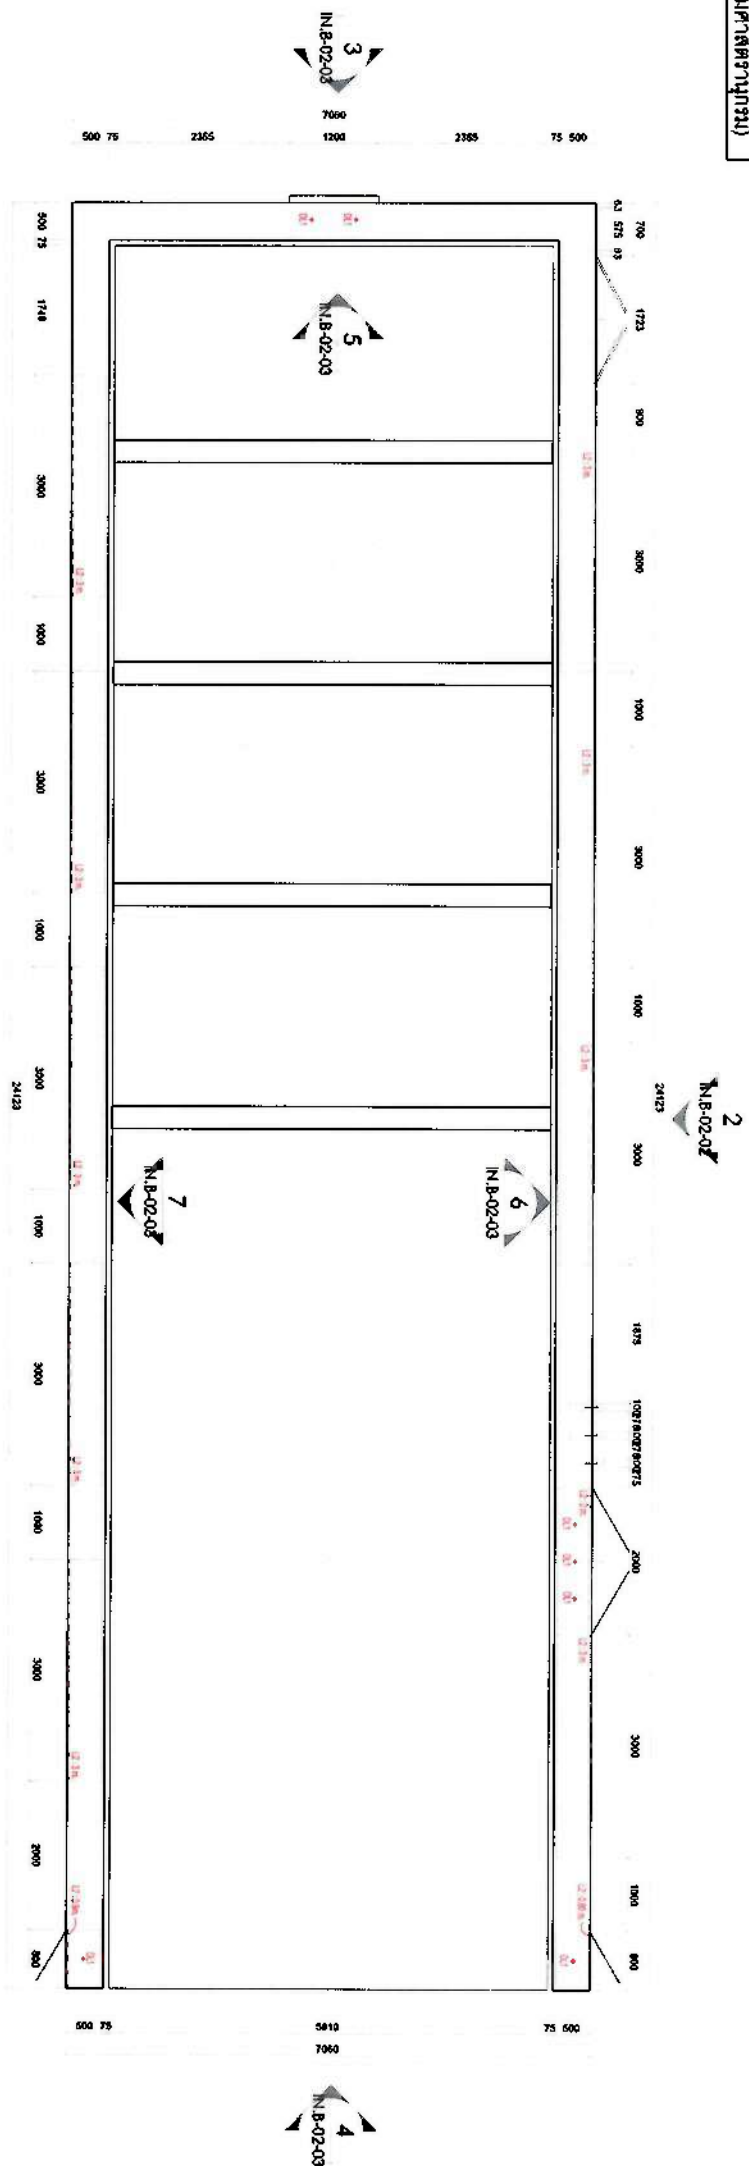

1 TOP VIEW (FB24 DETAIL)
SCALE 1:50

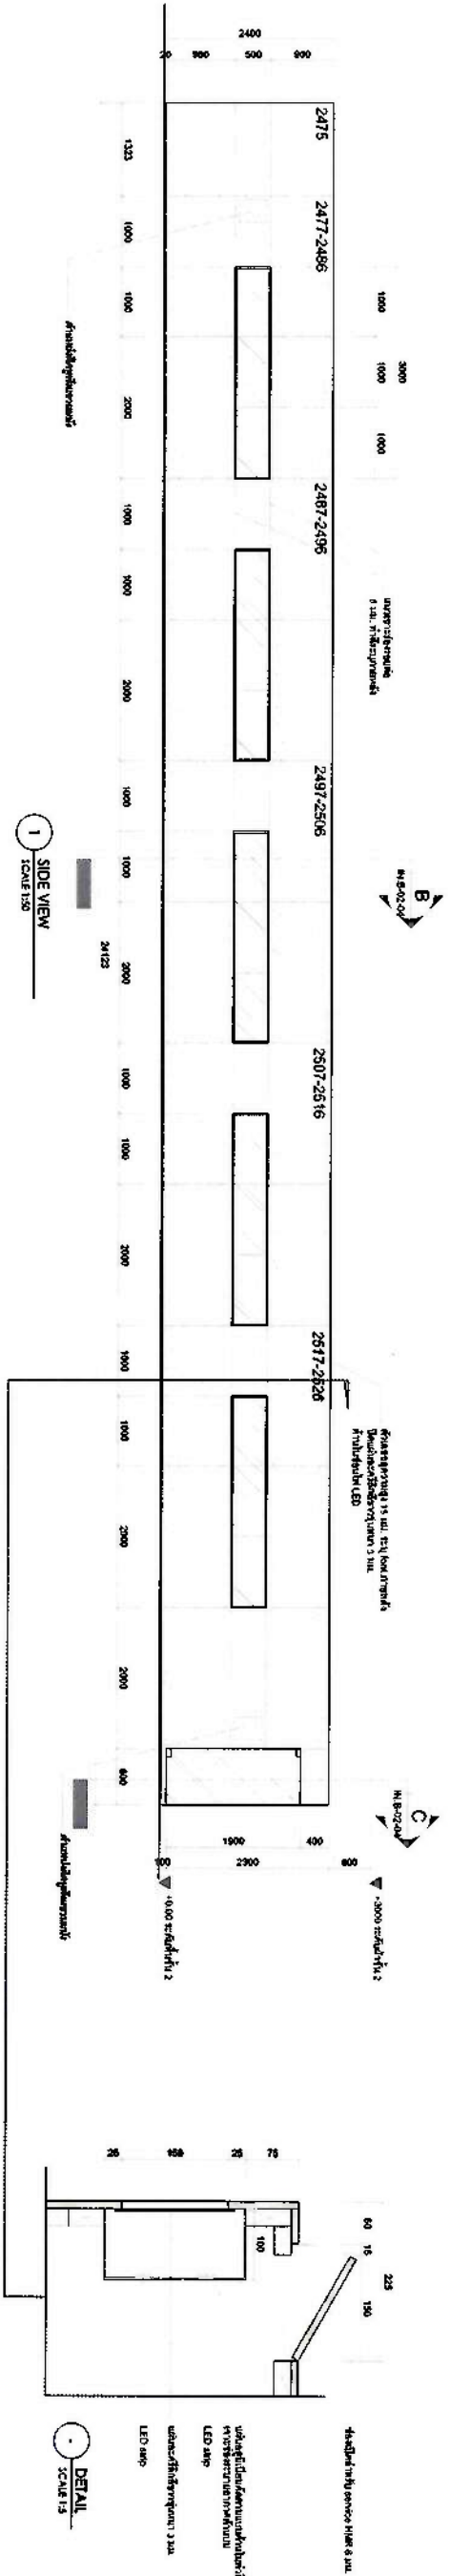


DETAIL
SCALE 1:5

2 SIDE VIEW
SCALE 1:50


QIDNR	
PROJ. NO. : FB24 DETAIL (ທີ່ນັດສະໜອງ)	DATE : 2024-02-02
DESIGNER : [Signature]	CHECKED : [Signature]
DRAWN : [Signature]	DATE : 2024-02-02

2400
900
900

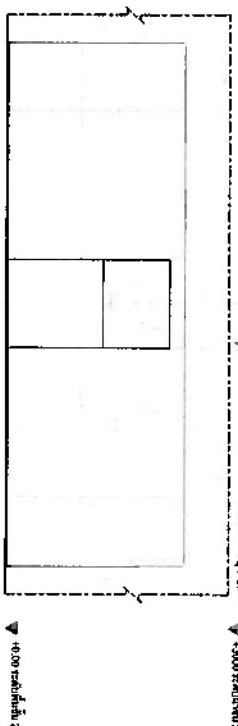


3 SIDE VIEW
SCALE 1:50

2400
2000
400

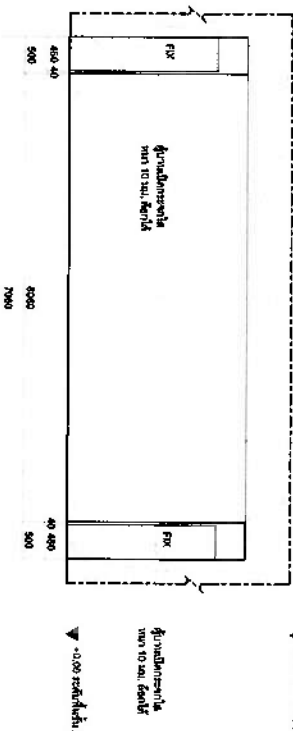


4 SIDE VIEW
SCALE 1:50

2400
2000
400

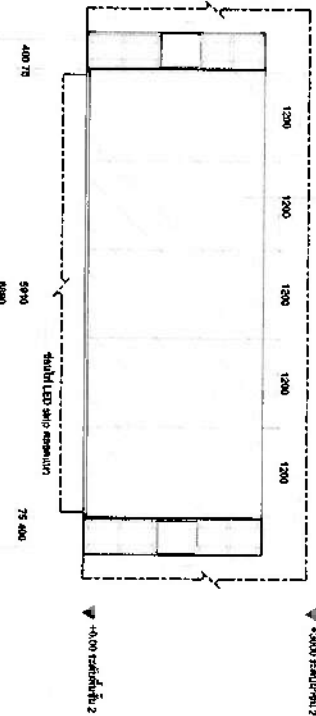


5 SIDE VIEW
SCALE 1:50

2400
900
900

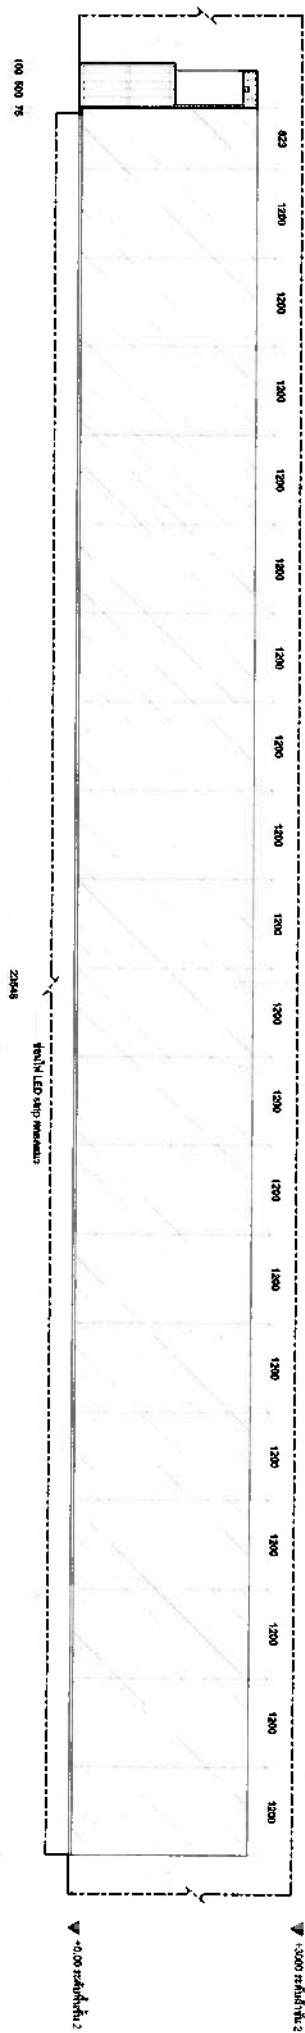

6 SIDE VIEW
SCALE 1:50

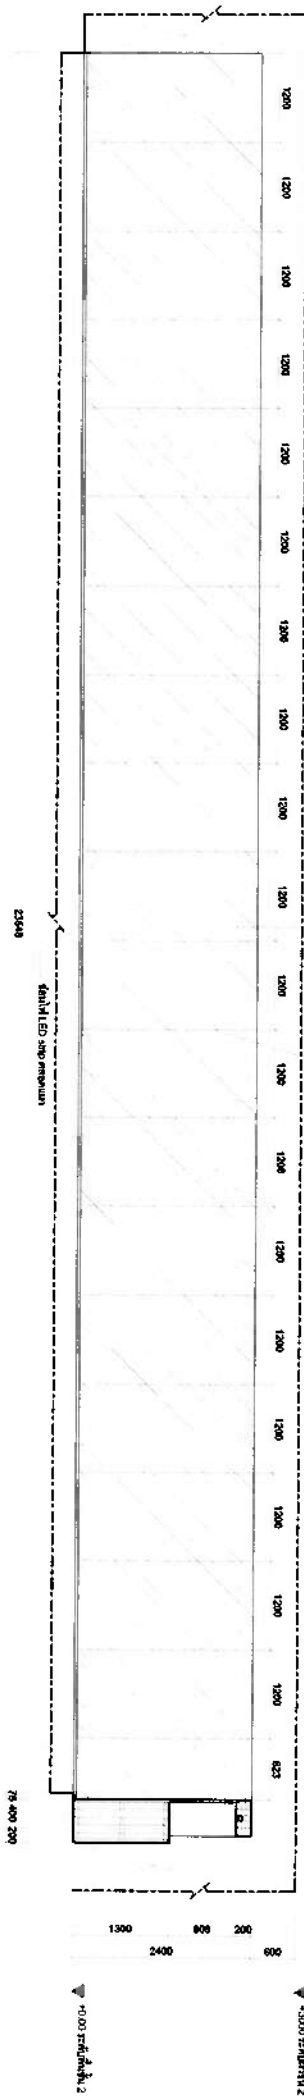

7 SIDE VIEW
SCALE 1:50

2400
900
900

2000 1200 2000 500

2400
2000
400

2000 1200 2000 500

2400
2000
400



2000 1200 2000 500

QIDAR

PROJECT TITLE:	PROJECT NO.:
PROJECT LOCATION:	PROJECT NO.:
PROJECT NO.:	PROJECT NO.:

PROJECT TITLE:	PROJECT NO.:
PROJECT LOCATION:	PROJECT NO.:
PROJECT NO.:	PROJECT NO.:

Handwritten notes and signatures in the bottom right corner.

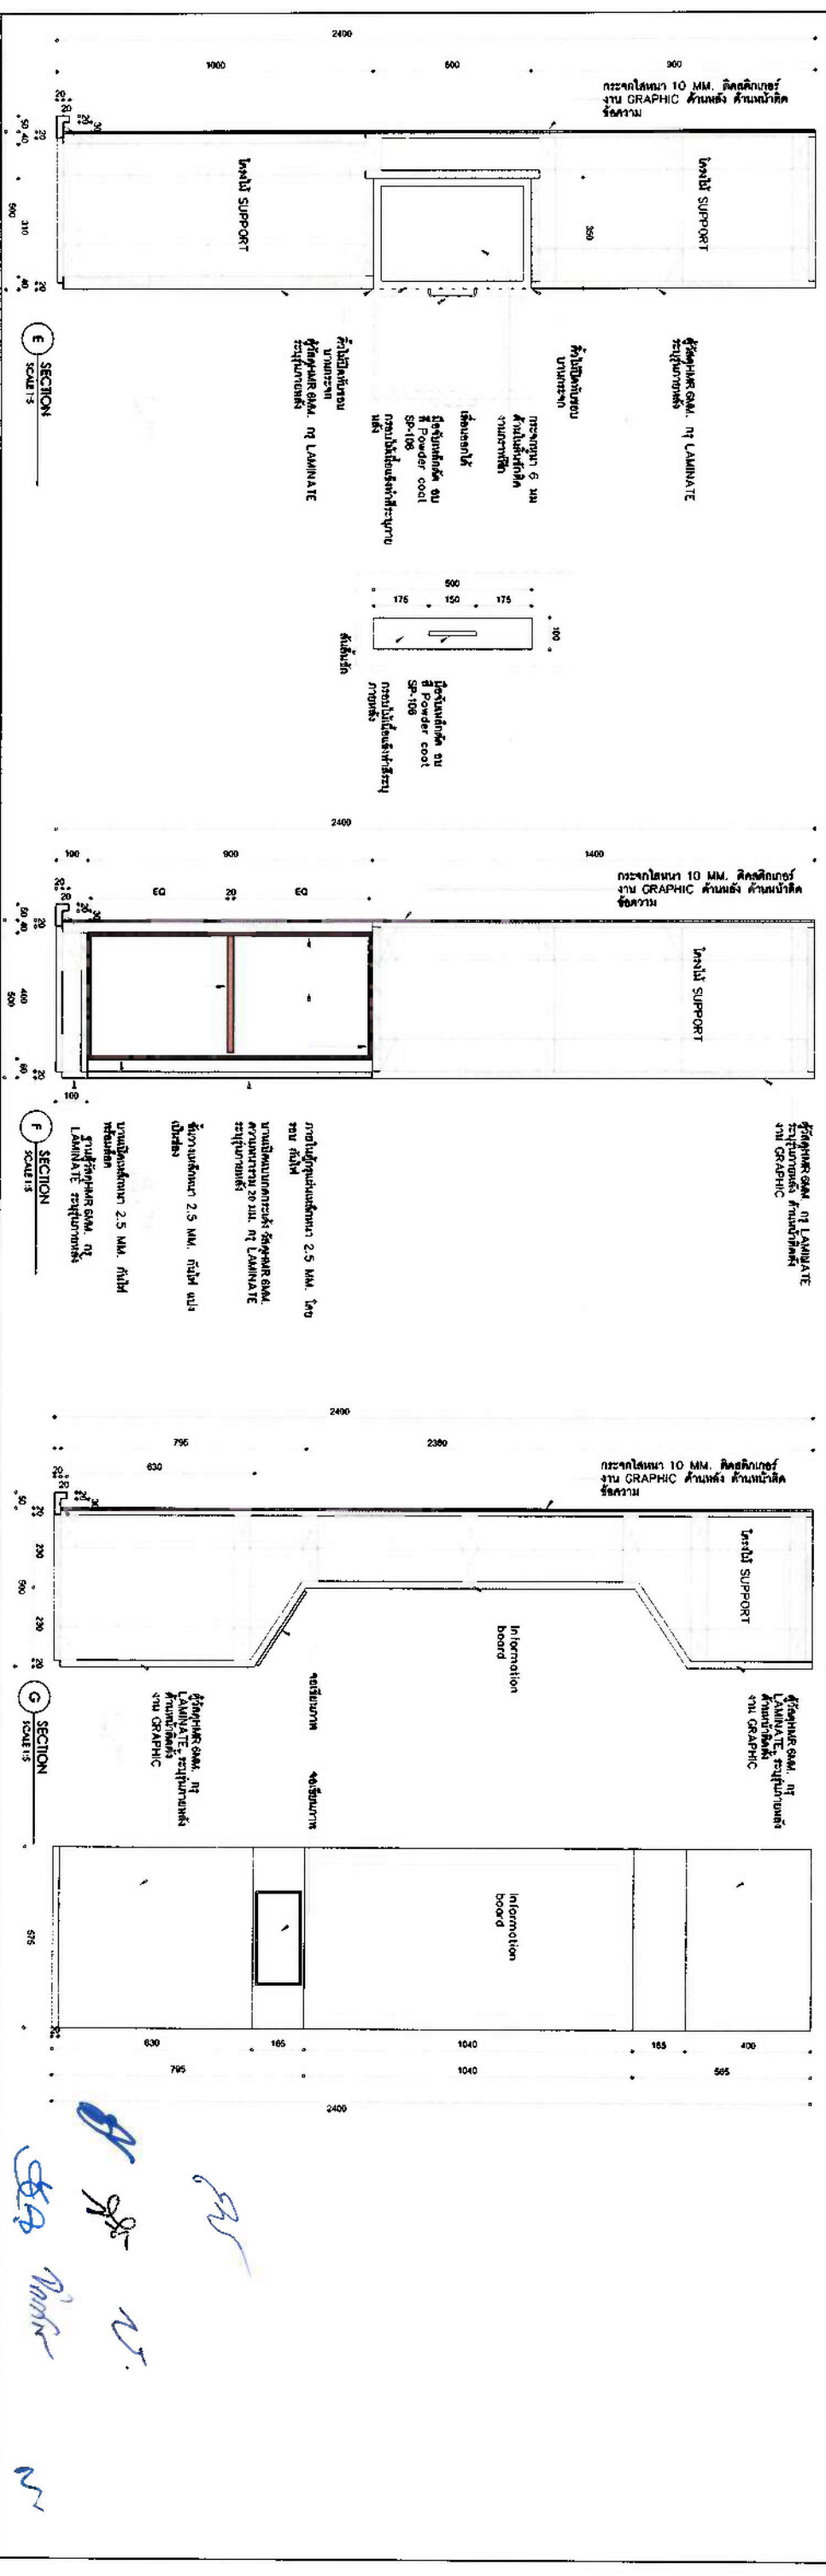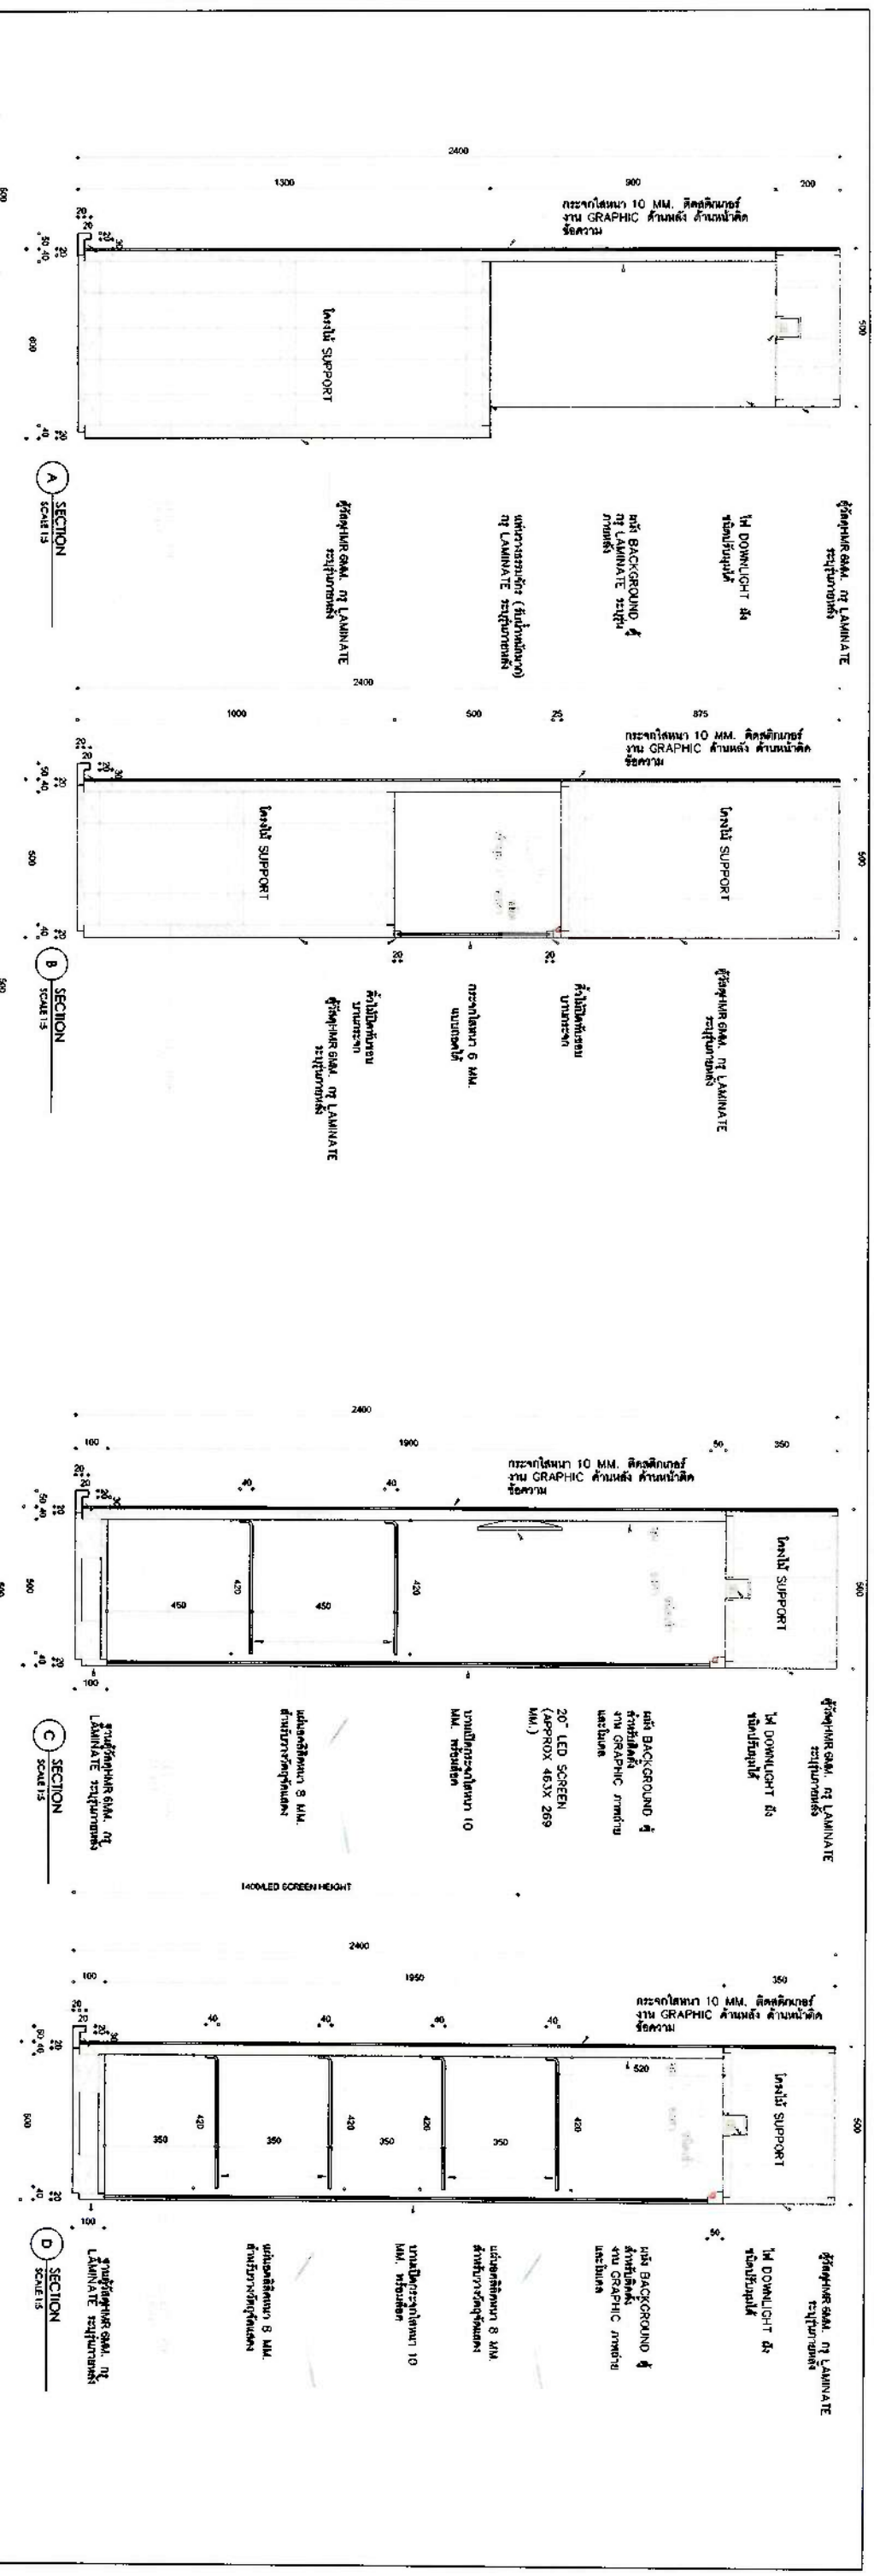

QIDR	
PROJECT TITLE: ตู้โชว์สินค้า	
DRAWING TITLE: ตู้โชว์สินค้า (หน้าและหลัง)	
REVISION:	
JOB NO.:	
CREATED:	
DRAWING NO.:	
IN-B-02-04	

[illegible]

Architectural drawings of the FB21 Detail. The top drawing is a plan view showing a rectangular structure with dimensions L1: 2.20 m and L2: 6 m. It includes a section line 'SEC A' and a north arrow. The bottom drawing is a side view showing the profile of the structure with a height of 2.20 m. It includes a section line 'SEC B' and a north arrow. Both drawings are labeled 'FB21 DETAIL (3/3/2018)'.

[illegible][illegible]

The architectural drawings include a top view (Fig. 22 Detail) and three side elevations (1, 2, and 3). The top view shows a rectangular building footprint with dimensions and section lines. The side elevations show the building's profile with heights and section lines. The drawings are labeled with 'SECTION 5 MAX' and 'FINISHED GRADE OF LAMINATE REQUIREMENT'.

TOP VIEW (FIG. 22 DETAIL)

SECTION 5 MAX
FINISHED GRADE OF LAMINATE REQUIREMENT

1 SIDE VIEW
SCALE 1/25

2 ELEVATION
SCALE 1/25

3 SIDE VIEW
SCALE 1/25

4 SIDE VIEW
SCALE 1/25

FB22 DETAIL (Dimensions)

The image displays architectural drawings of a bench, consisting of a plan view and three side views.

PLAN (B25 DETAIL)

The plan view shows the top-down layout of the bench. It is divided into two main sections: a rectangular section on the left and a section with horizontal slats on the right. The overall width is 500 units. The slatted section is 550 units wide. The drawing includes a north arrow pointing upwards, a scale bar for 1:500, and a north arrow pointing downwards. The drawing is labeled "PLAN (B25 DETAIL)" and "SCALE 1:50".

SIDE VIEW 1

The first side view shows the profile of the bench. It features a curved backrest and a seat. The backrest is 240 units high. The seat is 160 units high. The overall width is 500 units. The drawing is labeled "SIDE VIEW 1" and "SCALE 1:50".


SIDE VIEW 2

The second side view shows the profile of the bench from a different angle. It features a curved backrest and a seat. The backrest is 240 units high. The seat is 160 units high. The overall width is 500 units. The drawing is labeled "SIDE VIEW 2" and "SCALE 1:50".

SIDE VIEW 3

The third side view shows the profile of the bench from a third angle. It features a curved backrest and a seat. The backrest is 240 units high. The seat is 160 units high. The overall width is 500 units. The drawing is labeled "SIDE VIEW 3" and "SCALE 1:50".

[illegible]

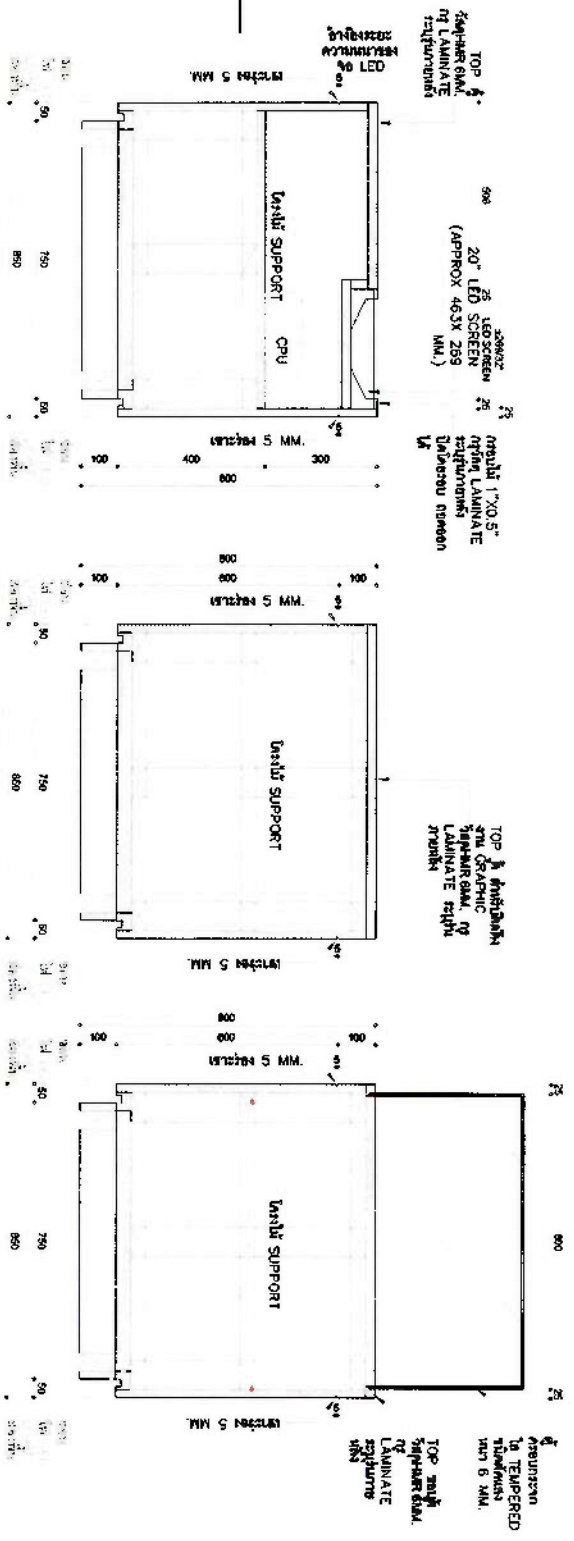


SECTION
SCALE 1:10


[illegible]

FB26 DETAIL (ဖိပ်ပုံအကျဉ်း)


အသုံးပြုမှုအရ လိုအပ်သည့် အချက်အလက်များကို ဖော်ပြပါ အချက်အလက်များနှင့် ကိုက်ညီအောင် ရေးသားပါ။

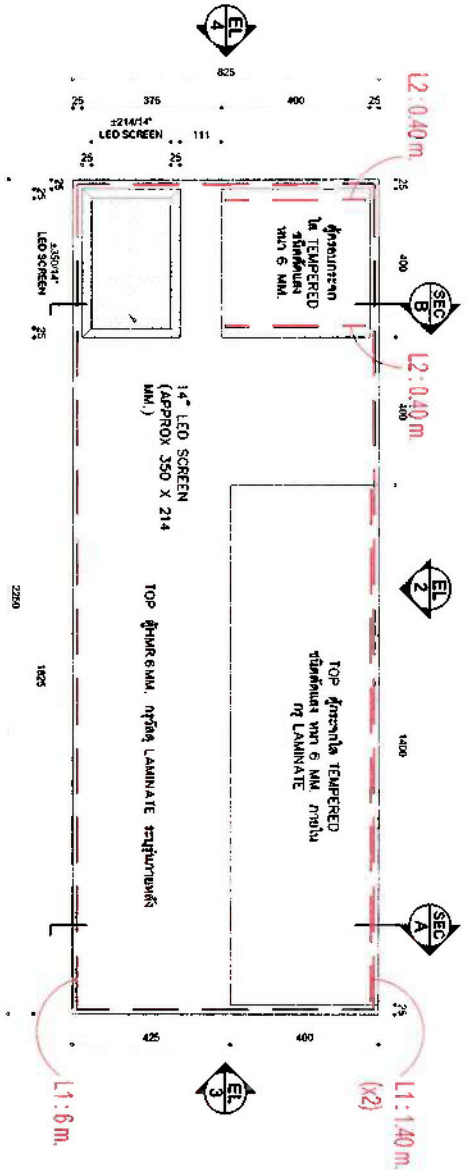


TOP VIEW (FB26 DETAIL)
SCALE 1:10

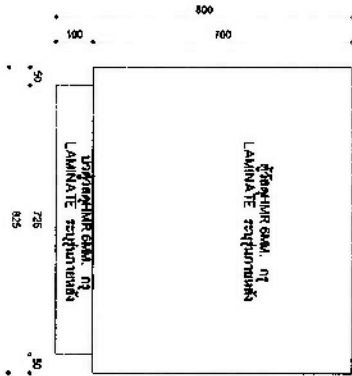


3 SIDE VIEW
SCALE 1:10

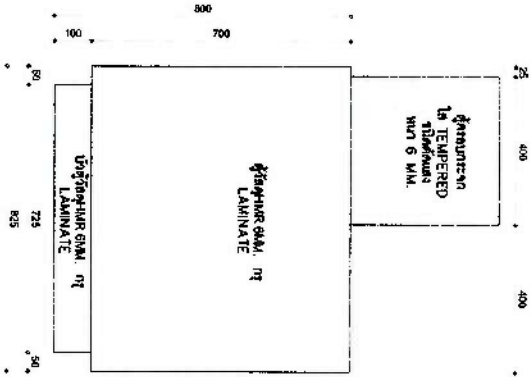


4 SIDE VIEW
SCALE 1:10

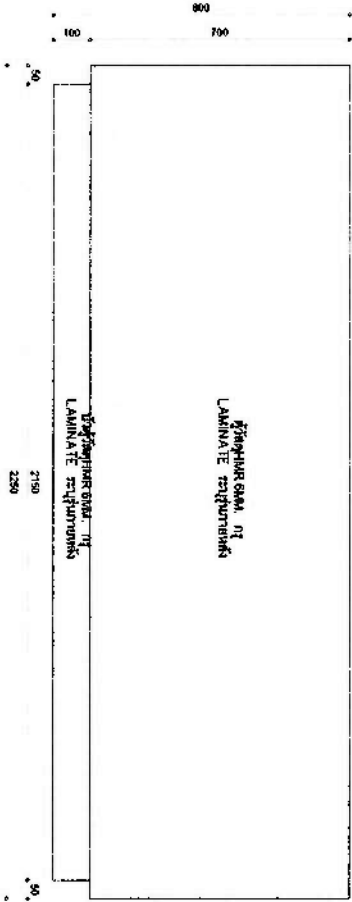


1 SIDE VIEW
SCALE 1:10

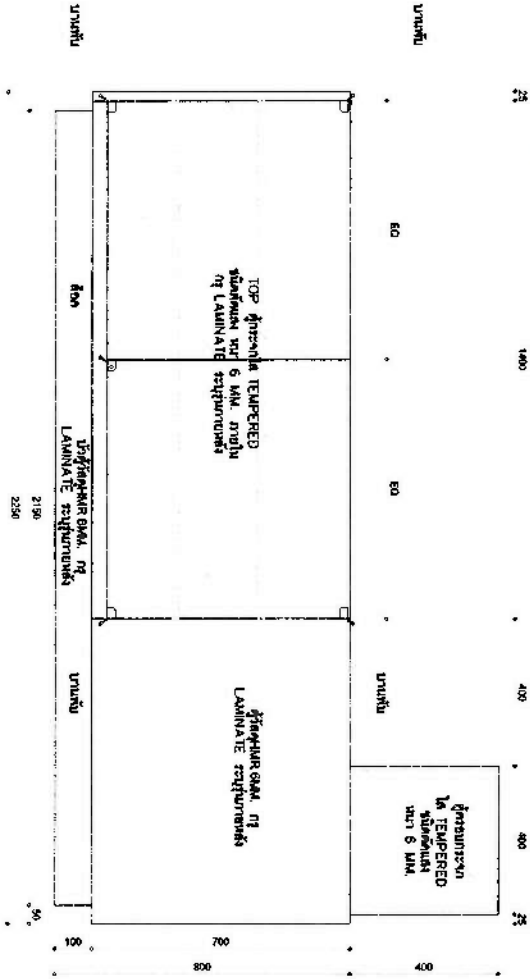

2 SIDE VIEW
SCALE 1:10


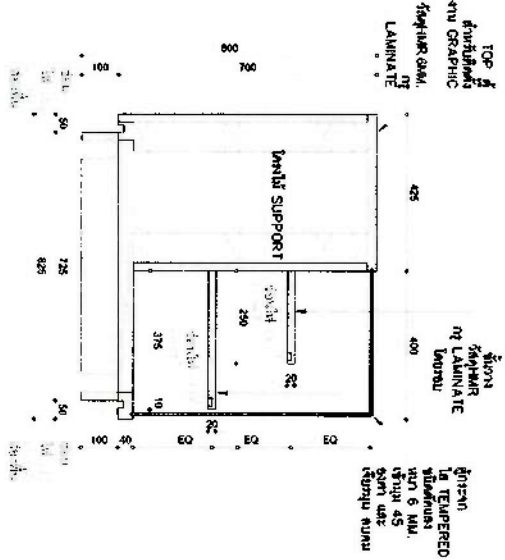


A SECTION
SCALE 1:10

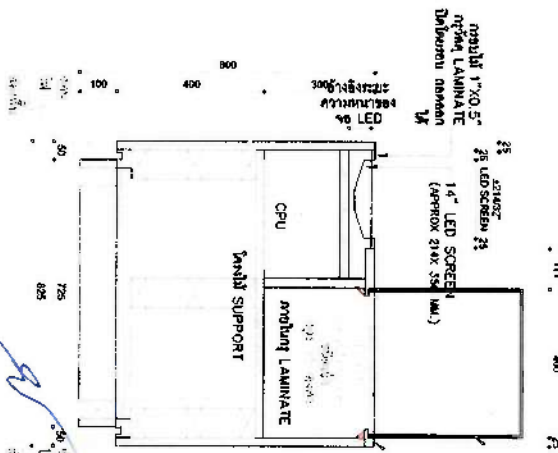

B SECTION
SCALE 1:10

QIDOR	
Project Name: FB26 DETAIL	Client: QIDOR
Location: QIDOR	Scale: 1:10
Drawn: QIDOR	Checked: QIDOR
Date: 2023-08-08	Project No: IN-B-02-08

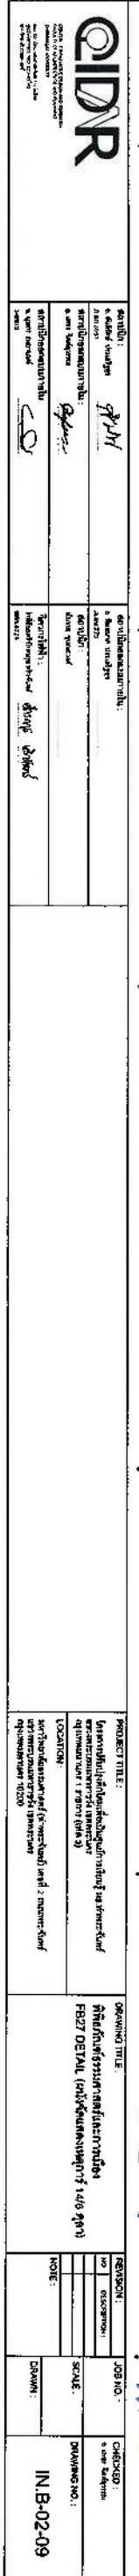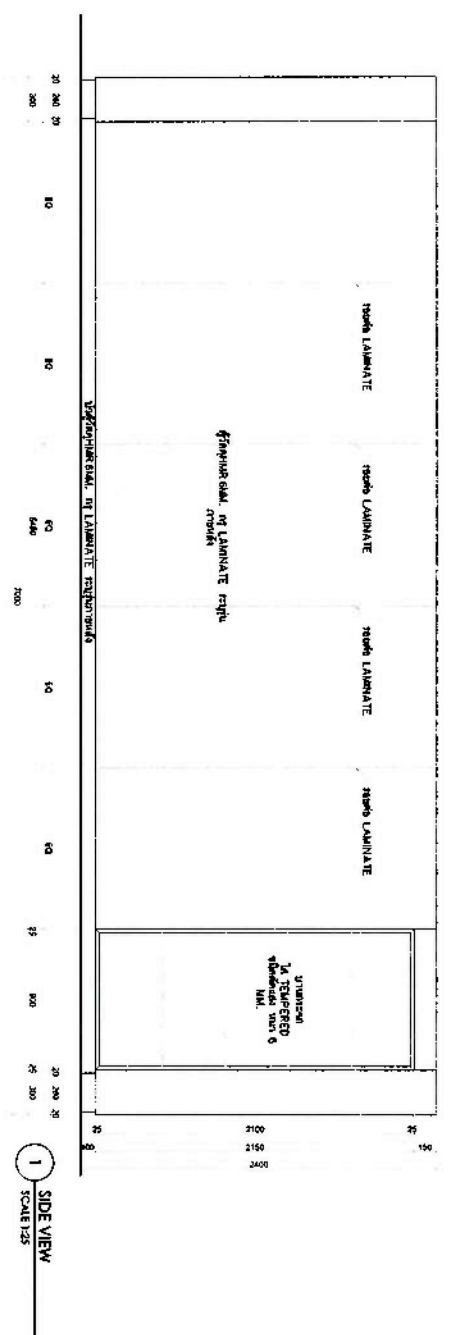

27

28

29

30

31

32

33

 
 
34


35

36


37

38




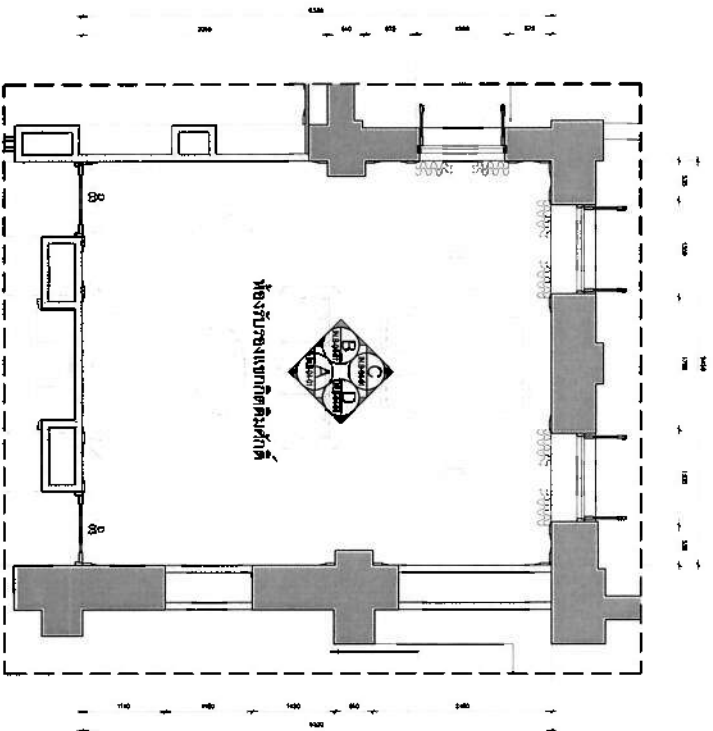


FURNITURE LAYOUT
SCALE 1:50

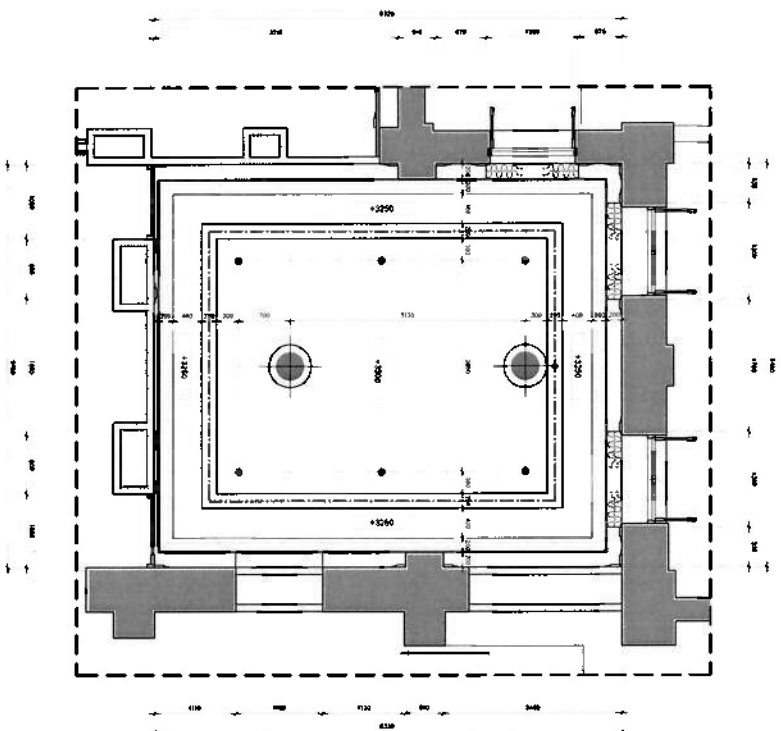


CEILING & LIGHTING LAYOUT
SCALE 1:50

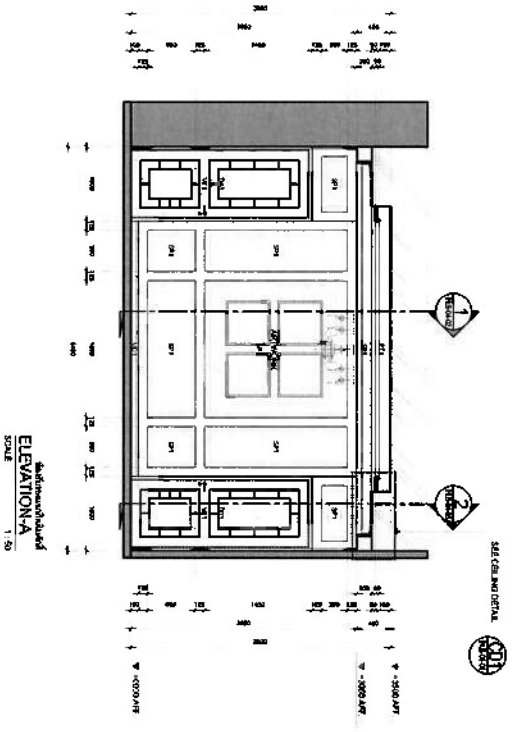


ELEVATION A
SCALE 1:50

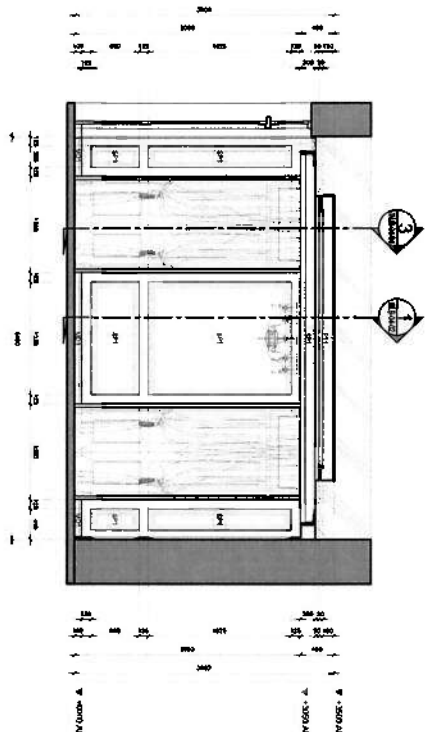

ELEVATION C
SCALE 1:50

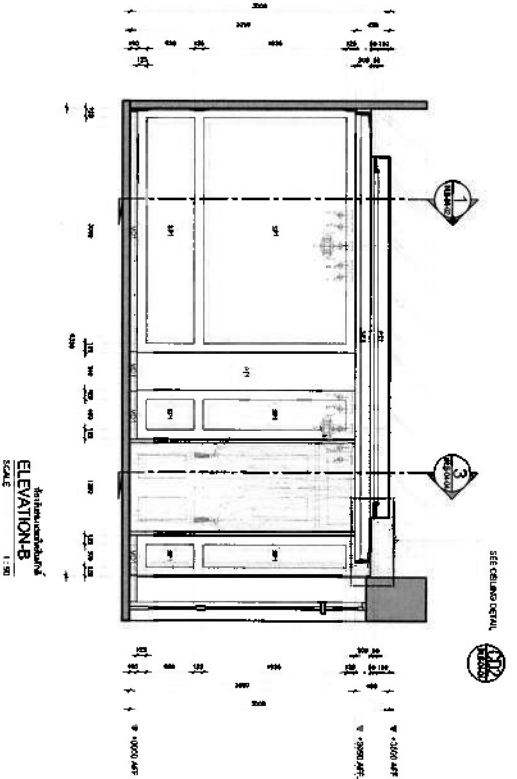

ELEVATION B
SCALE 1:50

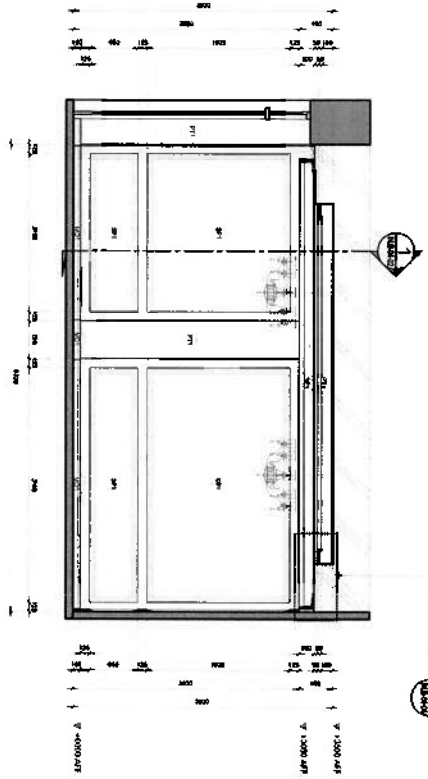

ELEVATION D
SCALE 1:50

ชื่อโครงการ: QIDR	ชื่ออาคาร: QIDR
ชื่อพื้นที่: QIDR	ชื่อพื้นที่: QIDR
ชื่อพื้นที่: QIDR	ชื่อพื้นที่: QIDR
ชื่อพื้นที่: QIDR	ชื่อพื้นที่: QIDR

PROJECT TITLE:	PROJECT TITLE:
PROJECT TITLE:	PROJECT TITLE:
PROJECT TITLE: Sewer Rehabilitation and Upgrade Project in a market area with a high density of commercial and residential development (1.5 million sq. ft.)	DRAWING TITLE: Site Plan of Sewer Rehabilitation SECTION-1	REVISION: <table><tr><th>NO.</th><th>DESCRIPTION</th></tr><tr><td> </td><td> </td></tr><tr><td> </td><td> </td></tr><tr><td> </td><td> </td></tr></table>	NO.	DESCRIPTION							JOB NO.:	CHECKED: 1.5 mil. sq. ft.
NO.	DESCRIPTION											
LOCATION: Project location is shown on the map. Contact local authorities for more information. 1.5 million sq. ft. (15000)	NOTE: 	SCALE:	DRAWING NO.:	IN-B-04-02								


MAIL ROOM
12

25

21

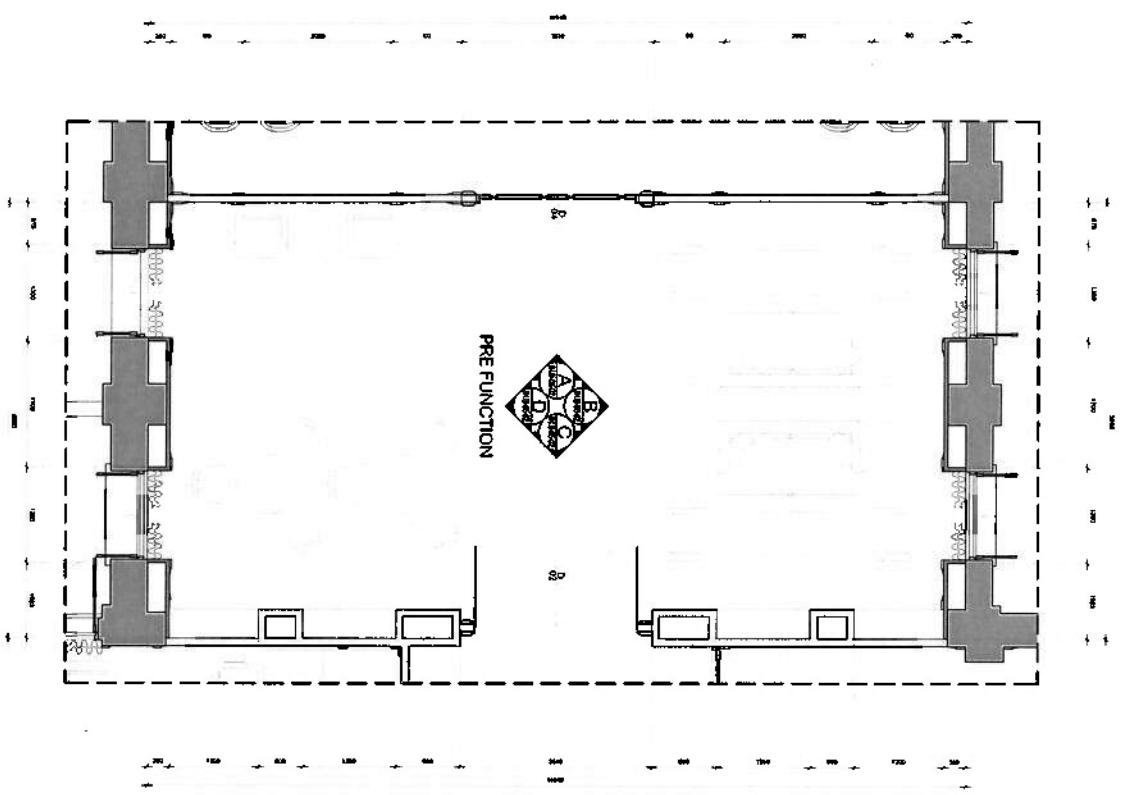



FURNITURE LAYOUT POS FUNCTION
SCALE 1"=3'-0"

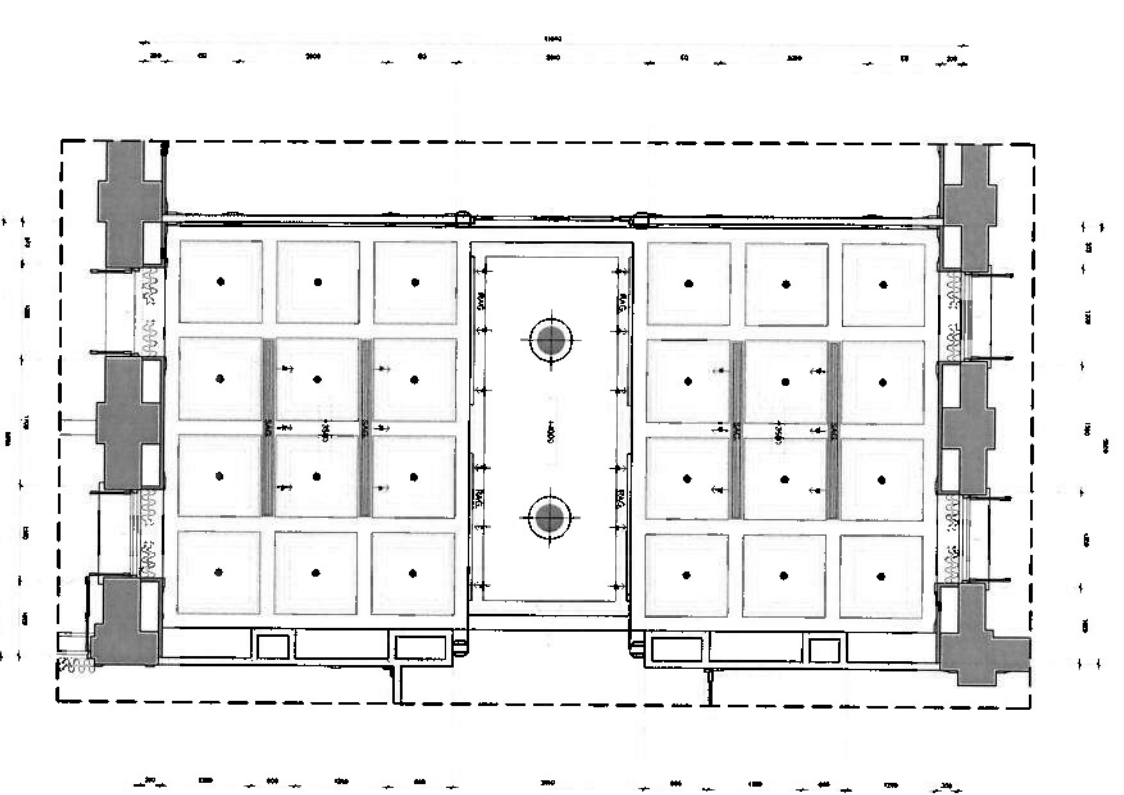


CEILING & LIGHTING LAYOUT

15.
 16.
 17.
 100.

[illegible]

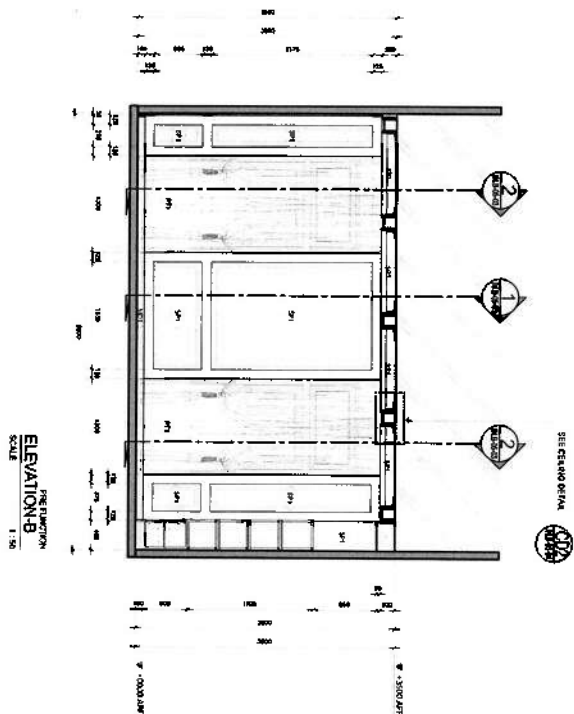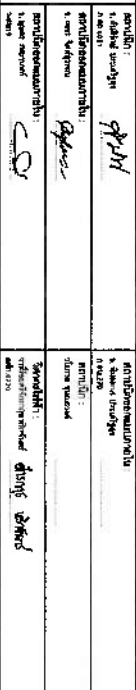


PRE ELEVATION-B
SCALE 1 : 50

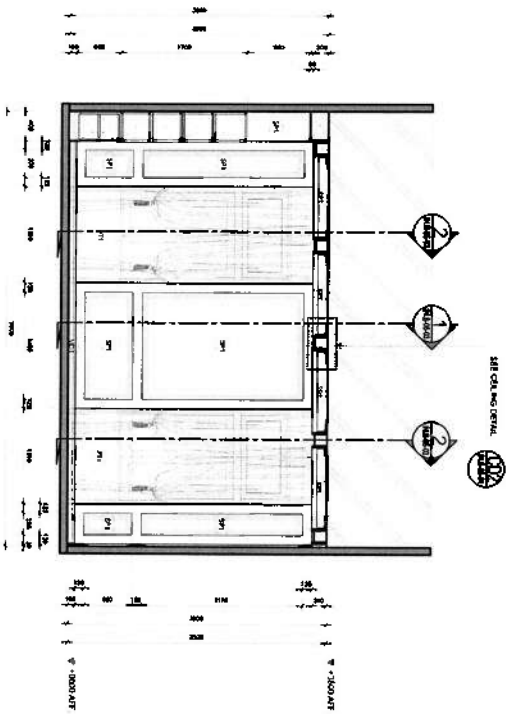


FILE FUNCTION
ELEVATION-D
SCALE 1 6

1. drawing title 2. sheet no. 3. scale 4. date 5. name 6. signature 7. stamp 8. date 9. name 10. signature 11. stamp 12. date 13. name 14. signature 15. stamp 16. date 17. name 18. signature 19. stamp 20. date 21. name 22. signature 23. stamp 24. date 25. name 26. signature 27. stamp 28. date 29. name 30. signature 31. stamp 32. date 33. name 34. signature 35. stamp 36. date 37. name 38. signature 39. stamp 40. date 41. name 42. signature 43. stamp 44. date 45. name 46. signature 47. stamp 48. date 49. name 50. signature 51. stamp 52. date 53. name 54. signature 55. stamp 56. date 57. name 58. signature 59. stamp 60. date 61. name 62. signature 63. stamp 64. date 65. name 66. signature 67. stamp 68. date 69. name 70. signature 71. stamp 72. date 73. name 74. signature 75. stamp 76. date 77. name 78. signature 79. stamp 80. date 81. name 82. signature 83. stamp 84. date 85. name 86. signature 87. stamp 88. date 89. name 90. signature 91. stamp 92. date 93. name 94. signature 95. stamp 96. date 97. name 98. signature 99. stamp 100. date 101. name 102. signature 103. stamp 104. date 105. name 106. signature 107. stamp 108. date 109. name 110. signature 111. stamp 112. date 113. name 114. signature 115. stamp 116. date 117. name 118. signature 119. stamp 120. date 121. name 122. signature 123. stamp 124. date 125. name 126. signature 127. stamp 128. date 129. name 130. signature 131. stamp 132. date 133. name 134. signature 135. stamp 136. date 137. name 138. signature 139. stamp 140. date 141. name 142. signature 143. stamp 144. date 145. name 146. signature 147. stamp 148. date 149. name 150. signature 151. stamp 152. date 153. name 154. signature 155. stamp 156. date 157. name 158. signature 159. stamp 160. date 161. name 162. signature 163. stamp 164. date 165. name 166. signature 167. stamp 168. date 169. name 170. signature 171. stamp 172. date 173. name 174. signature 175. stamp 176. date 177. name 178. signature 179. stamp 180. date 181. name 182. signature 183. stamp 184. date 185. name 186. signature 187. stamp 188. date 189. name 190. signature 191. stamp 192. date 193. name 194. signature 195. stamp 196. date 197. name 198. signature 199. stamp 200. date 201. name 202. signature 203. stamp 204. date 205. name 206. signature 207. stamp 208. date 209. name 210. signature 211. stamp 212. date 213. name 214. signature 215. stamp 216. date 217. name 218. signature 219. stamp 220. date 221. name 222. signature 223. stamp 224. date 225. name 226. signature 227. stamp 228. date 229. name 230. signature 231. stamp 232. date 233. name 234. signature 235. stamp 236. date 237. name 238. signature 239. stamp 240. date 241. name 242. signature 243. stamp 244. date 245. name 246. signature 247. stamp 248. date 249. name 250. signature 251. stamp 252. date 253. name 254. signature 255. stamp 256. date 257. name 258. signature 259. stamp 260. date 261. name 262. signature 263. stamp 264. date 265. name 266. signature 267. stamp 268. date 269. name 270. signature 271. stamp 272. date 273. name 274. signature 275. stamp 276. date 277. name 278. signature 279. stamp 280. date 281. name 282. signature 283. stamp 284. date 285. name 286. signature 287. stamp 288. date 289. name 290. signature 291. stamp 292. date 293. name 294. signature 295. stamp 296. date 297. name 298. signature 299. stamp 300. date 301. name 302. signature 303. stamp 304. date 305. name 306. signature 307. stamp 308. date 309. name 310. signature 311. stamp 312. date 313. name 314. signature 315. stamp 316. date 317. name 318. signature 319. stamp 320. date 321. name 322. signature 323. stamp 324. date 325. name 326. signature 327. stamp 328. date 329. name 330. signature 331. stamp 332. date 333. name 334. signature 335. stamp 336. date 337. name 338. signature 339. stamp 340. date 341. name 342. signature 343. stamp 344. date 345. name 346. signature 347. stamp 348. date 349. name 350. signature 351. stamp 352. date 353. name 354. signature 355. stamp 356. date 357. name 358. signature 359. stamp 360. date 361. name 362. signature 363. stamp 364. date 365. name 366. signature 367. stamp 368. date 369. name 370. signature 371. stamp 372. date 373. name 374. signature 375. stamp 376. date 377. name 378. signature 379. stamp 380. date 381. name 382. signature 383. stamp 384. date 385. name 386. signature 387. stamp 388. date 389. name 390. signature 391. stamp 392. date 393. name 394. signature 395. stamp 396. date 397. name 398. signature 399. stamp 400. date 401. name 402. signature 403. stamp 404. date 405. name 406. signature 407. stamp 408. date 409. name 410. signature 411. stamp 412. date 413. name 414. signature 415. stamp 416. date 417. name 418. signature 419. stamp
--


FB41B DETAIL (8/1/77)

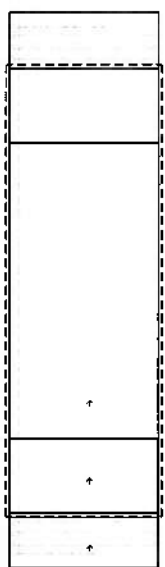


TOP VIEW
SCALE 1 : 10

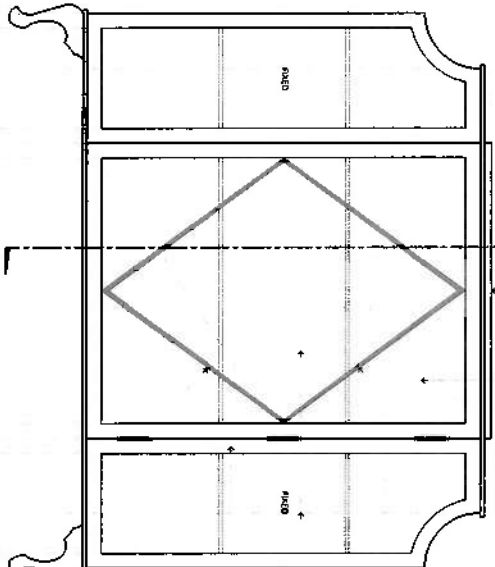


FRONT VIEW
SCALE 1 : 10

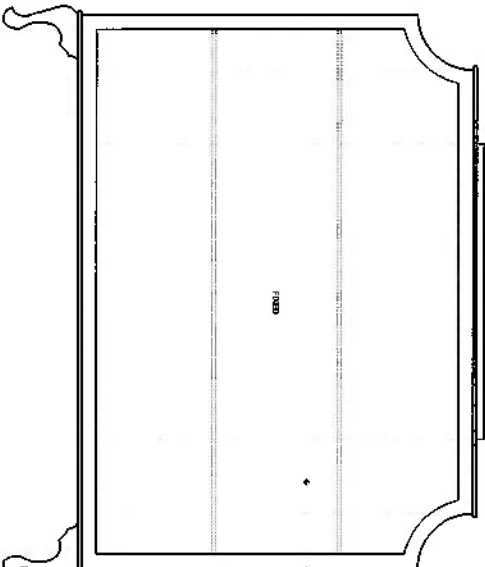


BACK VIEW
SCALE 1 : 10

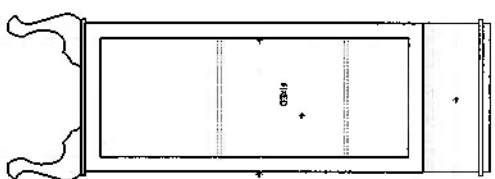


SIDE VIEW
SCALE 1" = 1'

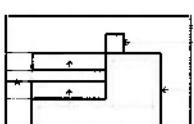


DETAIL-A
SCALE 1"=1'

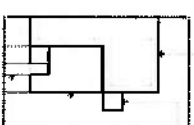

DETAIL-B
SCALE 1:2

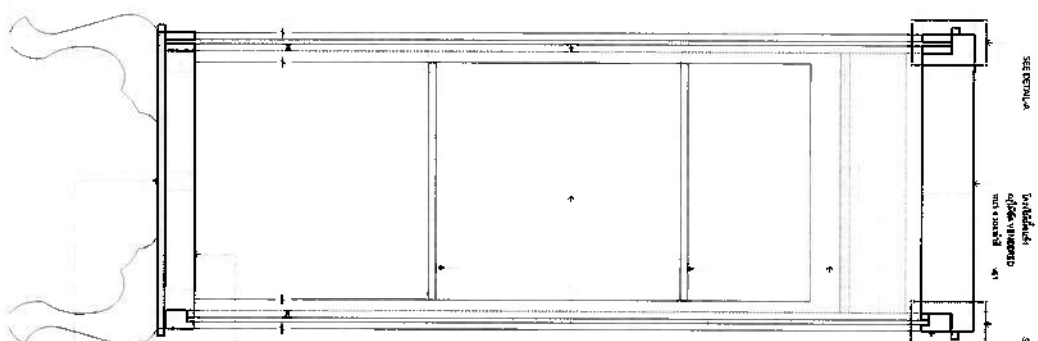

SECTION-1
SCALE 1:1

 








address: • address line 1 100000	address line 2 100000	address line 3 100000	address line 4 100000	address line 5 100000	address line 6 100000	address line 7 100000	address line 8 100000	address line 9 100000	address line 10 100000	address line 11 100000	address line 12 100000	address line 13 100000	address line 14 100000	address line 15 100000	address line 16 100000	address line 17 100000	address line 18 100000	address line 19 100000	address line 20 100000	address line 21 100000	address line 22 100000	address line 23 100000	address line 24 100000	address line 25 100000	address line 26 100000	address line 27 100000	address line 28 100000	address line 29 100000	address line 30 100000	address line 31 100000	address line 32 100000	address line 33 100000	address line 34 100000	address line 35 100000	address line 36 100000	address line 37 100000	address line 38 100000	address line 39 100000	address line 40 100000	address line 41 100000	address line 42 100000	address line 43 100000	address line 44 100000	address line 45 100000	address line 46 100000	address line 47 100000	address line 48 100000	address line 49 100000	address line 50 100000	address line 51 100000	address line 52 100000	address line 53 100000	address line 54 100000	address line 55 100000	address line 56 100000	address line 57 100000	address line 58 100000	address line 59 100000	address line 60 100000	address line 61 100000	address line 62 100000	address line 63 100000	address line 64 100000	address line 65 100000	address line 66 100000	address line 67 100000	address line 68 100000	address line 69 100000	address line 70 100000	address line 71 100000	address line 72 100000	address line 73 100000	address line 74 100000	address line 75 100000	address line 76 100000	address line 77 100000	address line 78 100000	address line 79 100000	address line 80 100000	address line 81 100000	address line 82 100000	address line 83 100000	address line 84 100000	address line 85 100000	address line 86 100000	address line 87 100000	address line 88 100000	address line 89 100000	address line 90 100000	address line 91 100000	address line 92 100000	address line 93 100000	address line 94 100000	address line 95 100000	address line 96 100000	address line 97 100000	address line 98 100000	address line 99 100000	address line 100 100000
--	--------------------------	--------------------------	--------------------------	--------------------------	--------------------------	--------------------------	--------------------------	--------------------------	---------------------------	---------------------------	----------------------------

PROJECT TITLE	LOCATION:
Investigative study of biological effects of water-borne pesticides on the fish, <i>Apogon niger</i> (Petersen) (Project # 1000)	Marine Biological Laboratory, P.O. Box 24 Woods Hole, Massachusetts 02543


DRAWING TITLE : Handing of information ELEVATION A, B, C, D		REVISION :		JOB NO. :		CHECKER : = Rev. Subgroup	
		1	REVISED ON				
				SCALE :		DRAWING NO. :	
			NOTE :				
				DRAWN :			

IN-B-06-03

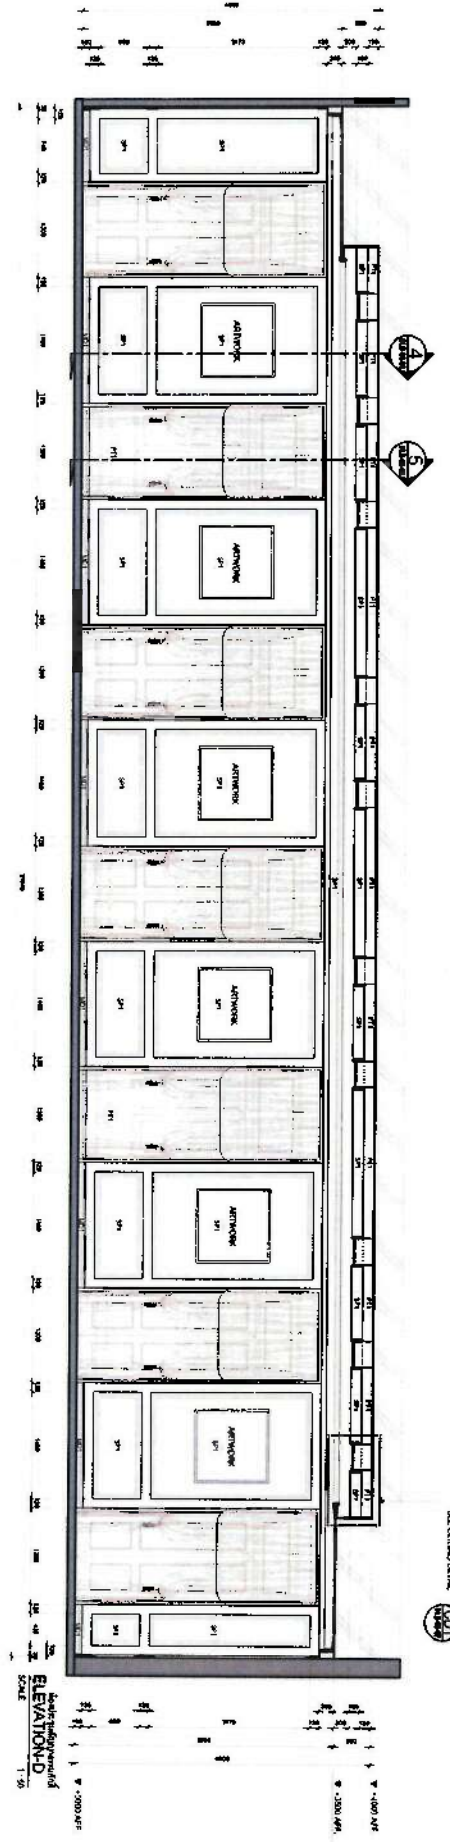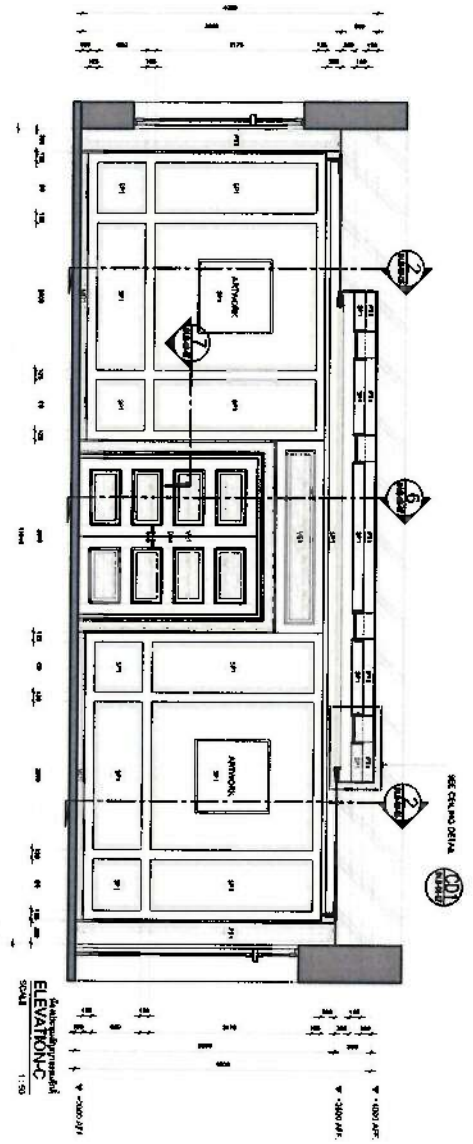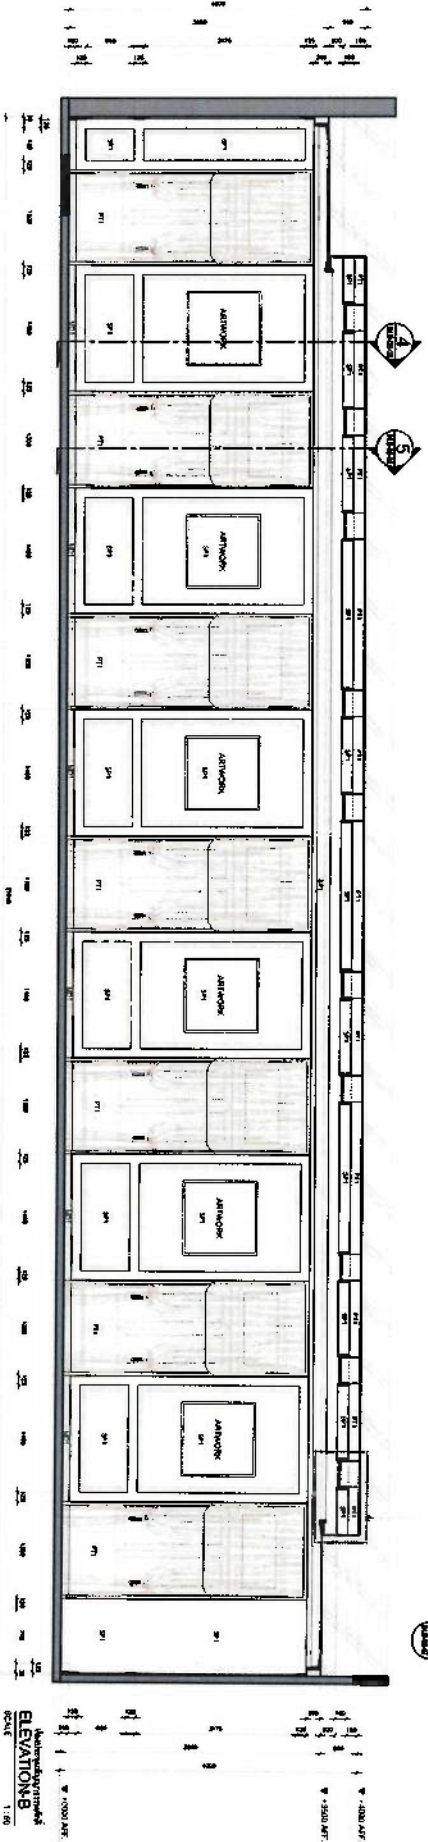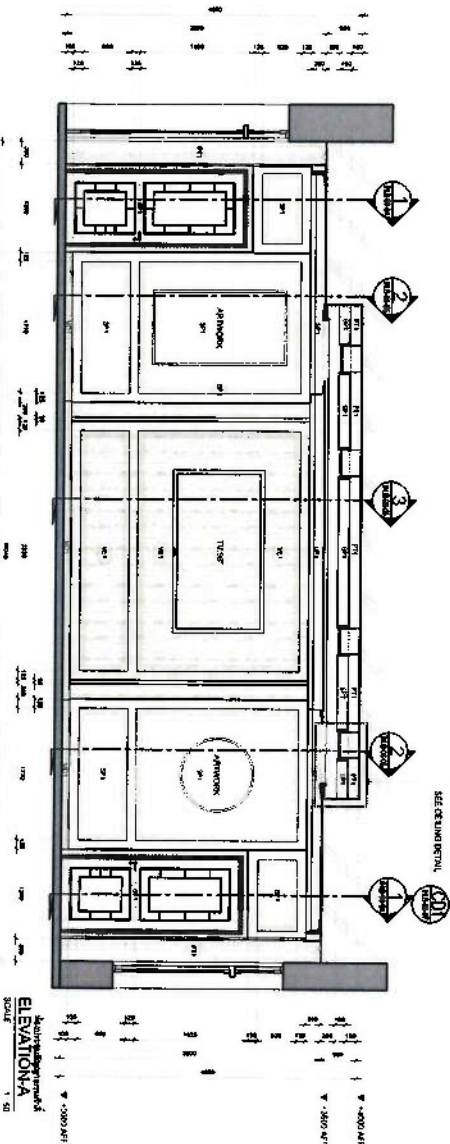


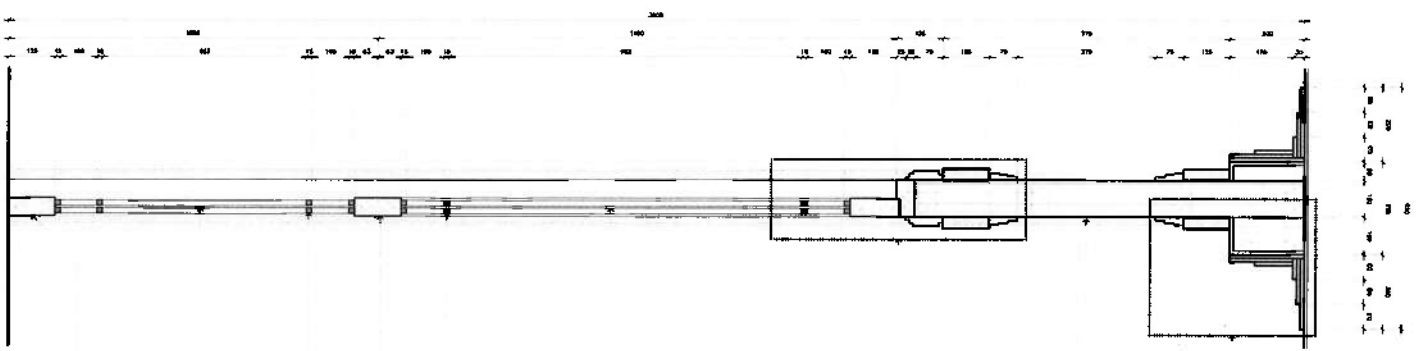

SECTION-1
SCALE: 1/8" = 1'-0"

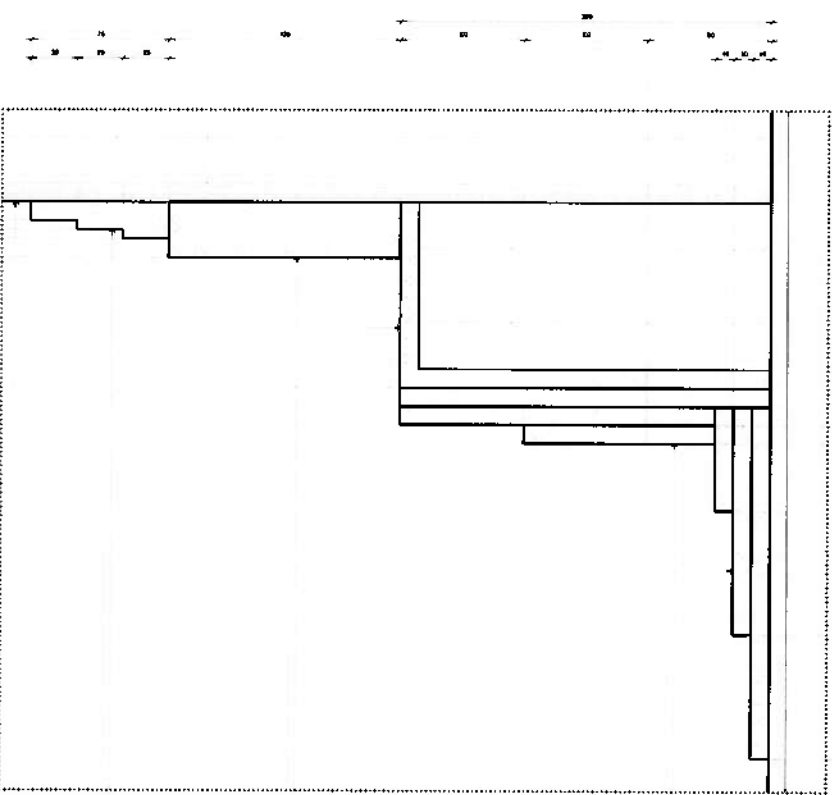

SECTION-2
SCALE: 1/8" = 1'-0"

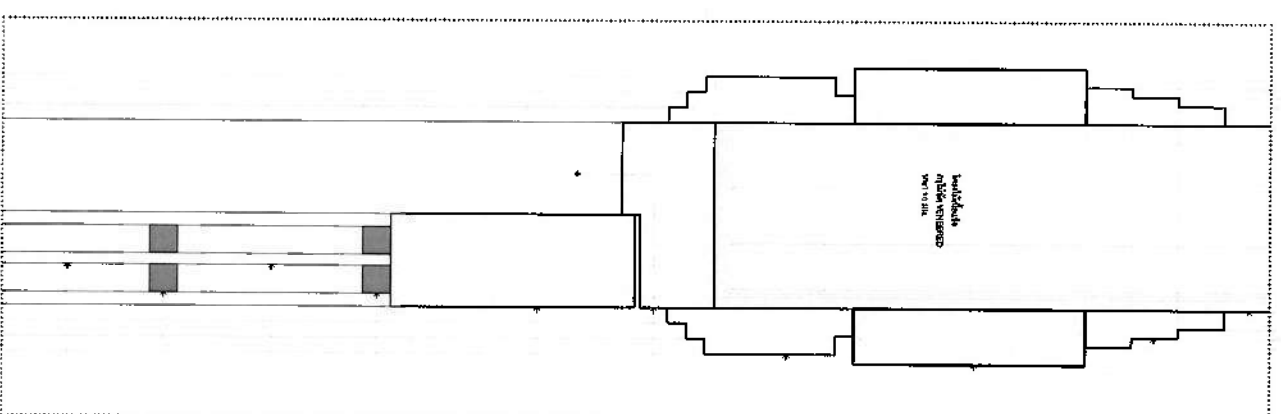

SECTION-3
SCALE: 1/8" = 1'-0"

QIDAR	
PROJECT TITLE: SECTION-1	DATE: 1/10
DESIGNER: QIDAR	CHECKED: QIDAR
LOCATION: QIDAR	SCALE: 1/8" = 1'-0"
PROJECT NO: QIDAR	DRAWING NO: IN-B-06-04



SECTION-2
SCALE 1 : 10



DETAIL-A
SCALE 1:2




DETAIL-B
SCALE 1:2



DETAIL-C
SCALE 1:2



DETAIL-D

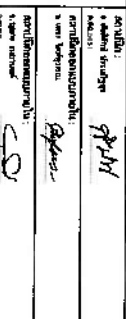


PROJECT TITLE:
Investigating the relationship between the use of the Internet and the use of the Internet for information purposes (in the UK)

LOCATION:
The University of York, UK (Yorkshire), and a number of other locations in the UK

DRAWING TITLE :
 3D Model of the Machine
 SECTION-2, 3

REVISION: NO. DESCRIPTION:	JOB NO.:	CHECKED: & UNIT SUPERVISOR	DRAWING NO.:	SCALE:	NOTE:	DRAWN:	IN

ISSUED:
DATE: 06/05/2015
AWARD NO.:
IN.B-06-05

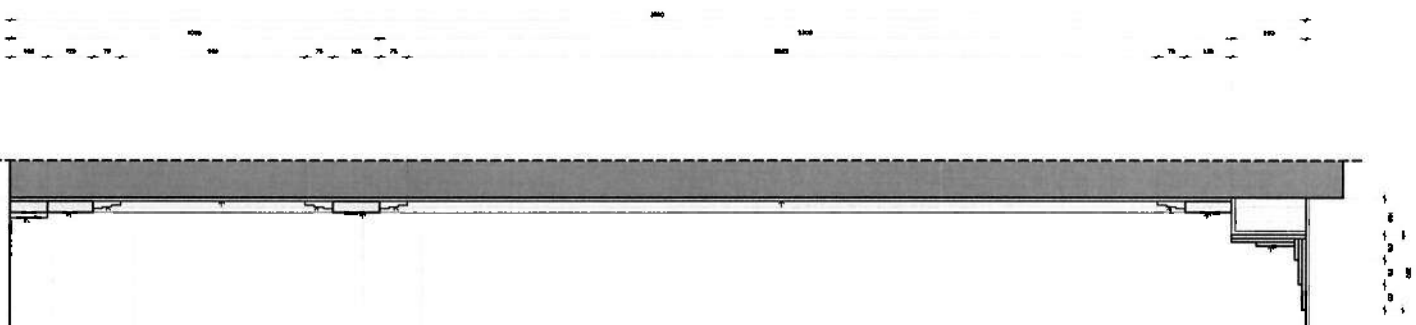[illegible]

with 100
100

10/10/2007 10:10:10 AM


[illegible]

© 2001 by John Wiley & Sons, Inc.

biochemistry 101

संस्कृत-संज्ञा

100

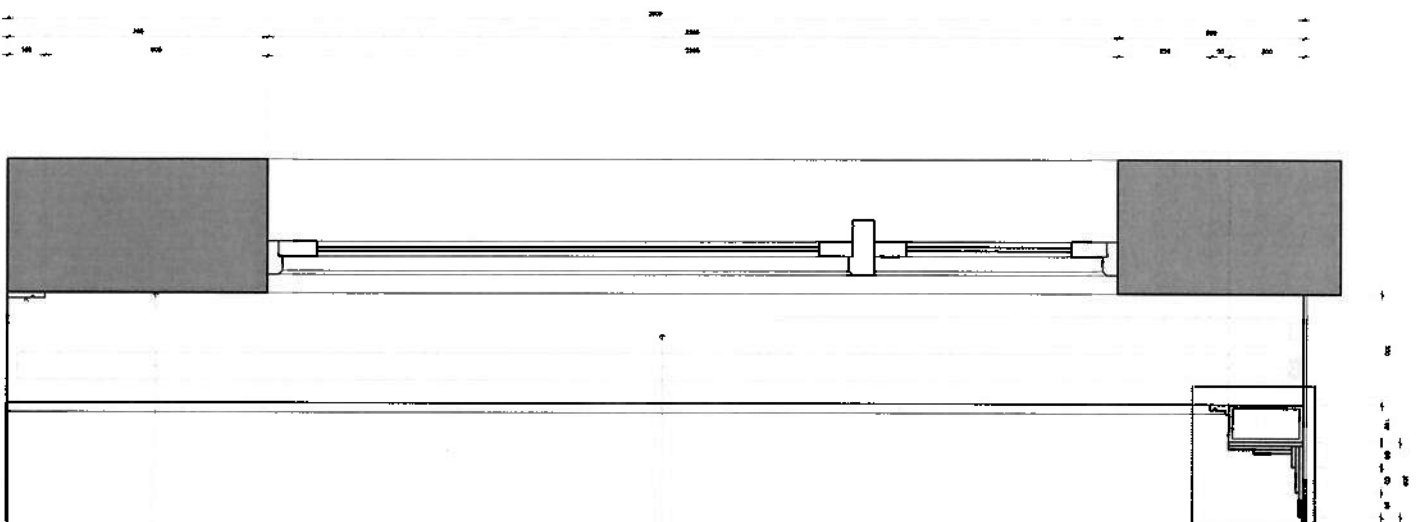



SECRET




Equation (14) can be written as

continued on p. 17

will be:






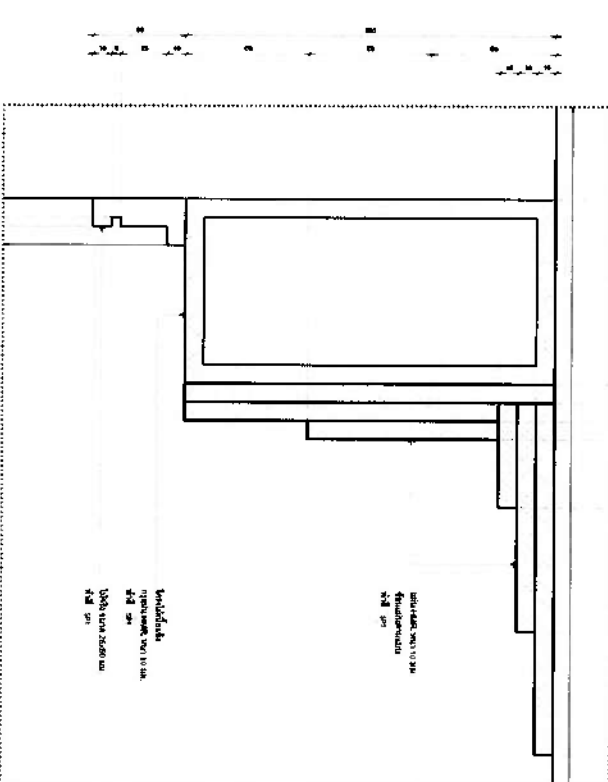
[illegible][illegible][illegible]

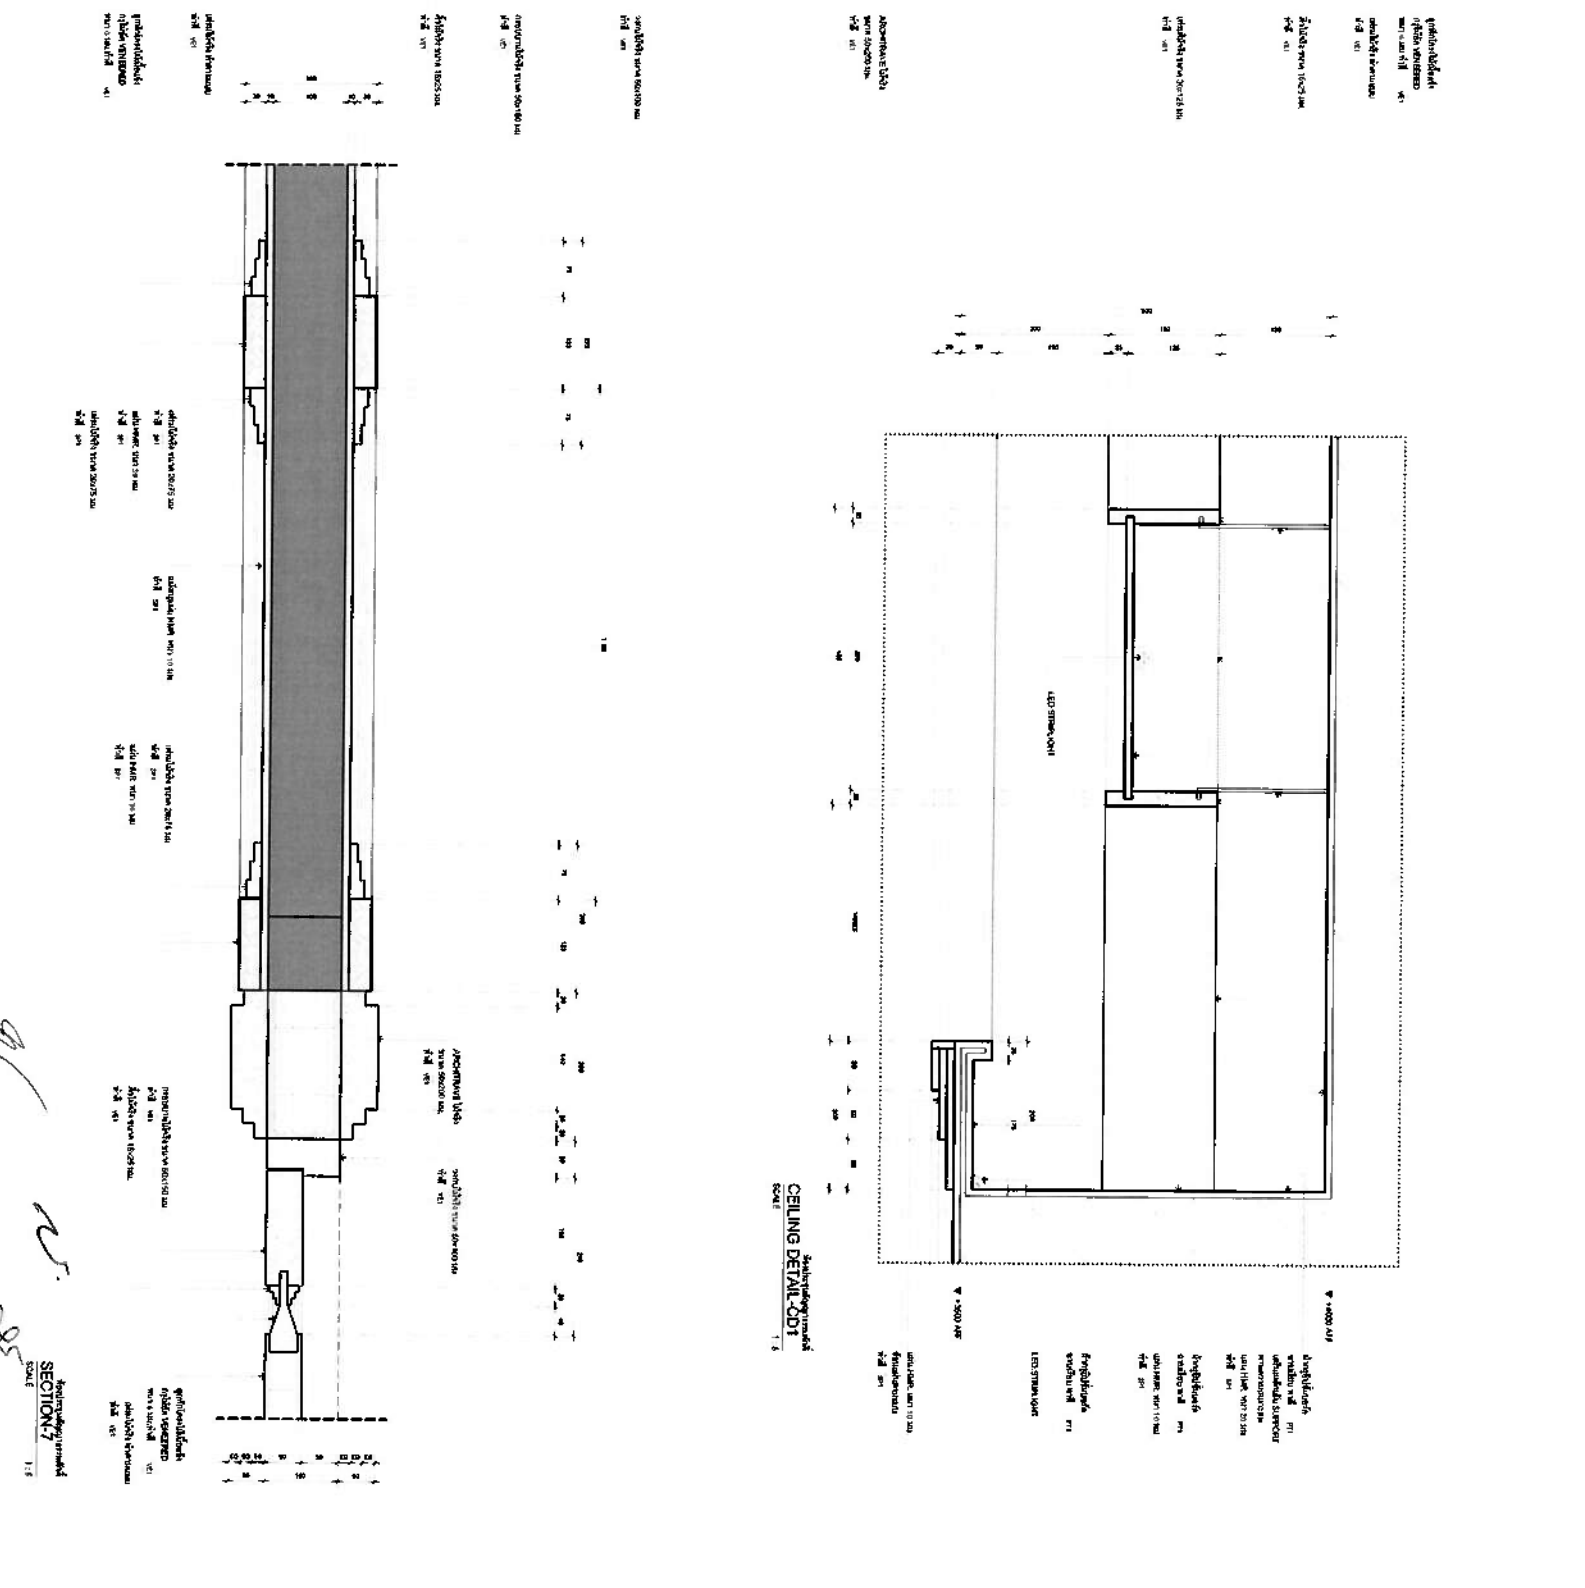

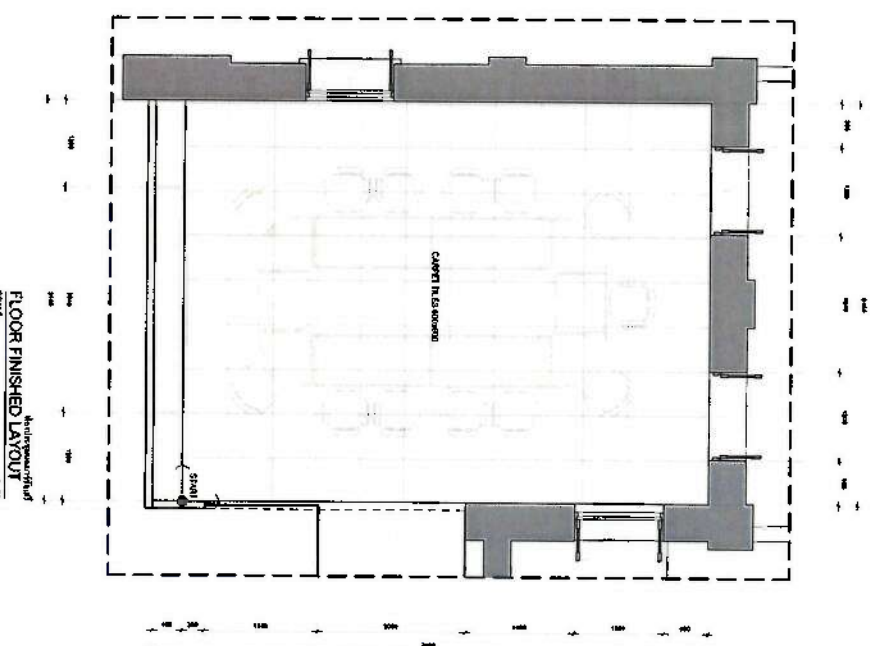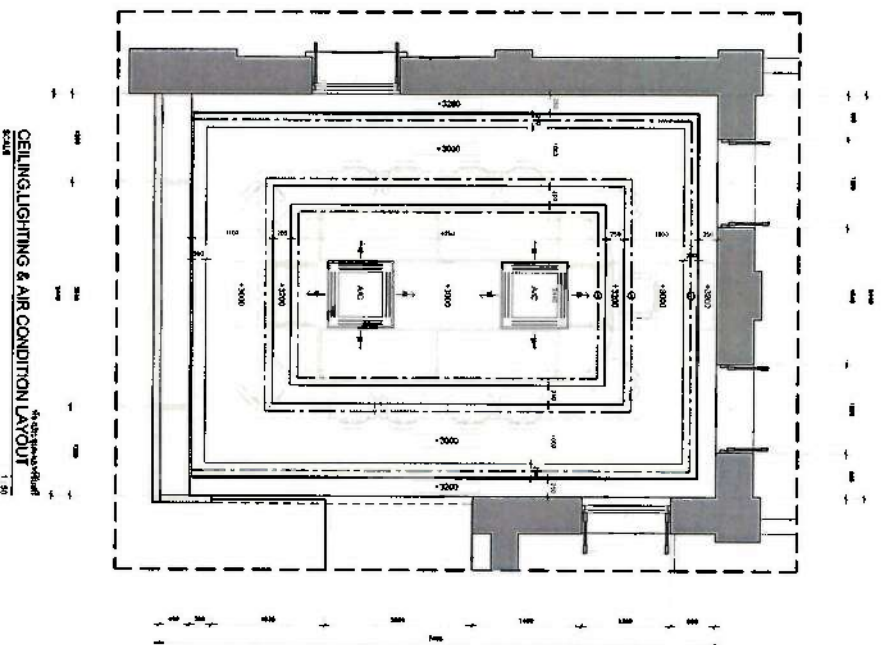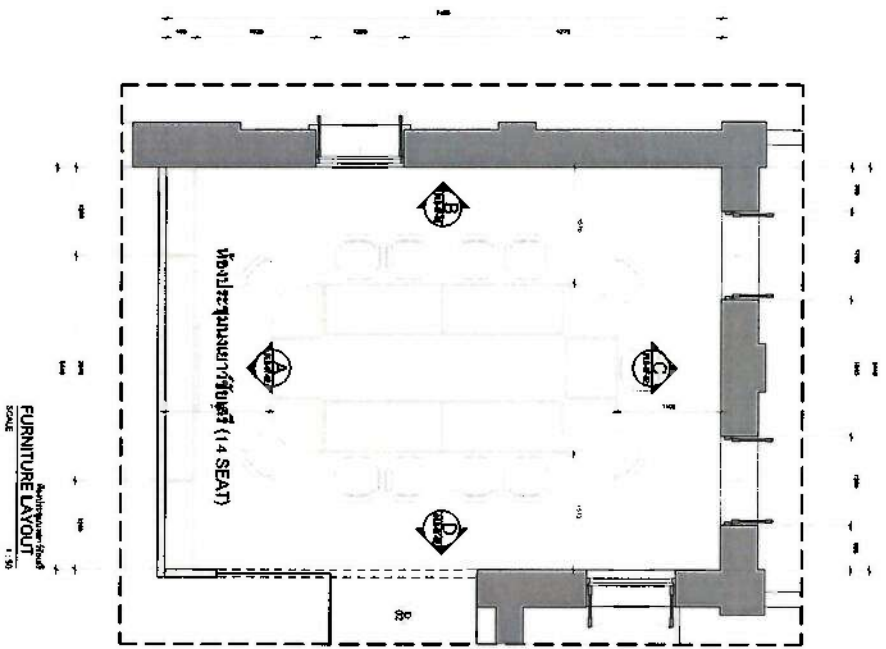

Handwritten notes and signatures in blue ink, including a large 'N' and several illegible signatures.

		PROJECT TITLE: 2nd FLOOR FURNITURE LAYOUT CEILING LIGHTING & AIR CONDITION LAYOUT FLOOR FINISHED LAYOUT	
DRAWING NO.: IN-B-07-01	CHECKED: [Signature]	SCALE: 1:50	DATE: [Blank]
PROJECT TITLE: 2nd FLOOR FURNITURE LAYOUT CEILING LIGHTING & AIR CONDITION LAYOUT FLOOR FINISHED LAYOUT		DRAWING NO.: IN-B-07-01	

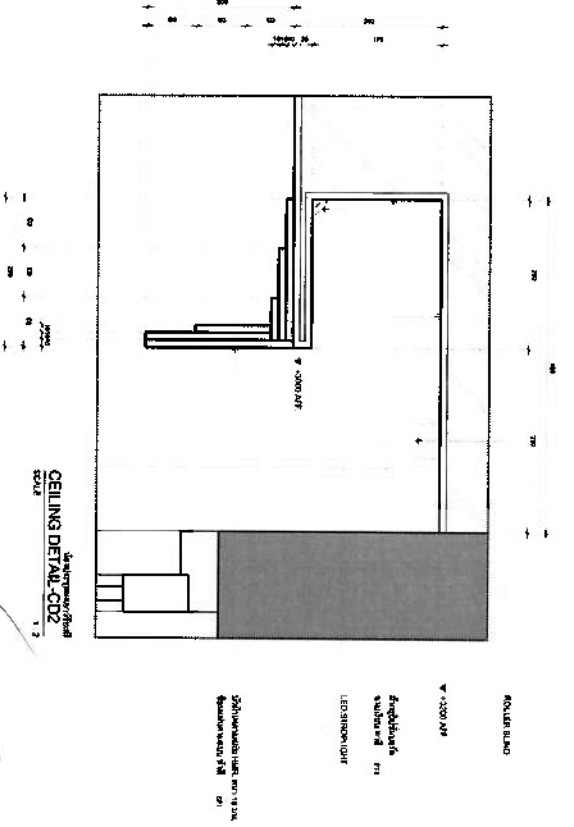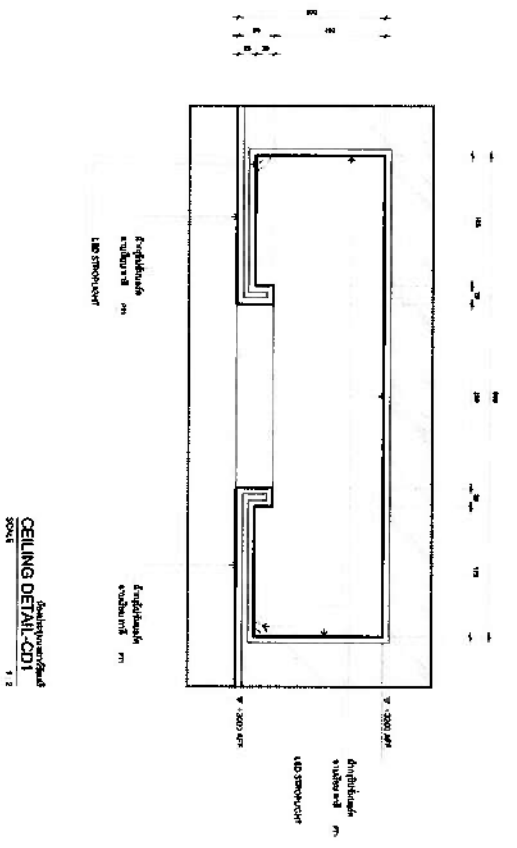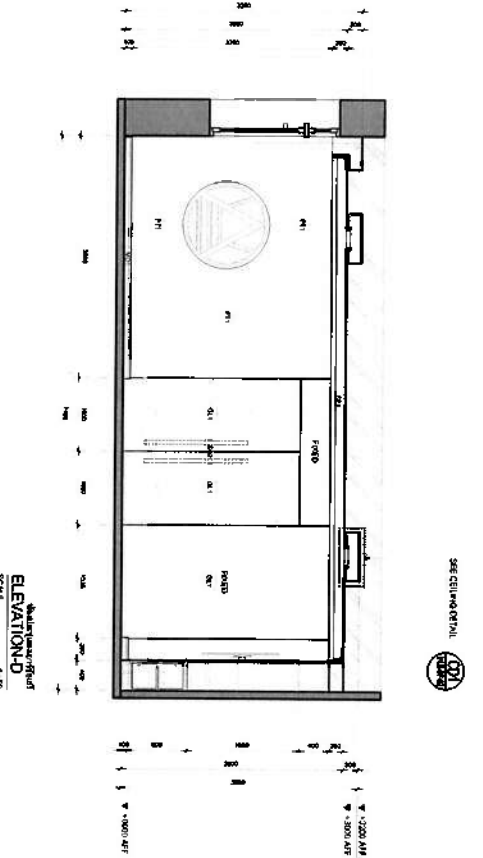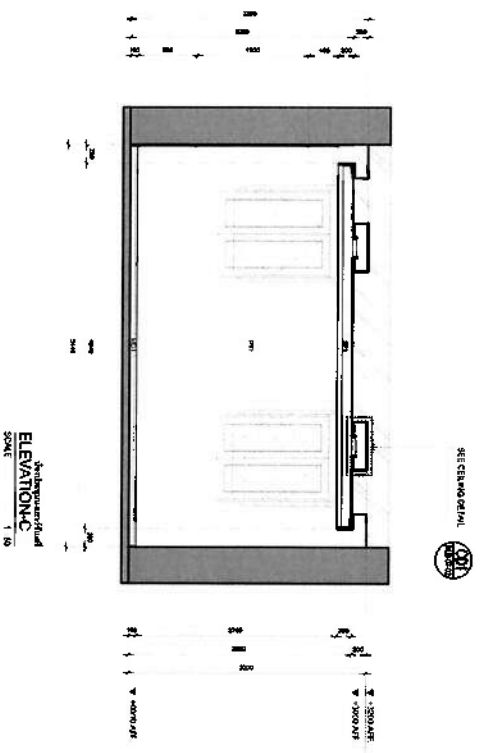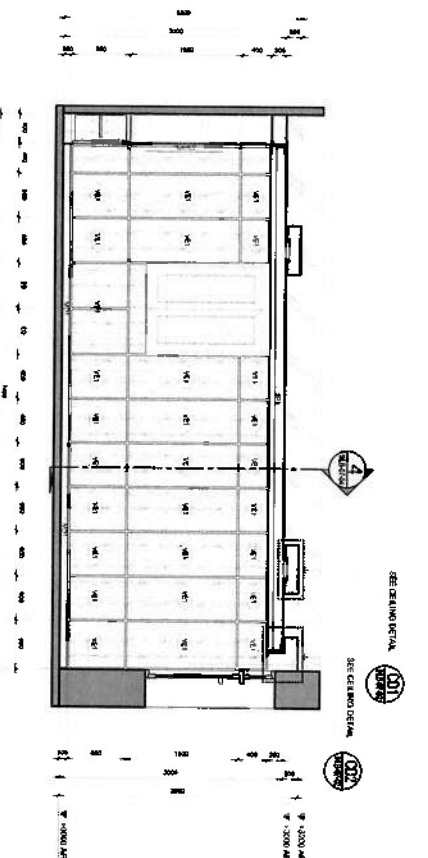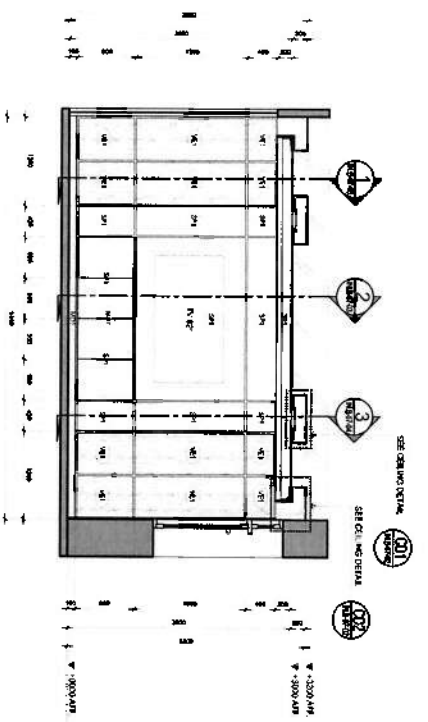


QIDR	
PROJECT TITLE: 2nd Floor	DATE: 10/1/11
PROJECT NO: IN-B-07-02	SCALE: 1/8\"
DESIGNER: IN-B-07-02	CHECKED: IN-B-07-02
NOTES:	




PROJECT TITLE:	PROJECT NO.:
LOCATION:	DATE:
DESIGNER:	DRAWN BY:
CHECKED BY:	INCHES:

SECTION 1	SECTION 2
SCALE: 1/4" = 1'-0"	SCALE: 1/4" = 1'-0"




SECTION 1	SECTION 2
SCALE: 1/4" = 1'-0"	SCALE: 1/4" = 1'-0"

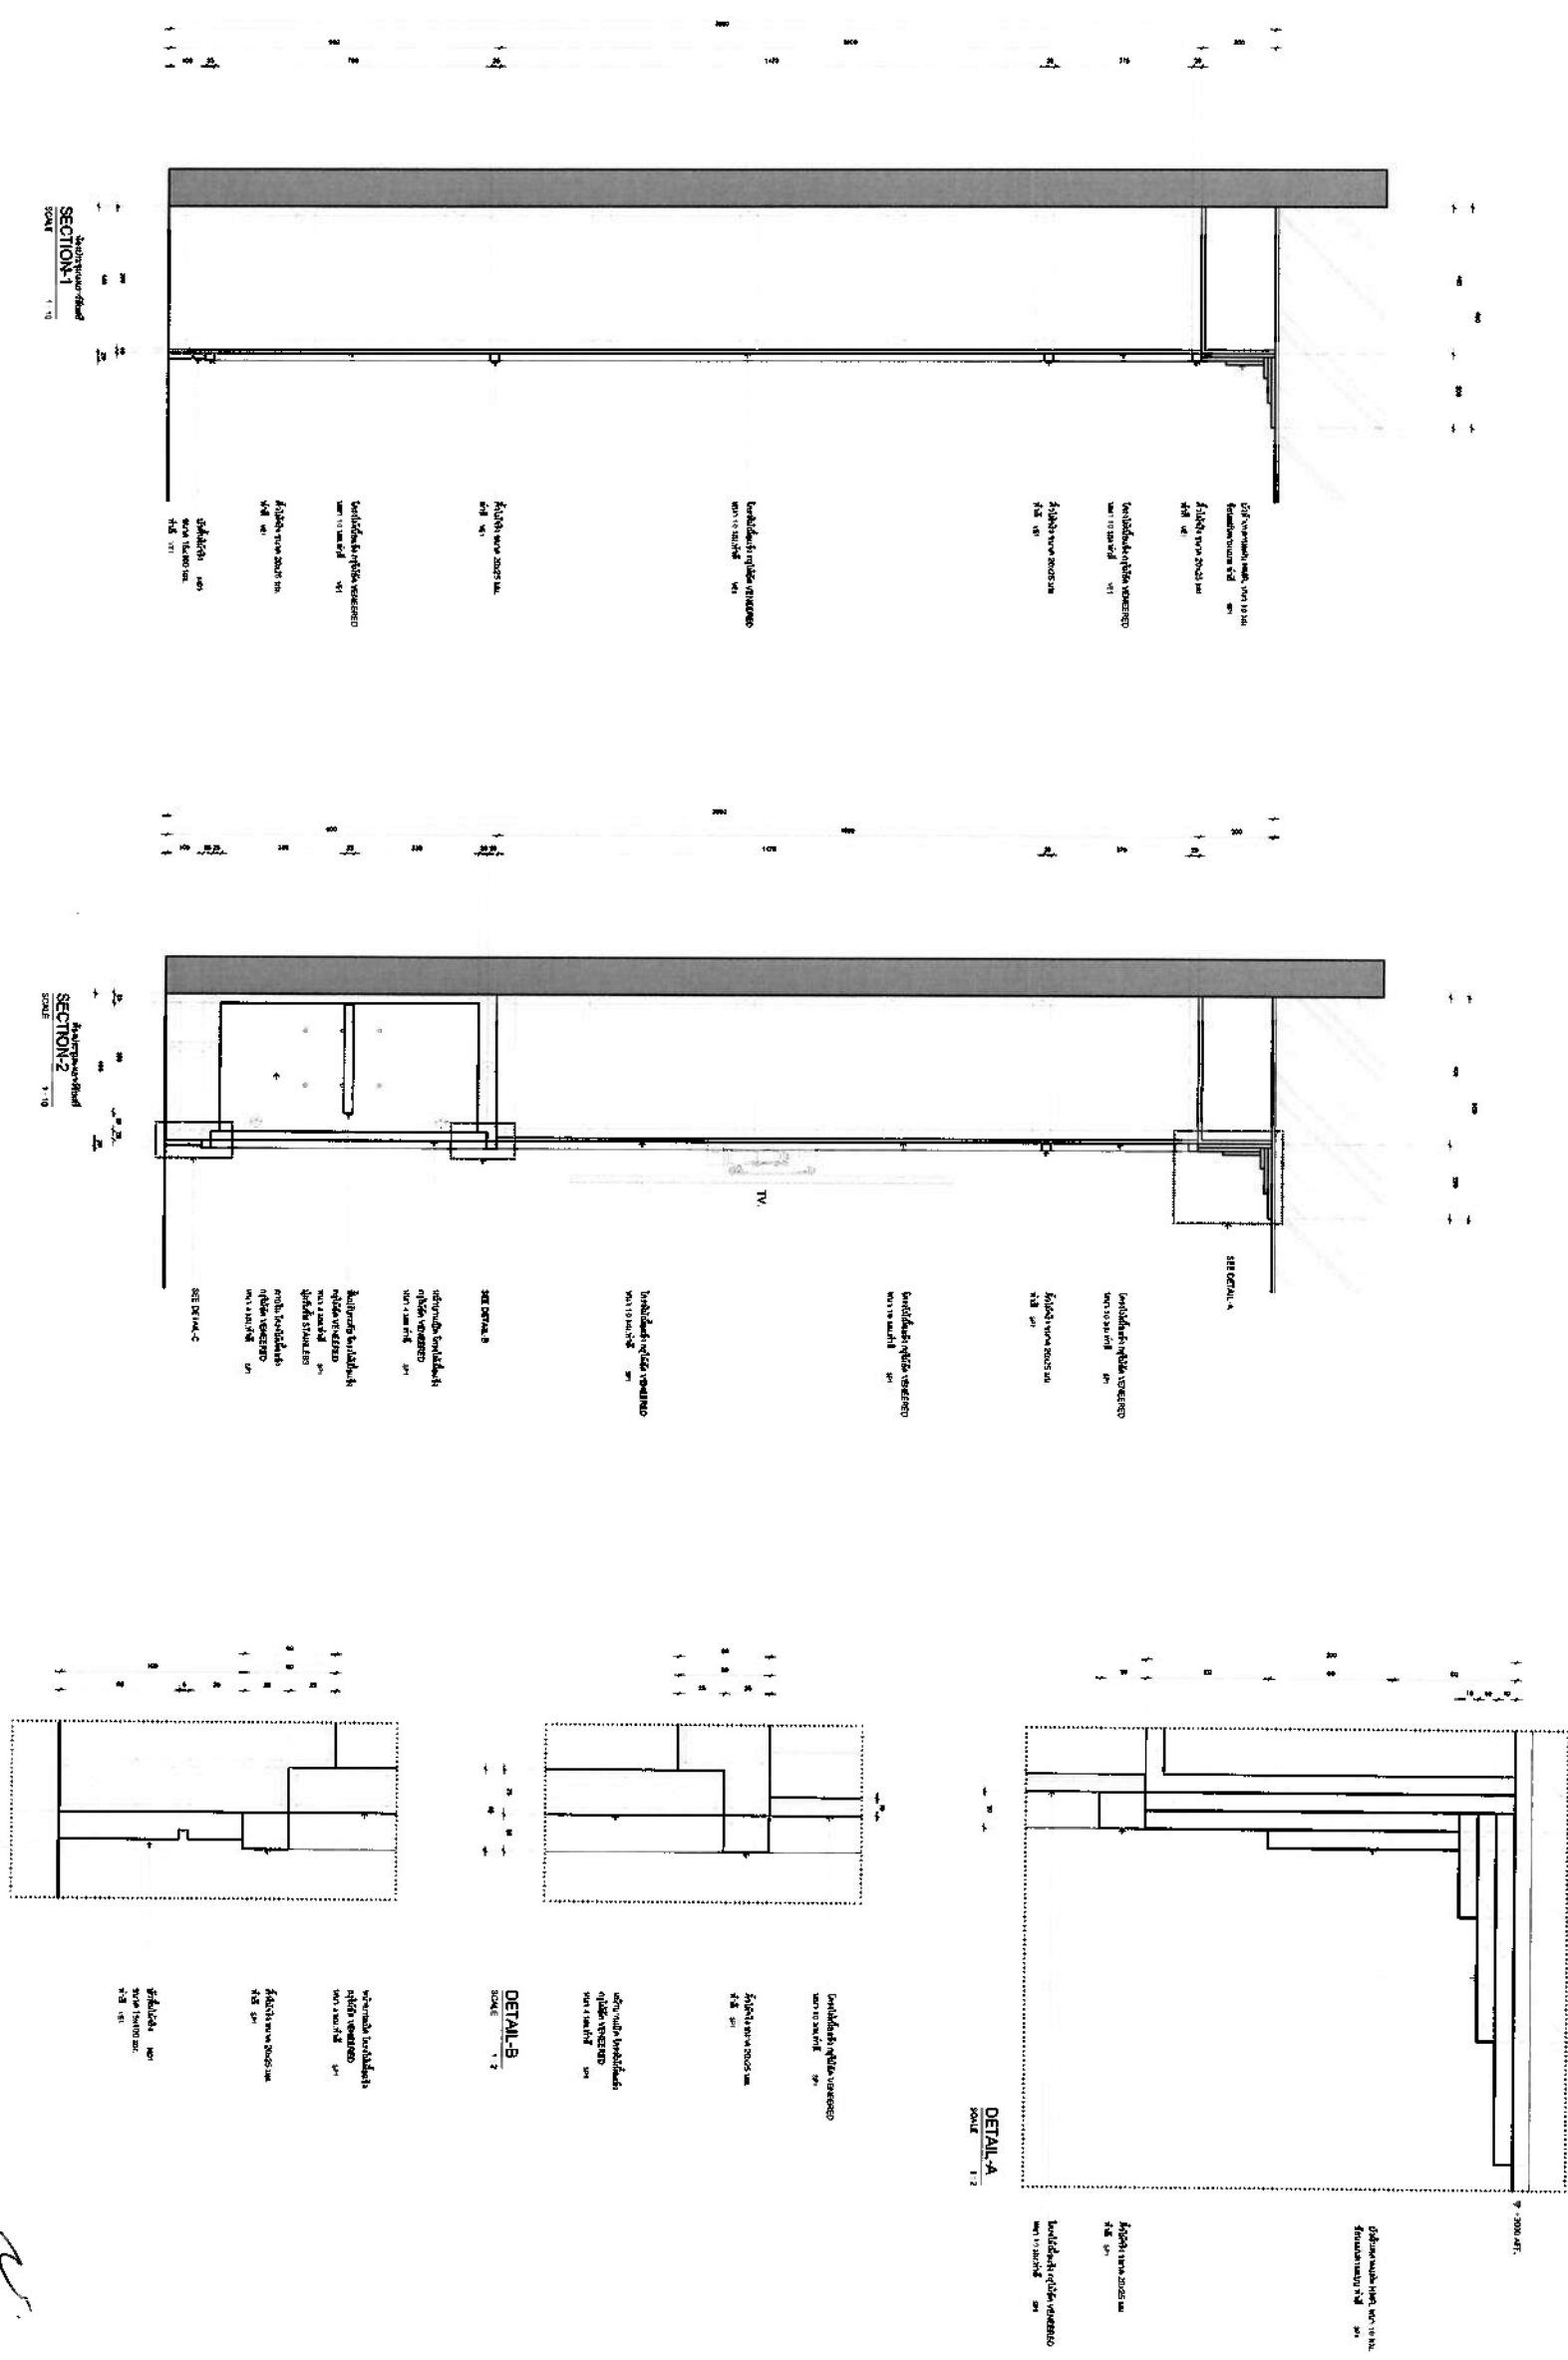

Handwritten notes and signatures in the bottom right corner of the drawing.

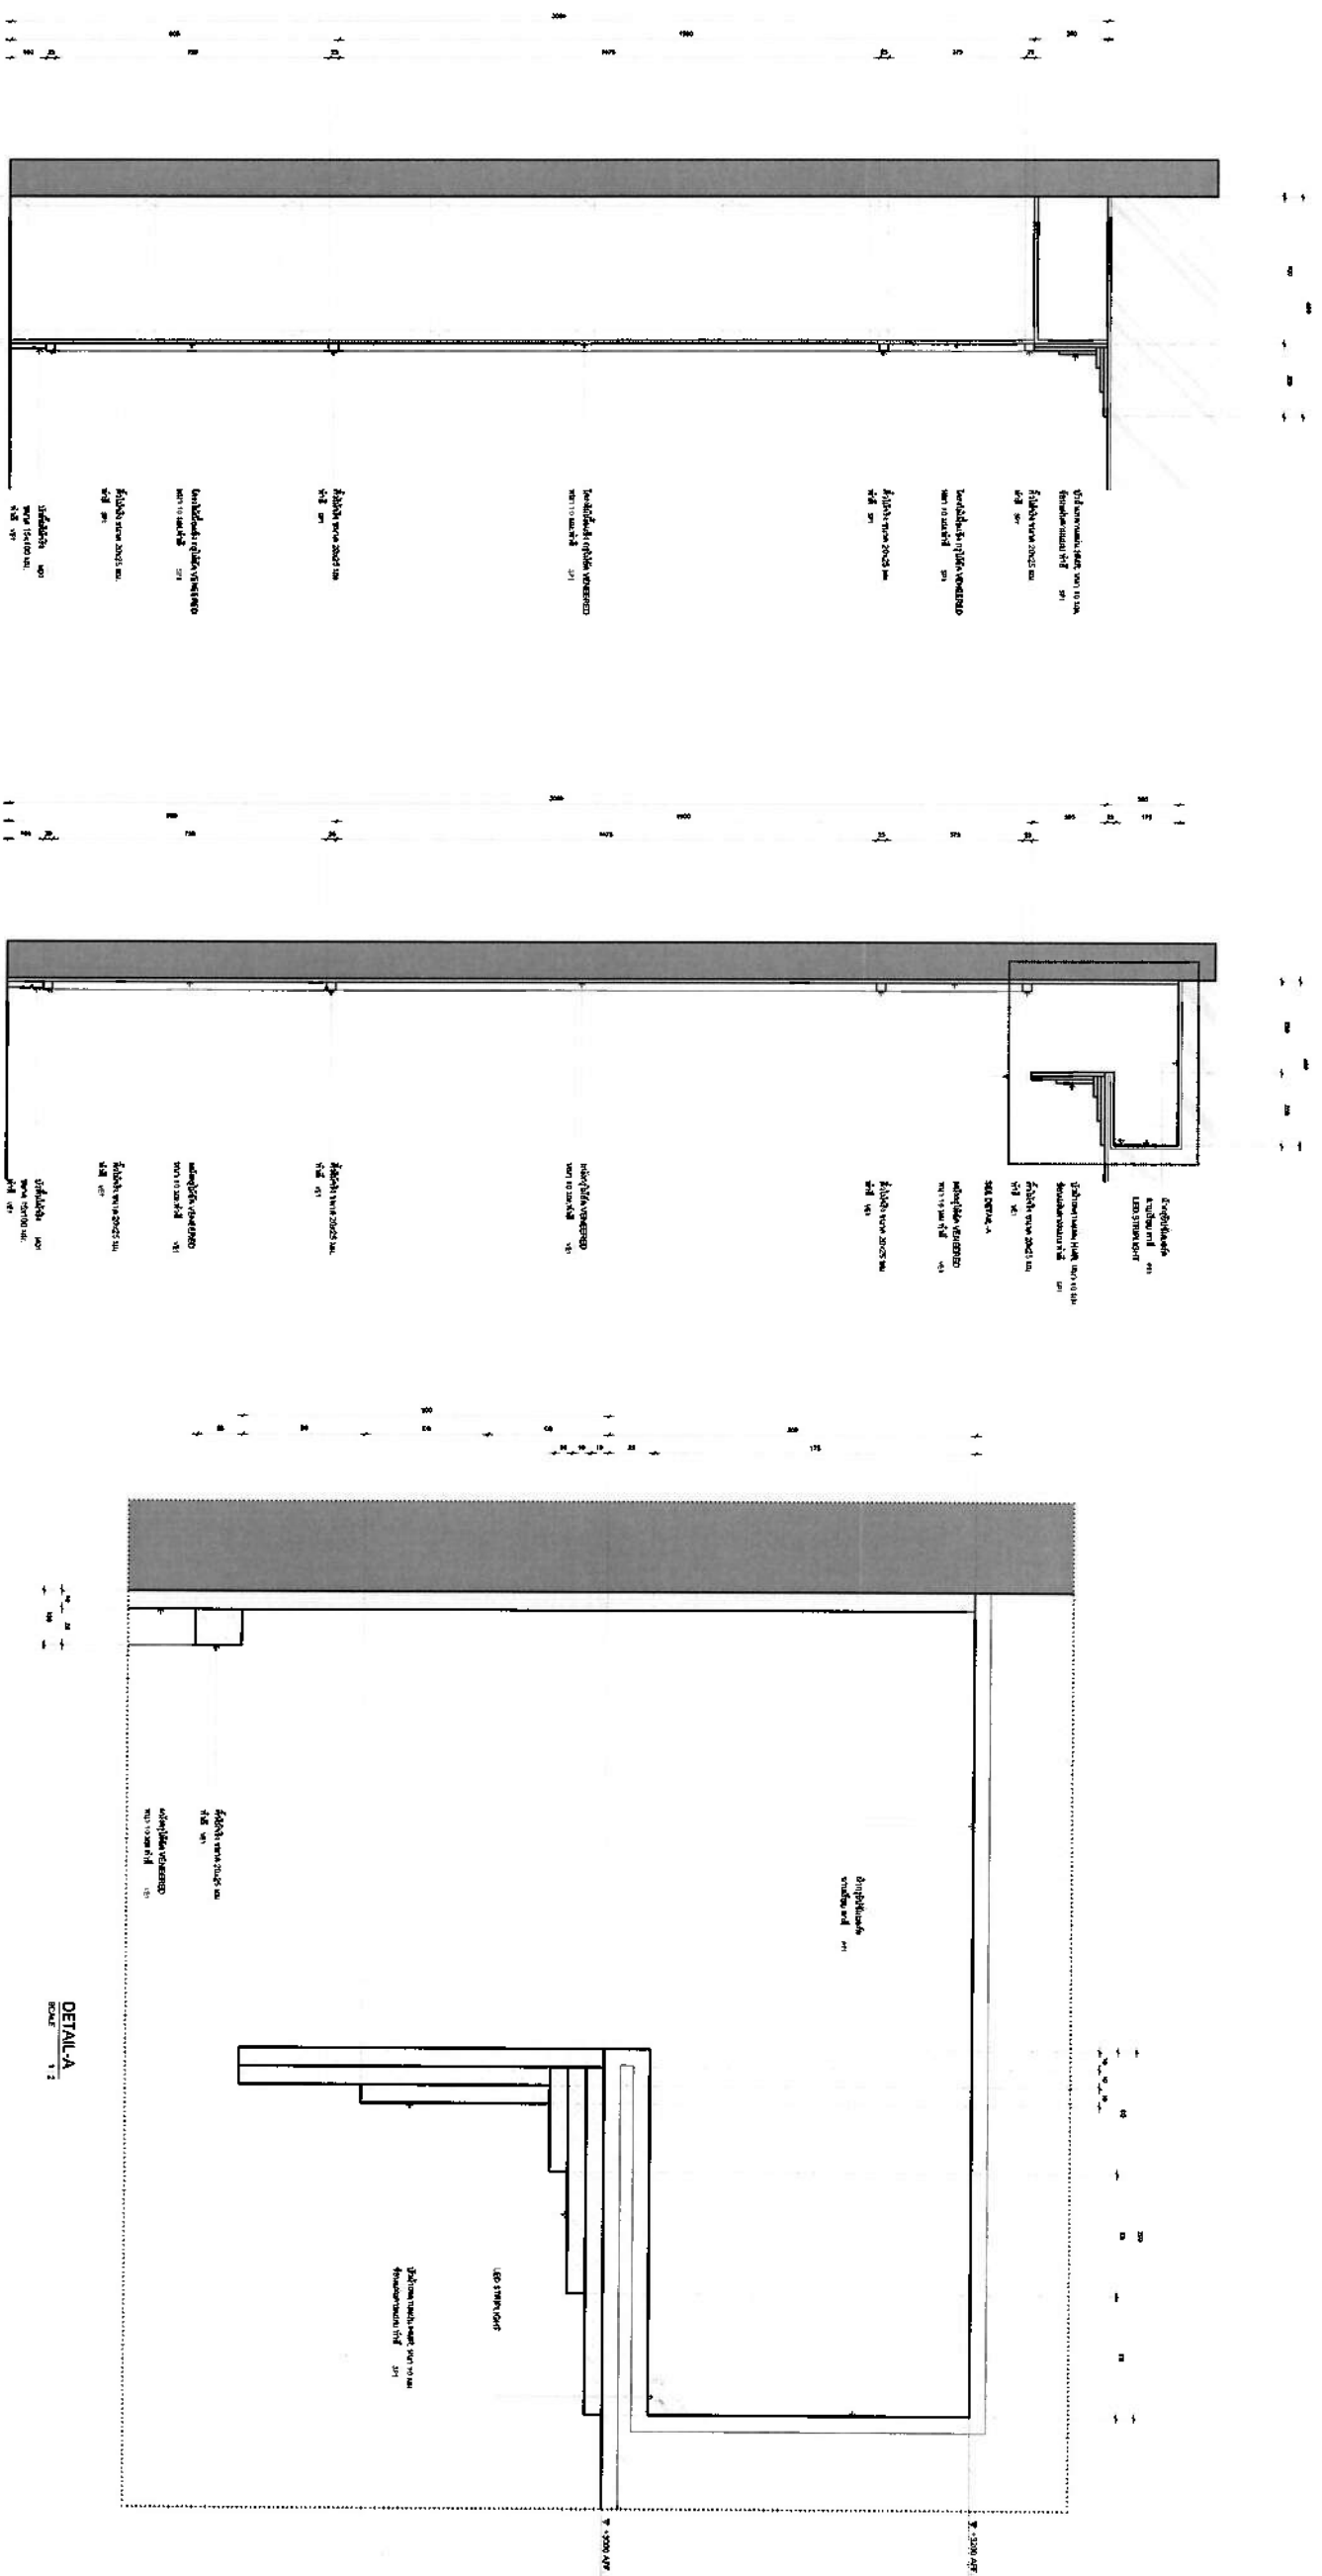

		PROJECT TITLE: 2nd FLOOR		DRAWING TITLE: SECTION 3, 4	
PROJECT NO.: IN-B-07-04		DATE: 1/10		SCALE: 1/10	
DESIGNER: [Signature]		CHECKED: [Signature]		DATE: 1/10	
LOCATION: [Text]		REVISION: NO. 1		SCALE: 1/10	
PROJECT TITLE: 2nd FLOOR		DRAWING TITLE: SECTION 3, 4		SCALE: 1/10	

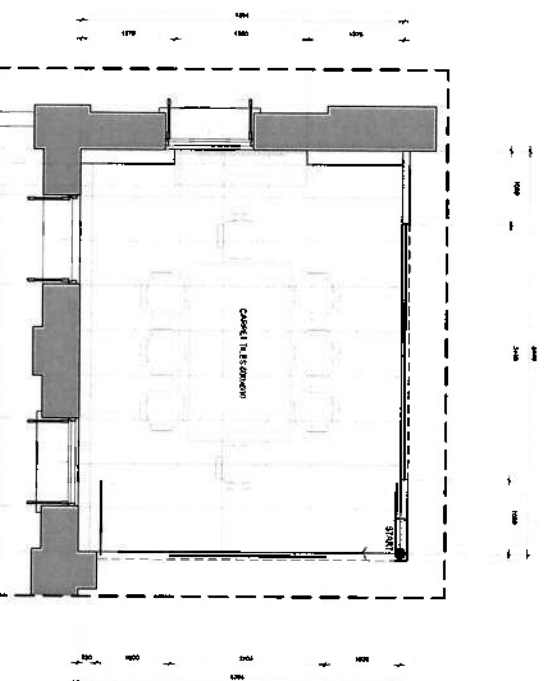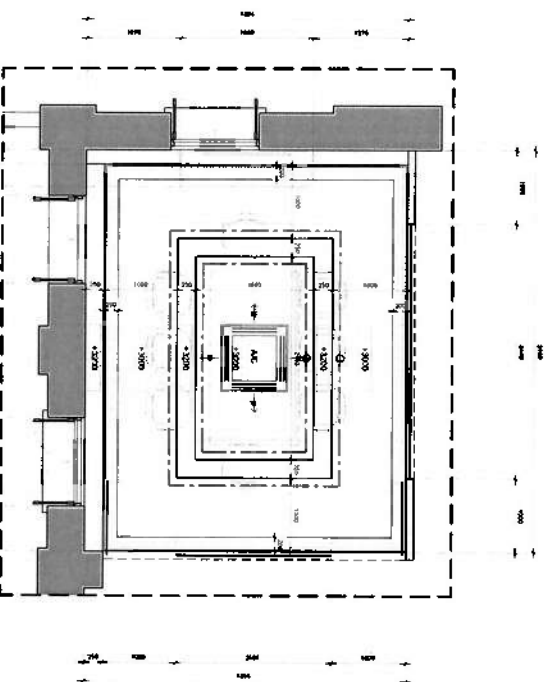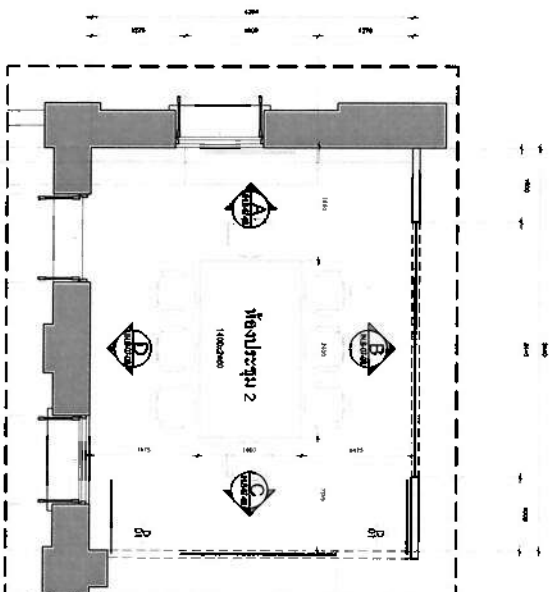

FURNITURE LAYOUT

CEILING, LIGHTING & AIR CONDITION LAYOUT

FLOOR FINISHED LAYOUT

 QIDR QIDR is a registered trademark of QIDR Inc. QIDR Inc. is a registered service mark of QIDR Inc. QIDR Inc. is a registered trademark of QIDR Inc. QIDR Inc. is a registered trademark of QIDR Inc.		PROJECT NO. : IN-B-07-05 DATE : 11/11/05 BY : IN-B-07-05 CHECKED : IN-B-07-05 SCALE : 1/8" = 1'-0" DRAWING NO. : IN-B-07-05	
PROJECT TITLE : 2nd FLOOR FINISHED LAYOUT LOCATION : 2nd FLOOR NOTES : 1. SEE 1st FLOOR FINISHED LAYOUT FOR DETAILS.		REVISION : NO. 1 DATE : 11/11/05 BY : IN-B-07-05 CHECKED : IN-B-07-05	
PROJECT NO. : IN-B-07-05 DATE : 11/11/05 BY : IN-B-07-05 CHECKED : IN-B-07-05		REVISION : NO. 1 DATE : 11/11/05 BY : IN-B-07-05 CHECKED : IN-B-07-05	

[illegible]

PROJECT TITLE:	Intermittent, self-induced, and organic withdrawal in a mixed group of young adults with chronic substance abuse (1999-2000)
LOCATION:	University of Michigan Medical Center, Ann Arbor, Michigan Department of Psychiatry, University of Michigan Medical Center, Ann Arbor, Michigan 48106


DRAWING TITLE:
 1/2"=1'-0"
 ELEVATION-A, B, C, D
 CEILING DETAIL-CD1, CD2

REVISION :	
NO	DESCRIPTION


NOTE :

JOB NO. :	
SCALE :	
DRAWN :	


CHECKED:	
By User/Technician	
DRAWING NO.:	
IN.B-07-06	

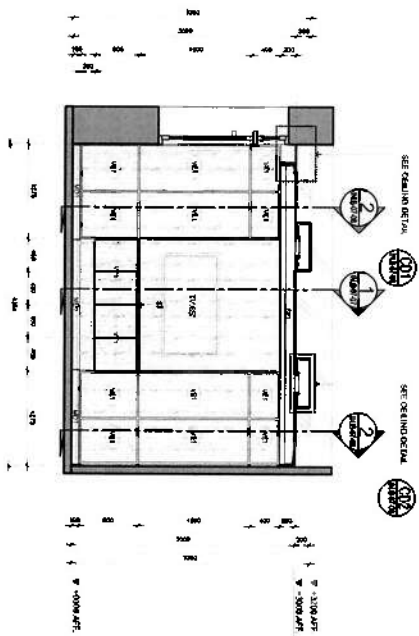


Northrup?
ELEVATION-A
SCALE 1 50

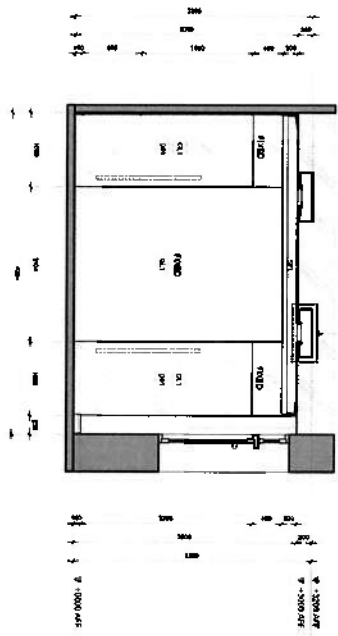


ELEVATION-C
SCALE 1:50

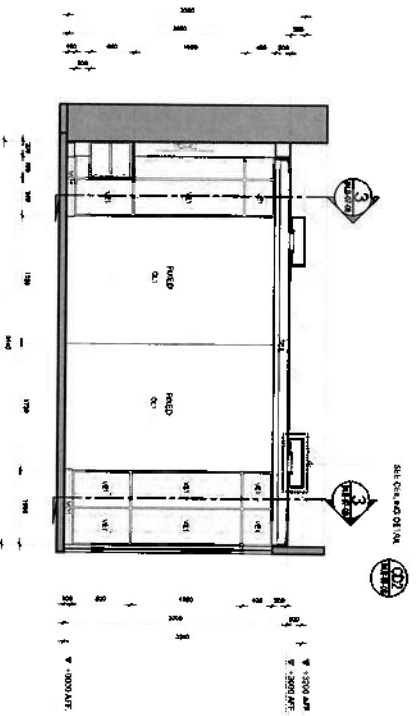


ELEVATION-B

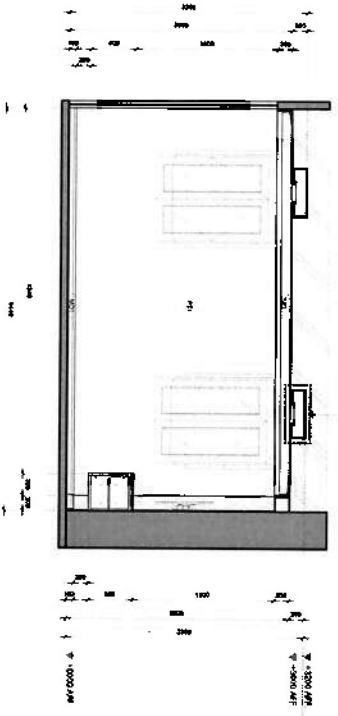

ELEVATION-D
9041 1:50

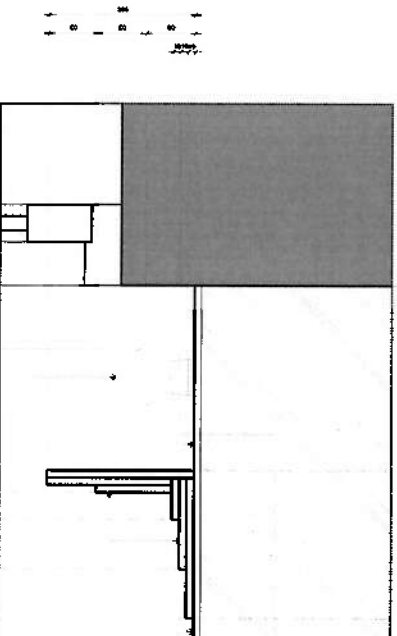



CEILING DETAIL-CD1

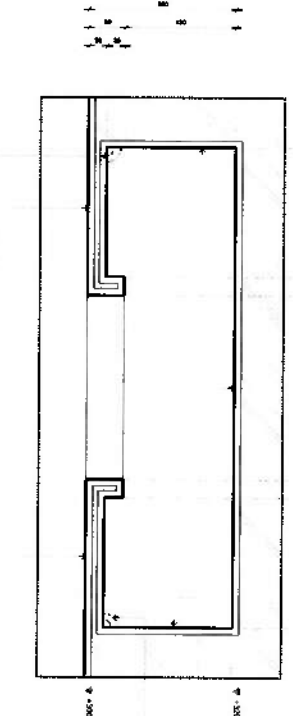

CEILING DETAIL-CD2


2.
Ed
Jr
Jr
Jr

2

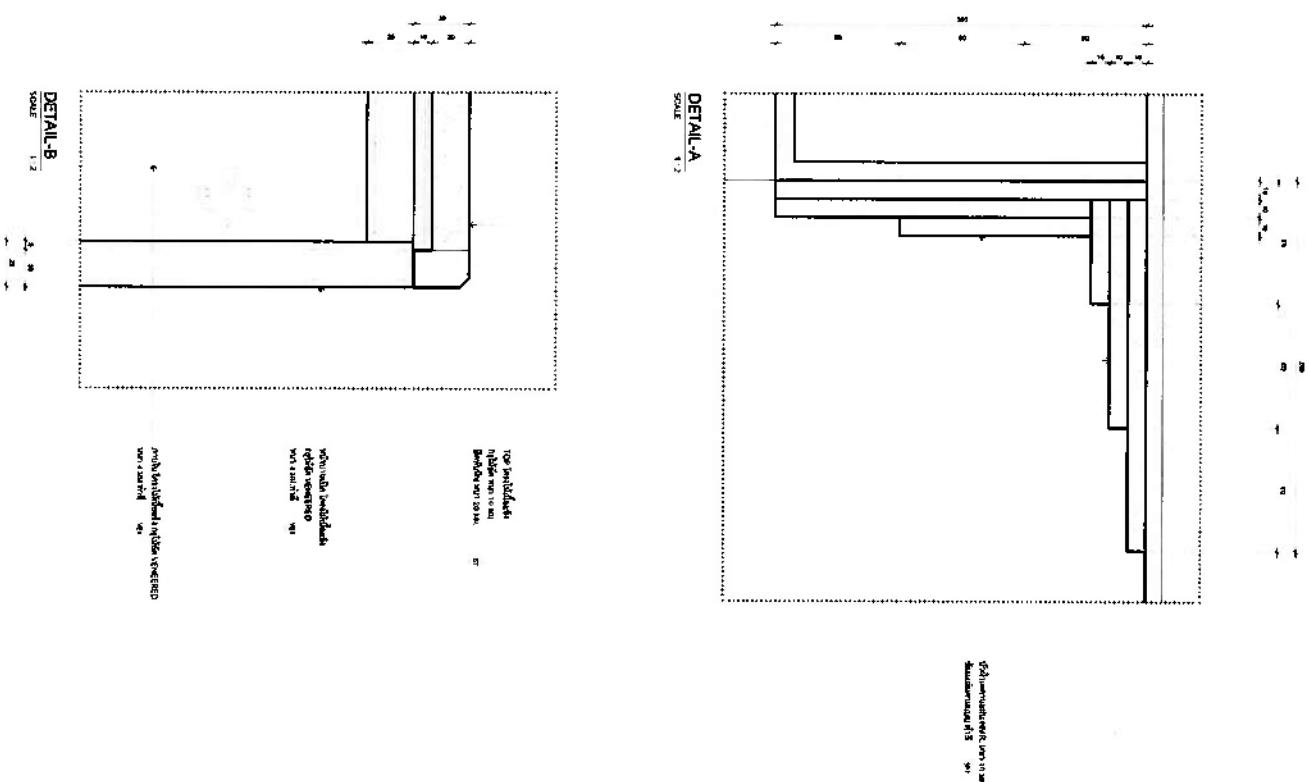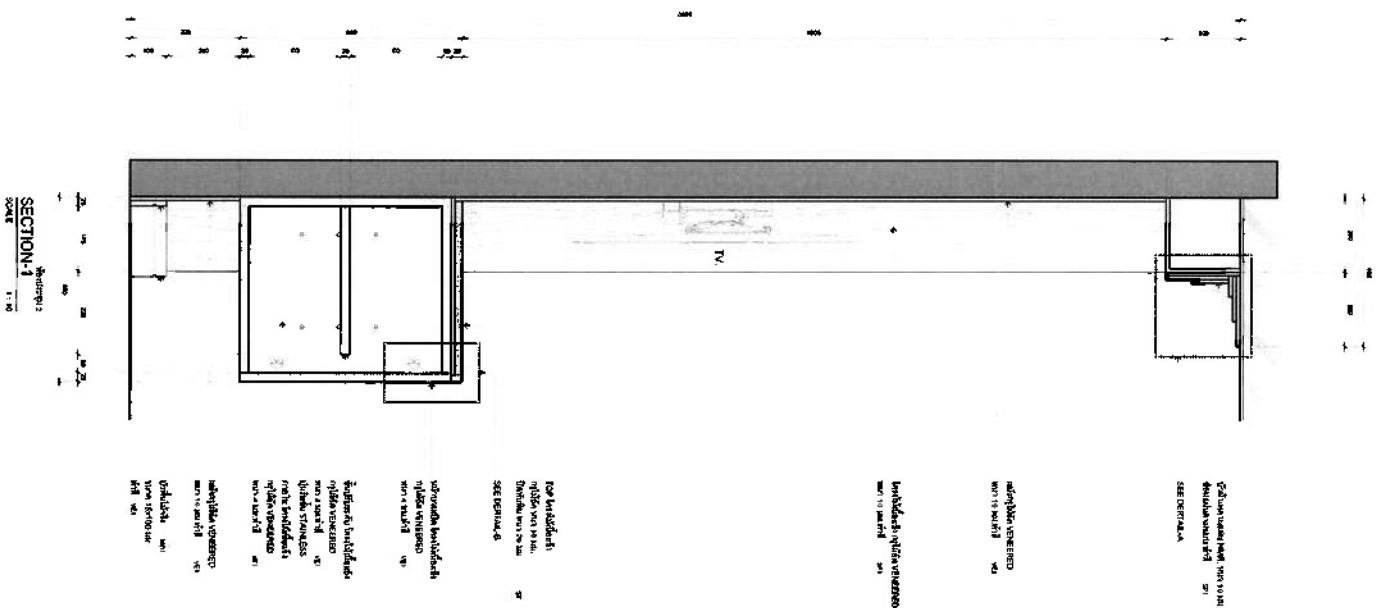
[illegible][illegible]

2.
 1900
 1901
 1902
 2353




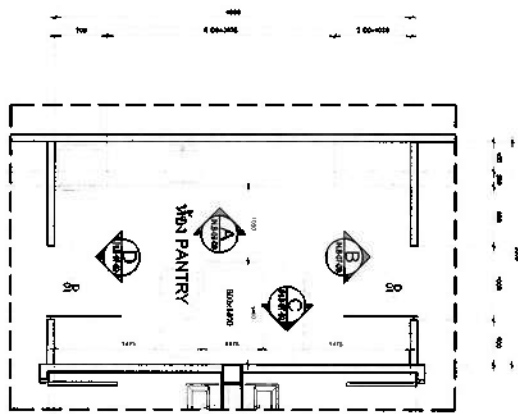


FURNITURE LAYOUT
SCALE: 1/8" = 1'-0"

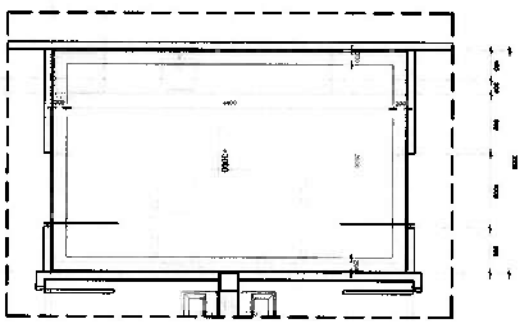


CEILING LIGHTING & AIR CONDITION LAYOUT
SCALE: 1/8" = 1'-0"

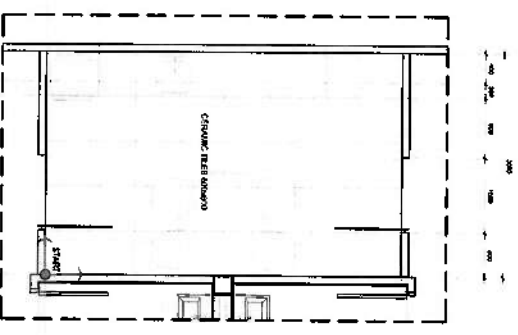


FLOOR FINISHED LAYOUT
SCALE: 1/8" = 1'-0"

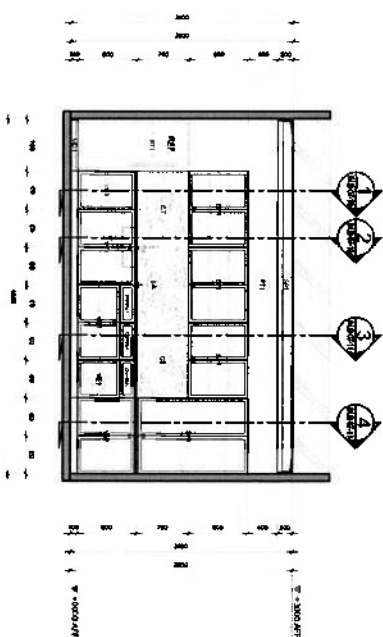


ELEVATION A
SCALE: 1/8" = 1'-0"

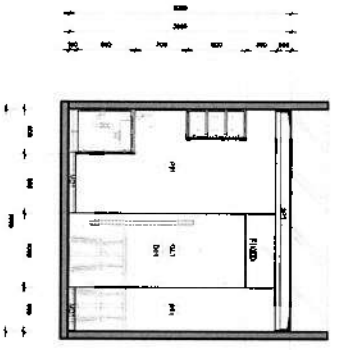


ELEVATION B
SCALE: 1/8" = 1'-0"

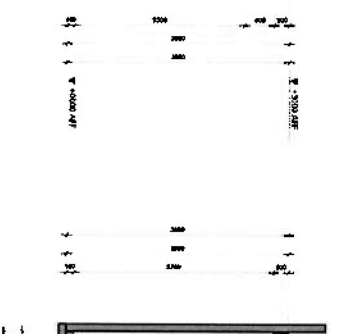

ELEVATION C
SCALE: 1/8" = 1'-0"

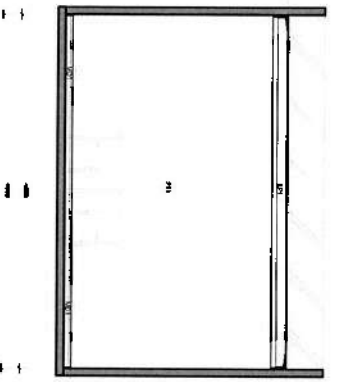


ELEVATION D
SCALE: 1/8" = 1'-0"

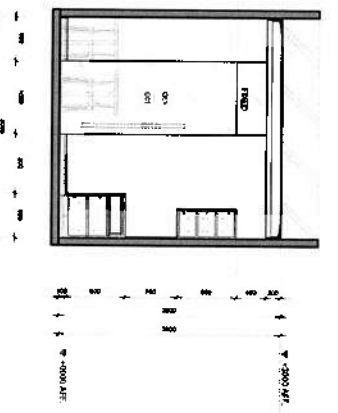

ELEVATION E
SCALE: 1/8" = 1'-0"

OWNER: 1. Owner's Name: <i>John Doe</i> 2. Owner's Address: <i>123 Main St, Anytown, CA 90210</i> 3. Owner's Phone: <i>(555) 123-4567</i> 4. Owner's Email: <i>john.doe@example.com</i>		DESIGNER: 1. Designer's Name: <i>John Doe</i> 2. Designer's Address: <i>123 Main St, Anytown, CA 90210</i> 3. Designer's Phone: <i>(555) 123-4567</i> 4. Designer's Email: <i>john.doe@example.com</i>	
PROJECT TITLE: 1. Project Name: <i>1st Floor Pantry</i> 2. Project Address: <i>123 Main St, Anytown, CA 90210</i> 3. Project Phone: <i>(555) 123-4567</i> 4. Project Email: <i>john.doe@example.com</i>		DATE: 1. Date: <i>10/20/2023</i> 2. Time: <i>10:00 AM</i> 3. Location: <i>123 Main St, Anytown, CA 90210</i> 4. Notes: <i>See attached drawings for details.</i>	
REVISIONS: 1. Revision: <i>1</i> 2. Description: <i>Added notes to drawing.</i> 3. Date: <i>10/20/2023</i> 4. By: <i>John Doe</i>		SCALE: 1. Scale: <i>1/8" = 1'-0"</i> 2. Drawing No.: <i>IN-B-07-09</i>	





Handwritten notes and signatures:
John Doe
John Doe
John Doe
John Doe

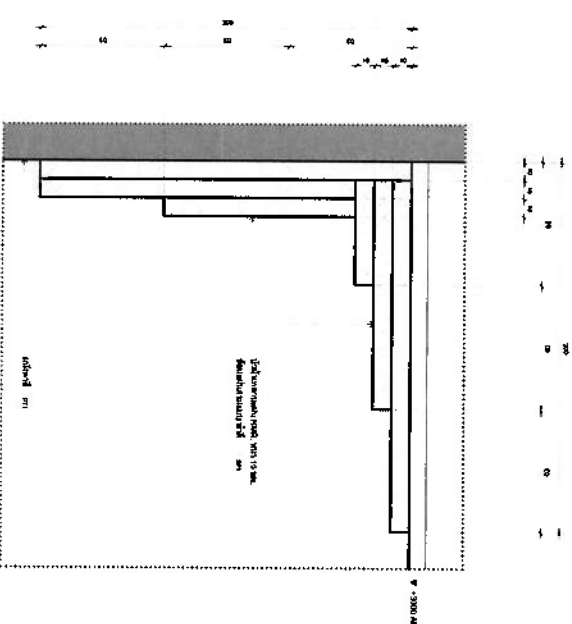


DETAIL-8



Scale 1" = 1'

2007-2008
 2009-2010
 2011-2012
 2589-2590
 2591-2

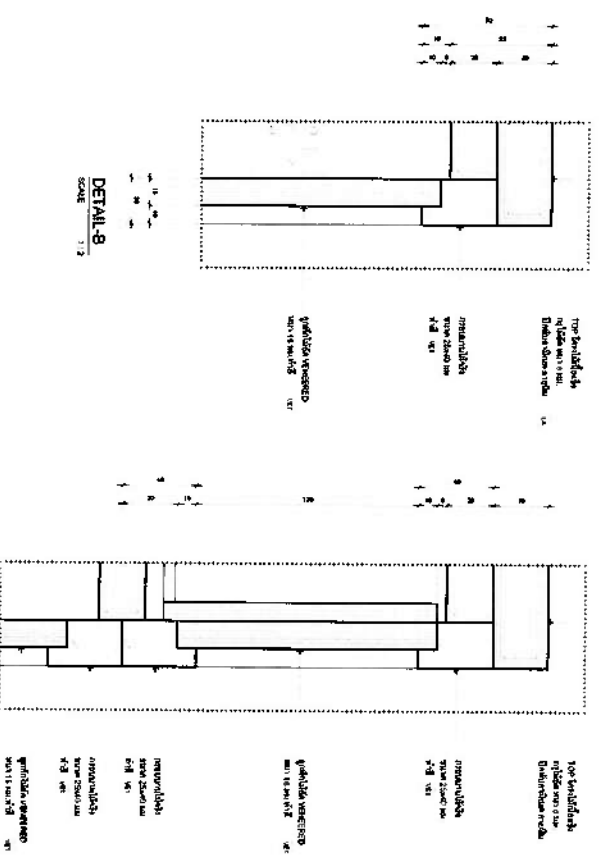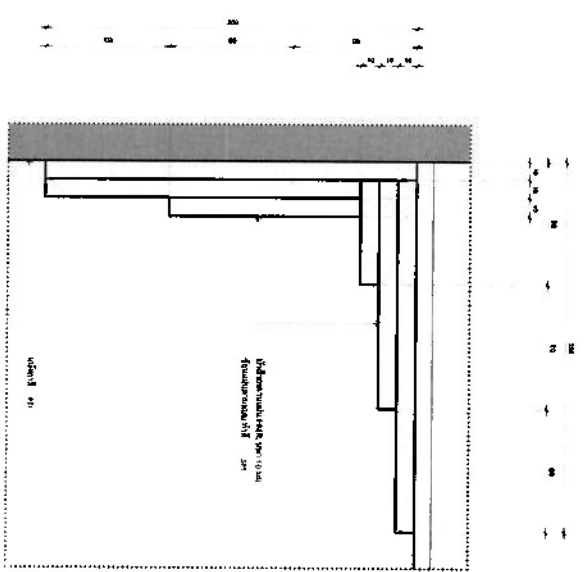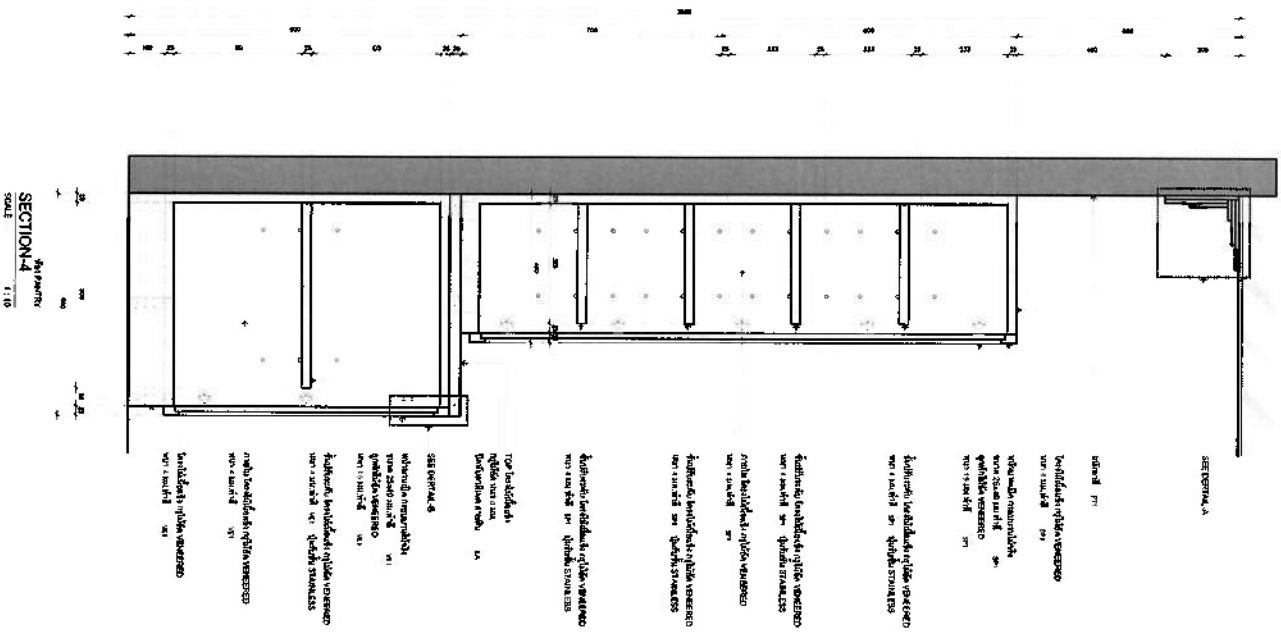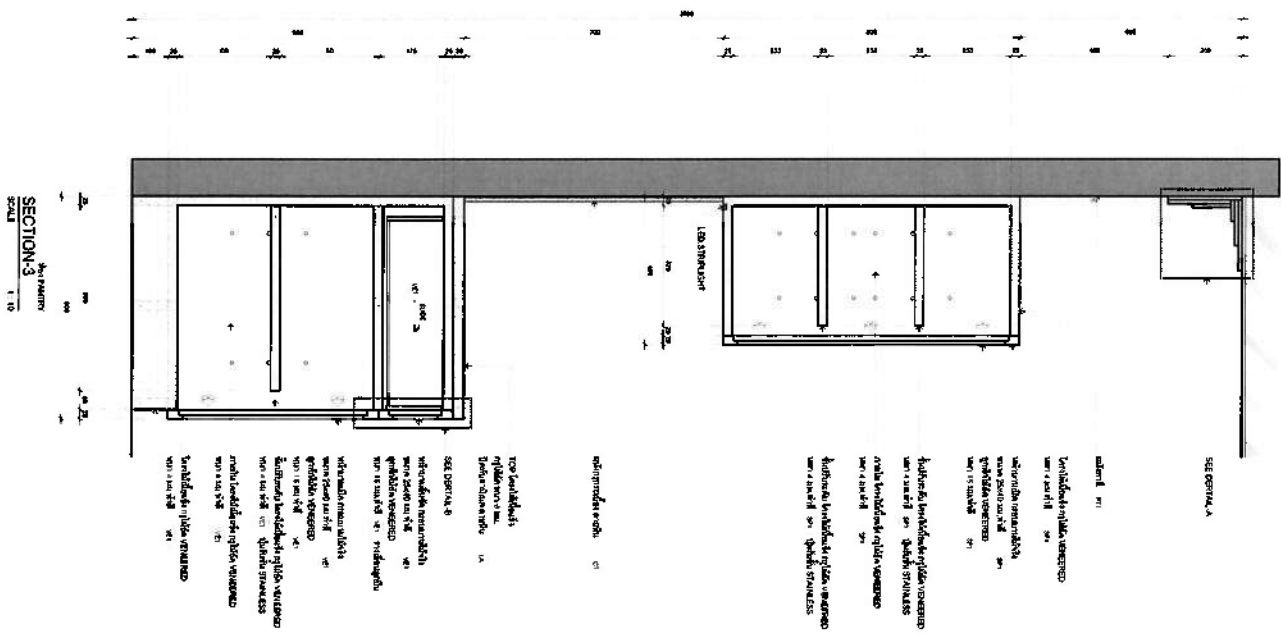

12

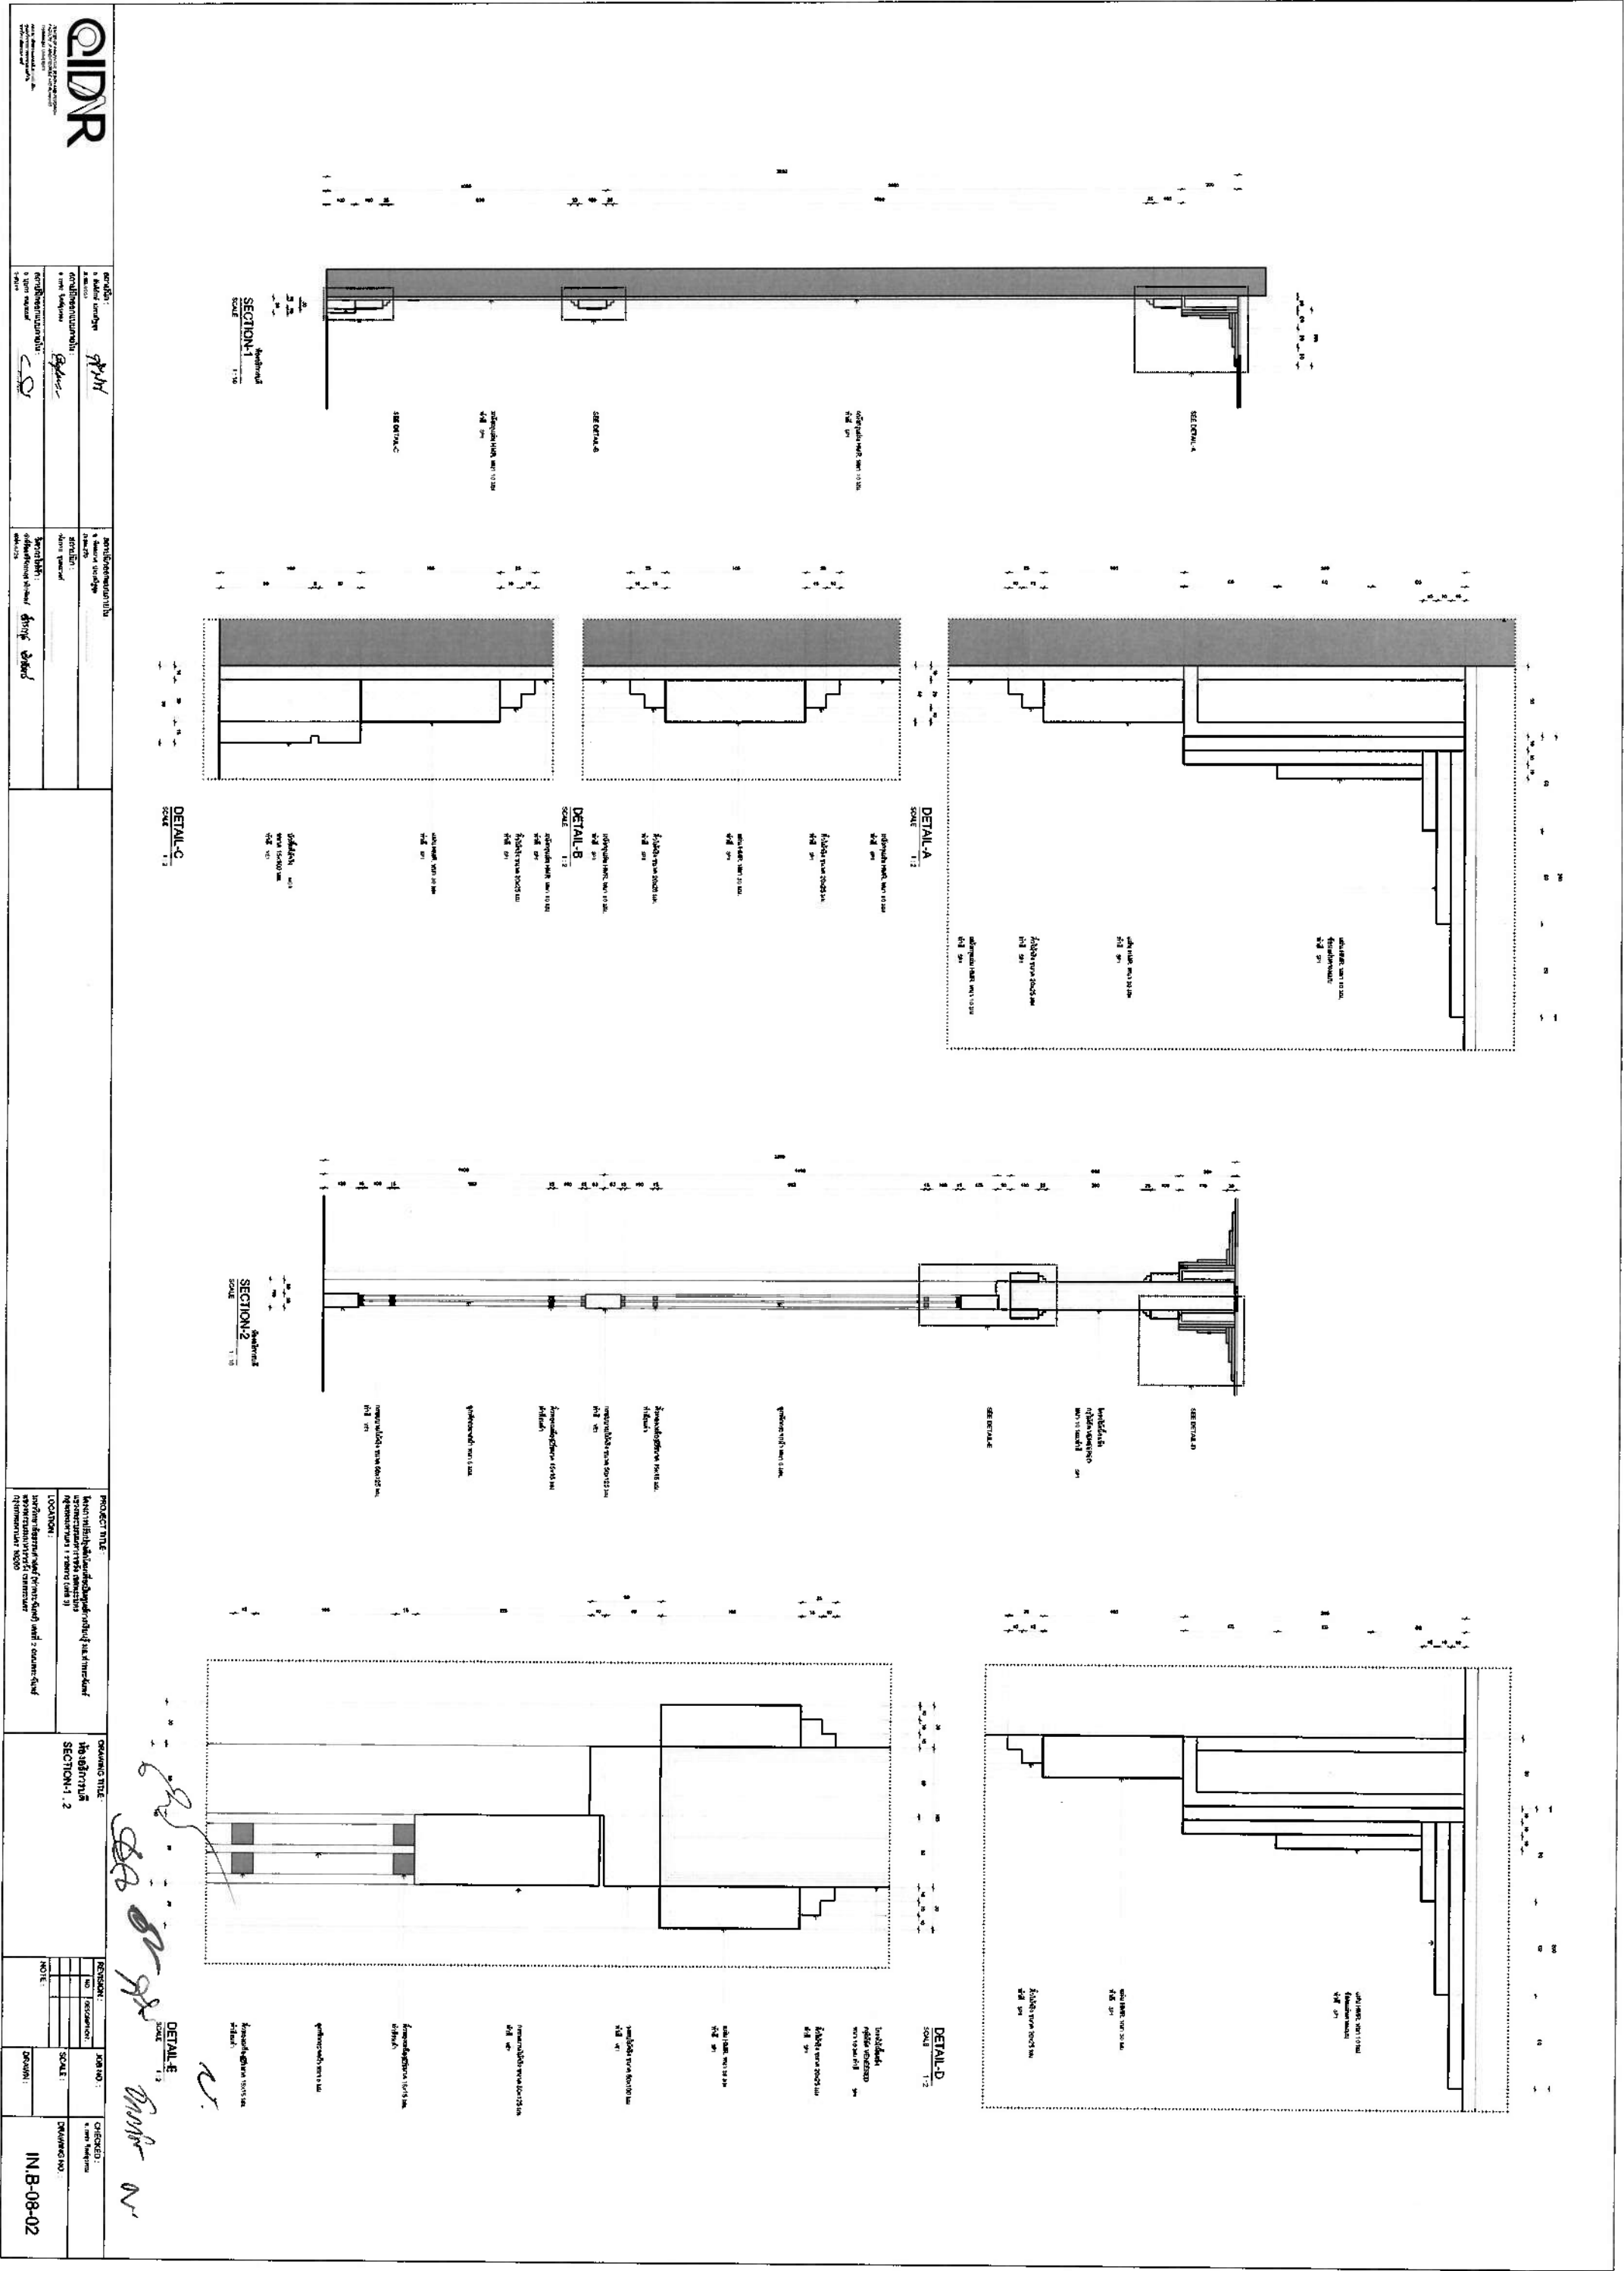

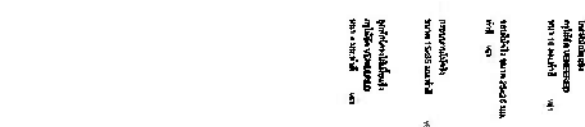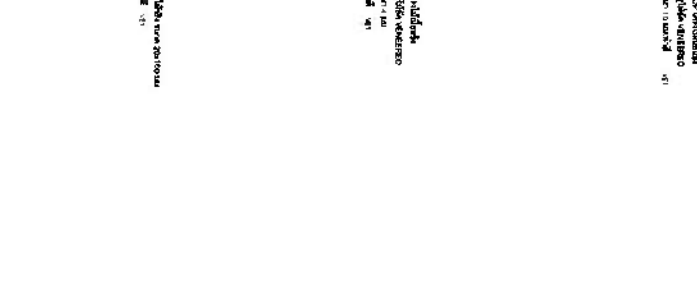


10/14/2014

பிழைப்புகள்

ms


DRAWING TITLE: หน้าตัดทาง P888 DETAIL (หน้าตัดบันไดเลื่อนทางขึ้น)	REVISION:		JOB NO.:	C/DISCOD: 1. ย่อ 2. คำเต็ม	DRAWING NO.:
	NO.	DESCRIPTION			
NOTE:	SCALE:		DRAWN:		IN.B-08-03

FB44 DETAIL (ตู้เก็บเชื้อฯ)

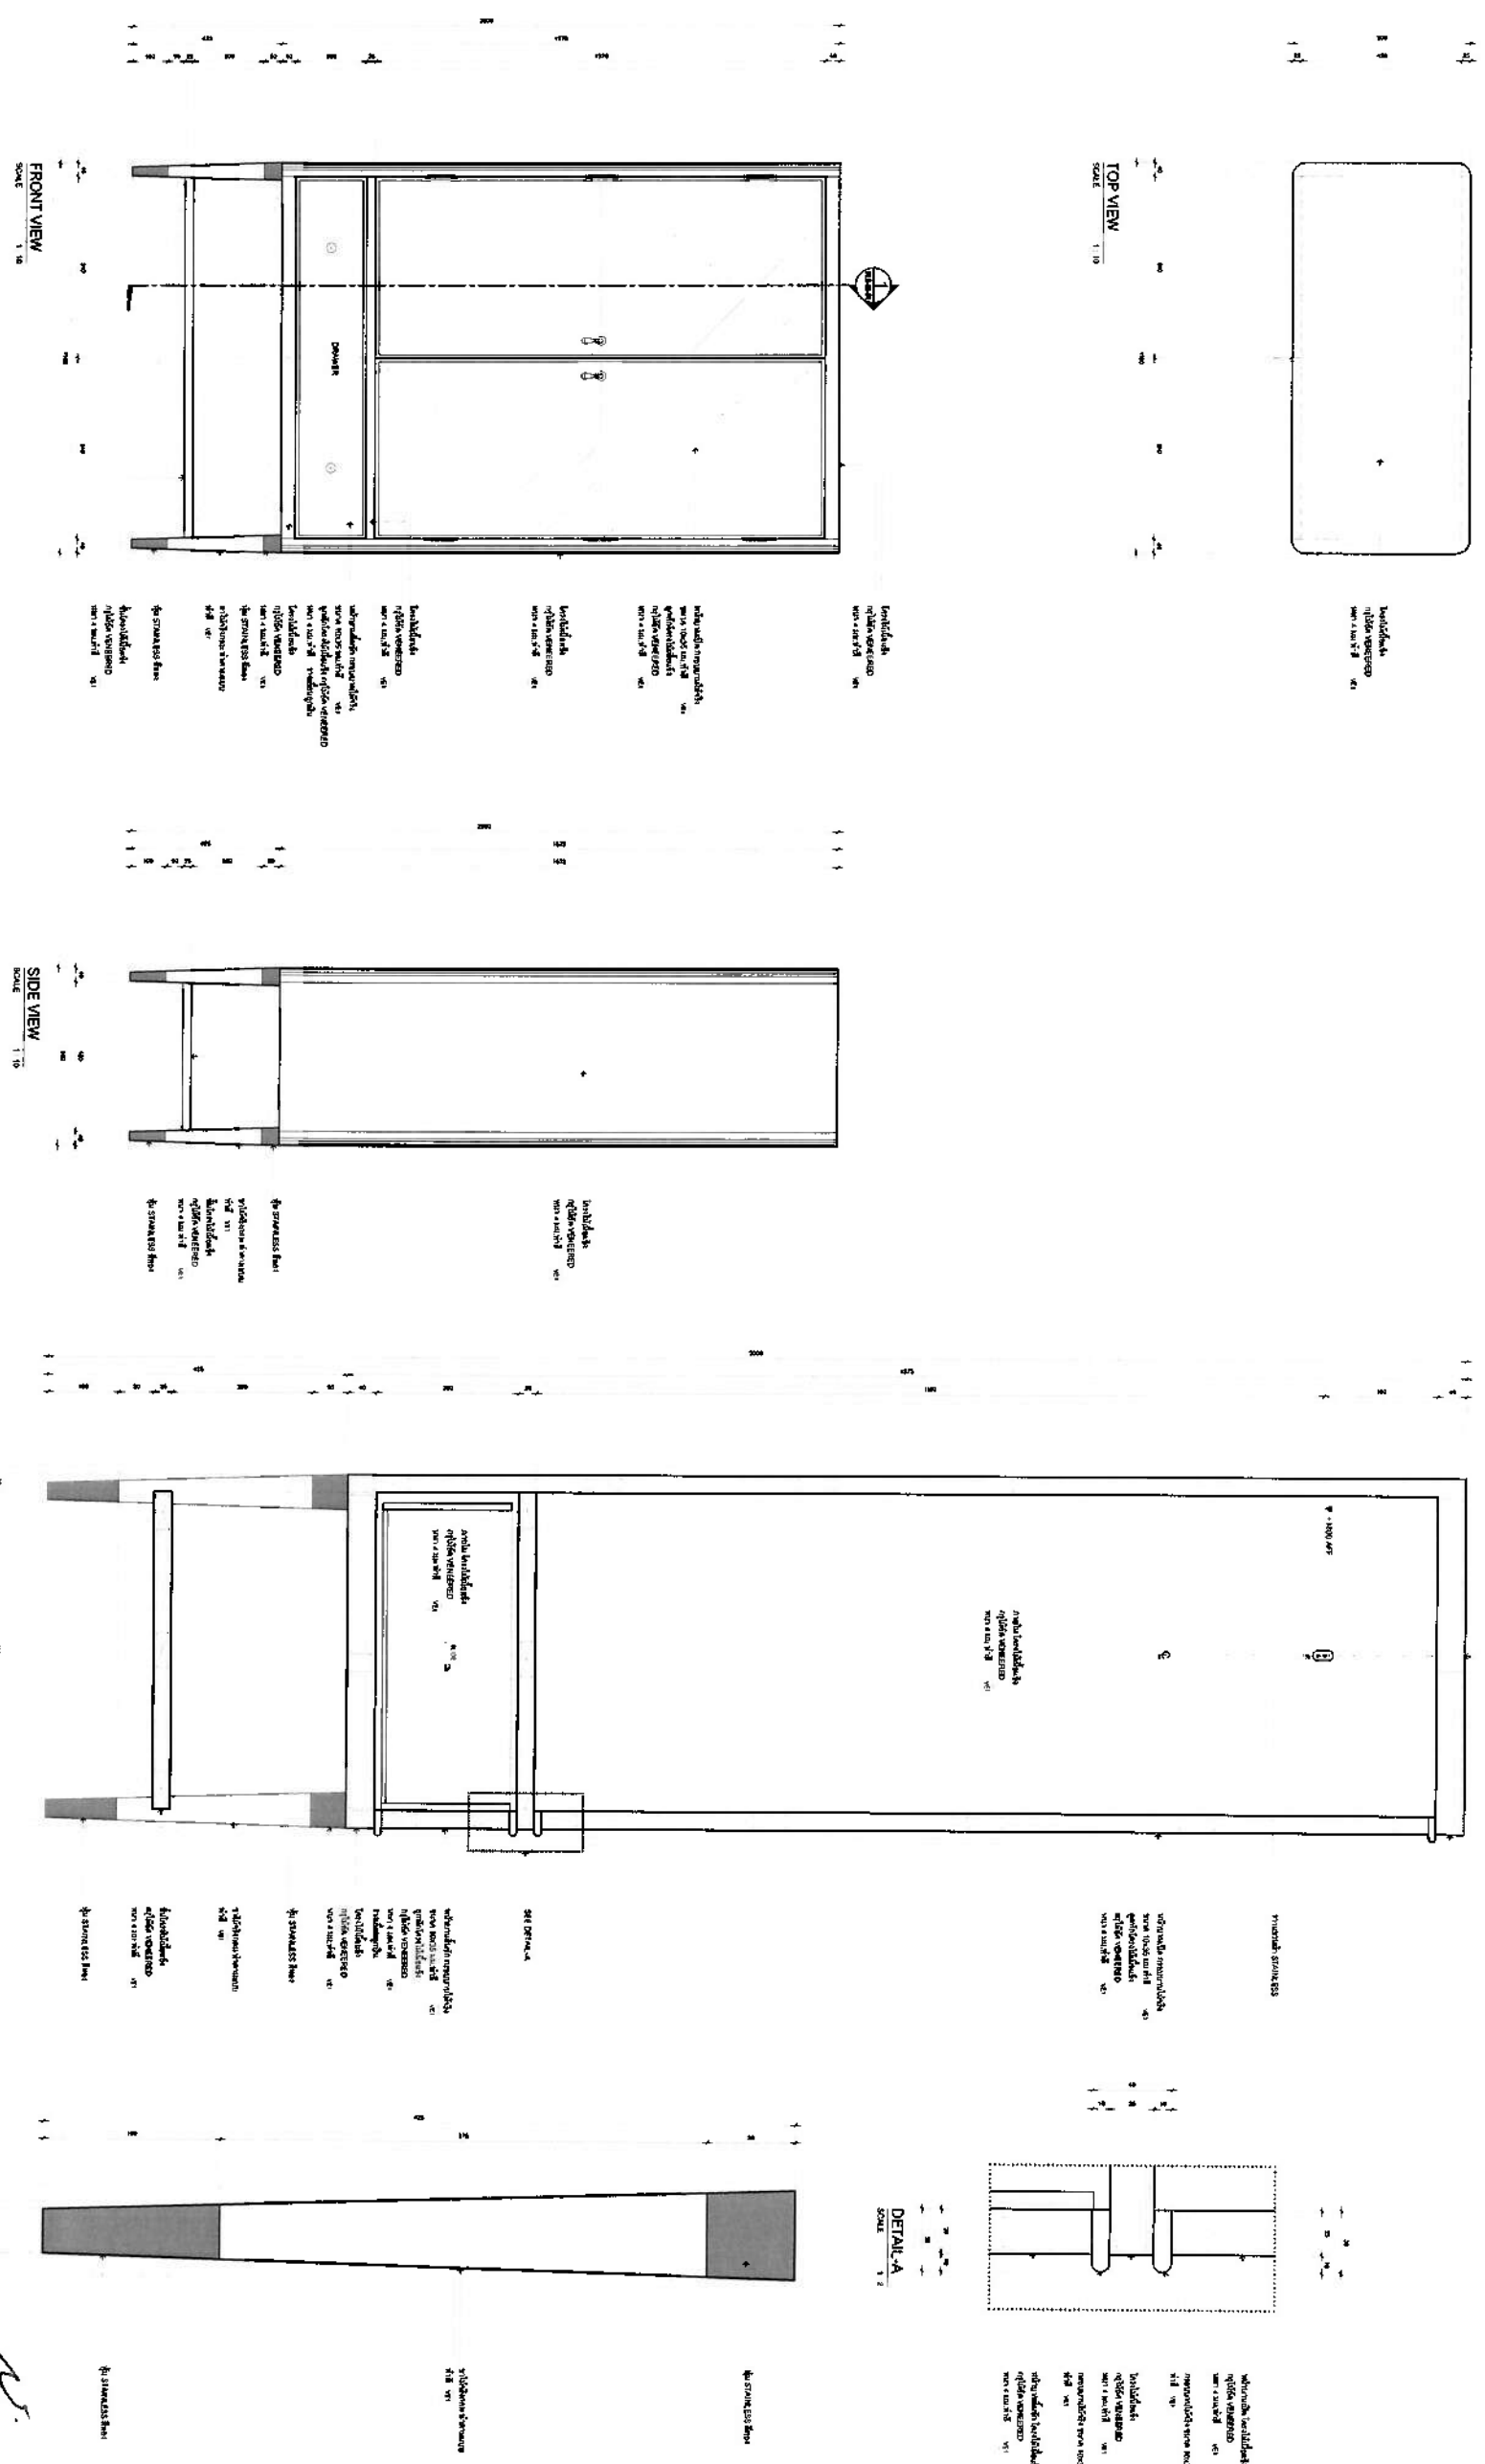


PROJECT TITLE: FB44 DETAIL (ตู้เก็บเชื้อฯ)	PROJECT TITLE: FB44 DETAIL (ตู้เก็บเชื้อฯ)
LOCATION: FB44 DETAIL (ตู้เก็บเชื้อฯ)	LOCATION: FB44 DETAIL (ตู้เก็บเชื้อฯ)
DATE: 11/11/2023	DATE: 11/11/2023
DESIGNED BY: IN-B-08-04	DESIGNED BY: IN-B-08-04
CHECKED BY: IN-B-08-04	CHECKED BY: IN-B-08-04


F64 DETAIL (ตัวเก็บเอกสาร)

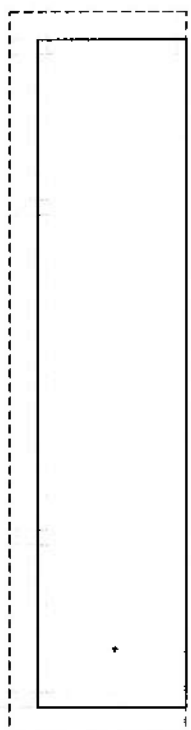


TOP VIEW
SCALE 1 : 10

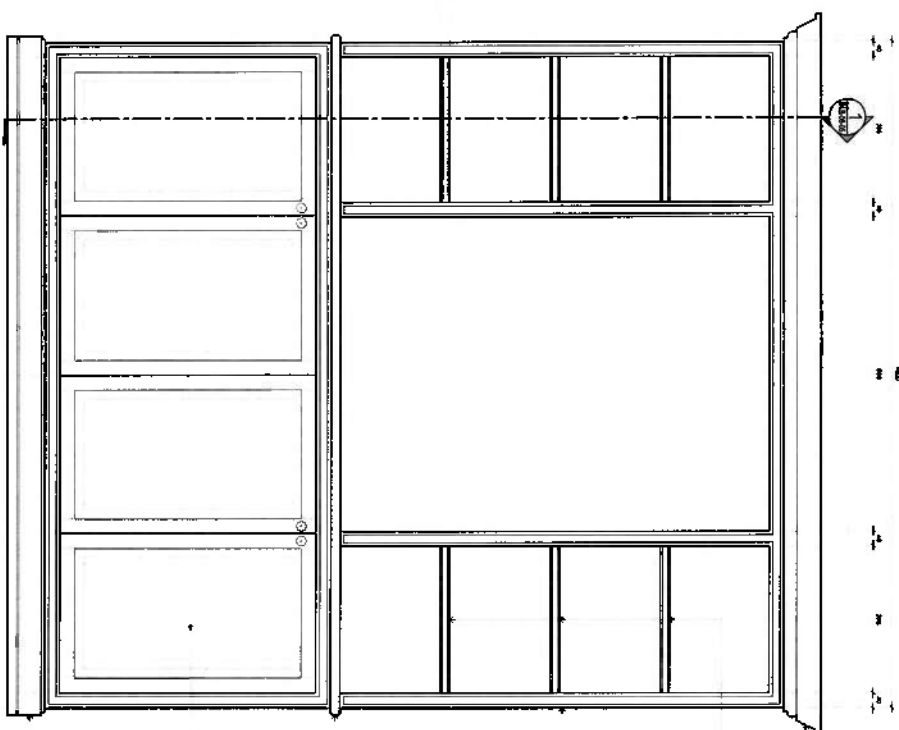


FRONT VIEW
SCALE 1" = 10"

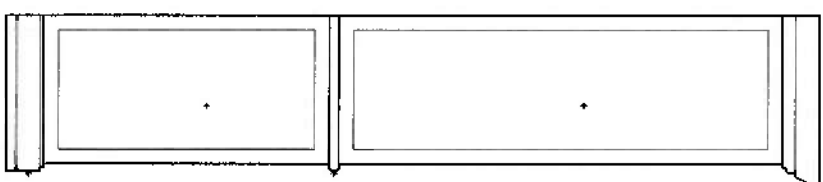


SIDE VIEW

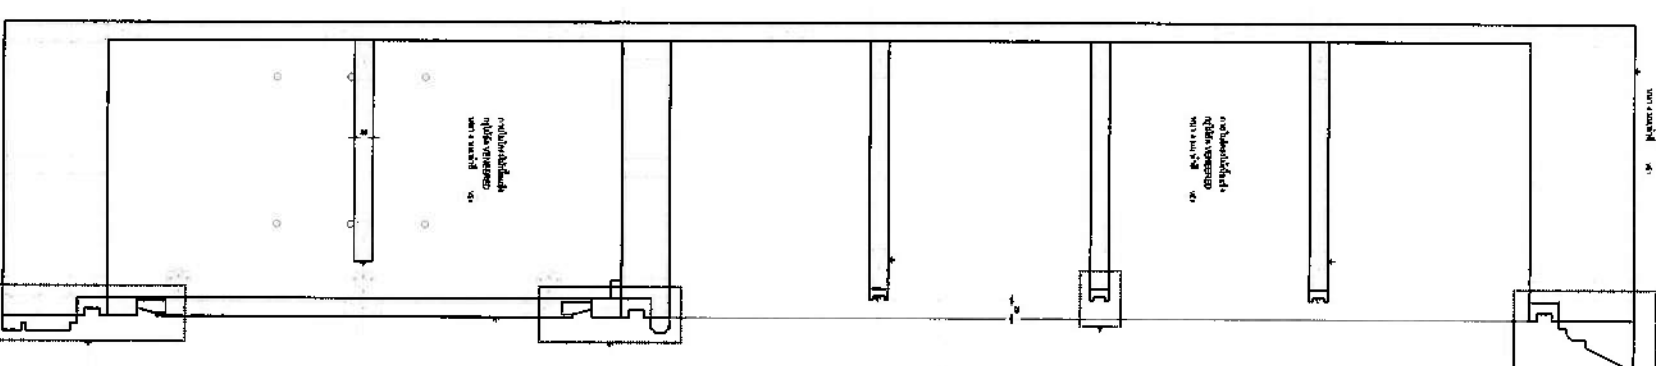


SECTION-1
SCORE 1

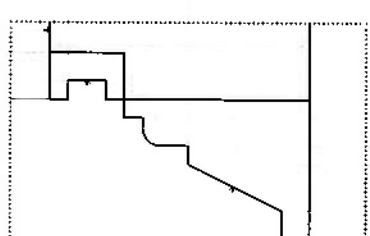


DETAIL-A
SCALE 1:1

 

DETAIL-B
SCALE 1"=1'-0"

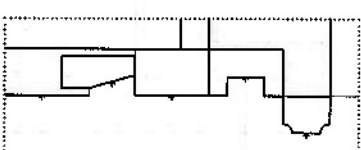

DETAIL-C
SCM 112

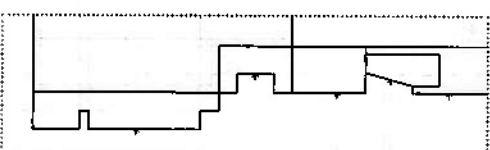

DETAIL-D
SCALE 1:2



QIDR

© 2004 by the American Psychological Association
0893-3200/04/\$12.00 DOI: 10.1037/0893-3200.19.1.105
Published online February 2, 2004

๑. ชื่อเรื่อง :
 ๒. เลขที่ / วันที่ :
 ๓. ๐๐๐๐๐๐ :
 ๔. ชื่อผู้จัดทำ :
 ๕. ชื่อ :
 ๖. ชื่อ :
 ๗. ชื่อ :
 ๑๐๐. ชื่อ :

Serotonin 5-HT 5-hydroxytryptamine 5-HTP 5-HT ₁ 5-HT ₂ 5-HT ₃ 5-HT ₄ 5-HT ₅ 5-HT ₆ 5-HT ₇ 5-HT ₈ 5-HT ₉ 5-HT ₁₀ 5-HT ₁₁ 5-HT ₁₂ 5-HT ₁₃ 5-HT ₁₄ 5-HT ₁₅ 5-HT ₁₆ 5-HT ₁₇ 5-HT ₁₈ 5-HT ₁₉ 5-HT ₂₀ 5-HT ₂₁ 5-HT ₂₂ 5-HT ₂₃ 5-HT ₂₄ 5-HT ₂₅ 5-HT ₂₆ 5-HT ₂₇ 5-HT ₂₈ 5-HT ₂₉ 5-HT ₃₀ 5-HT ₃₁ 5-HT ₃₂ 5-HT ₃₃ 5-HT ₃₄ 5-HT ₃₅ 5-HT ₃₆ 5-HT ₃₇ 5-HT ₃₈ 5-HT ₃₉ 5-HT ₄₀ 5-HT ₄₁ 5-HT ₄₂ 5-HT ₄₃ 5-HT ₄₄ 5-HT ₄₅ 5-HT ₄₆ 5-HT ₄₇ 5-HT ₄₈ 5-HT ₄₉ 5-HT ₅₀ 5-HT ₅₁ 5-HT ₅₂ 5-HT ₅₃ 5-HT ₅₄ 5-HT ₅₅ 5-HT ₅₆ 5-HT ₅₇ 5-HT ₅₈ 5-HT ₅₉ 5-HT ₆₀ 5-HT ₆₁ 5-HT ₆₂ 5-HT ₆₃ 5-HT ₆₄ 5-HT ₆₅ 5-HT ₆₆ 5-HT ₆₇ 5-HT ₆₈ 5-HT ₆₉ 5-HT ₇₀ 5-HT ₇₁ 5-HT ₇₂ 5-HT ₇₃ 5-HT ₇₄ 5-HT ₇₅ 5-HT ₇₆ 5-HT ₇₇ 5-HT ₇₈ 5-HT ₇₉ 5-HT ₈₀ 5-HT ₈₁ 5-HT ₈₂ 5-HT ₈₃ 5-HT ₈₄ 5-HT ₈₅ 5-HT ₈₆ 5-HT ₈₇ 5-HT ₈₈ 5-HT ₈₉ 5-HT ₉₀ 5-HT ₉₁ 5-HT ₉₂ 5-HT ₉₃ 5-HT ₉₄ 5-HT ₉₅ 5-HT ₉₆ 5-HT ₉₇ 5-HT ₉₈ 5-HT ₉₉ 5-HT ₁₀₀ 5-HT ₁₀₁ 5-HT ₁₀₂ 5-HT ₁₀₃ 5-HT ₁₀₄ 5-HT ₁₀₅ 5-HT ₁₀₆ 5-HT ₁₀₇ 5-HT ₁₀₈ 5-HT ₁₀₉ 5-HT ₁₁₀ 5-HT ₁₁₁ 5-HT ₁₁₂ 5-HT ₁₁₃ 5-HT ₁₁₄ 5-HT ₁₁₅ 5-HT ₁₁₆ 5-HT ₁₁₇ 5-HT ₁₁₈ 5-HT ₁₁₉ 5-HT ₁₂₀ 5-HT ₁₂₁ 5-HT ₁₂₂ 5-HT ₁₂₃ 5-HT ₁₂₄ 5-HT ₁₂₅ 5-HT ₁₂₆ 5-HT ₁₂₇ 5-HT ₁₂₈ 5-HT ₁₂₉ 5-HT ₁₃₀ 5-HT ₁₃₁ 5-HT ₁₃₂ 5-HT ₁₃₃ 5-HT ₁₃₄ 5-HT ₁₃₅ 5-HT ₁₃₆ 5-HT ₁₃₇ 5-HT ₁₃₈ 5-HT ₁₃₉ 5-HT ₁₄₀ 5-HT ₁₄₁ 5-HT ₁₄₂ 5-HT ₁₄₃ 5-HT ₁₄₄ 5-HT ₁₄₅ 5-HT ₁₄₆ 5-HT ₁₄₇ 5-HT ₁₄₈ 5-HT ₁₄₉ 5-HT ₁₅₀ 5-HT ₁₅₁ 5-HT ₁₅₂ 5-HT ₁₅₃ 5-HT ₁₅₄ 5-HT ₁₅₅ 5-HT ₁₅₆ 5-HT ₁₅₇ 5-HT ₁₅₈ 5-HT ₁₅₉ 5-HT ₁₆₀ 5-HT ₁₆₁ 5-HT ₁₆₂ 5-HT ₁₆₃ 5-HT ₁₆₄ 5-HT ₁₆₅ 5-HT ₁₆₆ 5-HT ₁₆₇ 5-HT ₁₆₈ 5-HT ₁₆₉ 5-HT ₁₇₀ 5-HT ₁₇₁ 5-HT ₁₇₂ 5-HT ₁₇₃ 5-HT ₁₇₄ 5-HT ₁₇₅ 5-HT ₁₇₆ 5-HT ₁₇₇ 5-HT ₁₇₈ 5-HT ₁₇₉ 5-HT ₁₈₀ 5-HT ₁₈₁ 5-HT ₁₈₂ 5-HT ₁₈₃ 5-HT ₁₈₄ 5-HT ₁₈₅ 5-HT ₁₈₆ 5-HT ₁₈₇ 5-HT ₁₈₈ 5-HT ₁₈₉ 5-HT ₁₉₀ 5-HT ₁₉₁ 5-HT ₁₉₂ 5-HT ₁₉₃ 5-HT ₁₉₄ 5-HT ₁₉₅ 5-HT ₁₉₆ 5-HT ₁₉₇ 5-HT ₁₉₈ 5-HT ₁₉₉ 5-HT ₂₀₀ 5-HT ₂₀₁ 5-HT ₂₀₂ 5-HT ₂₀₃ 5-HT ₂₀₄ 5-HT ₂₀₅ 5-HT ₂₀₆ 5-HT ₂₀₇ 5-HT ₂₀₈ 5-HT ₂₀₉ 5-HT ₂₁₀ 5-HT ₂₁₁ 5-HT ₂₁₂ 5-HT ₂₁₃ 5-HT ₂₁₄ 5-HT ₂₁₅ 5-HT ₂₁₆ 5-HT ₂₁₇ 5-HT ₂₁₈ 5-HT ₂₁₉ 5-HT ₂₂₀ 5-HT ₂₂₁ 5-HT ₂₂₂ 5-HT ₂₂₃ 5-HT ₂₂₄ 5-HT ₂₂₅ 5-HT ₂₂₆ 5-HT ₂₂₇ 5-HT ₂₂₈ 5-HT ₂₂₉ 5-HT ₂₃₀ 5-HT ₂₃₁ 5-HT ₂₃₂ 5-HT ₂₃₃ 5-HT ₂₃₄ 5-HT ₂₃₅ 5-HT ₂₃₆ 5-HT ₂₃₇ 5-HT ₂₃₈ 5-HT ₂₃₉ 5-HT ₂₄₀ 5-HT ₂₄₁ 5-HT ₂₄₂ 5-HT ₂₄₃ 5-HT ₂₄₄ 5-HT ₂₄₅ 5-HT ₂₄₆ 5-HT ₂₄₇ 5-HT ₂₄₈ 5-HT ₂₄₉ 5-HT ₂₅₀ 5-HT ₂₅₁ 5-HT ₂₅₂ 5-HT ₂₅₃ 5-HT ₂₅₄ 5-HT ₂₅₅ 5-HT ₂₅₆ 5-HT ₂₅₇ 5-HT ₂₅₈ 5-HT ₂₅₉ 5-HT ₂₆₀


PROJECT TITLE:	LOCATION:
โครงการพัฒนาระบบการให้บริการลูกค้าของธนาคารกรุงศรีอยุธยา จำกัด (มหาชน) สาขาเชียงใหม่	เชียงใหม่

DRAWING TITLE :
 ฝักรอดักการน้
 FGD DETAIL (ผู้ดำเนินการ)

REVISION :		JOB NO.
NO.	DESCRIPTION :	
NOTE :		SCALE :
		DRAWN

CHECKED: by me: <i>Andreas</i>	DRAWING NO.: IN.B-08-05
-----------------------------------	--------------------------------

[illegible]

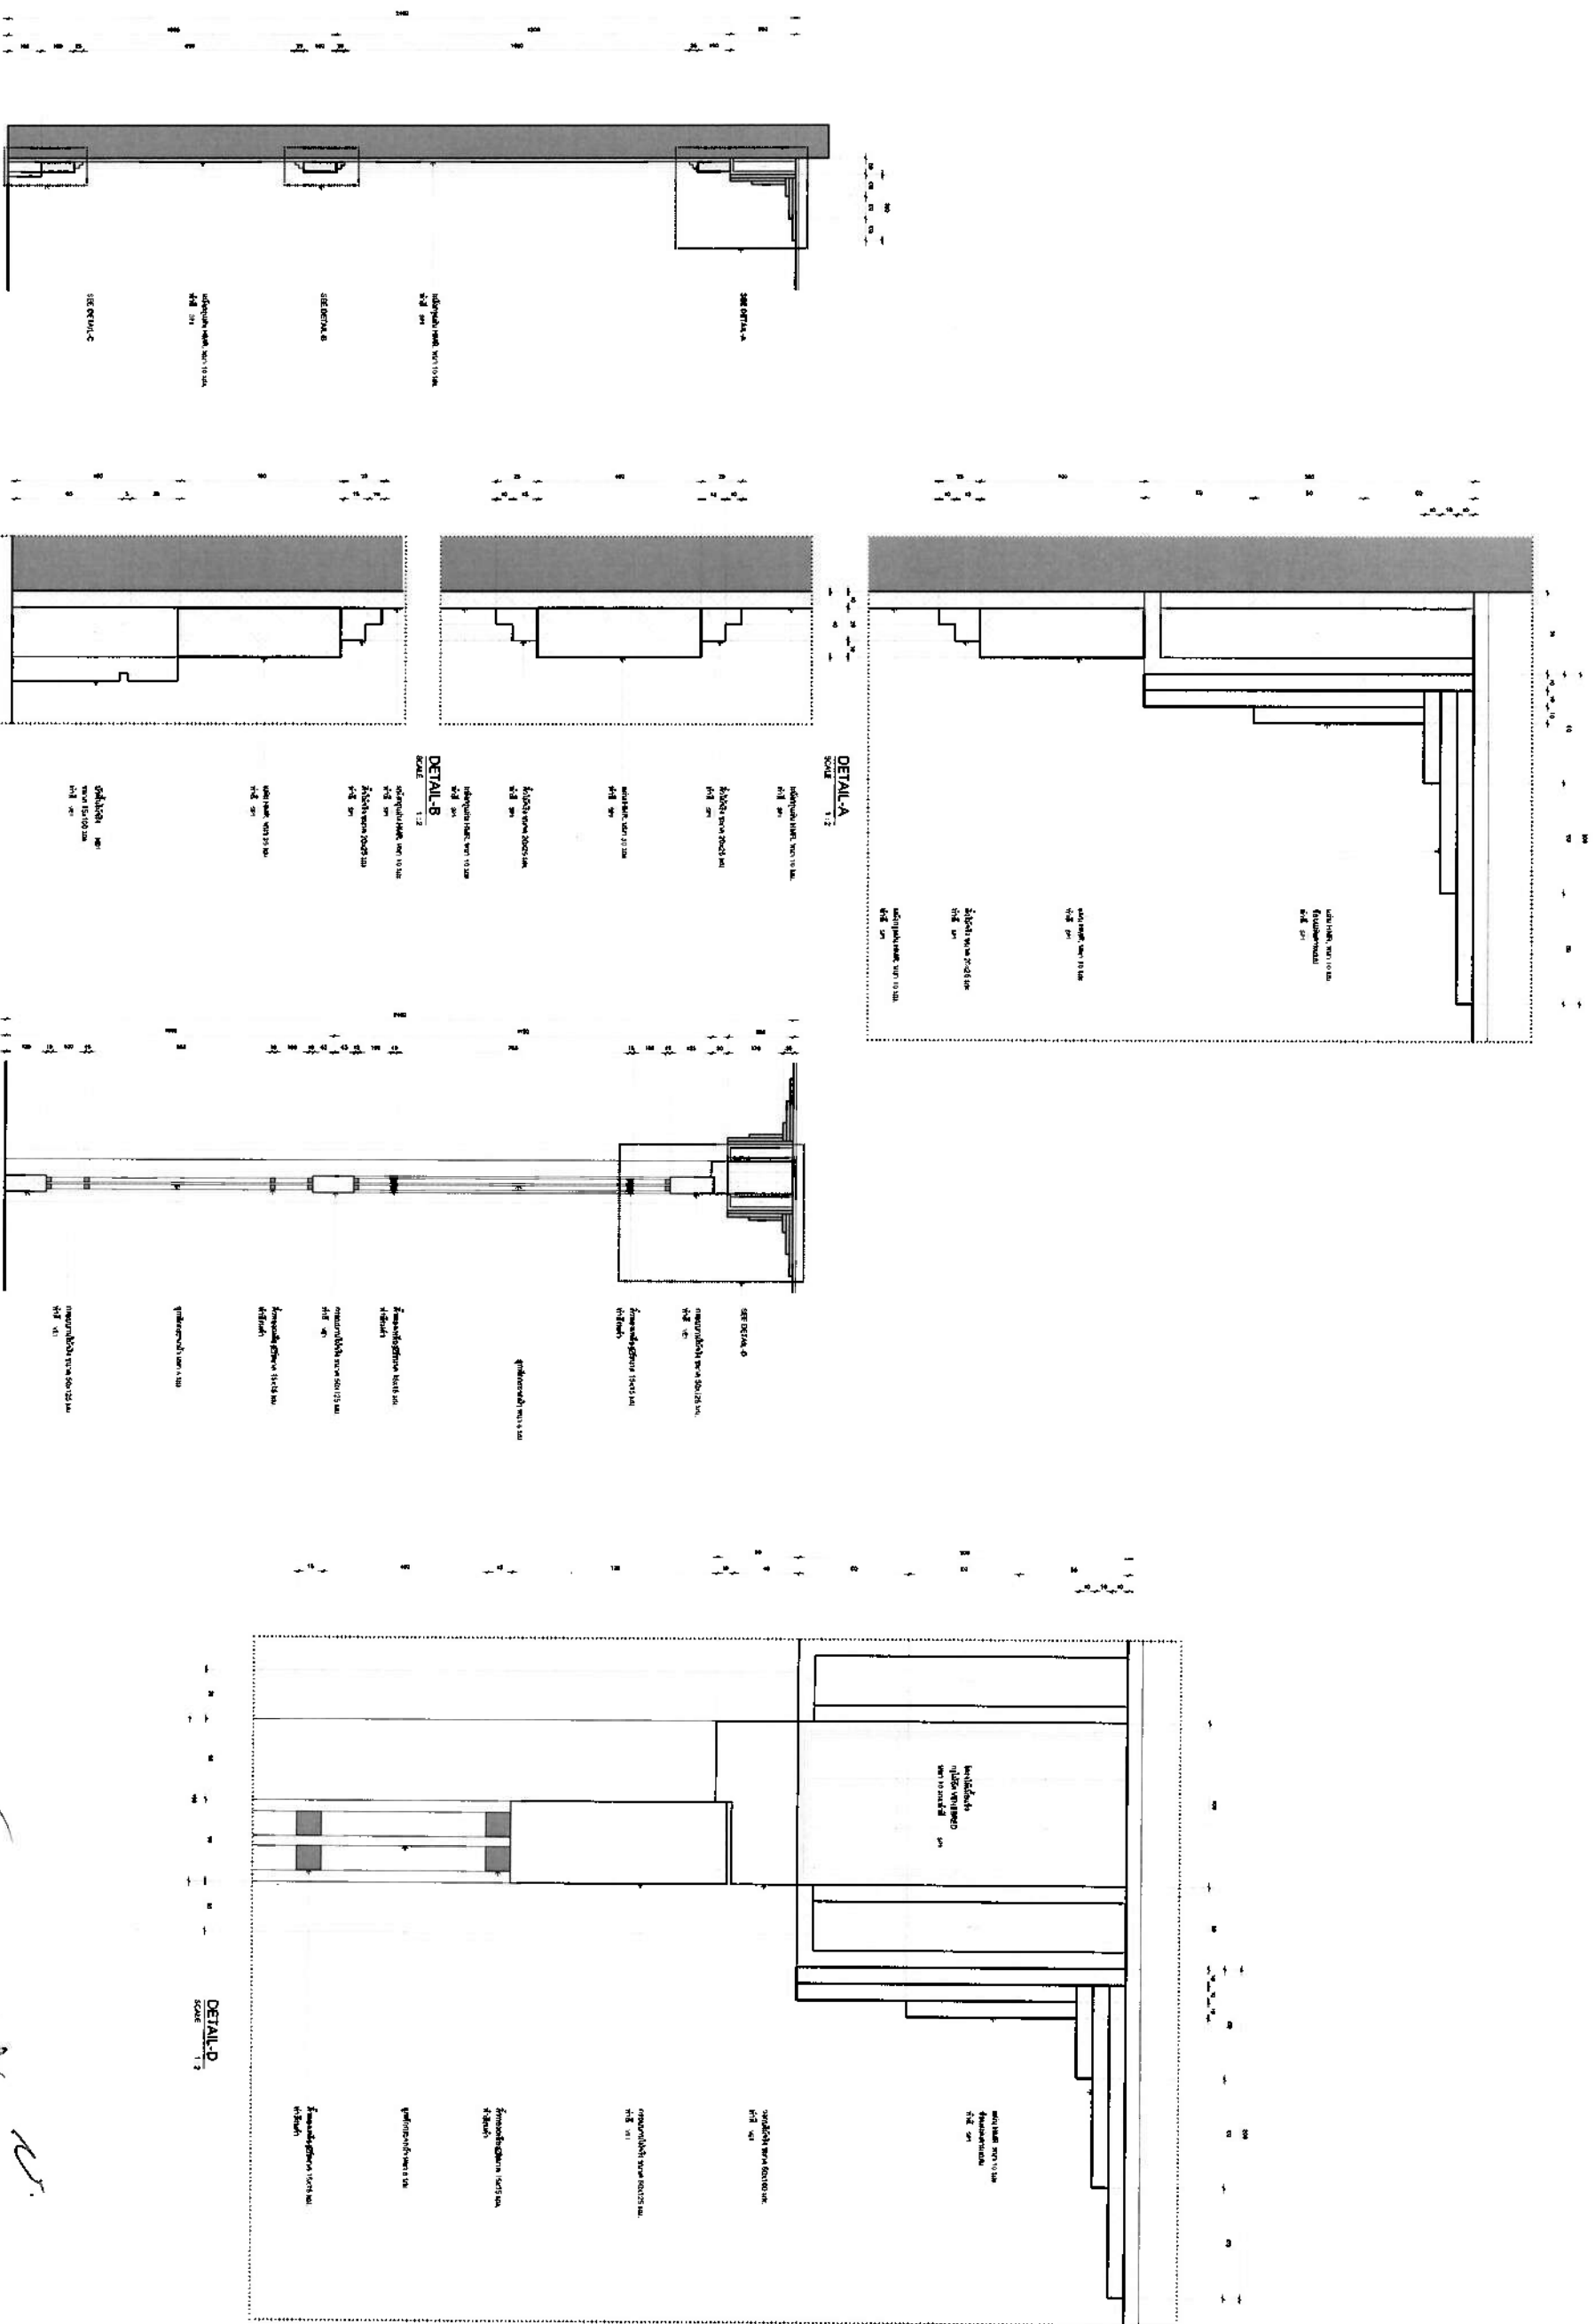

SECTION-1
SCALE 1:10

DETAIL-C
SCALE 1:2

SECTION-2
SCALE 1:10

DETAIL-A
SCALE 1:2

DETAIL-B
SCALE 1:2

DETAIL-D
SCALE 1:2




PROJECT TITLE:	Деталь здания
LOCATION:	г. Москва
DATE:	2023

PROJECT TITLE:	Деталь здания
LOCATION:	г. Москва
DATE:	2023


PROJECT TITLE:	Деталь здания
LOCATION:	г. Москва
DATE:	2023

PROJECT TITLE:	Деталь здания
LOCATION:	г. Москва
DATE:	2023


FB43 DETAIL (ສູ່ເກັບເອກສາງ)

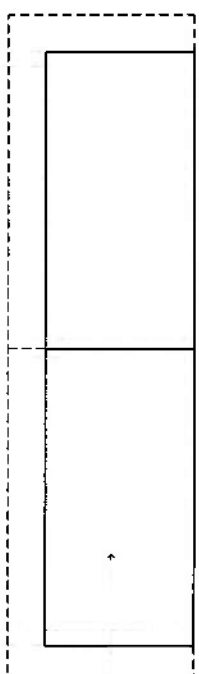

TOP VIEW
SCALE 1" = 80'

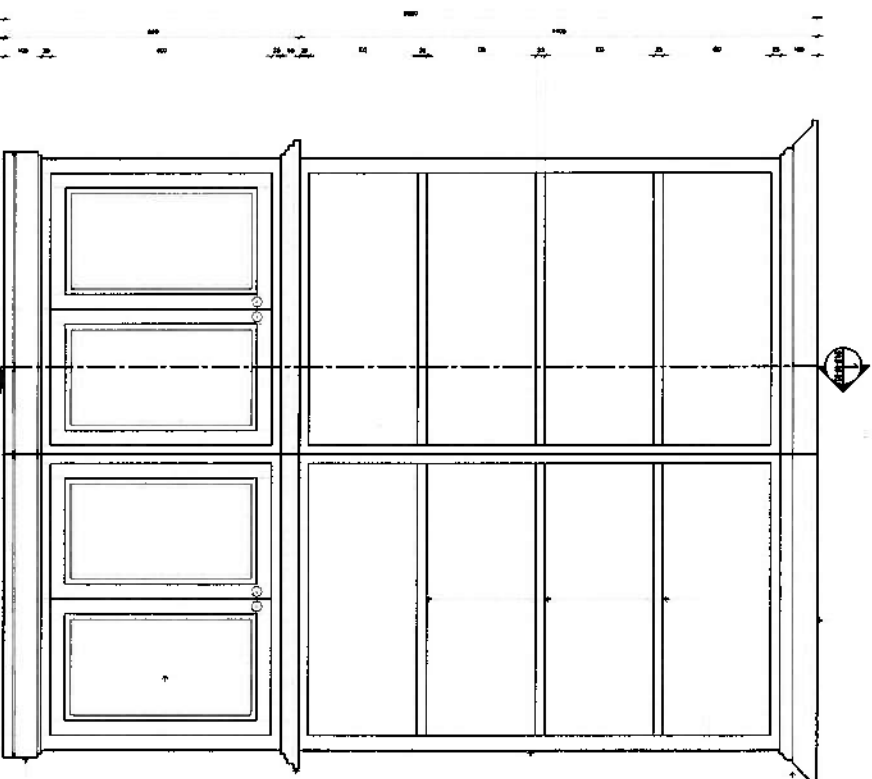


FRONT VIEW
SCALE 1" = 1'-0"

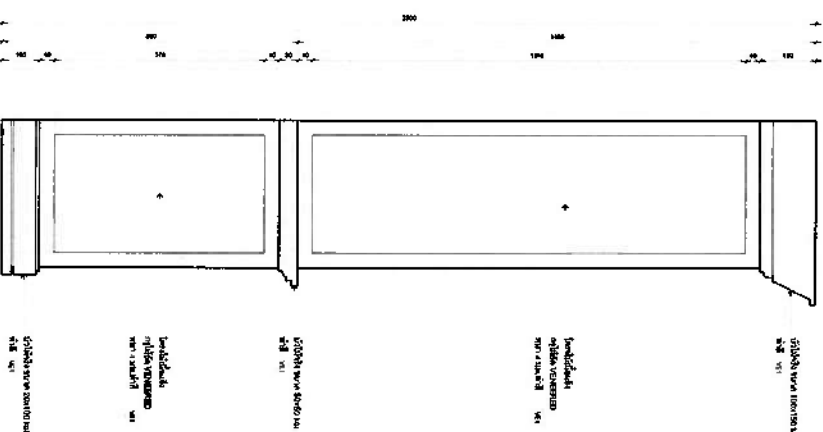


SIDE VIEW


SCALE 1" = 10'

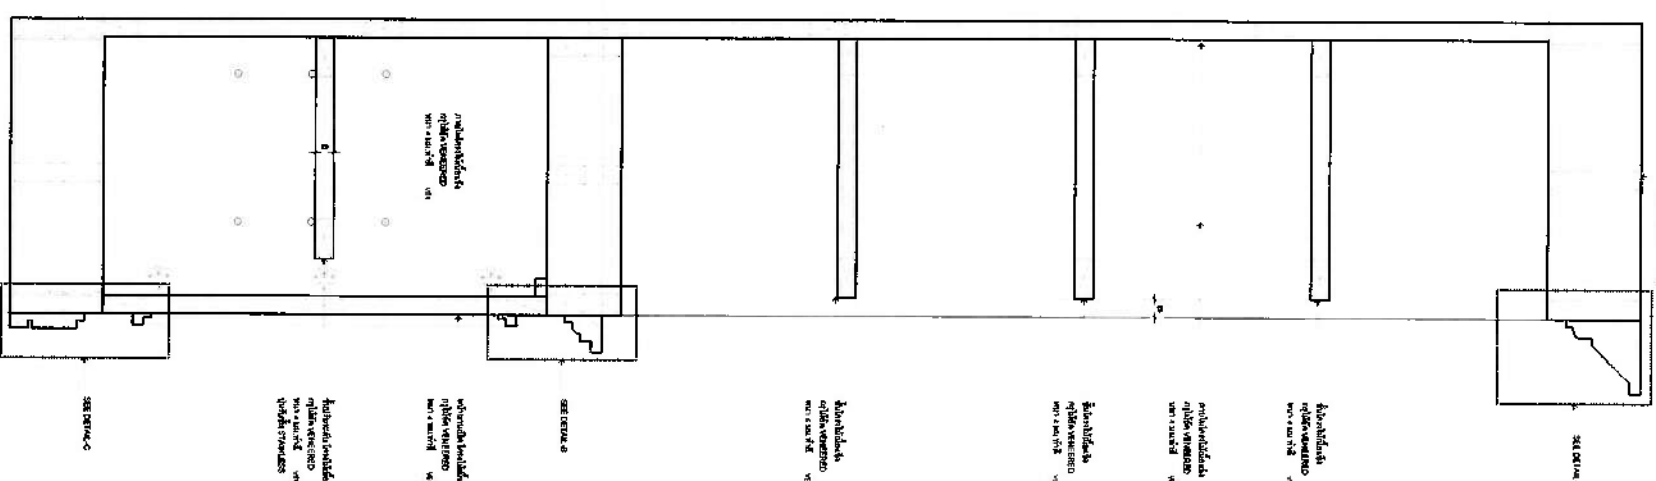


SECTION-1

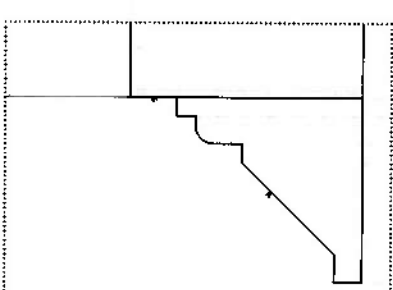


DETAIL-A
SCM 1:2

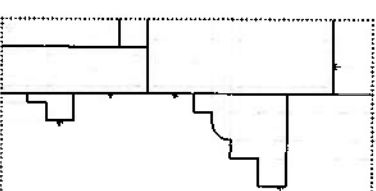

DETAIL-8
SCALE 1" = 2'

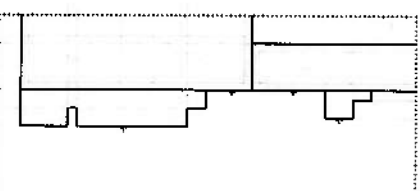

DETAIL-C
SCALE 1/2"

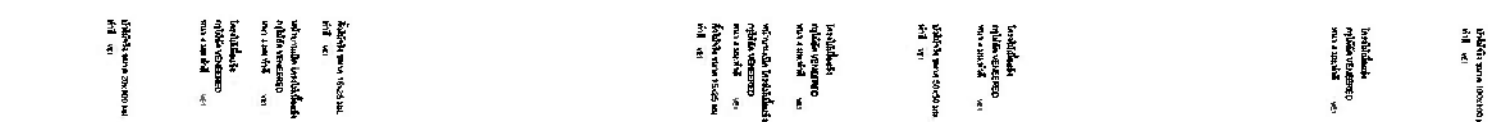

QIDR

[illegible][illegible]


PROJECT TITLE:	โครงการพัฒนาระบบการให้บริการข้อมูลข่าวสาร แก่ประชาชน (Public Information System Development Project)
LOCATION:	ศูนย์บริการข้อมูลข่าวสาร (Public Information Center) กรุงเทพมหานคร (Bangkok)

DRAWING TITLE :
ห้องระงับกลิ่นการพบดี
FB43 DETAIL (ตู้เก็บเอกสาร)


JOB NO.	REVISION :	
	NO.	DESCRIPTION
SCALE :		
DRAWN	NOTE :	

DRAWING NO.: IN-B-09-03


F43 DETAIL (พื้นที่งาน)

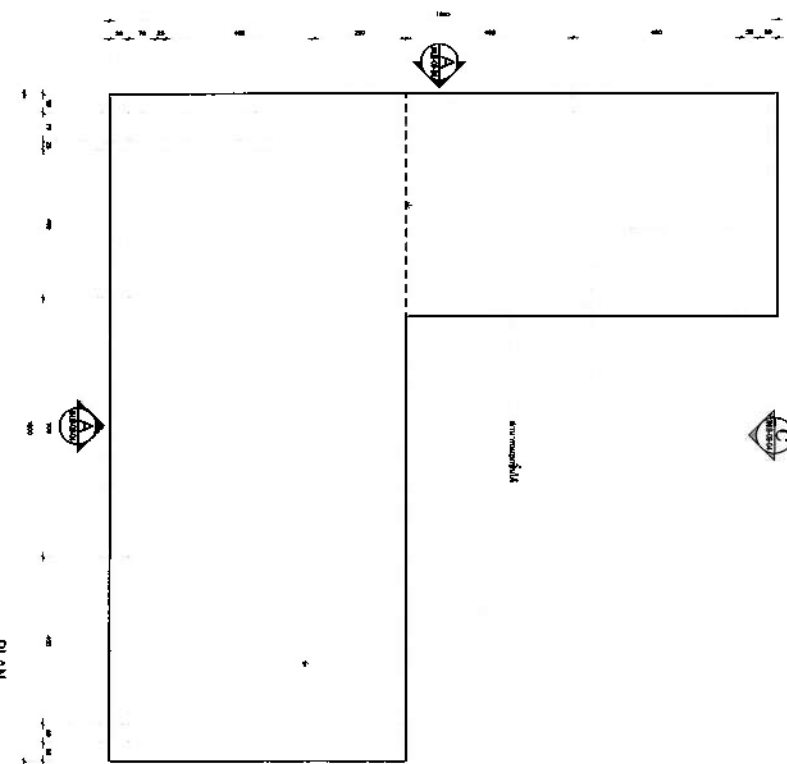


PLAN
SCALE 1/10

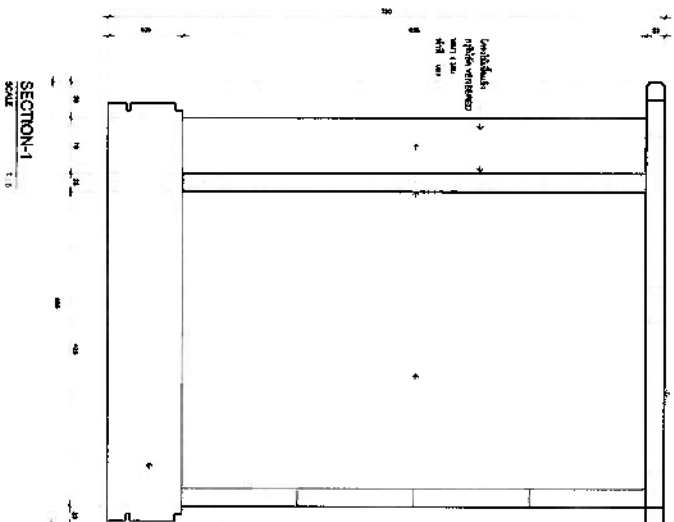


SECTION-1
SCALE 1/10

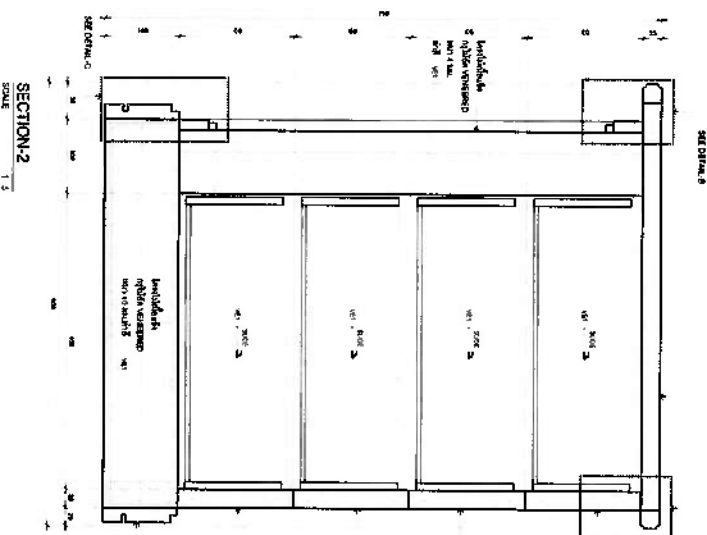


SECTION-2
SCALE 1/10

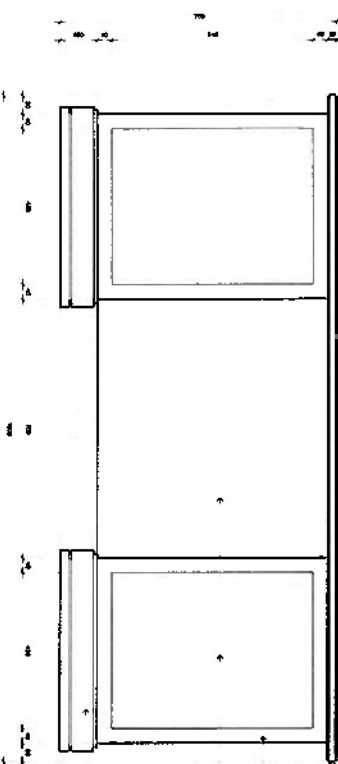


ELEVATION A
SCALE 1/10

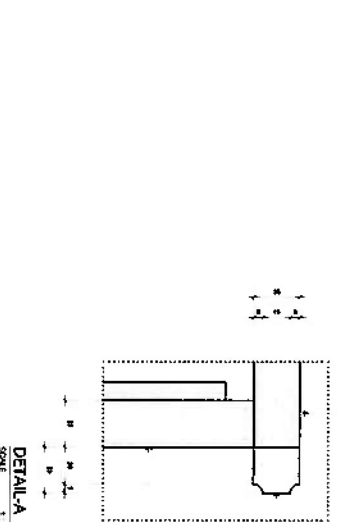


DETAIL A
SCALE 1/2

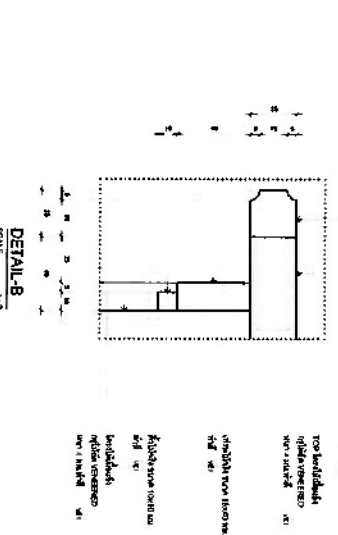


DETAIL B
SCALE 1/2

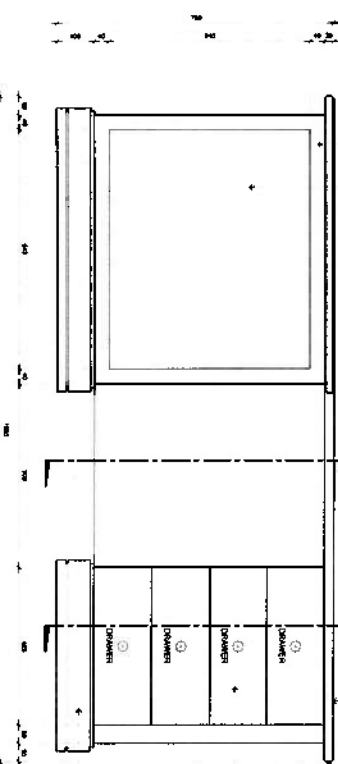

ELEVATION B
SCALE 1/10

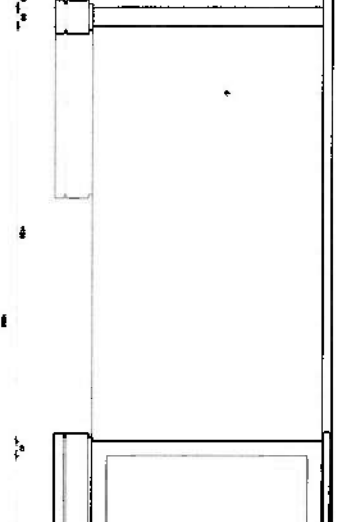

ELEVATION C
SCALE 1/10

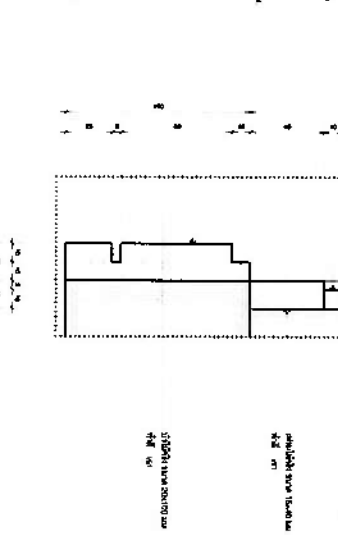


DETAIL C
SCALE 1/2




PROJECT TITLE	PROJECT NO.
PROJECT LOCATION	PROJECT DATE
PROJECT DESCRIPTION	PROJECT STATUS
PROJECT DRAWN BY	PROJECT CHECKED BY
PROJECT APPROVED BY	PROJECT REVIEWED BY

PROJECT TITLE	PROJECT NO.
PROJECT LOCATION	PROJECT DATE
PROJECT DESCRIPTION	PROJECT STATUS
PROJECT DRAWN BY	PROJECT CHECKED BY
PROJECT APPROVED BY	PROJECT REVIEWED BY


PROJECT TITLE	PROJECT NO.
PROJECT LOCATION	PROJECT DATE
PROJECT DESCRIPTION	PROJECT STATUS
PROJECT DRAWN BY	PROJECT CHECKED BY
PROJECT APPROVED BY	PROJECT REVIEWED BY

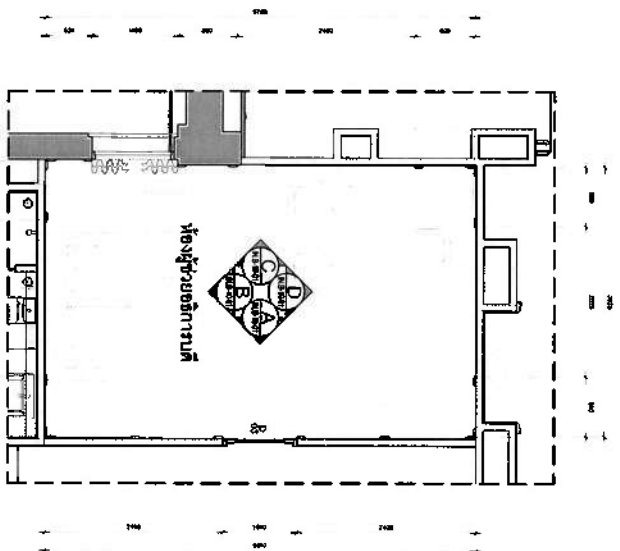


FURNITURE LAYOUT
SCALE 1:50

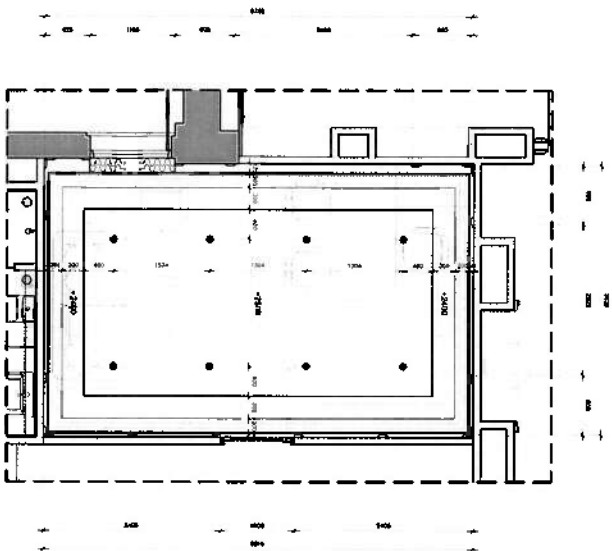


CEILING & LIGHTING LAYOUT
SCALE 1:50

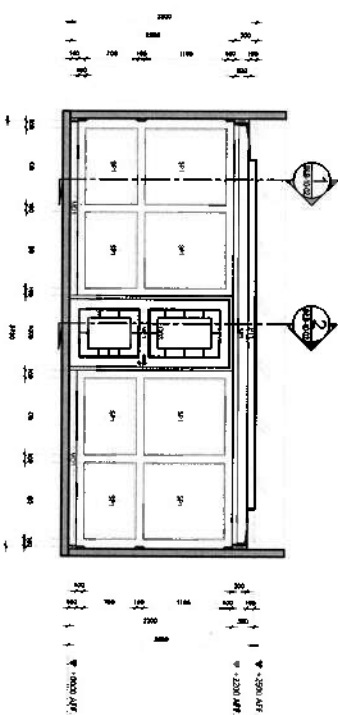


ELEVATION A
SCALE 1:50

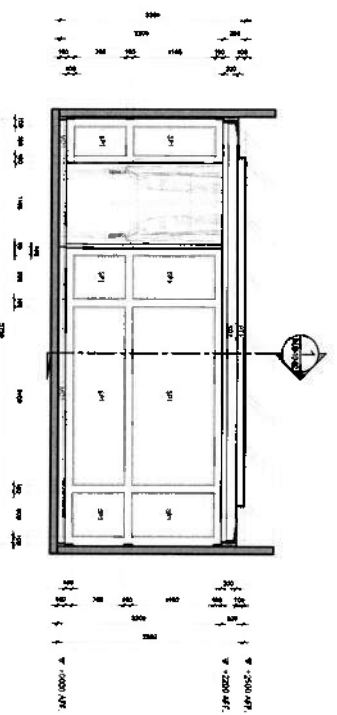


ELEVATION C
SCALE 1:50

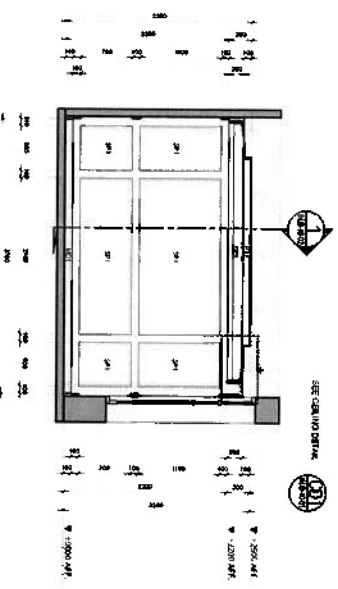

ELEVATION B
SCALE 1:50

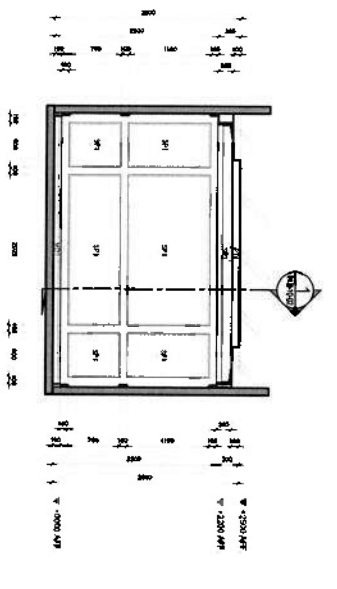

ELEVATION D
SCALE 1:50

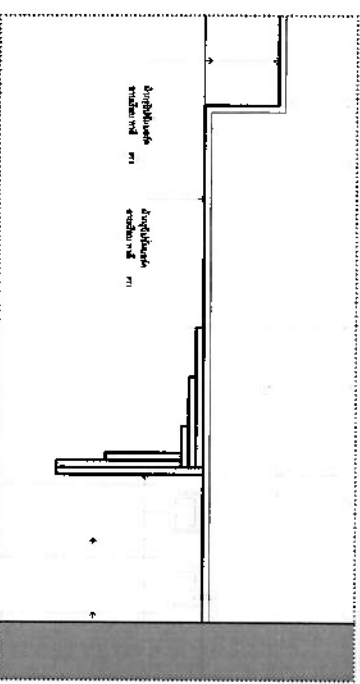








CEILING DETAIL CD1
SCALE 1:50

		PROJECT TITLE: โครงการพัฒนาระบบปรับอากาศและระบบไฟฟ้า LOCATION: อาคาร 1000	
DESIGNER: ป.ป.พ. CHECKED: ป.ป.พ. DRAWING NO.: IN-B-10-01	PROJECT TITLE: โครงการพัฒนาระบบปรับอากาศและระบบไฟฟ้า LOCATION: อาคาร 1000	DRAWING TITLE: แผนผังการวางตำแหน่งเครื่องปรับอากาศและระบบไฟฟ้า SCALE: 1:50	DRAWING NO.: IN-B-10-01


Client:	QIDAR
Project Name:	QIDAR
Location:	QIDAR
Scale:	QIDAR

Project Title:	QIDAR
Location:	QIDAR
Scale:	QIDAR


Project Title:	QIDAR
Location:	QIDAR
Scale:	QIDAR

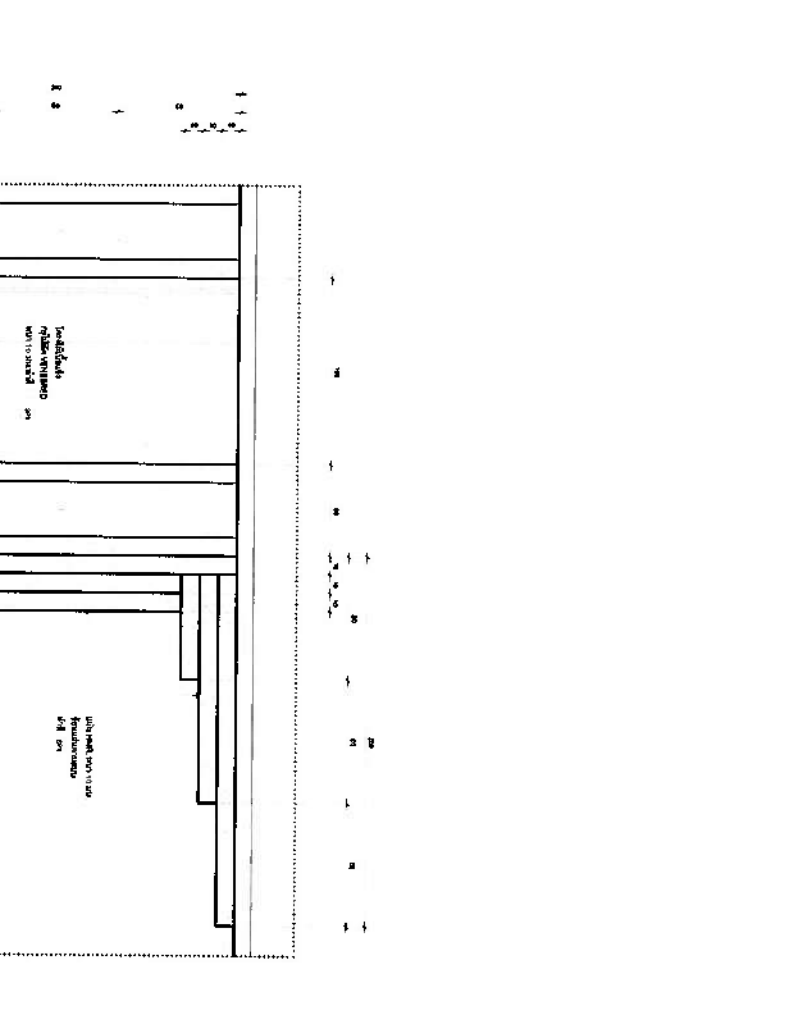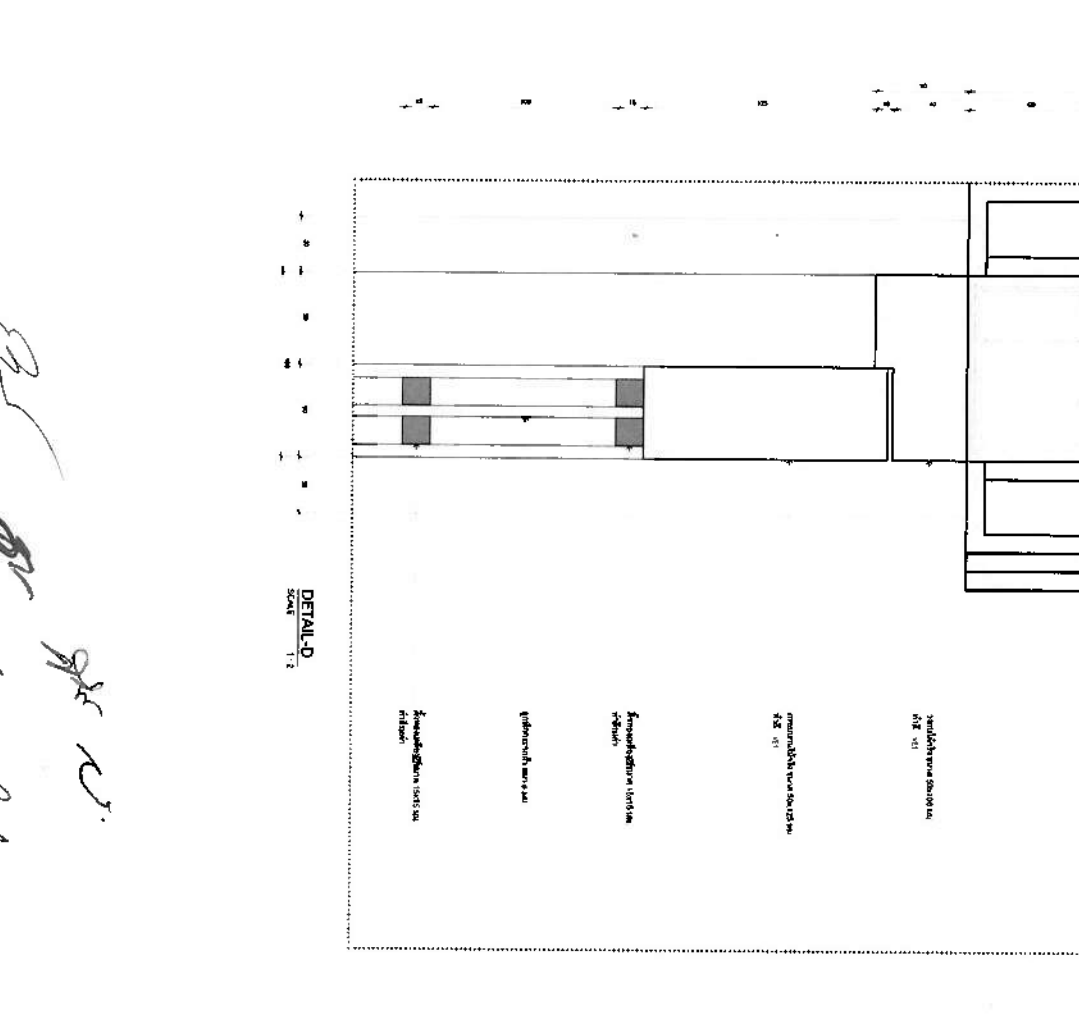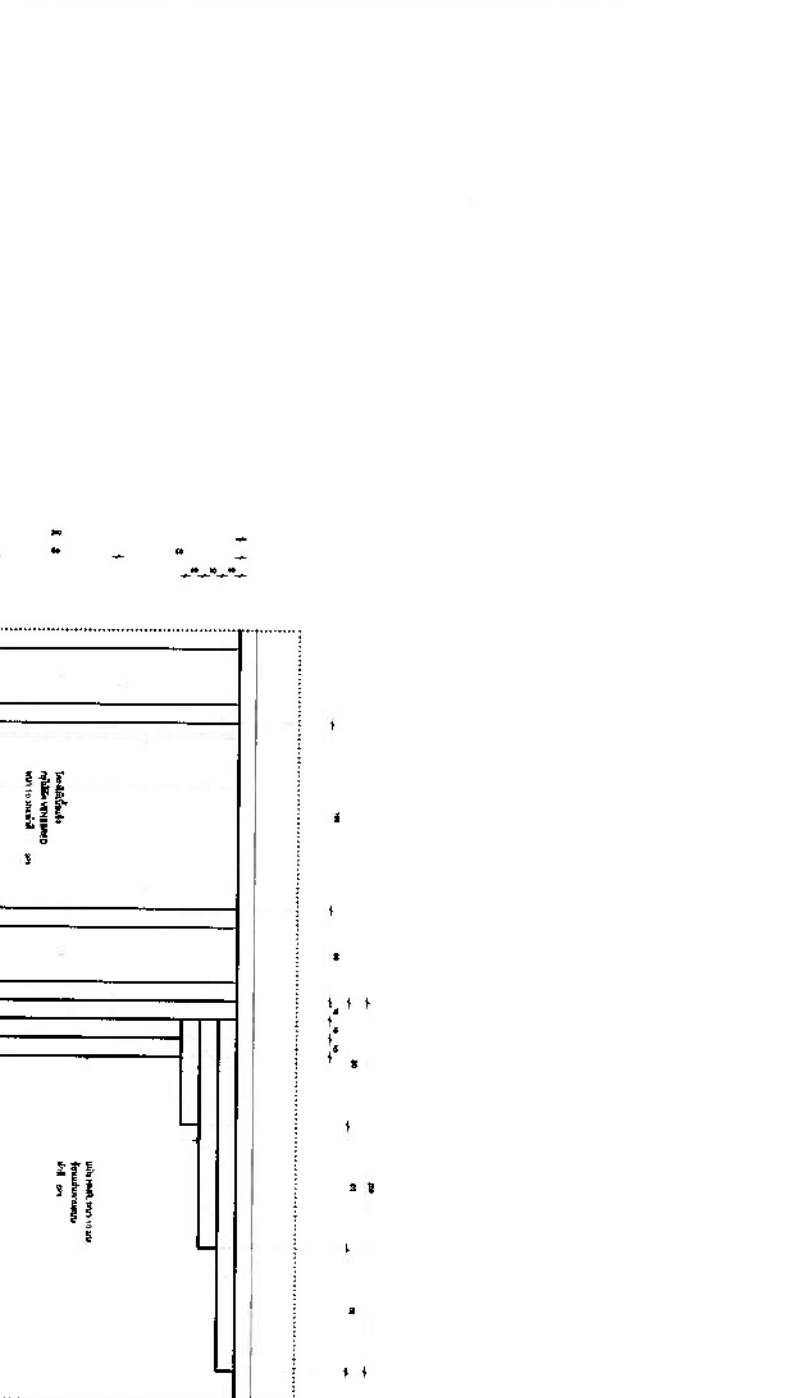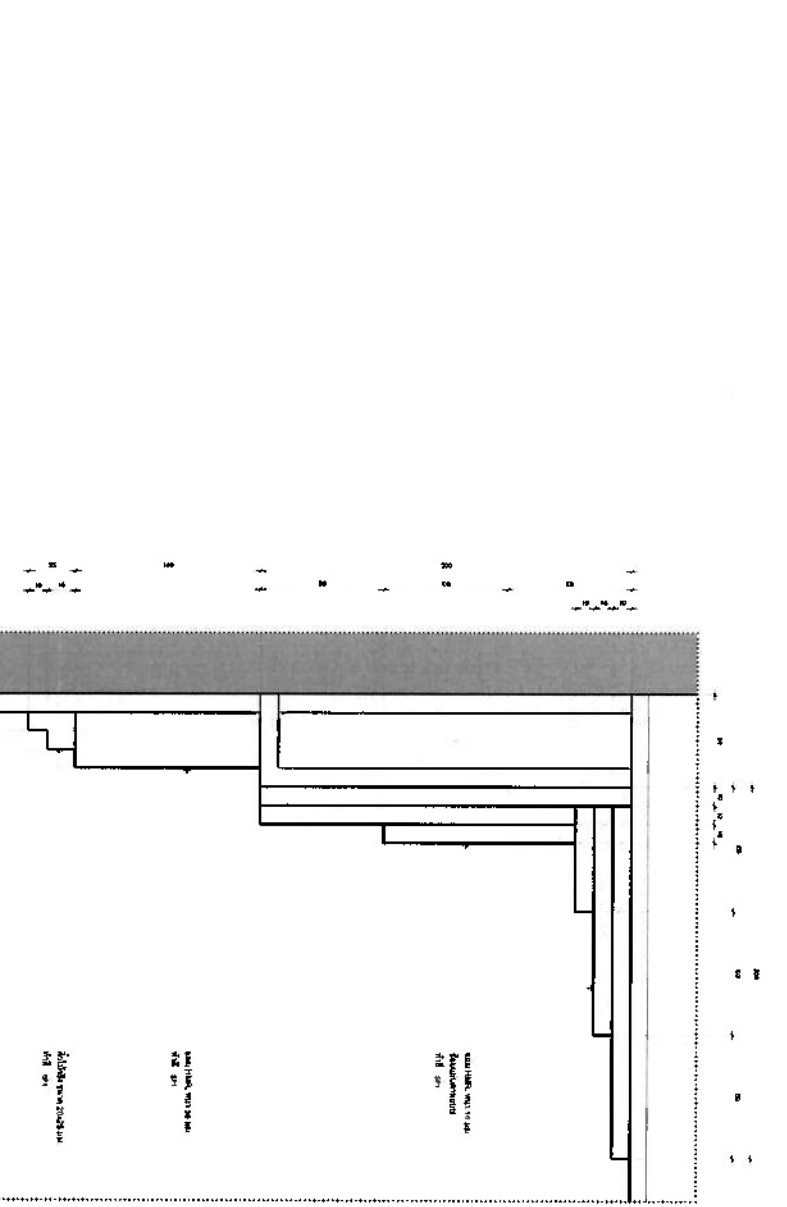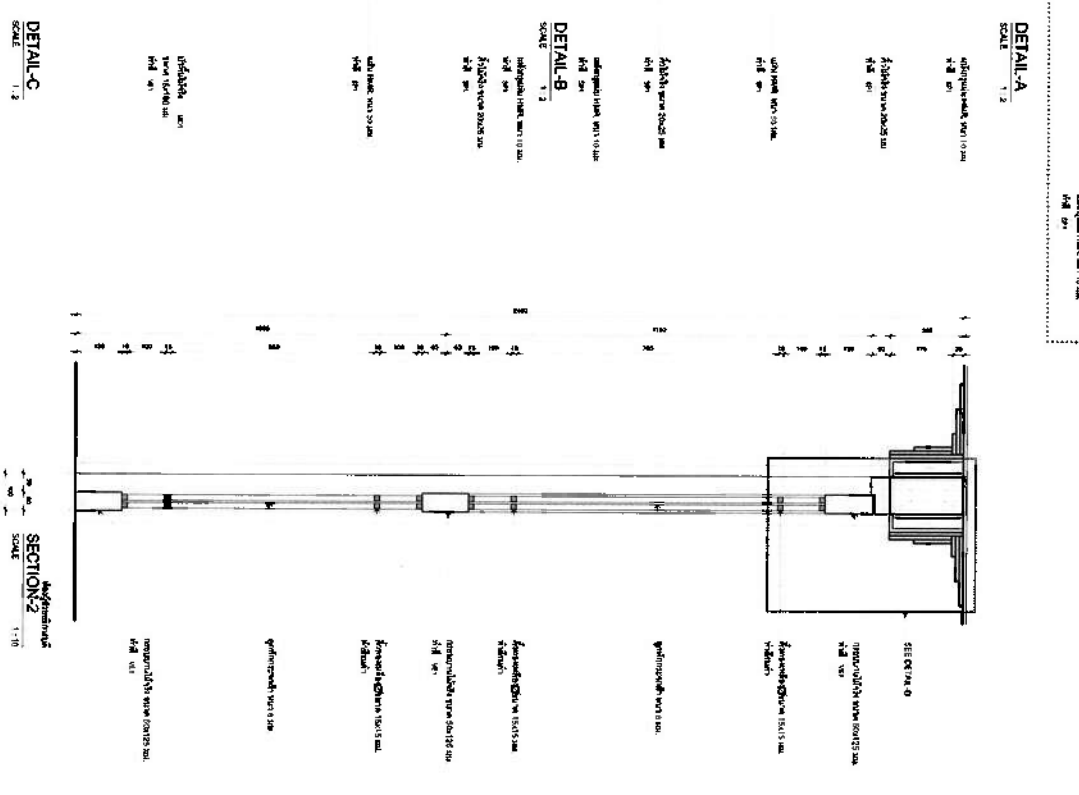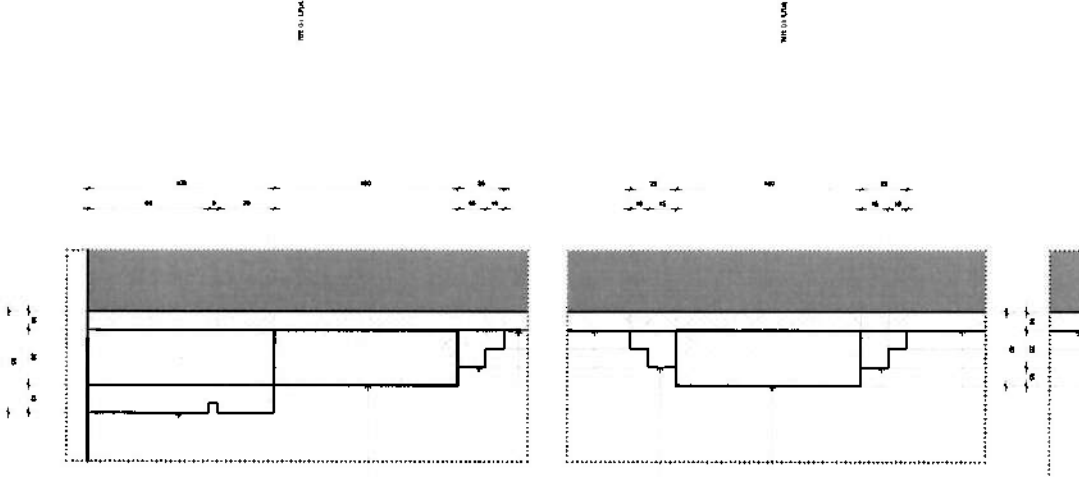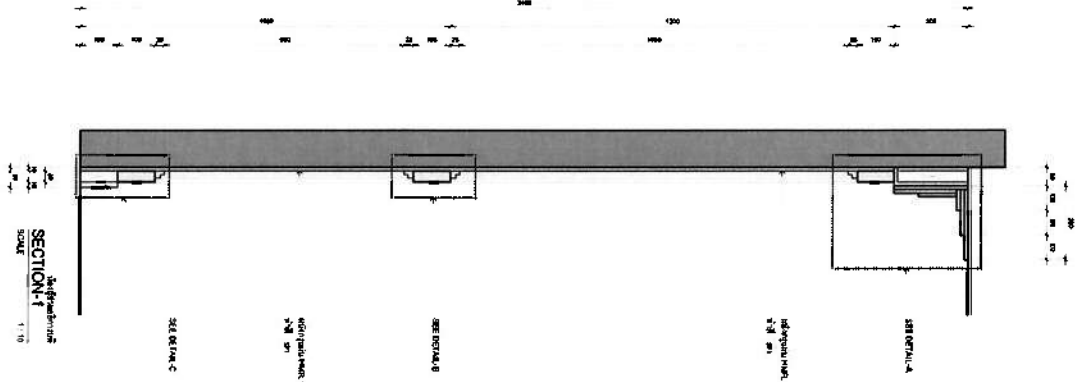


F64 DETAIL (ផ្នែកក្រចក)

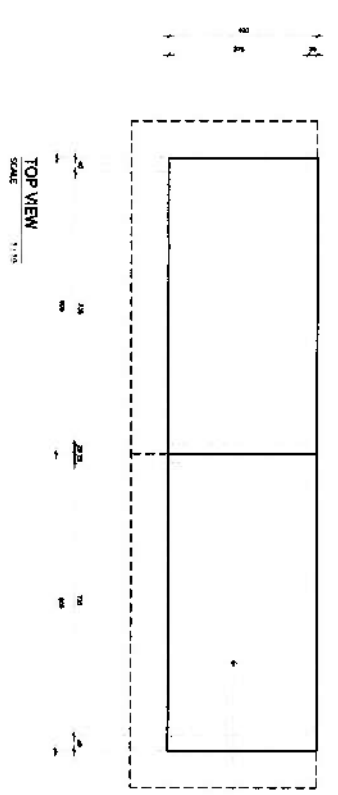


TOP VIEW
SCALE 1:10

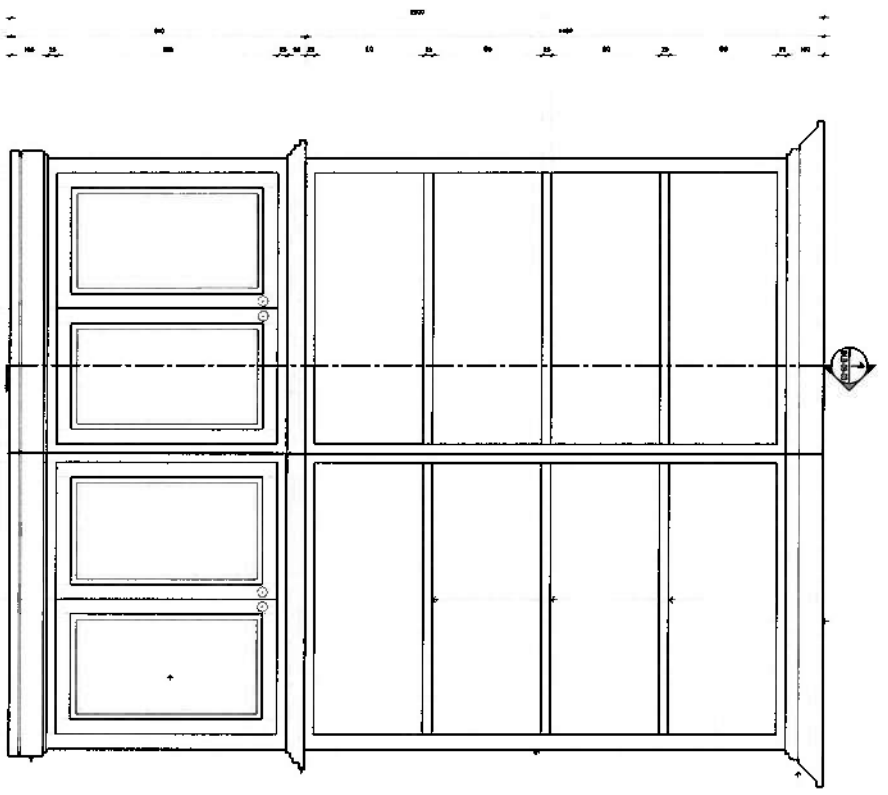


FRONT VIEW
SCALE 1:10

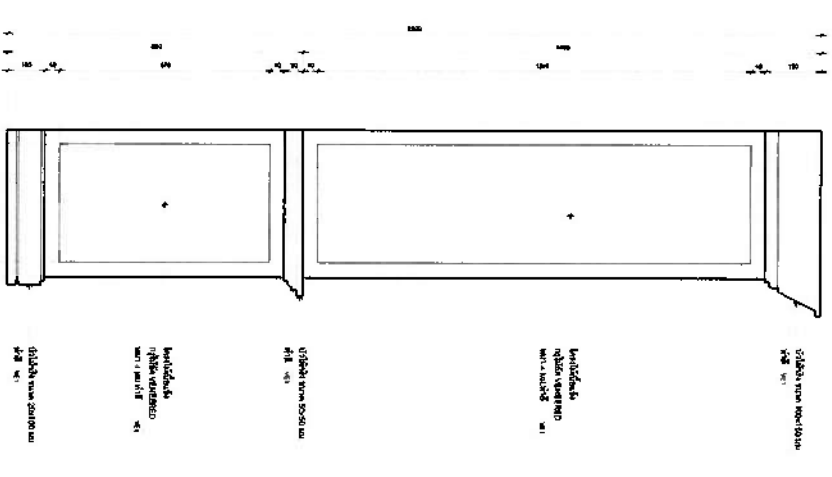


SIDE VIEW
SCALE 1:10

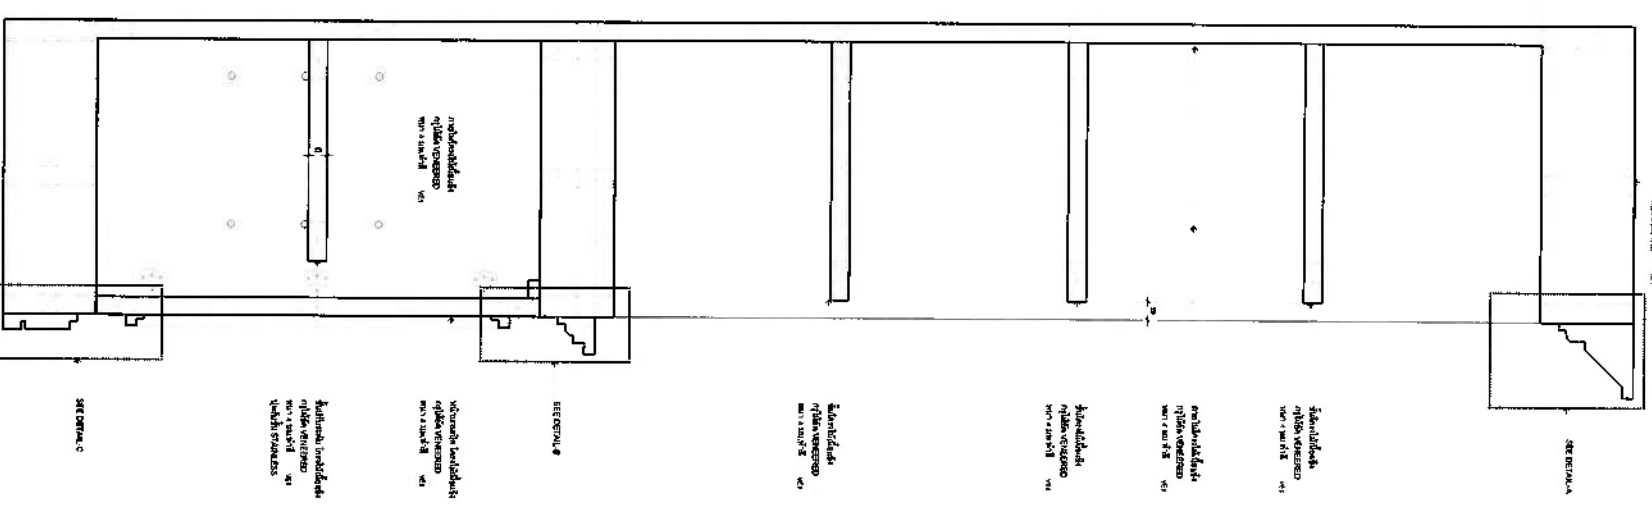


SECTION-1
SCALE 1:5

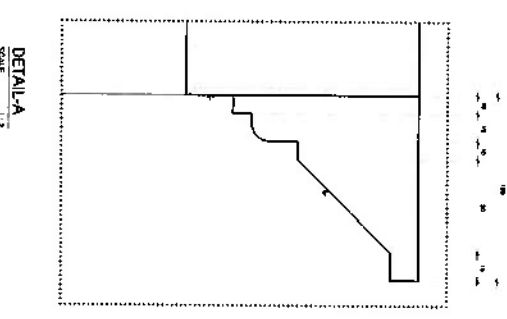

DETAIL-A
SCALE 1:2

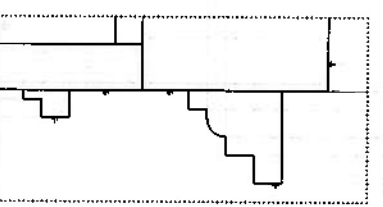


DETAIL-B
SCALE 1:2

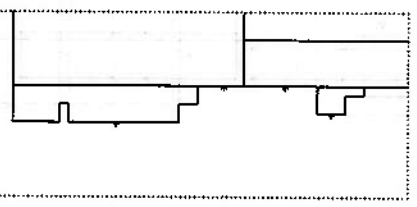


DETAIL-C
SCALE 1:2

PROJECT: វិស័យ វប្បធម៌		PROJECT: វិស័យ វប្បធម៌	
DRAWING TITLE: ផែនទីប្រតិបត្តិការ		DRAWING TITLE: ផែនទីប្រតិបត្តិការ	
LOCATION: ក្រុង ភ្នំពេញ		LOCATION: ក្រុង ភ្នំពេញ	
DATE: ០១/០១/២០២០		DATE: ០១/០១/២០២០	
REVISION:		REVISION:	
NO.		NO.	
DATE		DATE	
BY:		BY:	
CHECKED:		CHECKED:	
DATE		DATE	
DRAWING NO.:		DRAWING NO.:	
IN-B-10-03		IN-B-10-03	


F43 DETAIL (โต๊ะทำงาน)

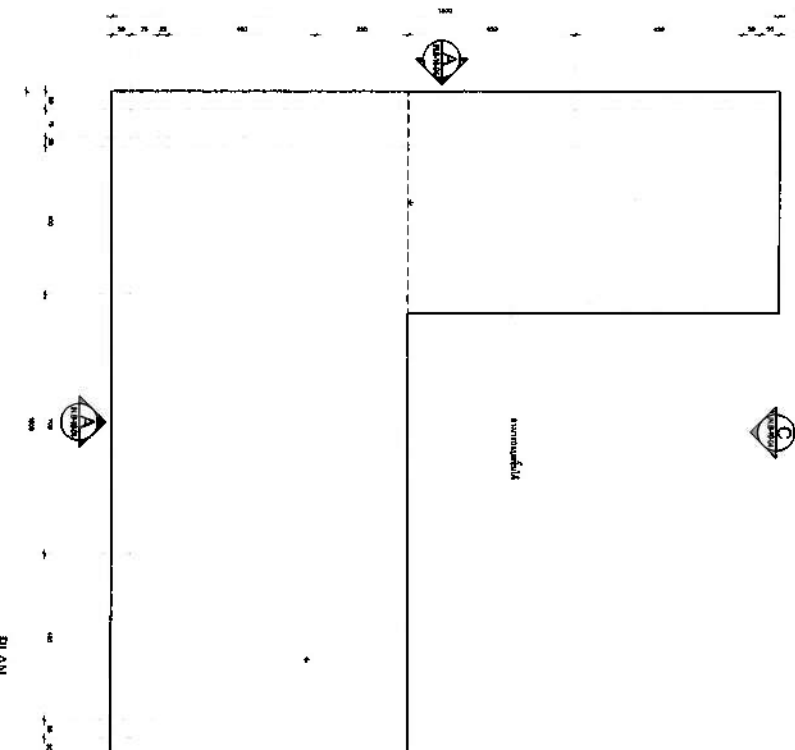


PLAN
SCALE 1:10

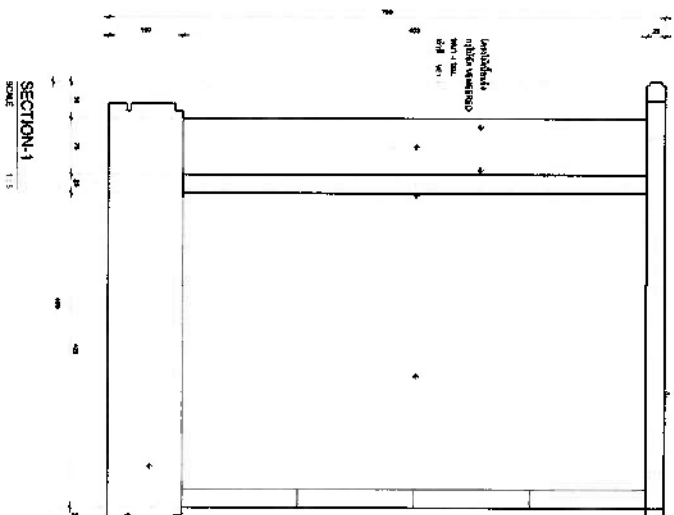


SECTION-1
SCALE 1:5

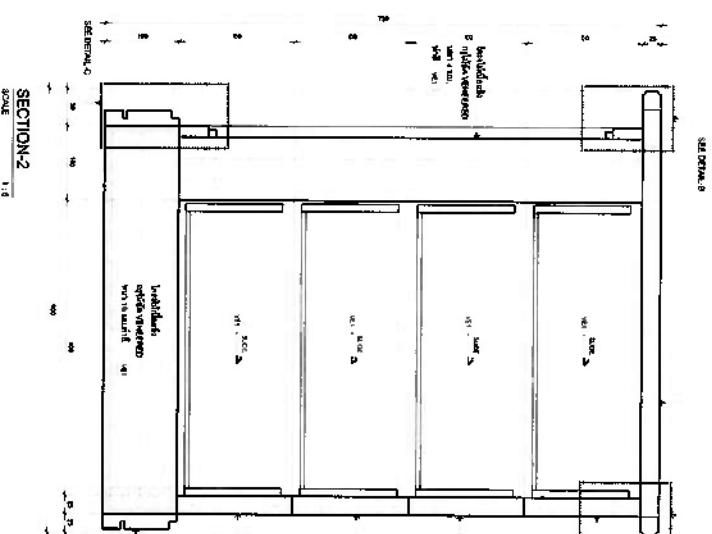


SECTION-2
SCALE 1:5

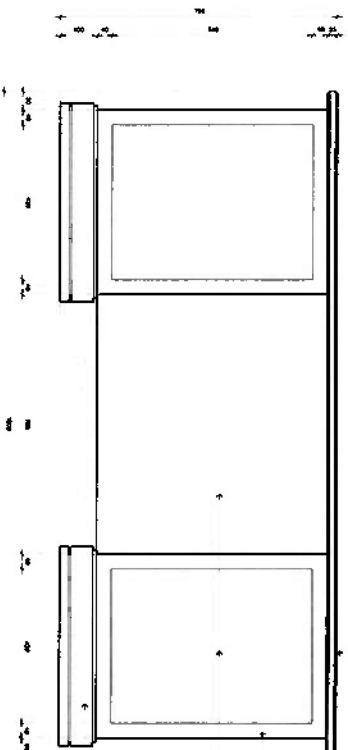


ELEVATION-A
SCALE 1:10

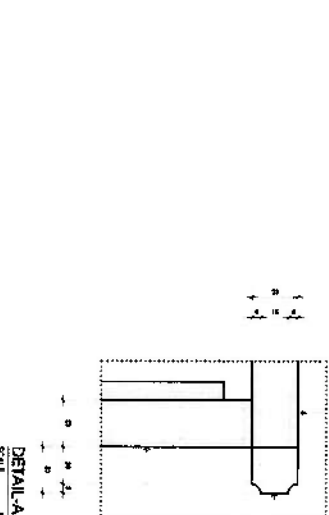


DETAIL-A
SCALE 1:2

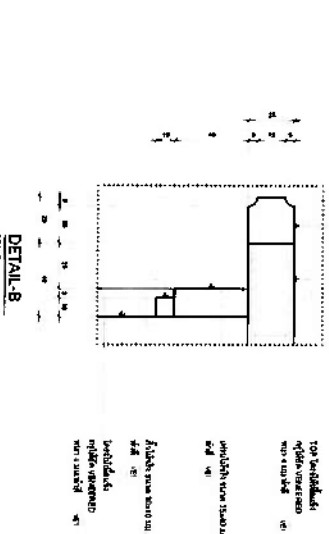


DETAIL-B
SCALE 1:2

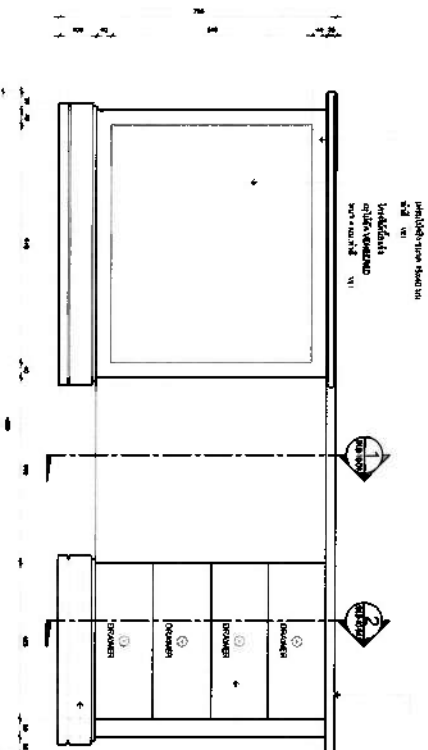

ELEVATION-B
SCALE 1:10

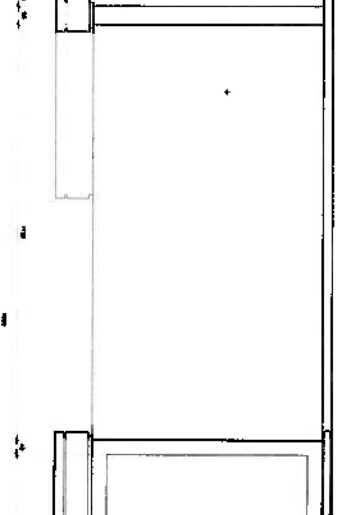

ELEVATION-C
SCALE 1:10

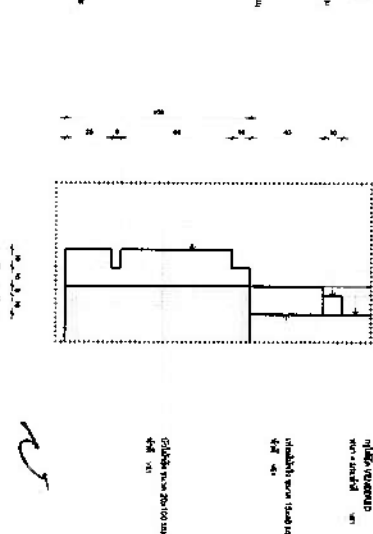

DETAIL-C
SCALE 1:2

QIDR		PROJECT TITLE		DRAWING TITLE	
F43 DETAIL (โต๊ะทำงาน)		F43 DETAIL (โต๊ะทำงาน)		F43 DETAIL (โต๊ะทำงาน)	
DESIGNED BY: <i>[Signature]</i>		CHECKED BY: <i>[Signature]</i>		DATE: <i>[Date]</i>	
DRAWN BY: <i>[Signature]</i>		SCALE: 1:10		PROJECT NO: IN-B-10-04	



N.


R

Frank

635

W

[illegible]

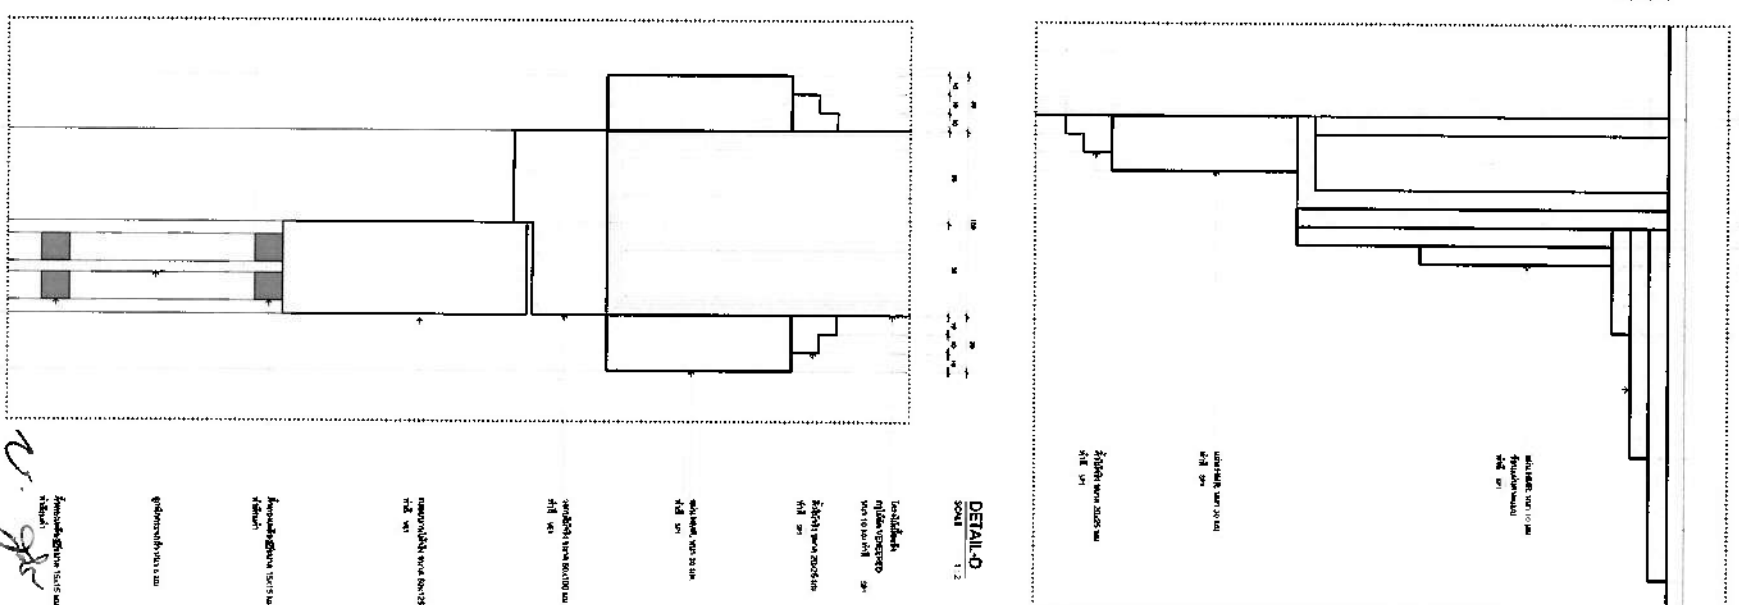



PLAN
SCALE 1" = 10'



 
ELEVATION-A
SCORE 1 = 1



F56 DETAIL (โต๊ะทำงานห้องนาฬิกา)



SEE DETAIL 4



SECTION-1
SCALE 1






DETAIL-A




DETAILED


DETAILS
SCALE 1/4" = 1'-0"

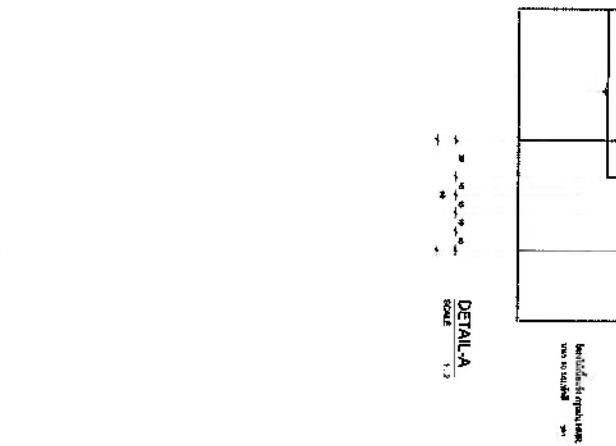


F43B DETAIL (F43B-111)

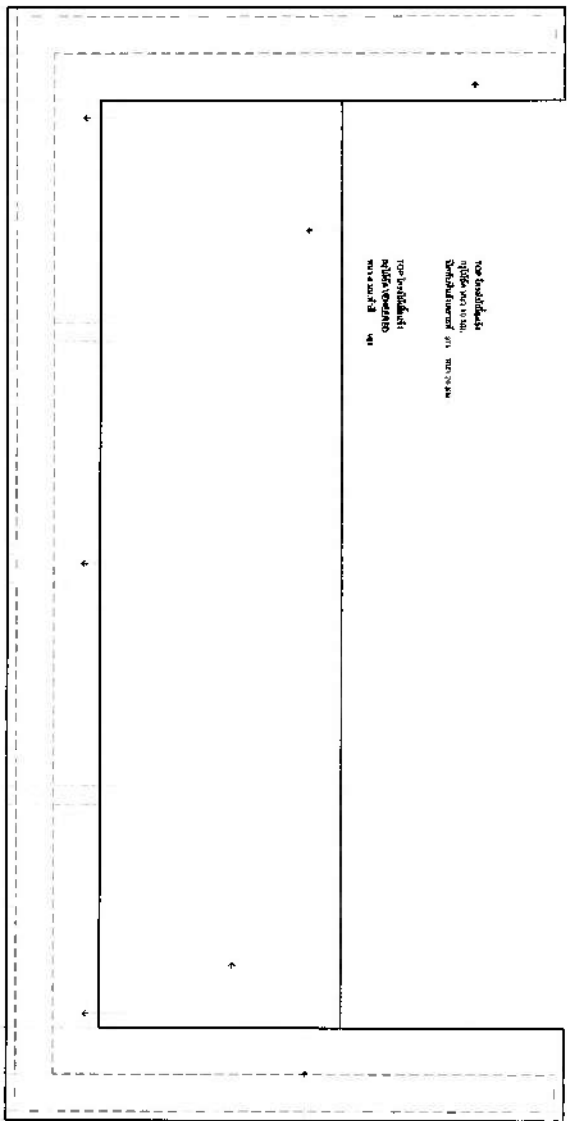


TOP VIEW
SCALE 1:10

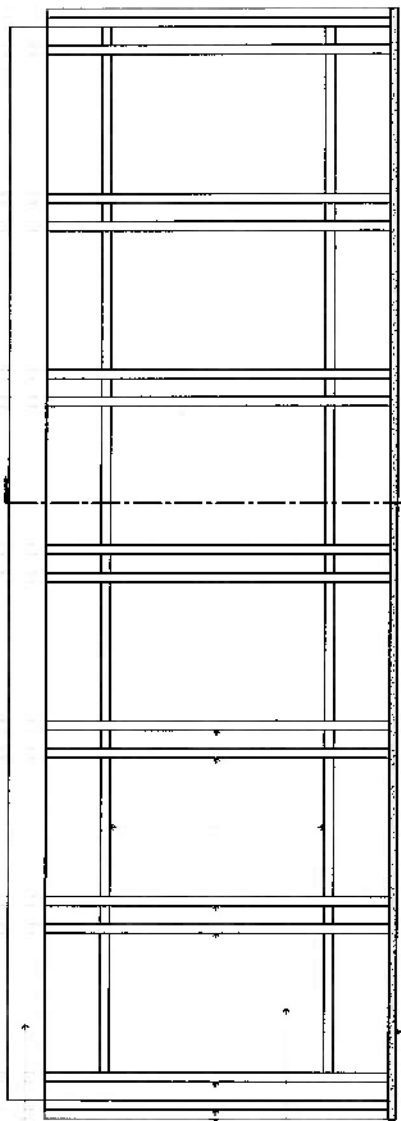


FRONT VIEW
SCALE 1:10

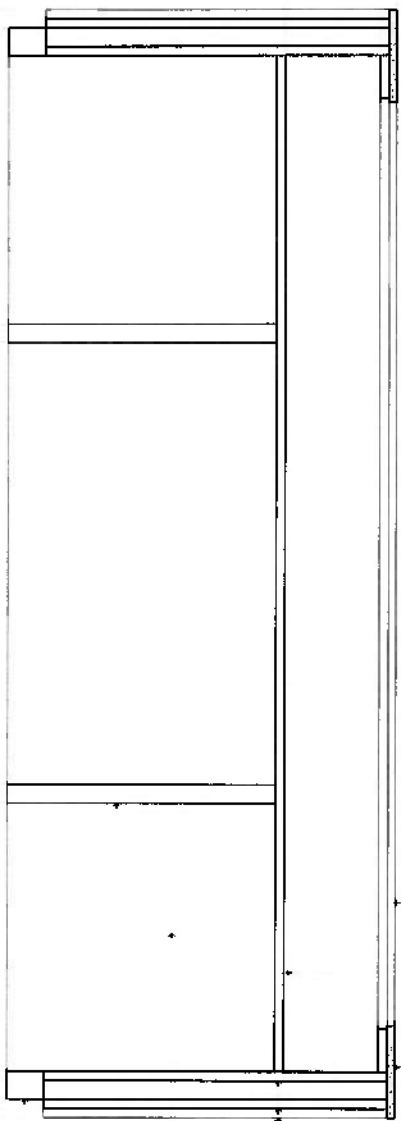

BACK VIEW
SCALE 1:10

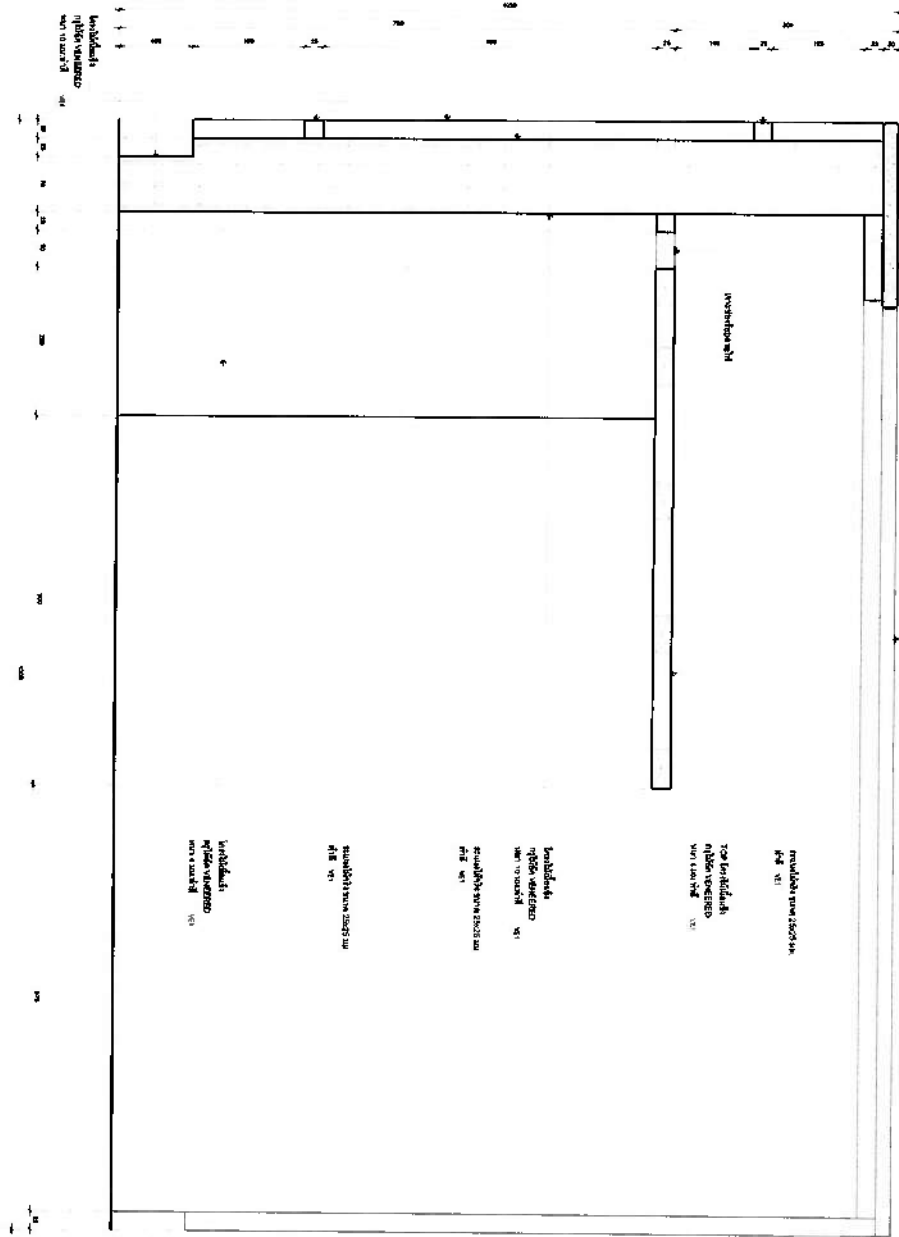


SECTION-1
SCALE 1:5

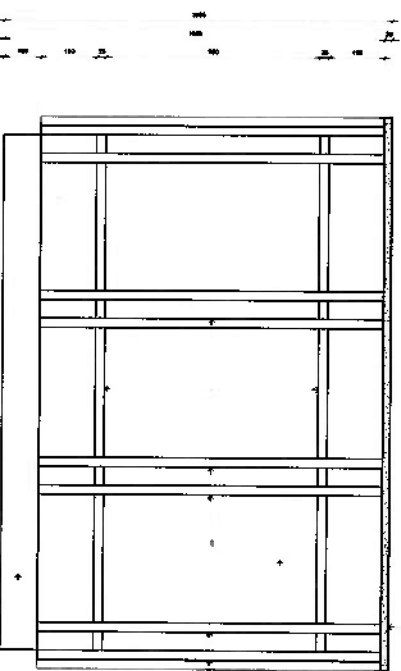


SIDE VIEW
SCALE 1:10

Project Name: <i>F43B</i>	Project Title: <i>F43B DETAIL (F43B-111)</i>
Client Name: <i>...</i>	Location: <i>...</i>
Design Name: <i>...</i>	Design No.: <i>...</i>
Scale: <i>...</i>	Scale: <i>...</i>
Drawn: <i>...</i>	Drawn: <i>...</i>
Checked: <i>...</i>	Checked: <i>...</i>
IN-B-12-02	


FB45 DETAIL (ផ្ទាំងកញ្ចក់)

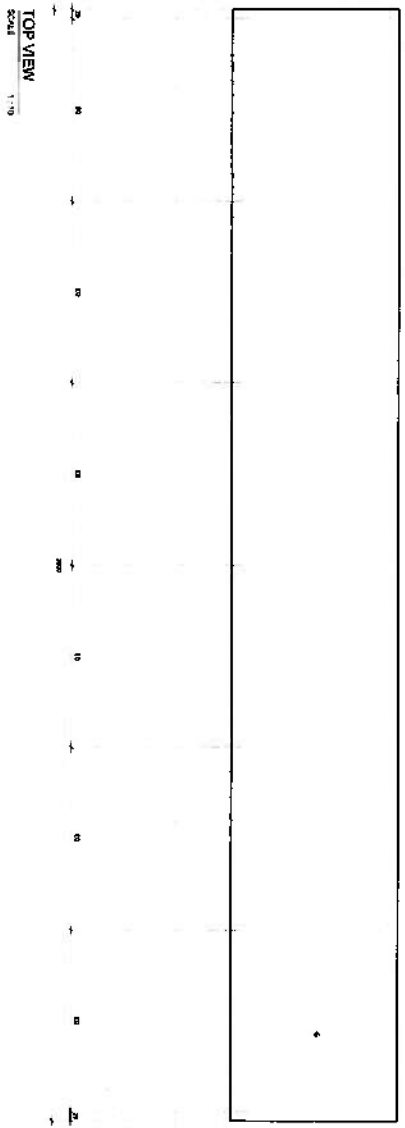


TOP VIEW
SCALE 1:10

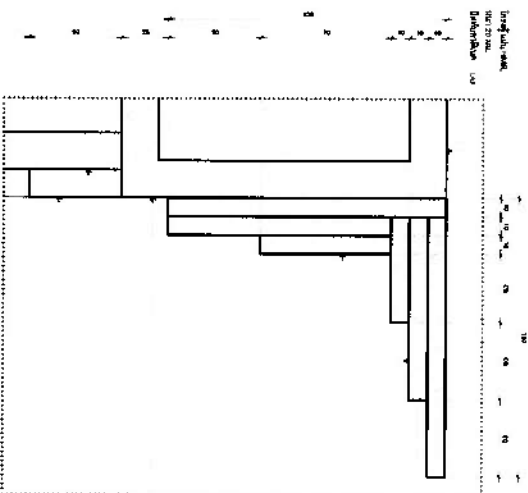


DETAIL A
SCALE 1:2

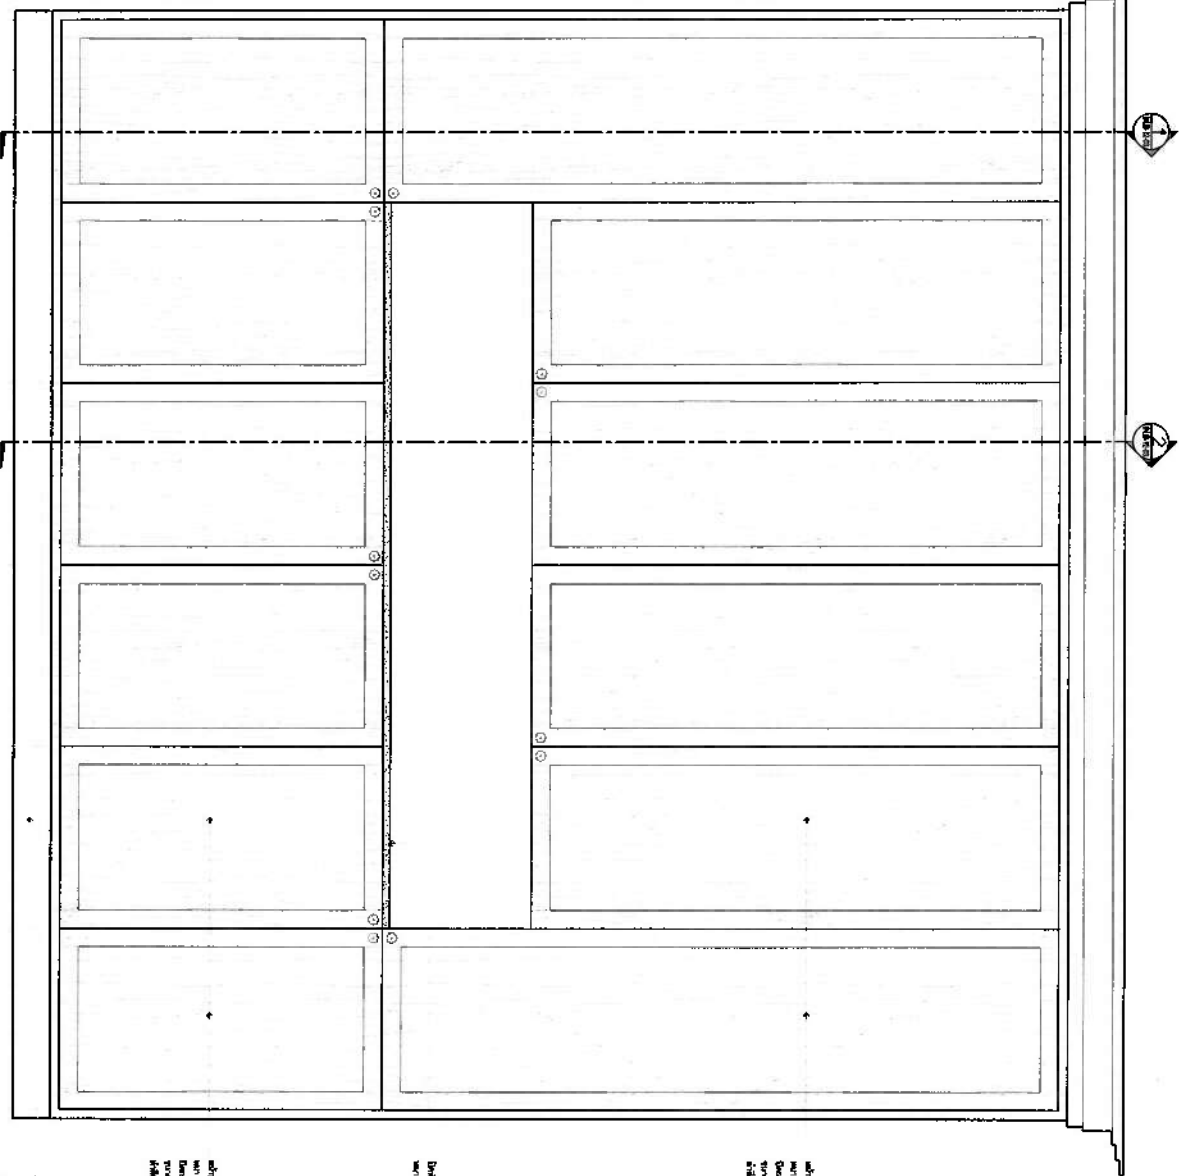


FRONT VIEW
SCALE 1:10

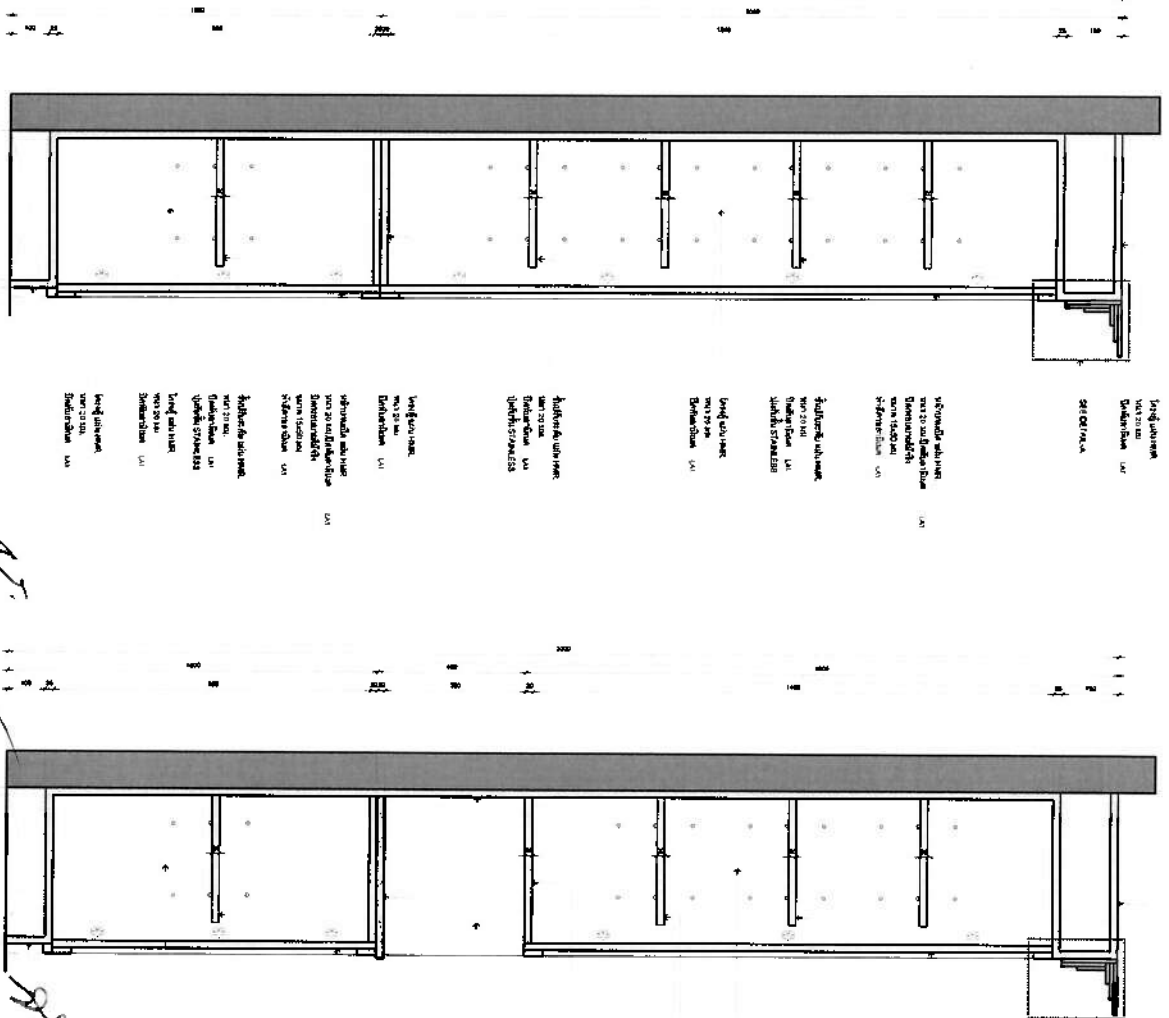

SECTION-1
SCALE 1:10

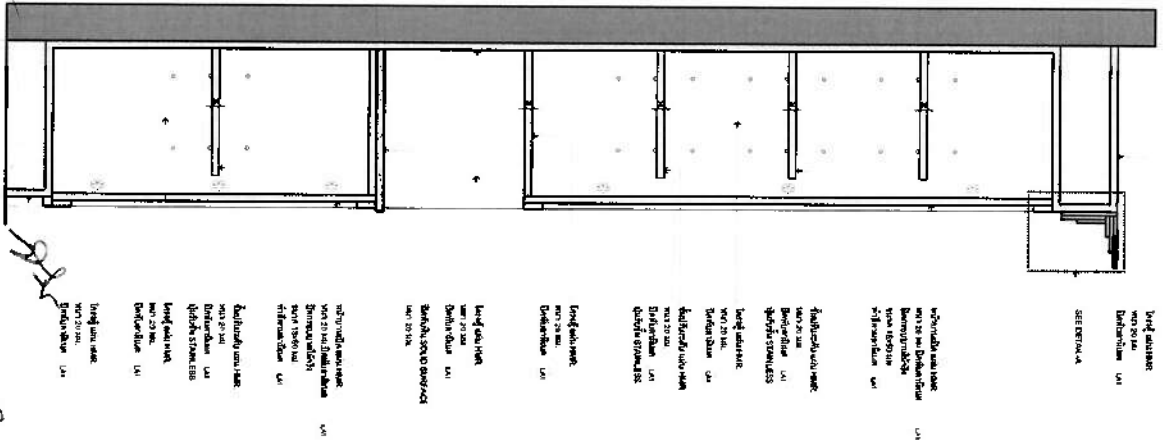

SECTION-2
SCALE 1:10

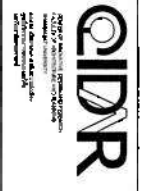

ឈ្មោះគម្រោង Project Name	ឈ្មោះអ្នករៀបចំ Prepared by
ឈ្មោះអ្នកត្រួតពិនិត្យ Checked by	ឈ្មោះអ្នកបោះពុម្ព Printed by
ឈ្មោះអ្នកបោះពុម្ព Printed by	ឈ្មោះអ្នកបោះពុម្ព Printed by


PROJECT TITLE	ឈ្មោះគម្រោង Project Name
LOCATION	ទីតាំងគម្រោង Project Location

DRAWING TITLE	ឈ្មោះគម្រោង Project Name
FB45 DETAIL (ផ្ទាំងកញ្ចក់)	

REVISION	លេខ No.	កម្រិត Level	កម្រិត Level	កម្រិត Level
NO.				
DATE				
CHECKED				
IN-B-12-03				



A 4260
B 3180
C 3430
D 3500
E 3627
F 3019
H

16 3300
17 3055
18 2724
19 2961
20 2884
21 2955
22 3080
23

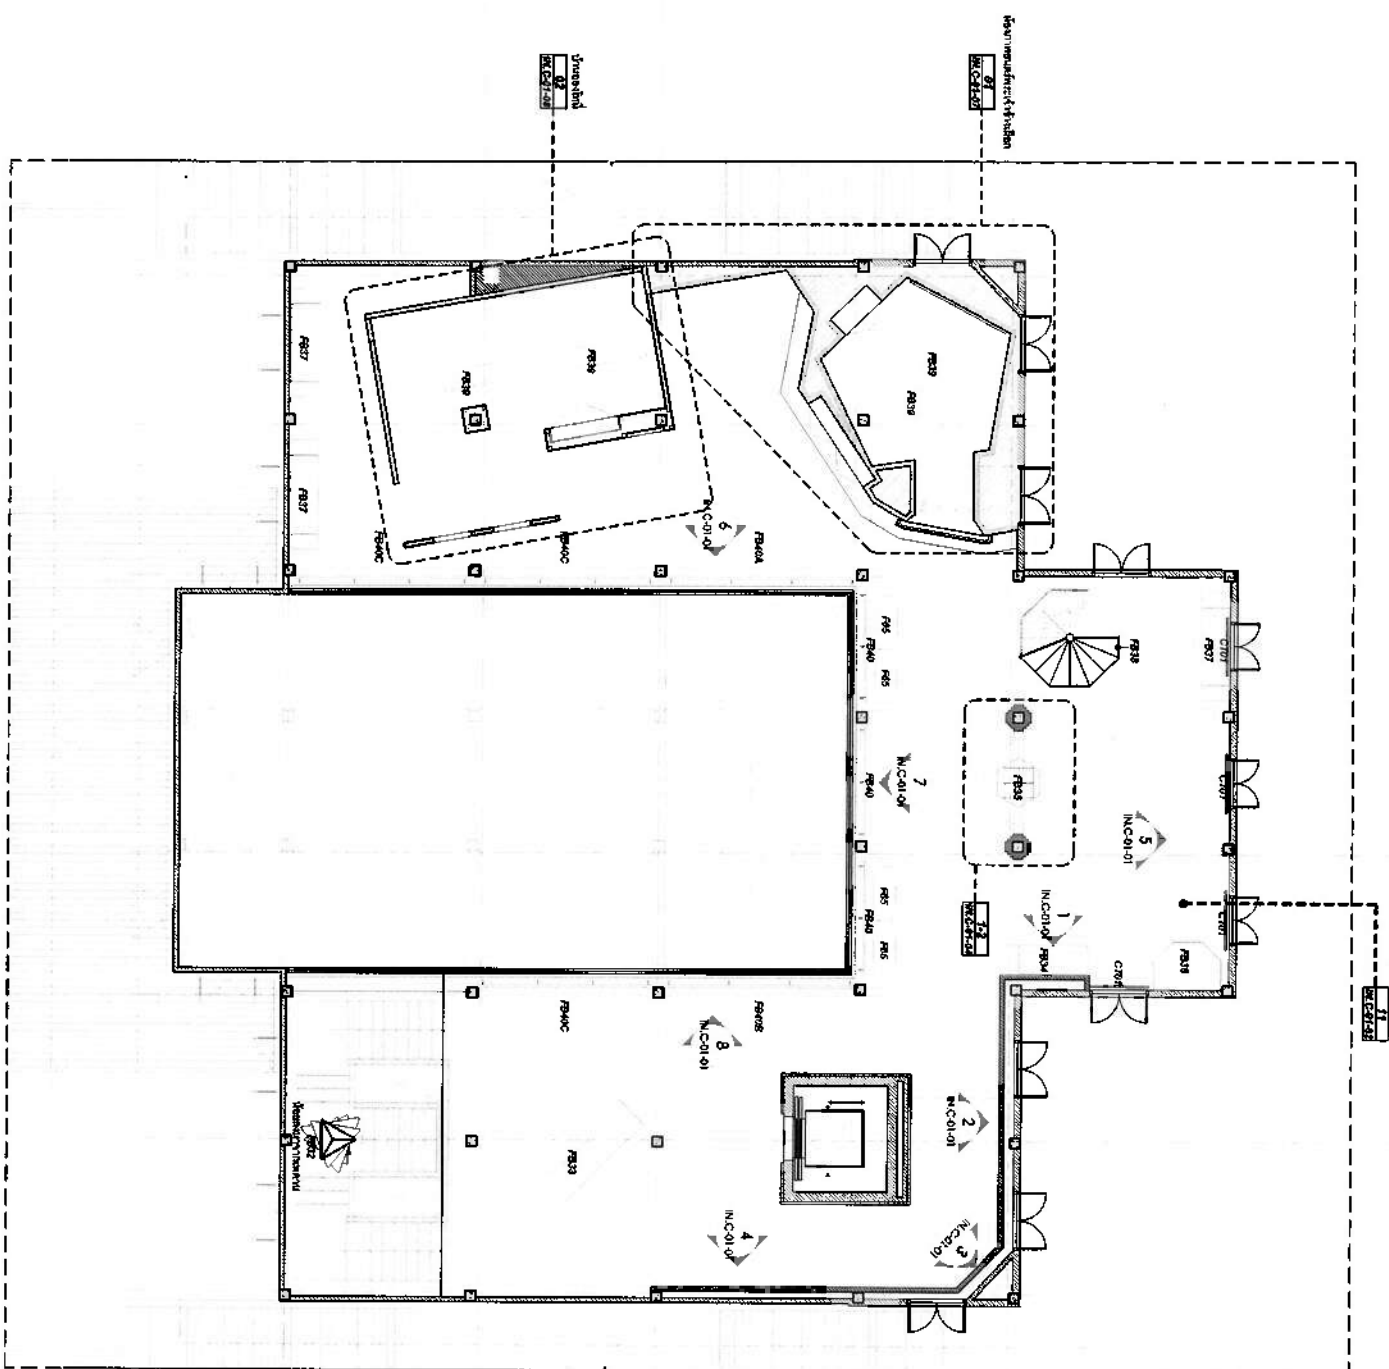

3rd FLOOR
FURNITURE LAYOUT
SCALE 1:175

GIDAR		PROJECT TITLE:		DRAWING TITLE:	
3rd FLOOR FURNITURE LAYOUT		3rd FLOOR FURNITURE LAYOUT		3rd FLOOR FURNITURE LAYOUT	
SCALE: 1:175		SCALE: 1:175		SCALE: 1:175	
DATE: 10/2000		DATE: 10/2000		DATE: 10/2000	
DRAWN BY: GIDAR		DRAWN BY: GIDAR		DRAWN BY: GIDAR	
CHECKED BY: GIDAR		CHECKED BY: GIDAR		CHECKED BY: GIDAR	
APPROVED BY: GIDAR		APPROVED BY: GIDAR		APPROVED BY: GIDAR	
PROJECT NO.: 1000		PROJECT NO.: 1000		PROJECT NO.: 1000	
DRAWING NO.: IN-C-00-01		DRAWING NO.: IN-C-00-01		DRAWING NO.: IN-C-00-01	

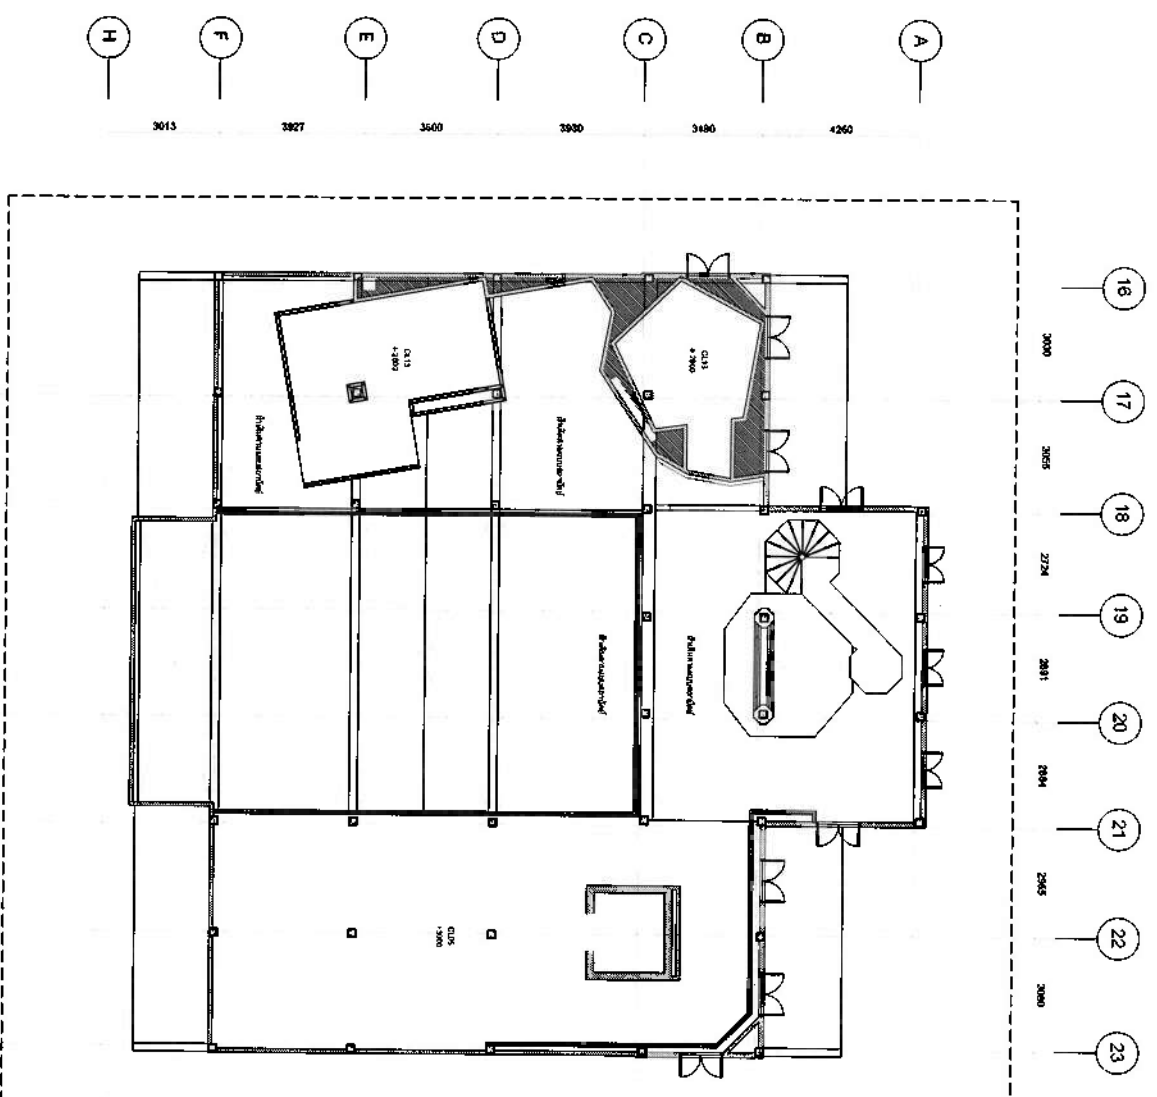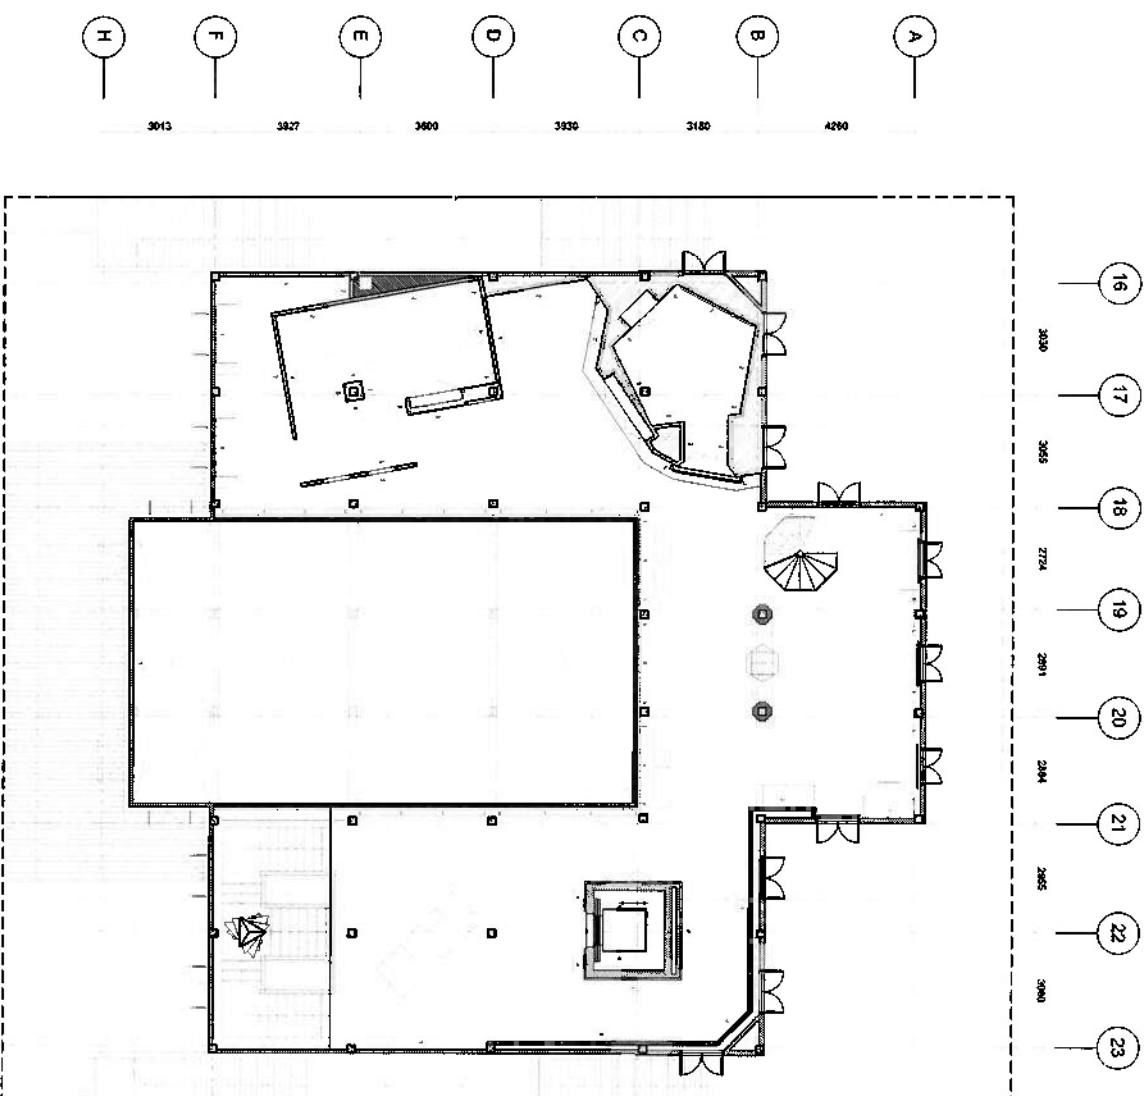


2nd FLOOR WALL PLAN

3rd FLOOR CEILING PLAN

QIDAR QIDAR ENGINEERING & ARCHITECTURE 10000 1st Avenue, Suite 100, San Diego, CA 92121 Tel: (619) 584-1234 Fax: (619) 584-1235 Email: info@qidar.com Website: www.qidar.com		PROJECT TITLE: 3rd Floor Wall Plan 3rd Floor Ceiling Plan		DRAWING TITLE: 3rd Floor Wall Plan 3rd Floor Ceiling Plan		REVISION: NO. DESCRIPTION 1. Initial Design 2. Final Design 3. Final Design		JOB NO.: 10000-00-02		CREDITED: 10000-00-02	
CLIENT: 10000 1st Avenue, Suite 100, San Diego, CA 92121 Tel: (619) 584-1234 Fax: (619) 584-1235 Email: info@qidar.com Website: www.qidar.com		PROJECT TITLE: 3rd Floor Wall Plan 3rd Floor Ceiling Plan		DRAWING TITLE: 3rd Floor Wall Plan 3rd Floor Ceiling Plan		REVISION: NO. DESCRIPTION 1. Initial Design 2. Final Design 3. Final Design		JOB NO.: 10000-00-02		CREDITED: 10000-00-02	
PROJECT TITLE: 3rd Floor Wall Plan 3rd Floor Ceiling Plan		DRAWING TITLE: 3rd Floor Wall Plan 3rd Floor Ceiling Plan		REVISION: NO. DESCRIPTION 1. Initial Design 2. Final Design 3. Final Design		JOB NO.: 10000-00-02		CREDITED: 10000-00-02		10000-00-02	

A 4260 B 3180 C 3820 D 3600 E 3827 F 3013 H

16 3830 17 3855 18 2724 19 2831 20 2864 21 2865 22 3880 23

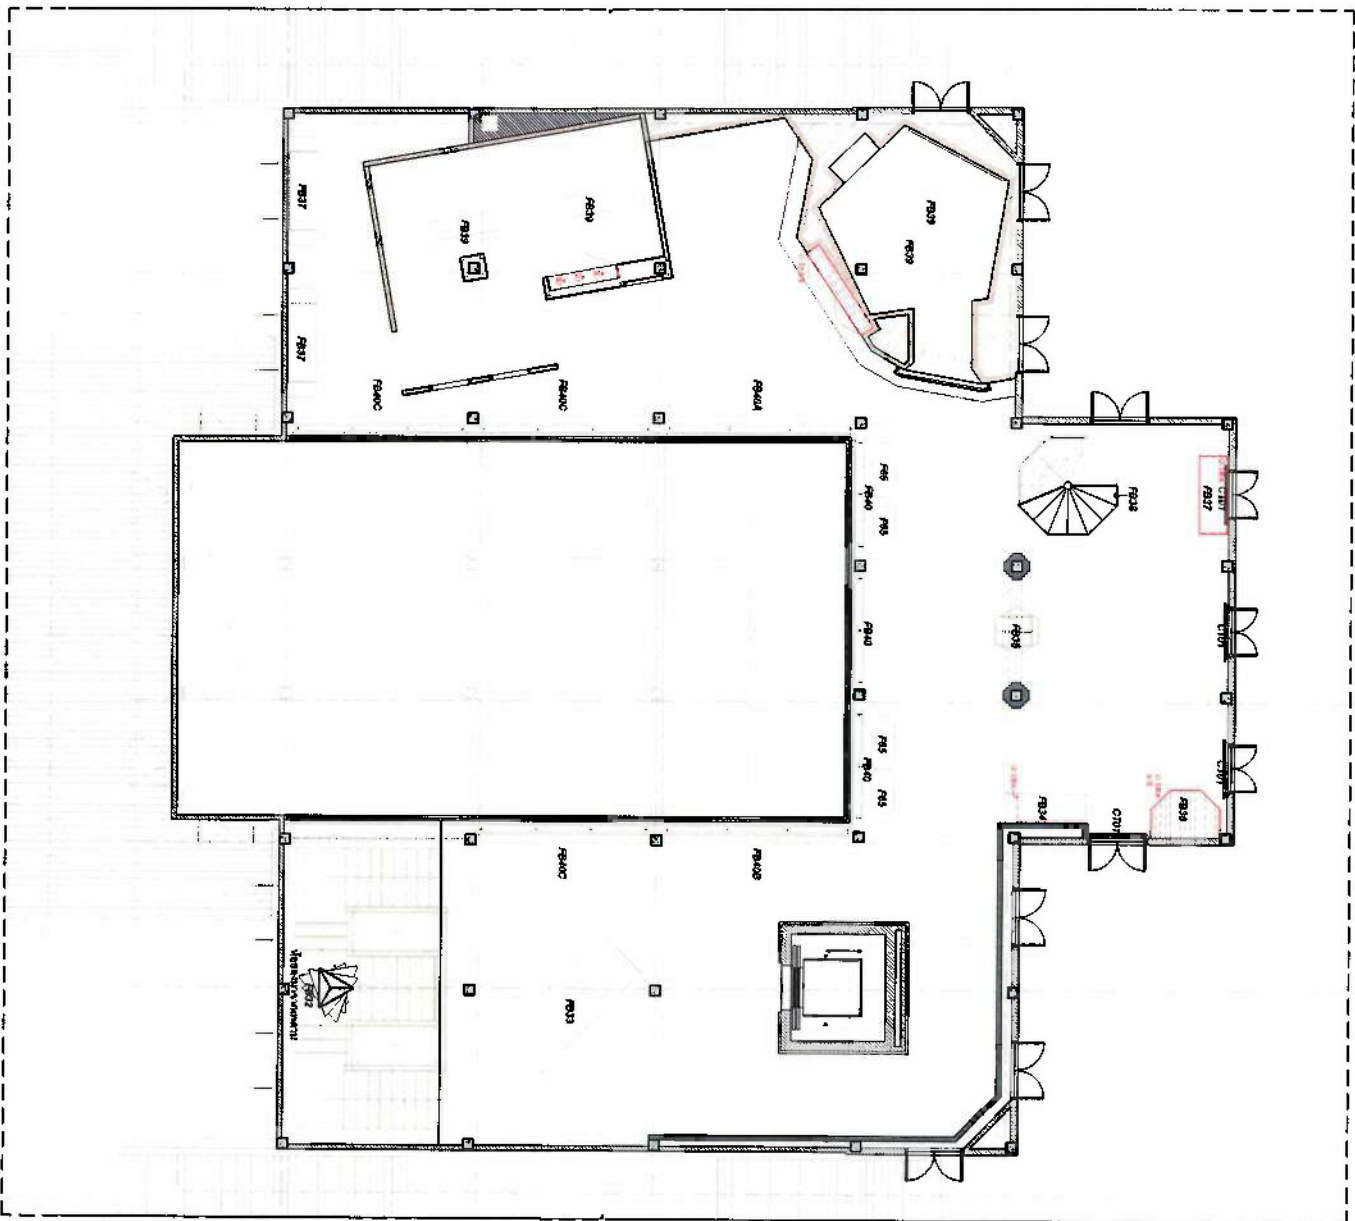

3rd FLOOR
LIGHTING FOR EXHIBITION
SCALE 1/15


CODE	DESCRIPTION	REMARKS
1	1.1	1.1.1
2	2.1	2.1.1
3	3.1	3.1.1

Handwritten notes and signatures in blue ink, including 'N', 'AS', 'SEA', and 'N'.

QIDAR Qatar International Design and Architecture Research P.O. Box 11111, Doha, Qatar Tel: +965 4400 1111 Fax: +965 4400 1112 Email: info@qidar.qa		Project Title: 3rd FLOOR LIGHTING FOR EXHIBITION		Drawing No.: INC-00-03	
Client: 3rd Floor	Architect: 3rd Floor	Scale: 1/15	Author: 3rd Floor	Checker: 3rd Floor	Date: 3rd Floor
Project No.: 3rd Floor	Revision: 3rd Floor	Scale: 1/15	Author: 3rd Floor	Checker: 3rd Floor	Date: 3rd Floor
Project No.: 3rd Floor	Revision: 3rd Floor	Scale: 1/15	Author: 3rd Floor	Checker: 3rd Floor	Date: 3rd Floor

- 16 3030
- 17 3065
- 18 2724
- 19 2891
- 20 2844
- 21 2955
- 22 3080
- 23

- A 4260
- B 3180
- C 3830
- D 3880
- E 3827
- F 3013
- H

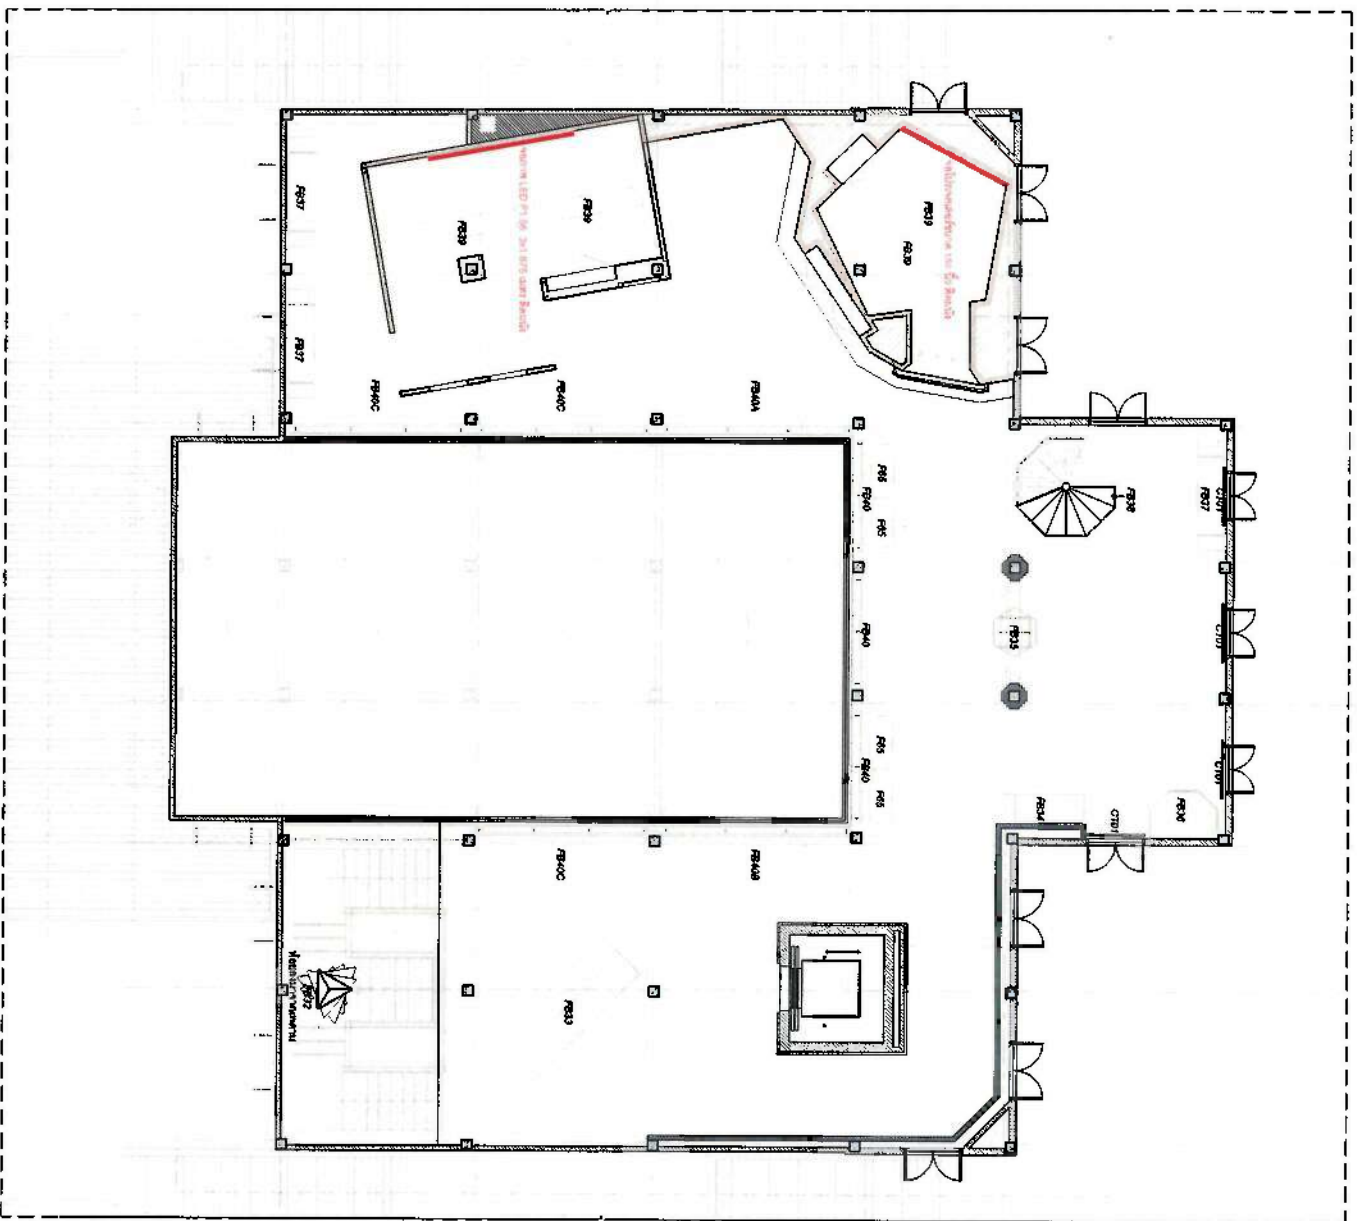

3rd FLOOR
MEDIA PLAN
1
SCALE 1/75

QIDAR QIDAR CONSULTING & DESIGN 10000 1st Avenue, Suite 100 San Diego, CA 92121 Phone: (619) 594-1000 Fax: (619) 594-1001 Email: info@qidar.com		Revision: 1 Date: 10/10/2003 Drawn: [Signature] Checked: [Signature] Scale: 1/75 Drawing No.: IN-C-00-04	
Project Name: 3rd Floor Media Room Project No.: 10000 Client: [Signature] Architect: [Signature] Engineer: [Signature]		Project Title: 3rd Floor Media Room Location: 10000 1st Avenue, Suite 100 Notes: [Handwritten notes]	





Handwritten notes and signatures in blue ink, including initials and a signature, located at the bottom right of the drawing.

หน้าหลัง 3 ส่วน มีลักษณะดังนี้

หน้าหลัง 3 ส่วน มีลักษณะดังนี้

หน้าหลัง 3 ส่วน มีลักษณะดังนี้

หน้าหลัง 3 ส่วน มีลักษณะดังนี้

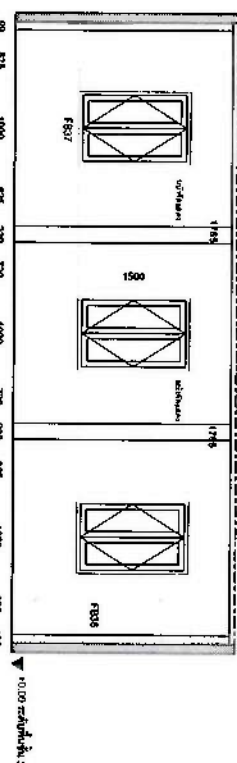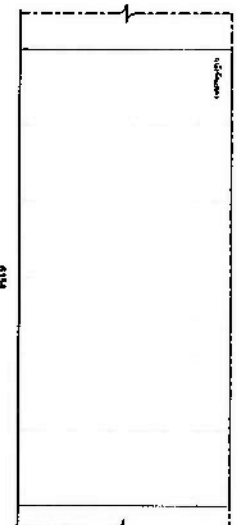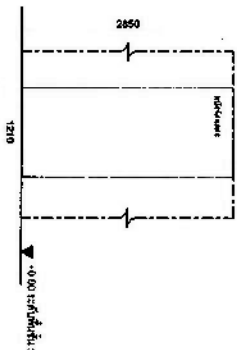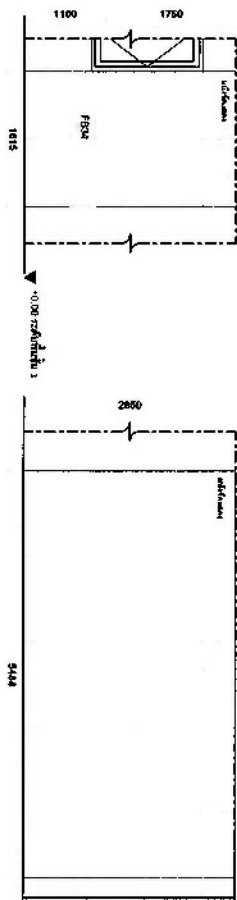




1 ELEVATION
SCALE 1:50

2 ELEVATION
SCALE 1:50

3 ELEVATION
SCALE 1:50

4 ELEVATION
SCALE 1:50

5 ELEVATION
SCALE 1:50





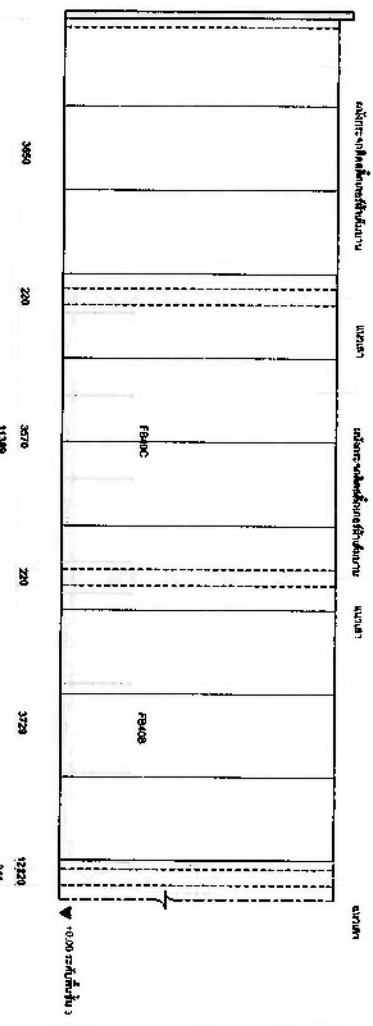
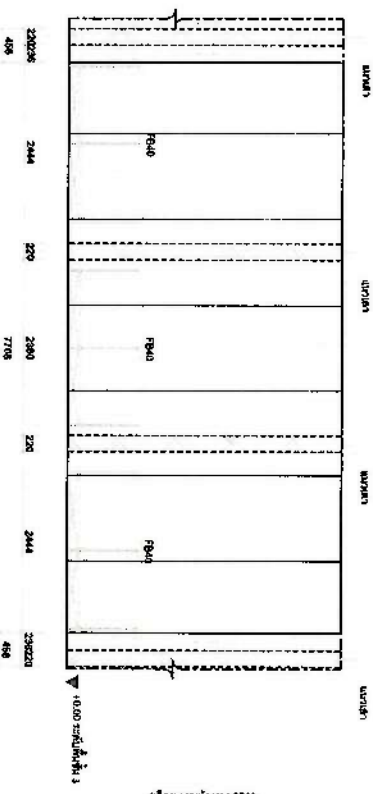
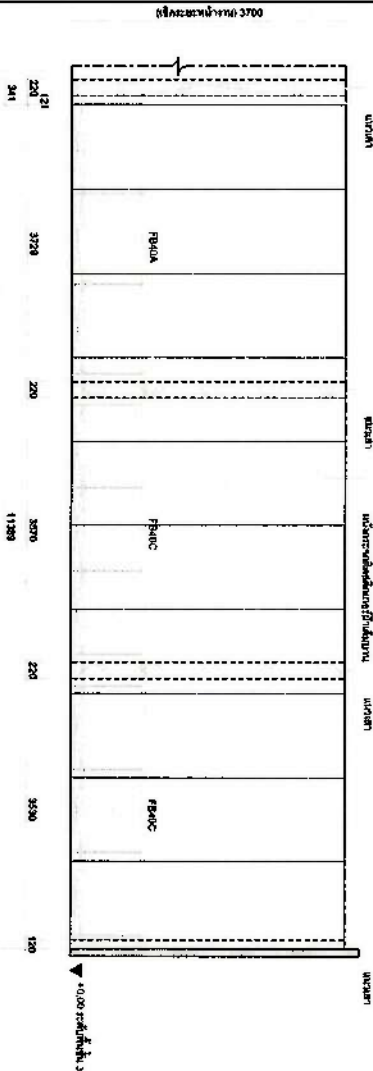


6 ELEVATION
SCALE 1:50

7 ELEVATION
SCALE 1:50

8 ELEVATION
SCALE 1:50

รูปทรงหลังคา 3 ส่วน มีลักษณะดังนี้
มีลักษณะเป็นรูปสามเหลี่ยม
มีลักษณะเป็นรูปสามเหลี่ยม

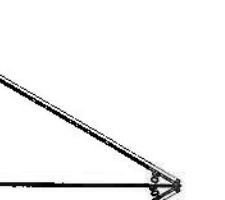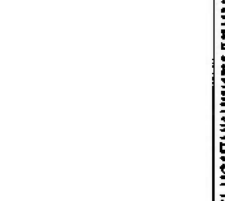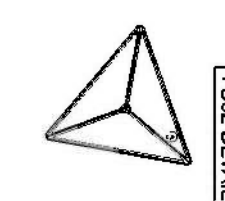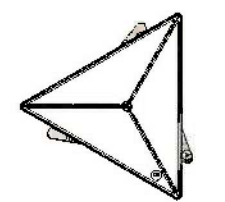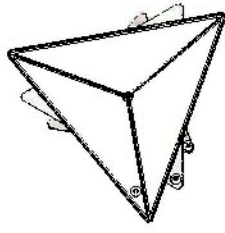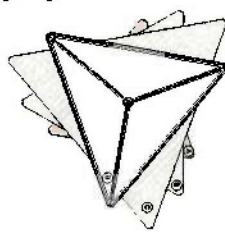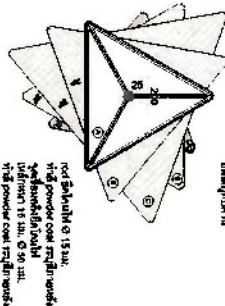

FB32 DETAIL (ในลักษณะที่ปรากฏ - ความละเอียด)

A TOP VIEW
SCALE 1:20

B TOP VIEW
SCALE 1:20

C TOP VIEW
SCALE 1:20

A TOP VIEW
SCALE 1:20

B TOP VIEW
SCALE 1:20

C TOP VIEW
SCALE 1:20

A TOP VIEW
SCALE 1:20









B TOP VIEW
SCALE 1:20

C TOP VIEW
SCALE 1:20

A TOP VIEW
SCALE 1:20

B TOP VIEW
SCALE 1:20

C TOP VIEW
SCALE 1:20

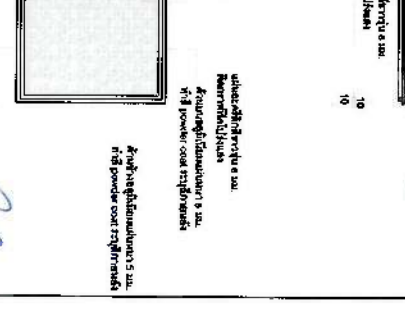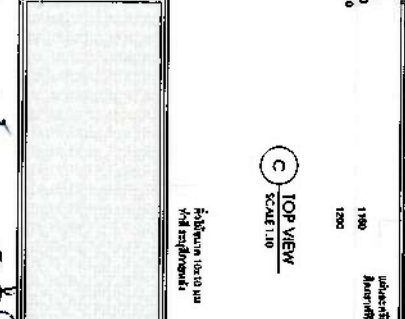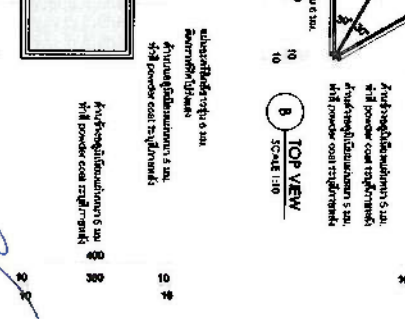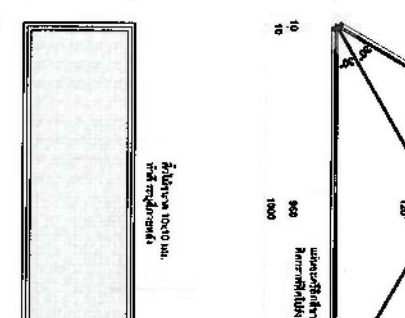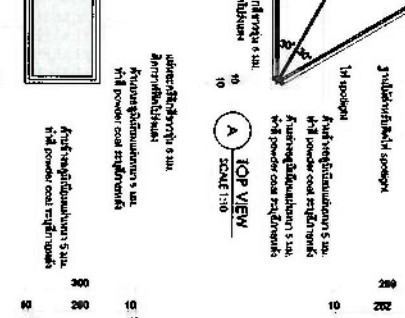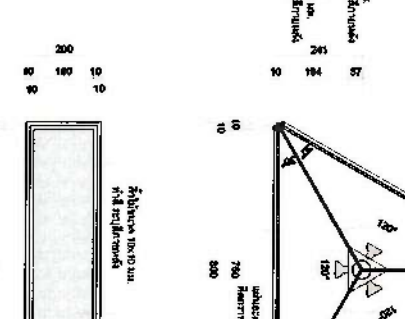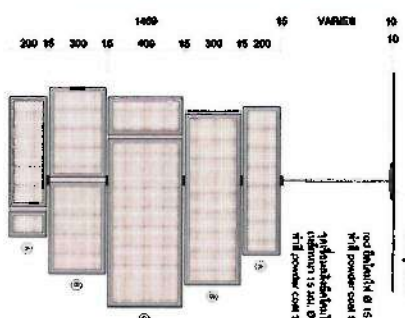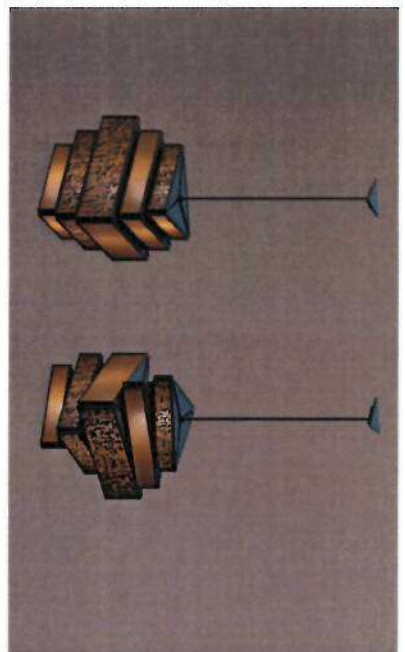

1 SIDE VIEW
SCALE 1:20

A SIDE VIEW
SCALE 1:20

B SIDE VIEW
SCALE 1:20

C SIDE VIEW
SCALE 1:20

A SIDE VIEW
SCALE 1:20

B SIDE VIEW
SCALE 1:20

C SIDE VIEW
SCALE 1:20

A SIDE VIEW
SCALE 1:20

B SIDE VIEW
SCALE 1:20

C SIDE VIEW
SCALE 1:20

QIDAR




QIDAR

ชื่อโครงการ	ชื่อโครงการ
ชื่ออาคาร	ชื่ออาคาร
ชื่อพื้นที่	ชื่อพื้นที่
ชื่อพื้นที่	ชื่อพื้นที่



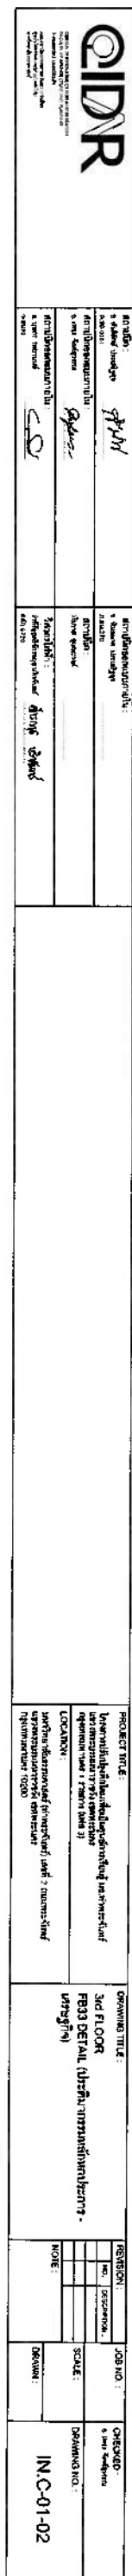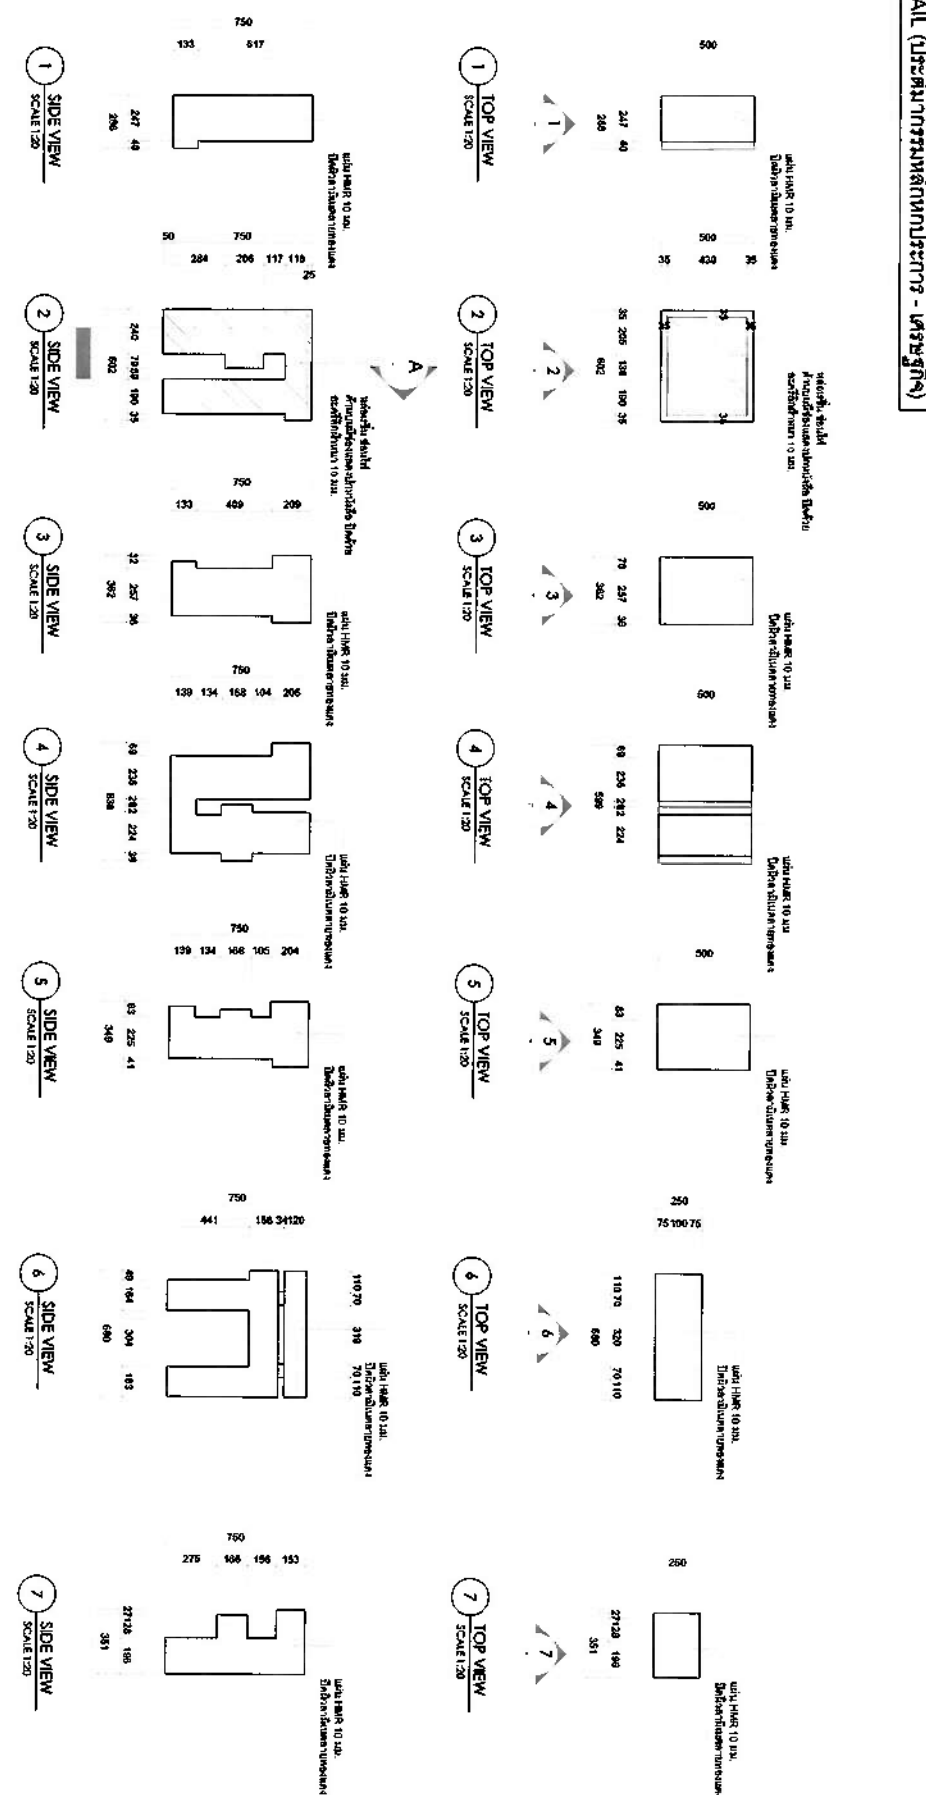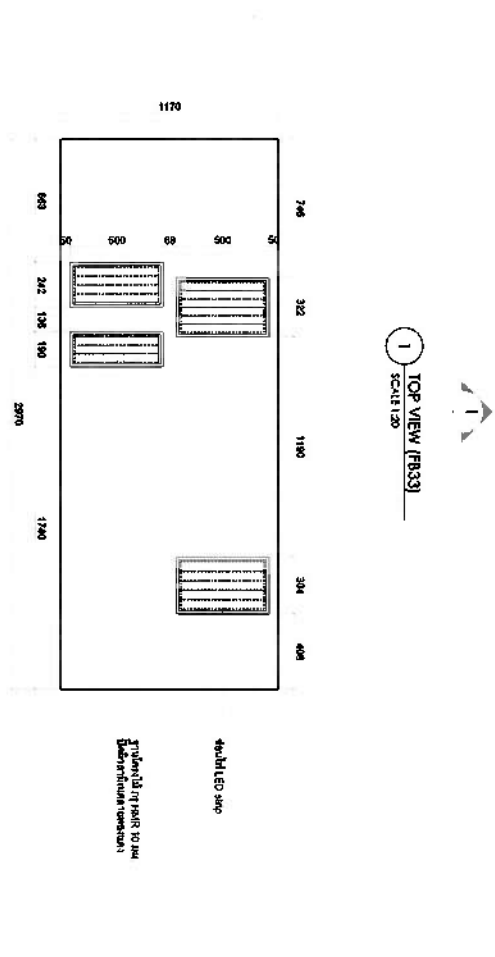


FB33 DETAIL (ประตูหน้าต่างเหล็กทึบกระจก - กระจกใส)

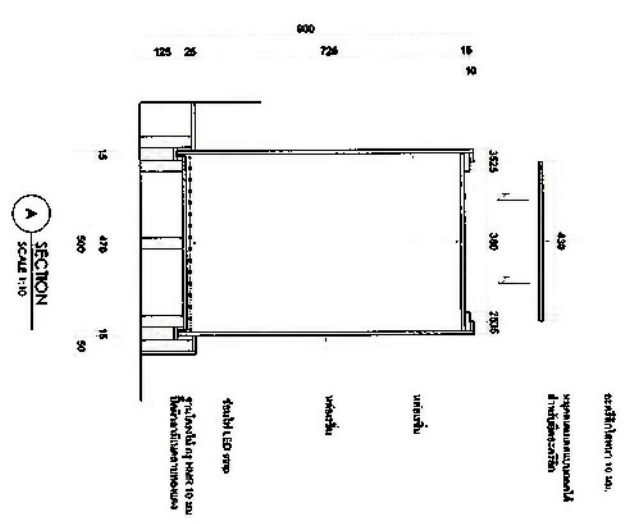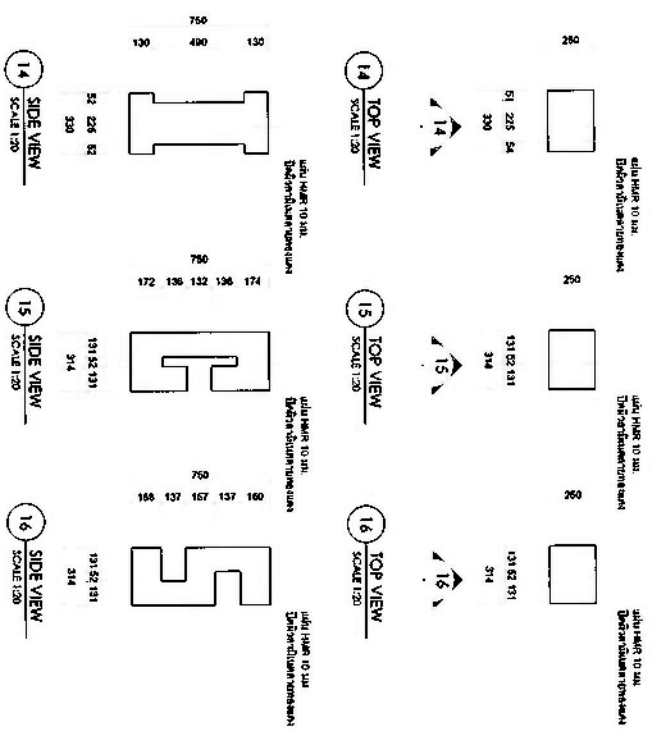



FB34 DETAIL (ตู้เก็บเศษแขวนผนัง)

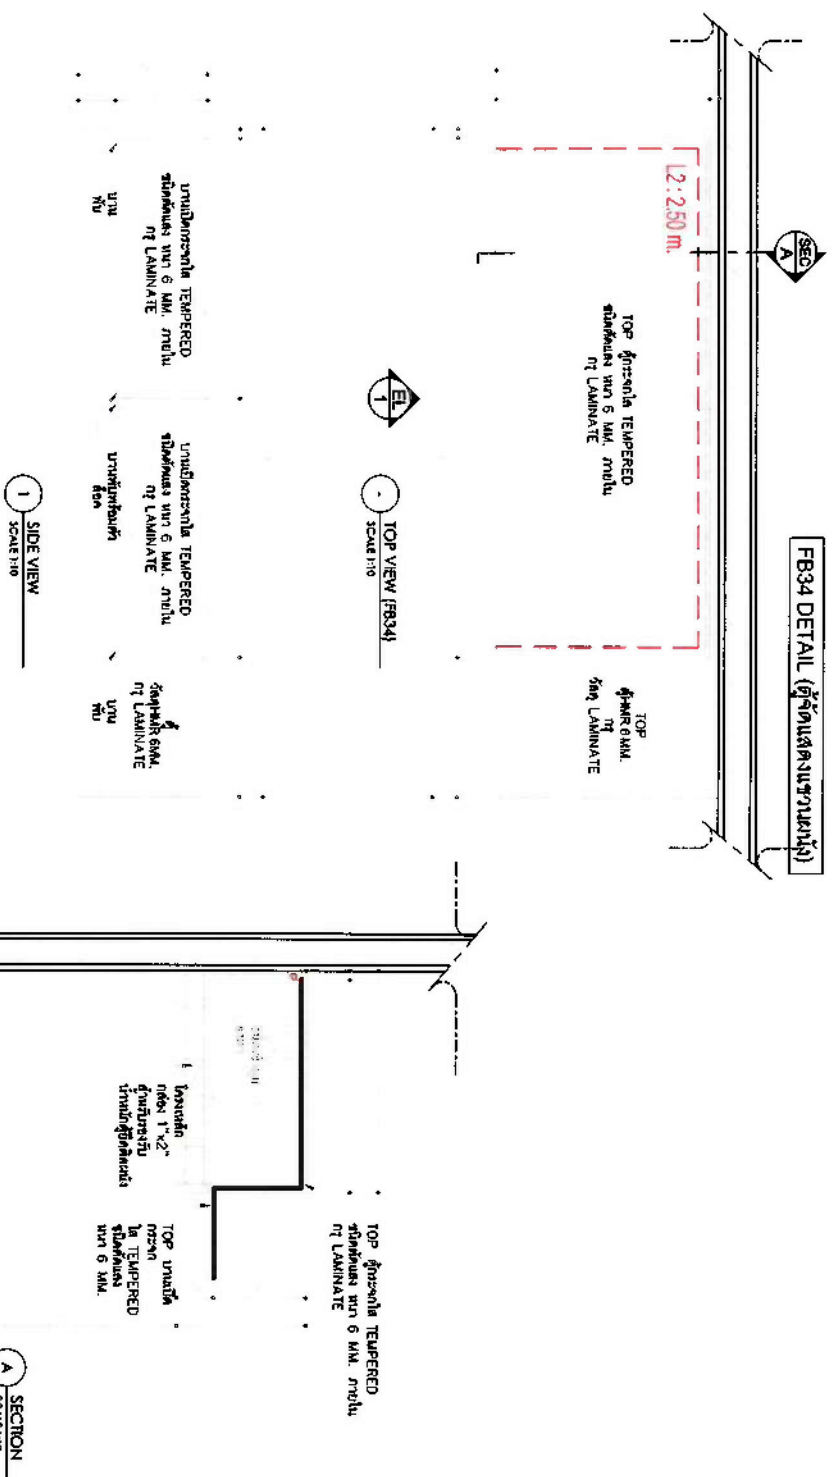


FB37 DETAIL (ตู้เก็บเศษแขวนผนัง)

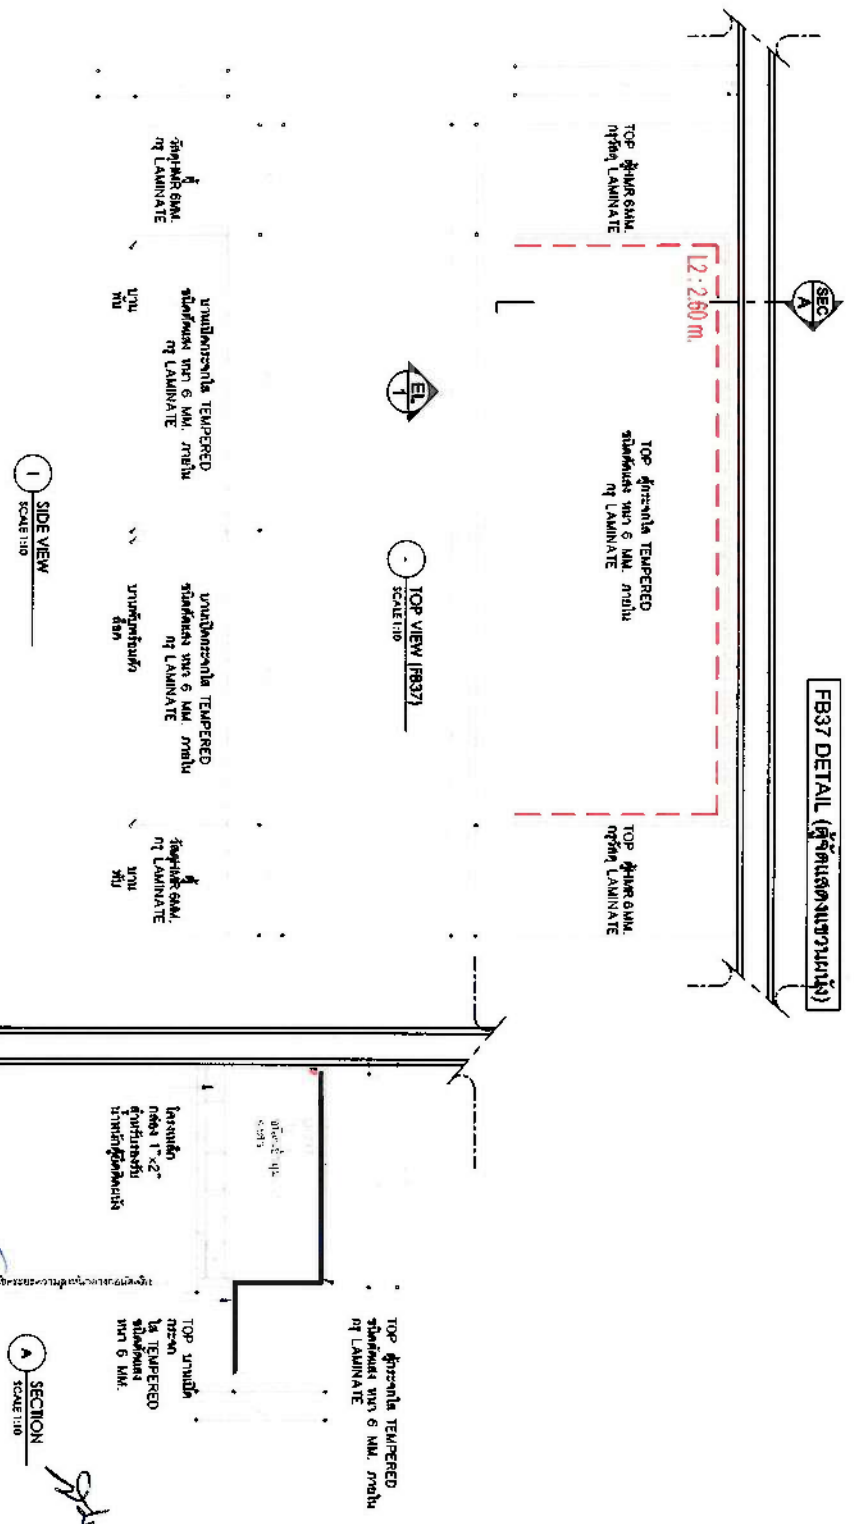


QIDOR	
บริษัท อีคิว ดีไซน์ จำกัด 101/101 หมู่ 10 ถนนสุขุมวิท แขวงคลองเตย เขตคลองเตย กรุงเทพมหานคร 10110	บริษัท อีคิว ดีไซน์ จำกัด 101/101 หมู่ 10 ถนนสุขุมวิท แขวงคลองเตย เขตคลองเตย กรุงเทพมหานคร 10110
ชื่อโครงการ : FB33 DETAIL (ประตูหน้าต่างเหล็กทึบกระจก - กระจกใส)	ชื่อโครงการ : FB33 DETAIL (ประตูหน้าต่างเหล็กทึบกระจก - กระจกใส)
ชื่อผู้จัดทำ : [Signature]	ชื่อผู้จัดทำ : [Signature]
ชื่อผู้ตรวจสอบ : [Signature]	ชื่อผู้ตรวจสอบ : [Signature]
ชื่อผู้อนุมัติ : [Signature]	ชื่อผู้อนุมัติ : [Signature]
วันที่อนุมัติ : 10/10/2563	วันที่อนุมัติ : 10/10/2563
ชื่อโครงการ : FB34 DETAIL (ตู้เก็บเศษแขวนผนัง)	ชื่อโครงการ : FB34 DETAIL (ตู้เก็บเศษแขวนผนัง)
ชื่อผู้จัดทำ : [Signature]	ชื่อผู้จัดทำ : [Signature]
ชื่อผู้ตรวจสอบ : [Signature]	ชื่อผู้ตรวจสอบ : [Signature]
ชื่อผู้อนุมัติ : [Signature]	ชื่อผู้อนุมัติ : [Signature]
วันที่อนุมัติ : 10/10/2563	วันที่อนุมัติ : 10/10/2563
ชื่อโครงการ : FB37 DETAIL (ตู้เก็บเศษแขวนผนัง)	ชื่อโครงการ : FB37 DETAIL (ตู้เก็บเศษแขวนผนัง)
ชื่อผู้จัดทำ : [Signature]	ชื่อผู้จัดทำ : [Signature]
ชื่อผู้ตรวจสอบ : [Signature]	ชื่อผู้ตรวจสอบ : [Signature]
ชื่อผู้อนุมัติ : [Signature]	ชื่อผู้อนุมัติ : [Signature]
วันที่อนุมัติ : 10/10/2563	วันที่อนุมัติ : 10/10/2563

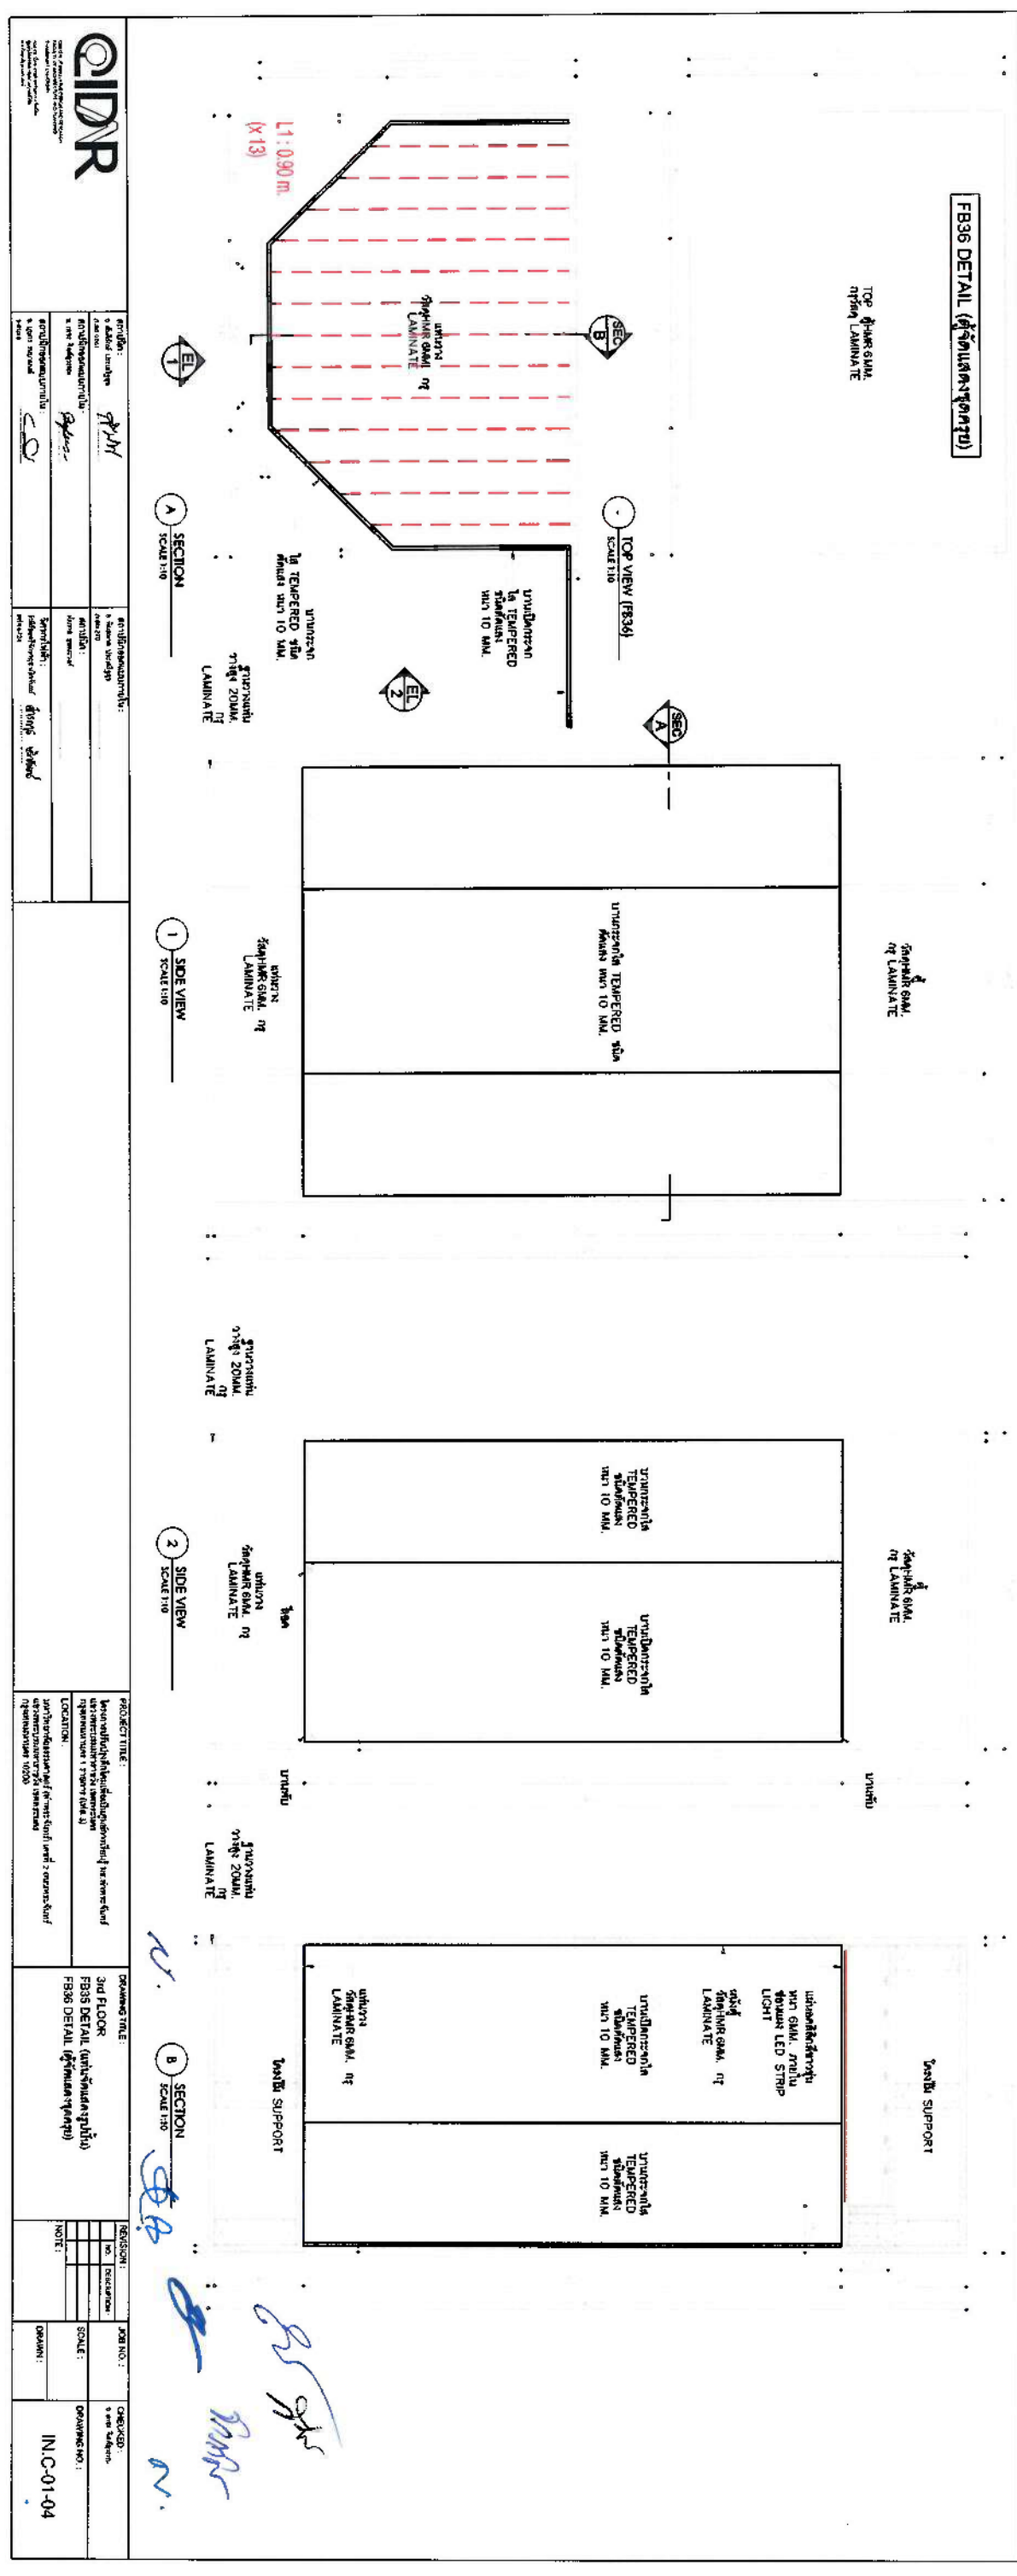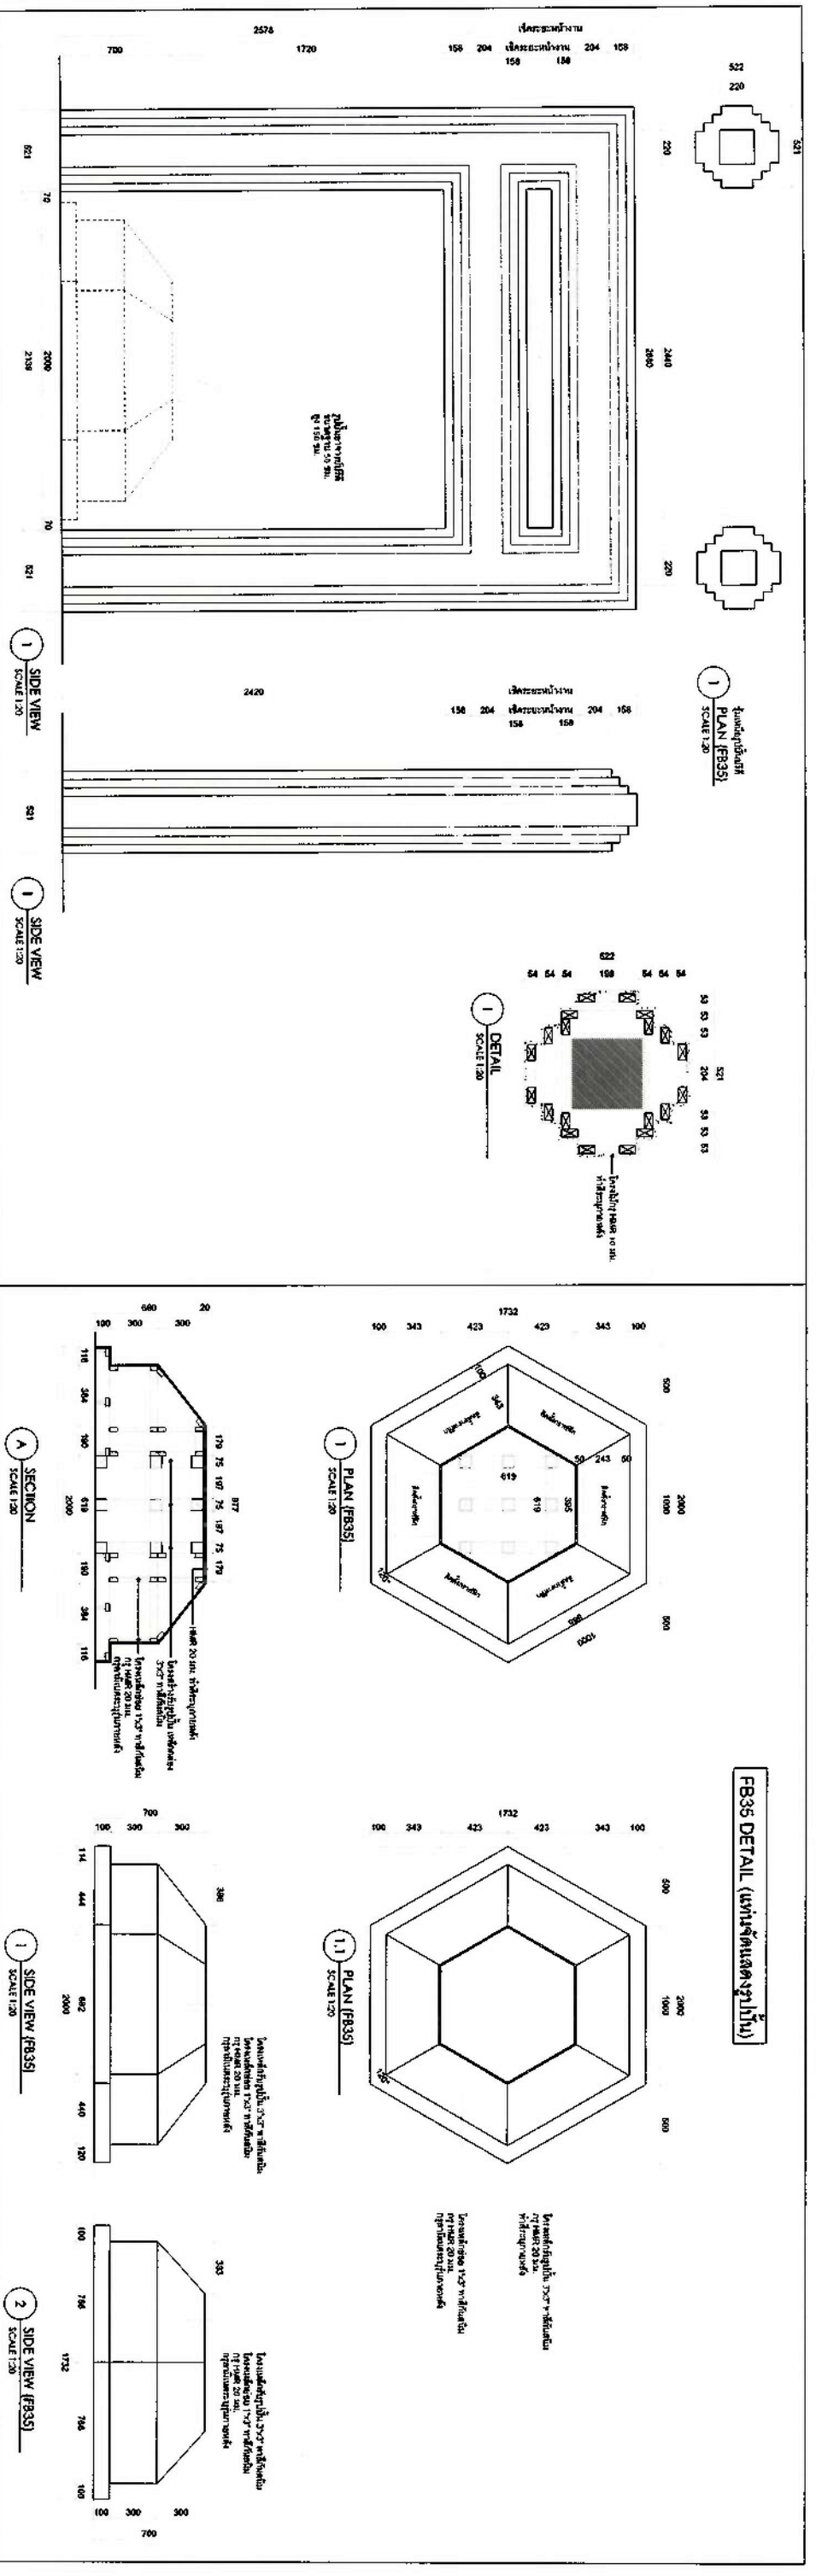








FB38 DETAIL (พรมไม้)

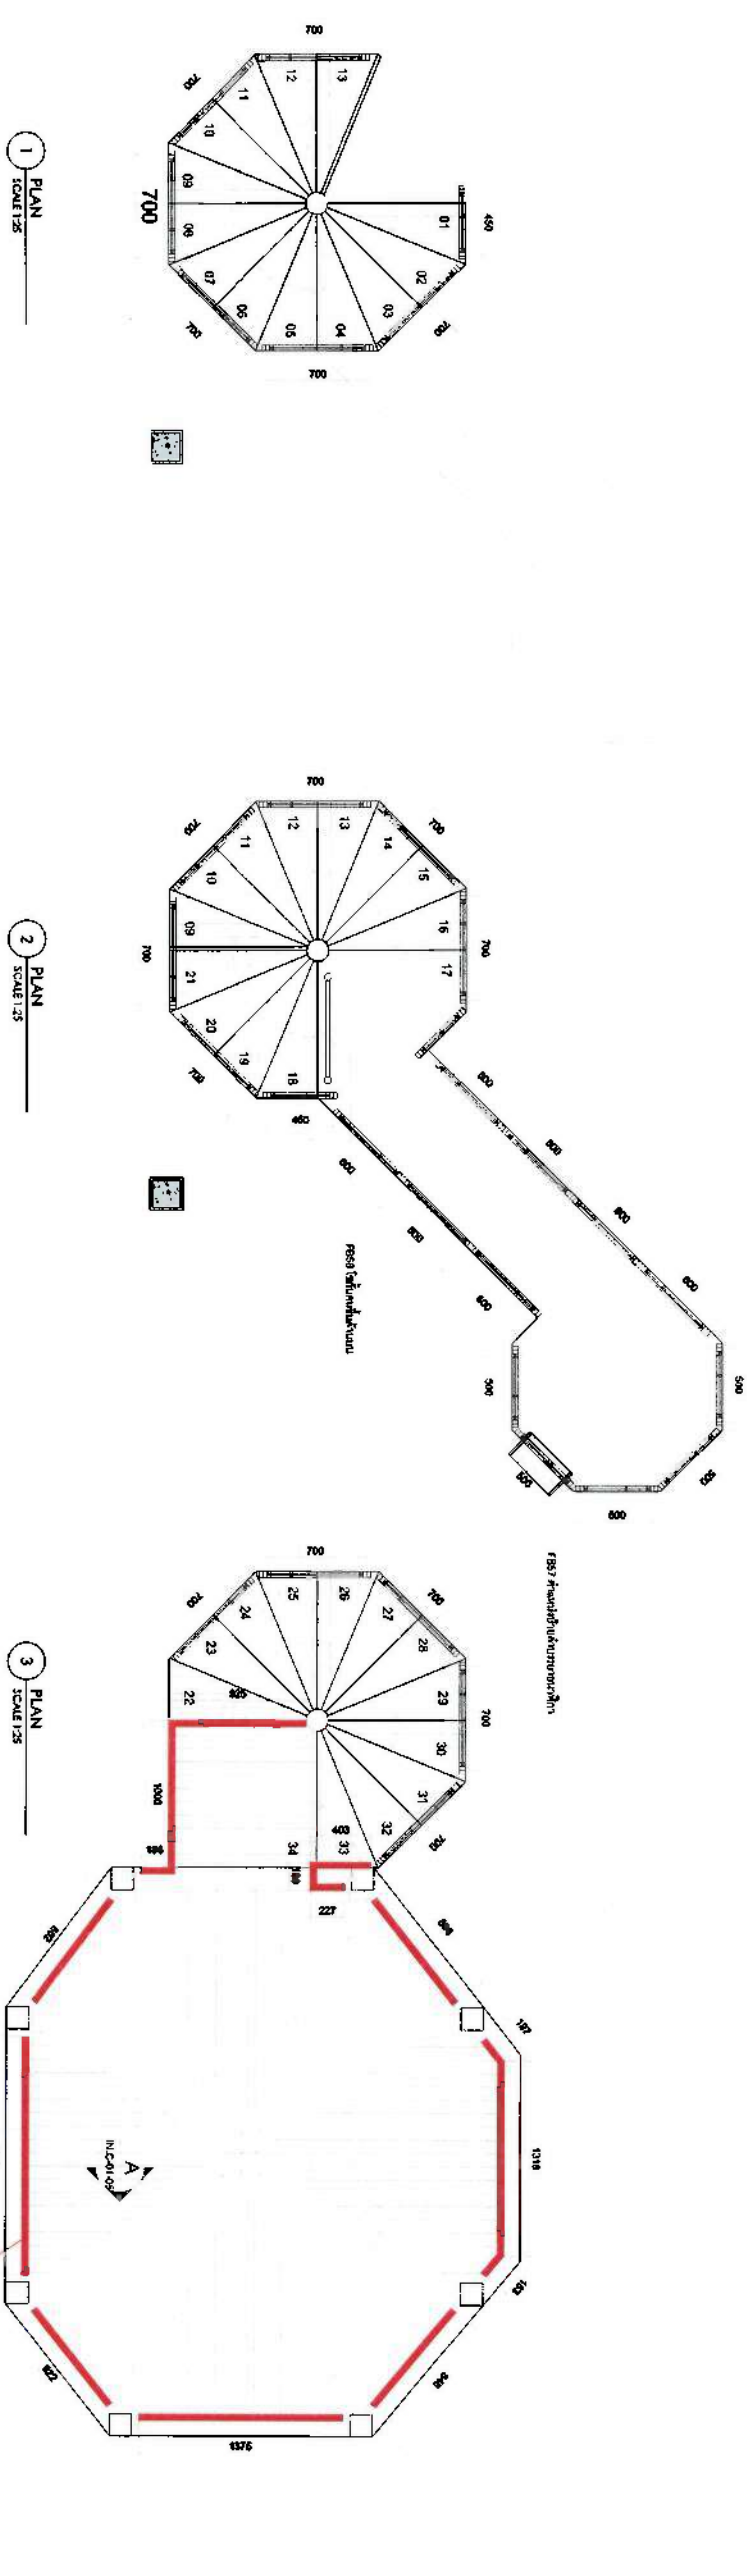


FB57 DETAIL (ไม้พรมพรมไม้)

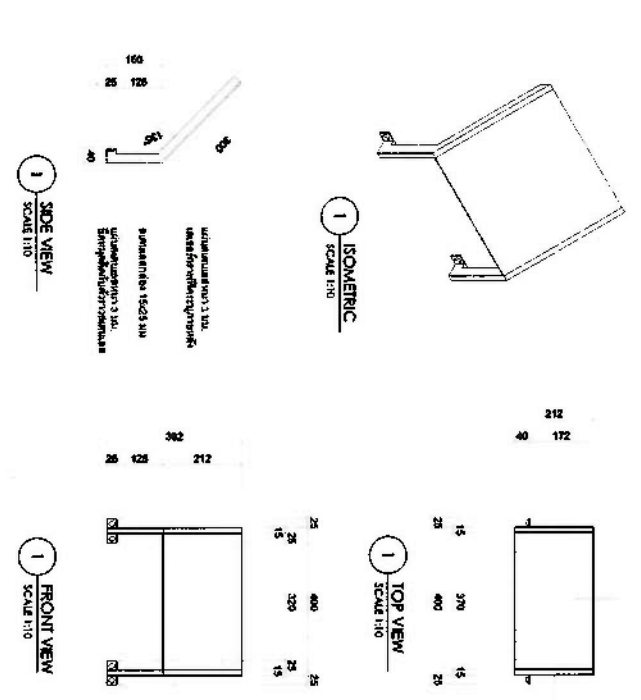


QIDR	
บริษัท อีดีอาร์ จำกัด	
เลขที่ 100/1 ถนนสุขุมวิท แขวงคลองเตย เขตคลองเตย กรุงเทพมหานคร 10110	
โทรศัพท์ 02-261-1111 โทรสาร 02-261-1112	
เว็บไซต์ www.qidr.com	
E-mail: info@qidr.com	
Fax: 02-261-1112	
Project Title: FB38 DETAIL (พรมไม้)	
Drawing Title: FB38 DETAIL (พรมไม้)	
Revision:	
Scale: 1:25	
Drawing No.: IN-C-01-05	

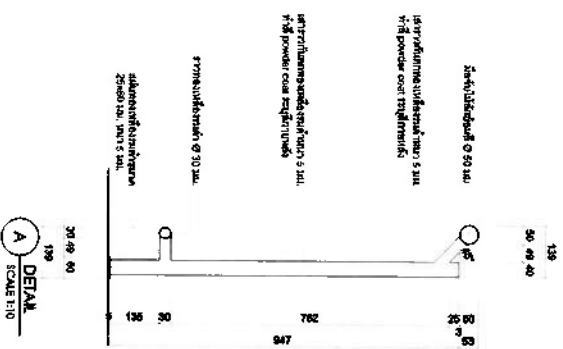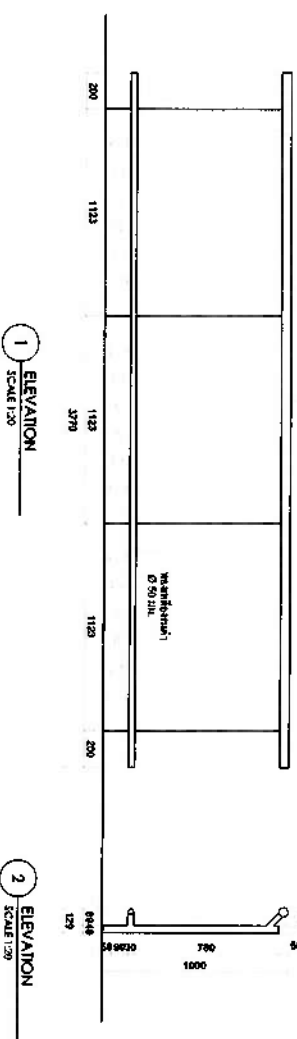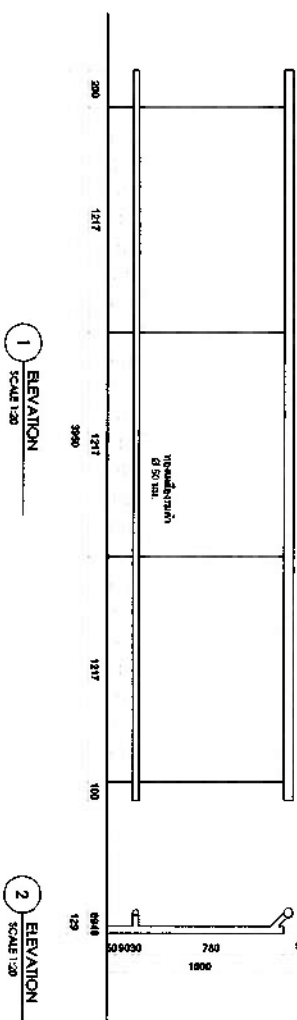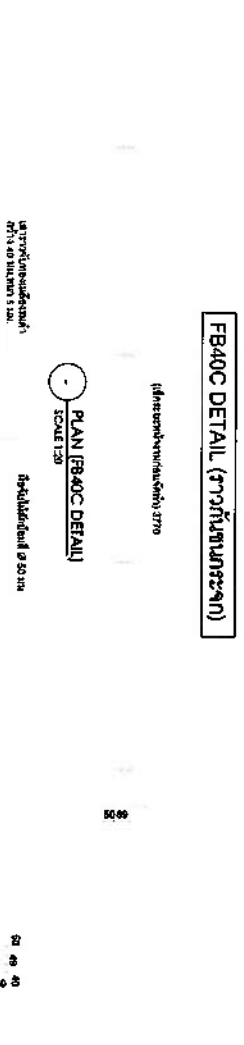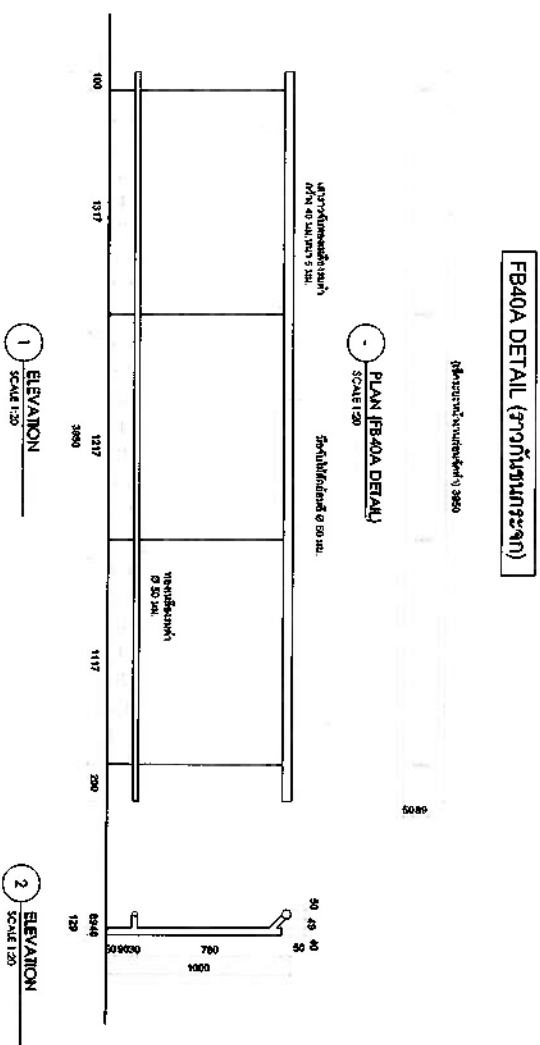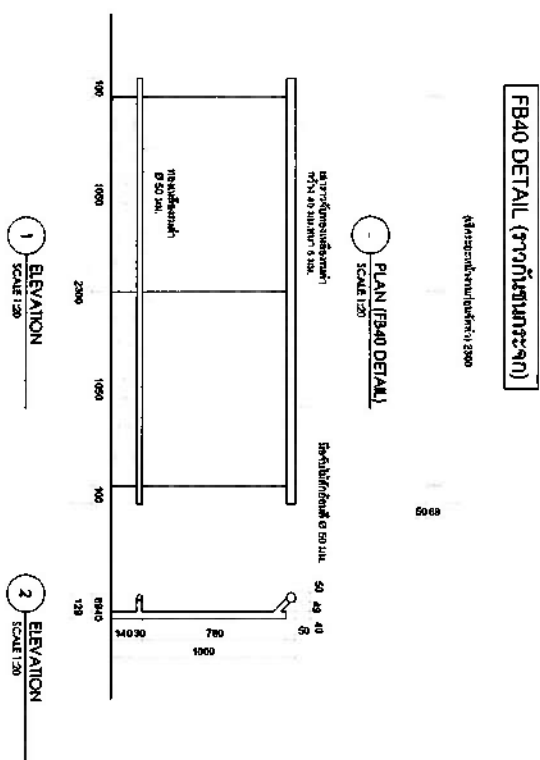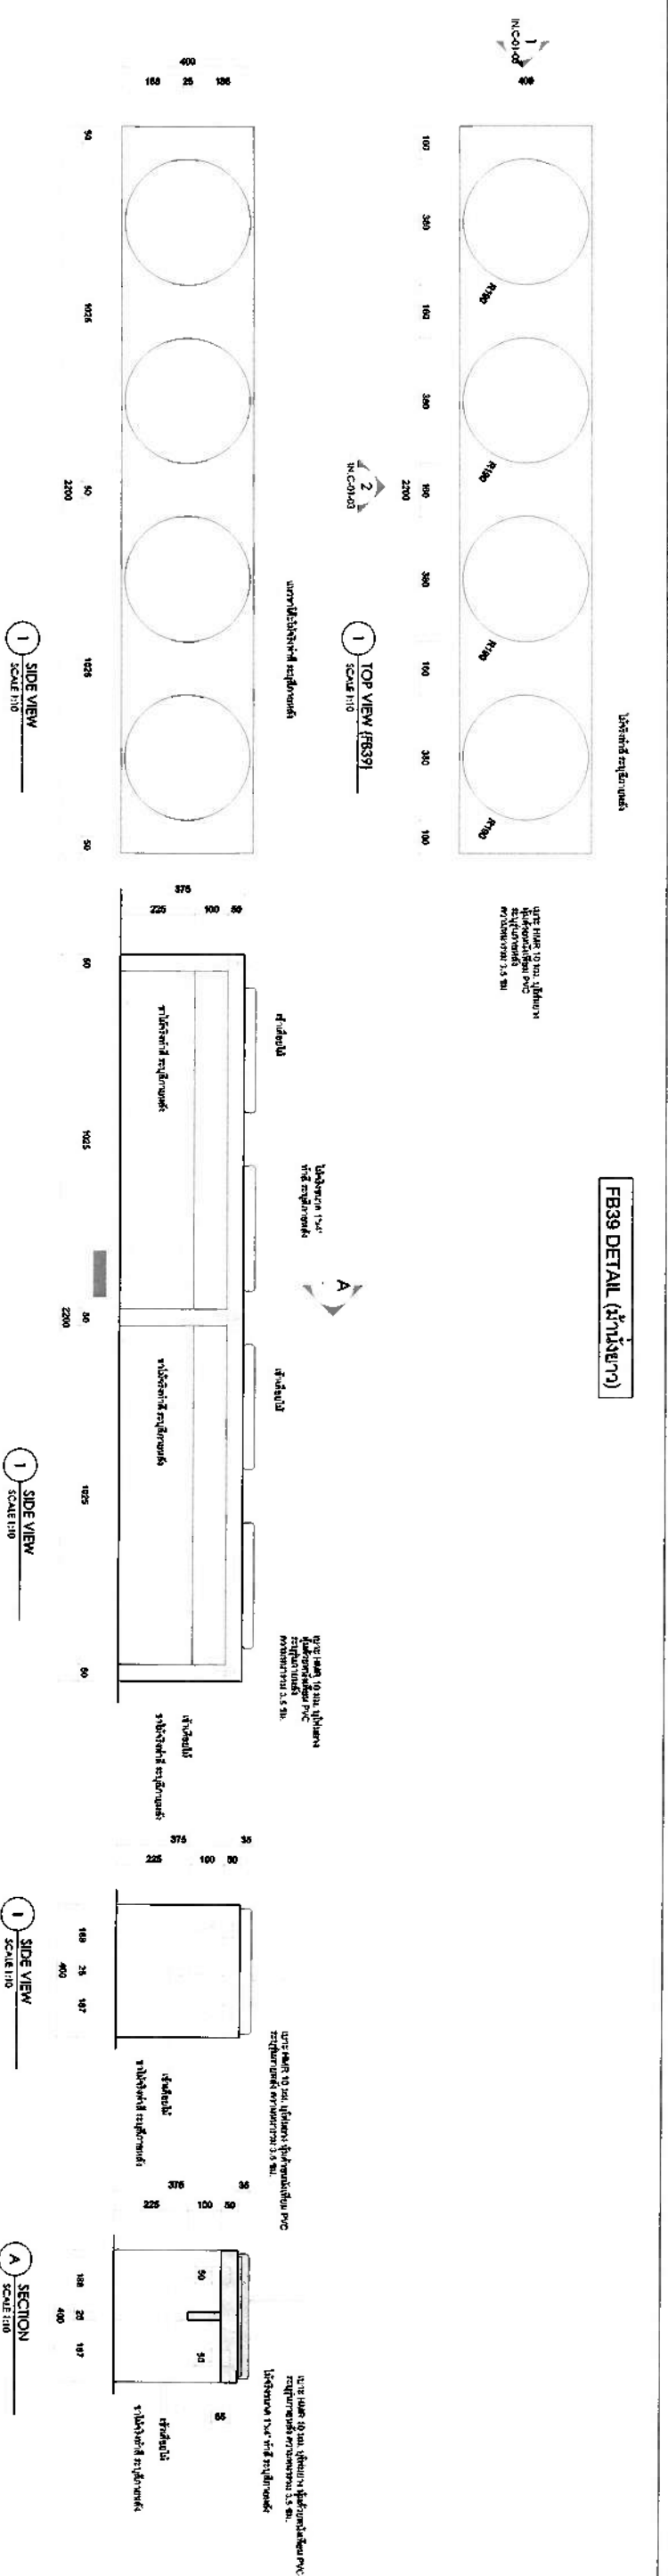


ห้องพยาบาลประจำบ้านพัก

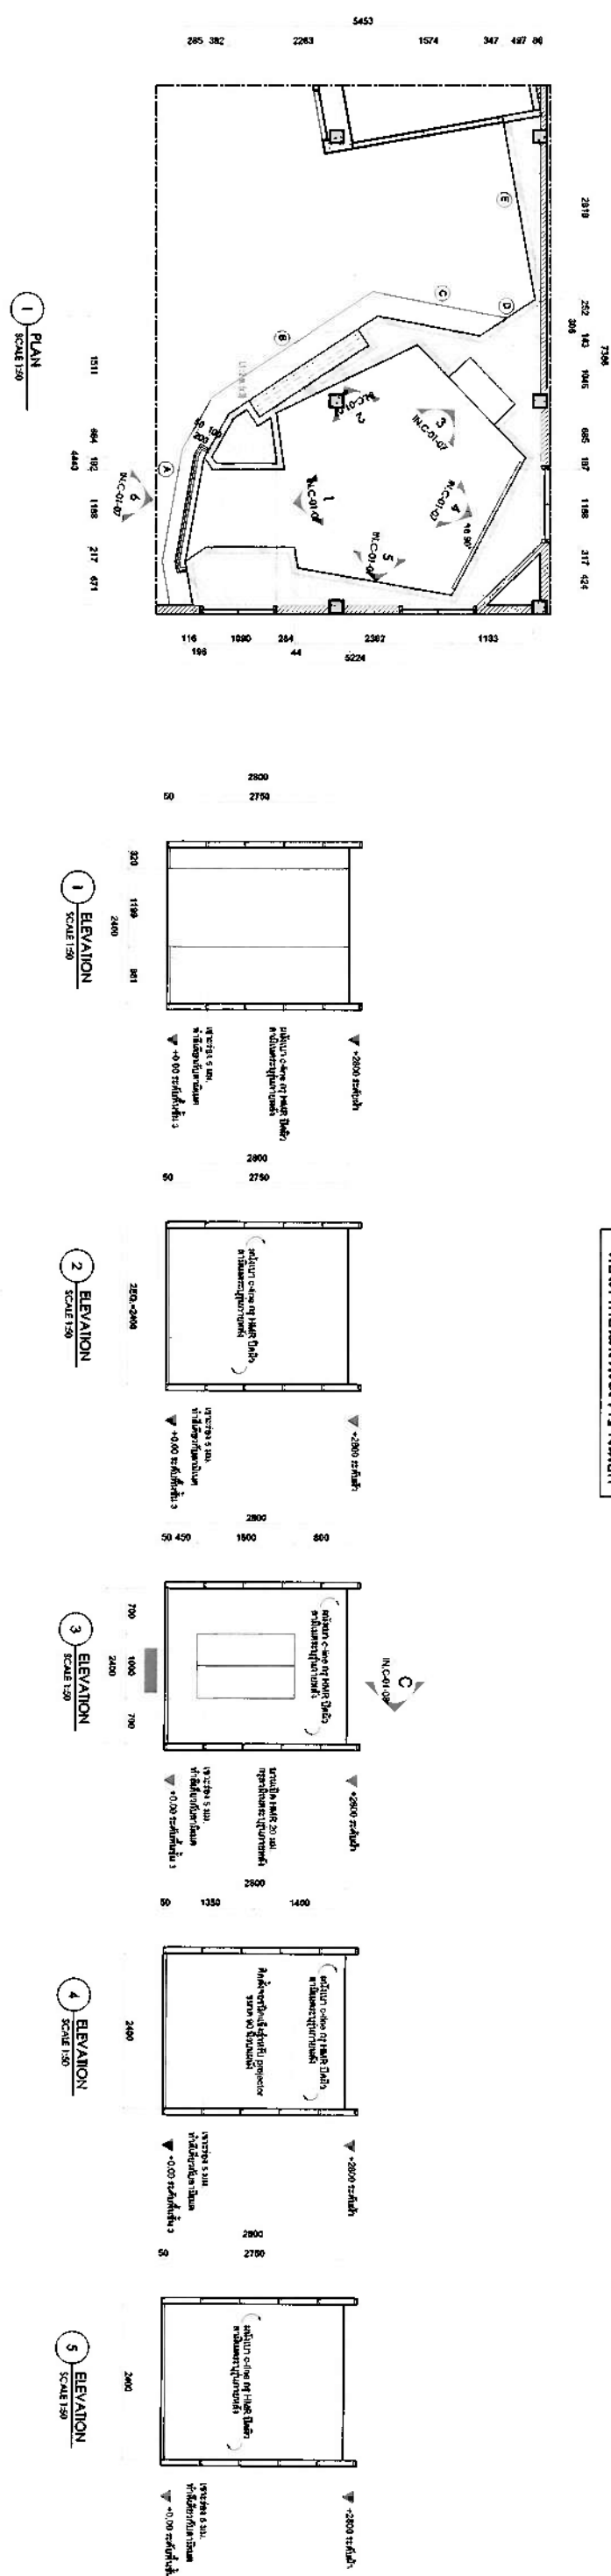

ELEVATION
SCALE 1:50

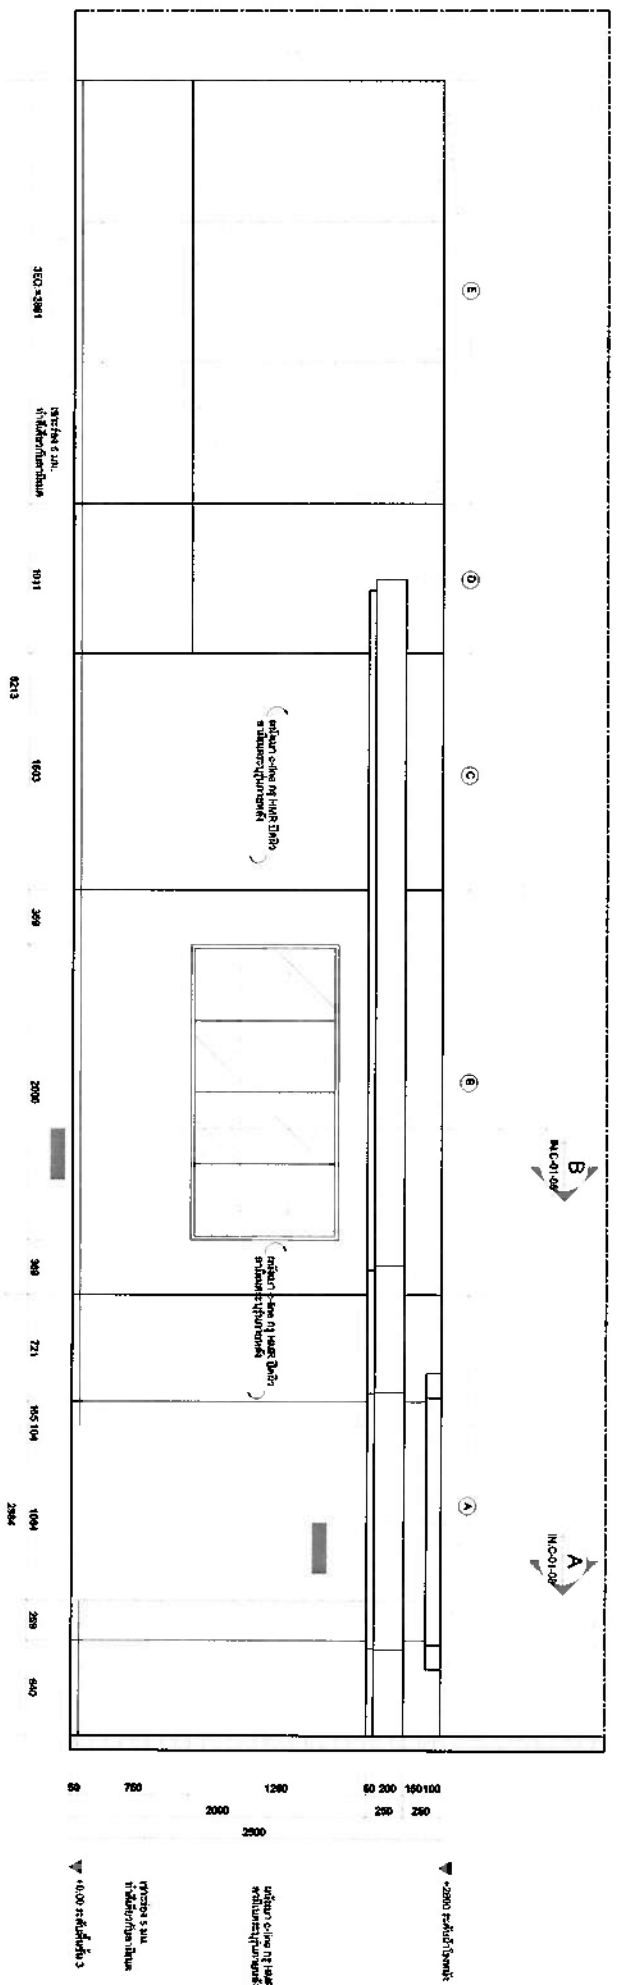


QIDAR	
Architectural Design & Construction	
Project Name: บ้านพัก	
Project Location: บ้านพัก	
Project No.: 1000	
Drawing No.: IN-C-01-07	
Scale: 1:50	
Date: 10/10/2563	
Drawn by: [Signature]	
Checked by: [Signature]	
Project Title: บ้านพัก	
Project Location: บ้านพัก	
Project No.: 1000	
Drawing No.: IN-C-01-07	
Scale: 1:50	
Date: 10/10/2563	
Drawn by: [Signature]	
Checked by: [Signature]	

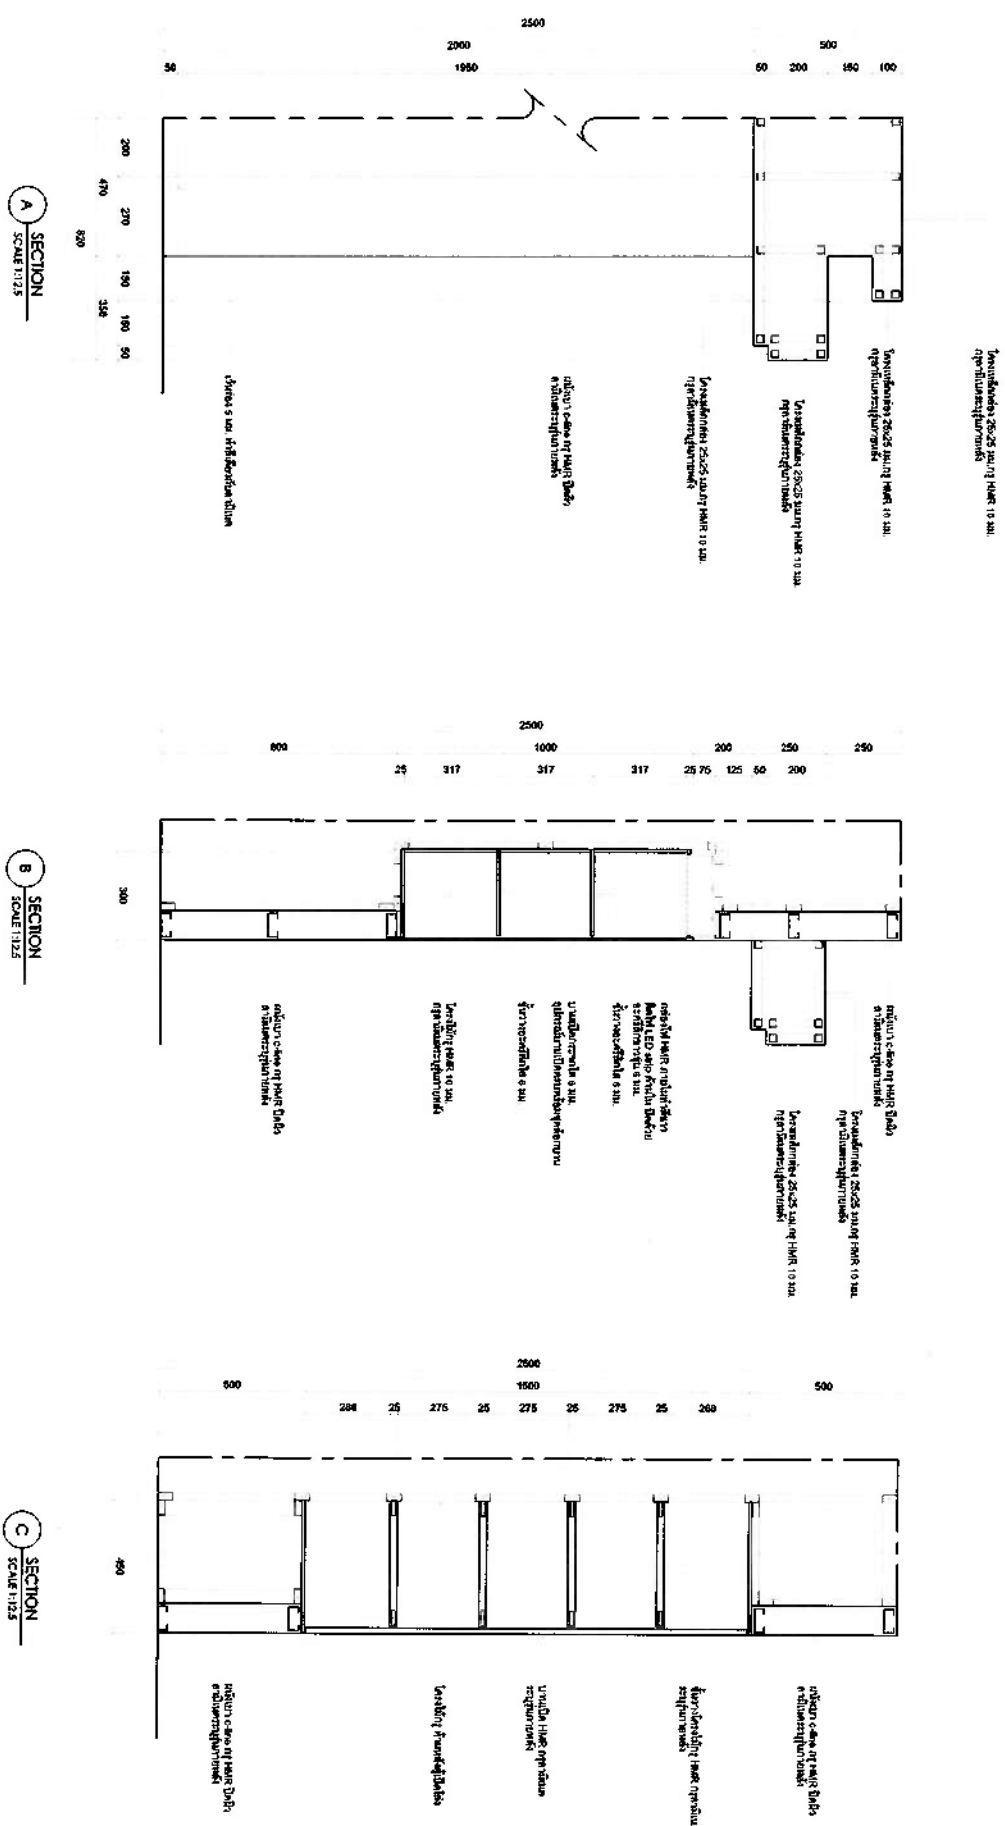


Handwritten signatures and initials, including a large signature at the top, a signature in the middle, and initials at the bottom.


บ้านของโหม่น

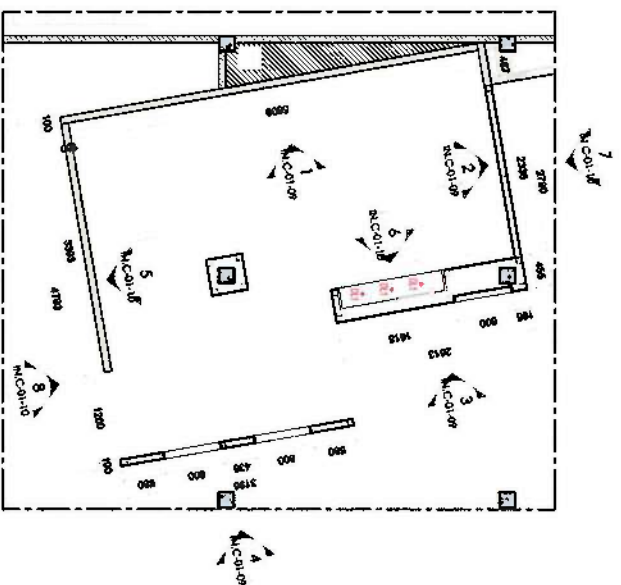


1
PLAN
SCALE 1:50

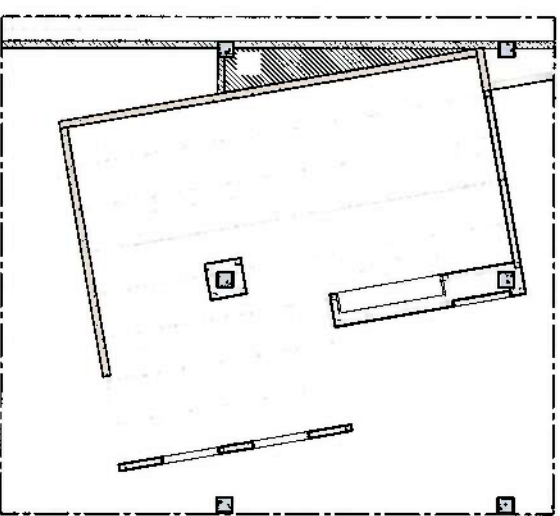


1
PLAN
SCALE 1:50

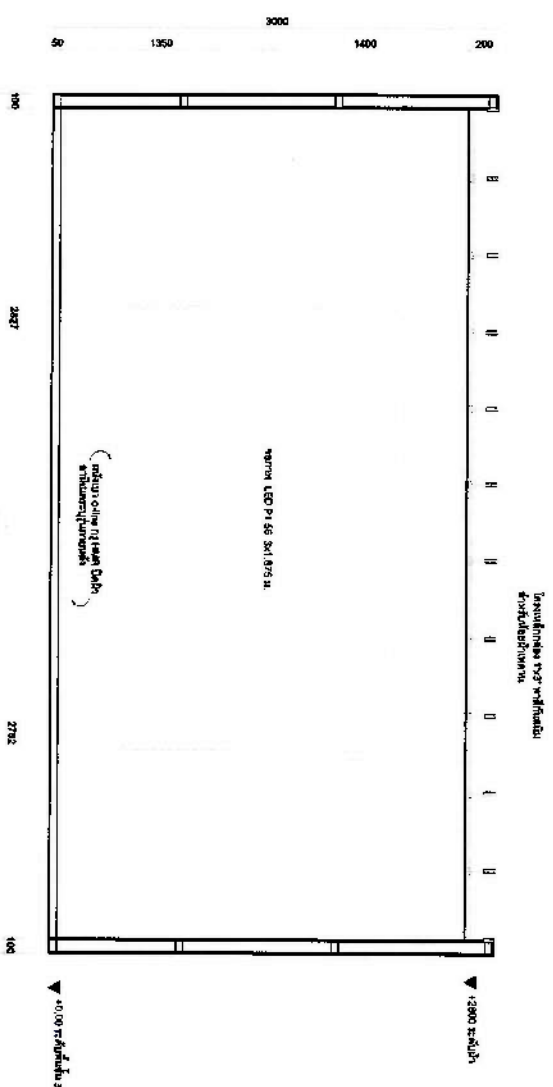


1 **ELEVATION**
SCALE 1:25

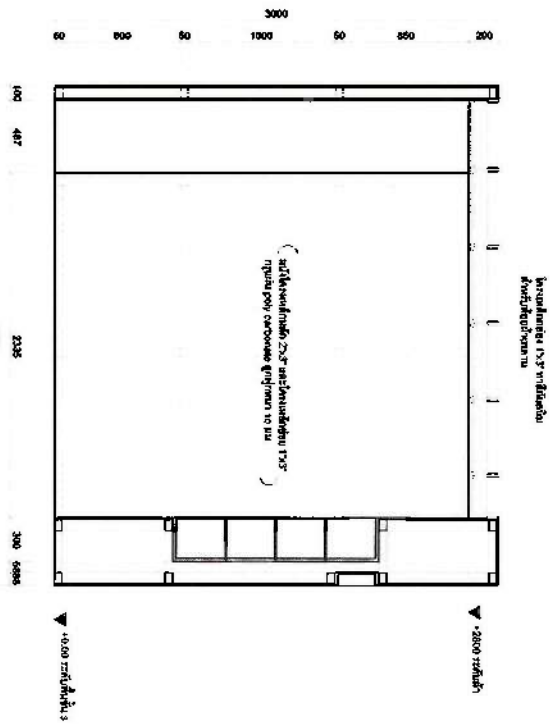

2
ELEVATION
SCALE 1"=25'

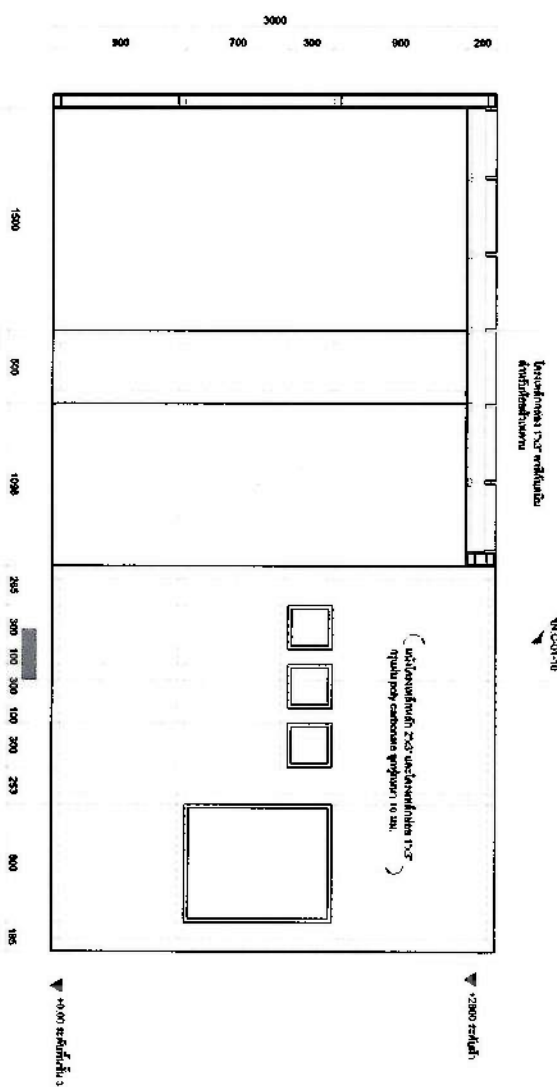


3 ELEVATION
SCALE 1/25

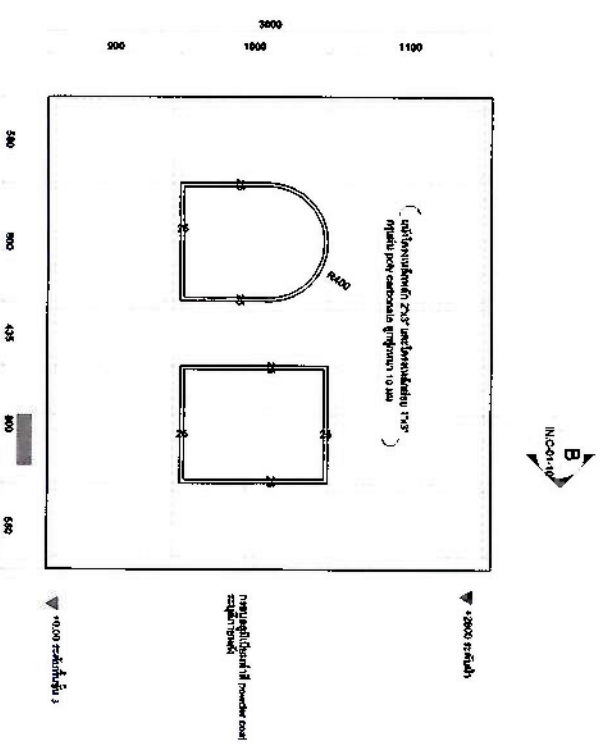

4 ELEVATION
SCALE 1/25


[illegible]

အောက်ဖက်မြင်မြင်ကွင်း

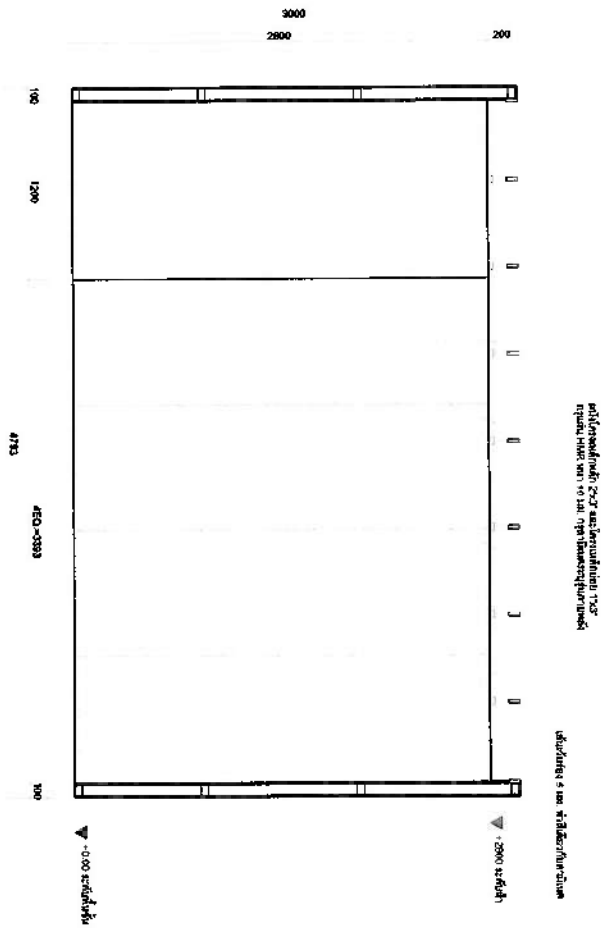


5 ELEVATION SCALE 1:25


ဘယ်လ်မြင်

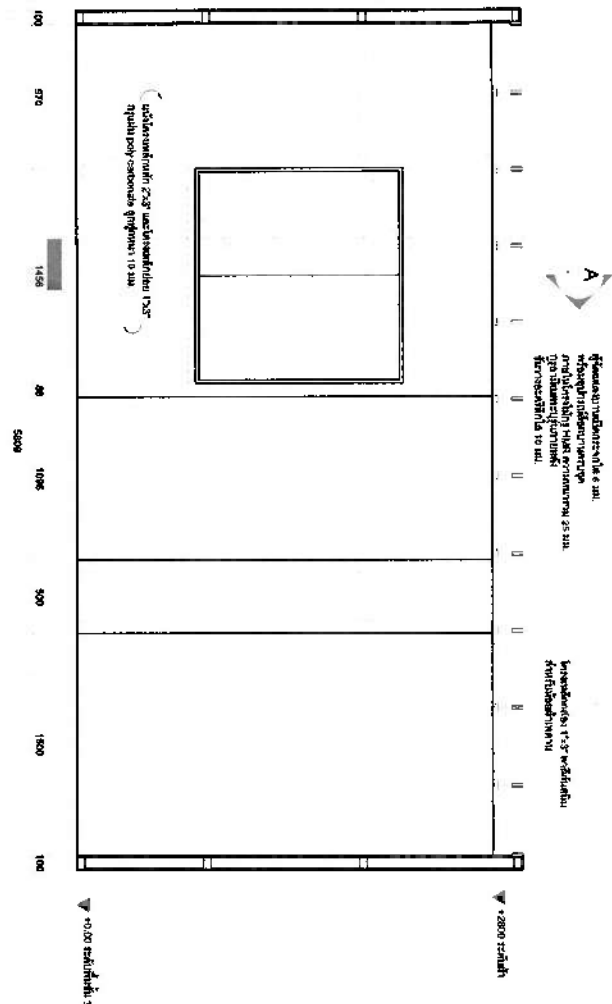

6 ELEVATION SCALE 1:25

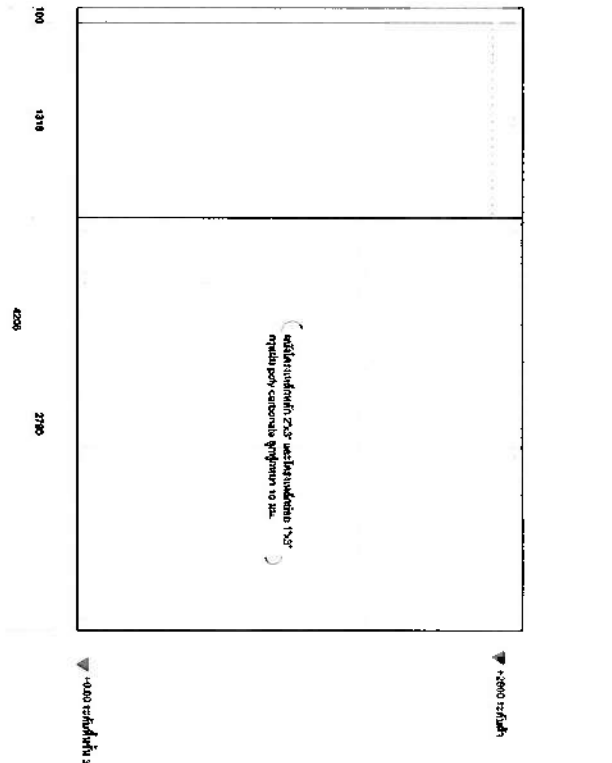

7 ELEVATION SCALE 1:25

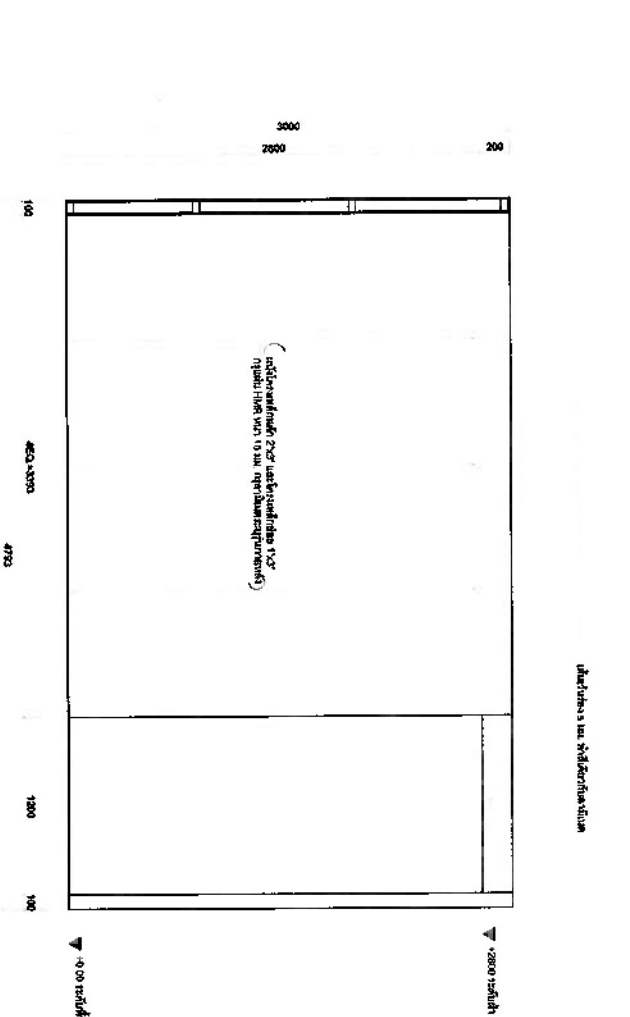

8 ELEVATION SCALE 1:25


A SECTION SCALE 1:7.5

B SECTION SCALE 1:7.5

1 DETAIL SCALE 1:2

PROJECT TITLE : စက်မှုဆေးကွက် 1x2		DRAWING TITLE : 3rd FLOOR	
PROJECT NO. : IN-C-01-10		DRAWING NO. : IN-C-01-10	
PROJECT LOCATION : စက်မှုဆေးကွက် 1x2		PROJECT DATE : 2023	
PROJECT OWNER : စက်မှုဆေးကွက် 1x2		PROJECT ARCHITECT : စက်မှုဆေးကွက် 1x2	
PROJECT ENGINEER : စက်မှုဆေးကွက် 1x2		PROJECT DRAFTER : စက်မှုဆေးကွက် 1x2	
PROJECT CHECKER : စက်မှုဆေးကွက် 1x2		PROJECT APPROVER : စက်မှုဆေးကွက် 1x2	

[illegible][illegible][illegible][illegible][illegible][illegible]

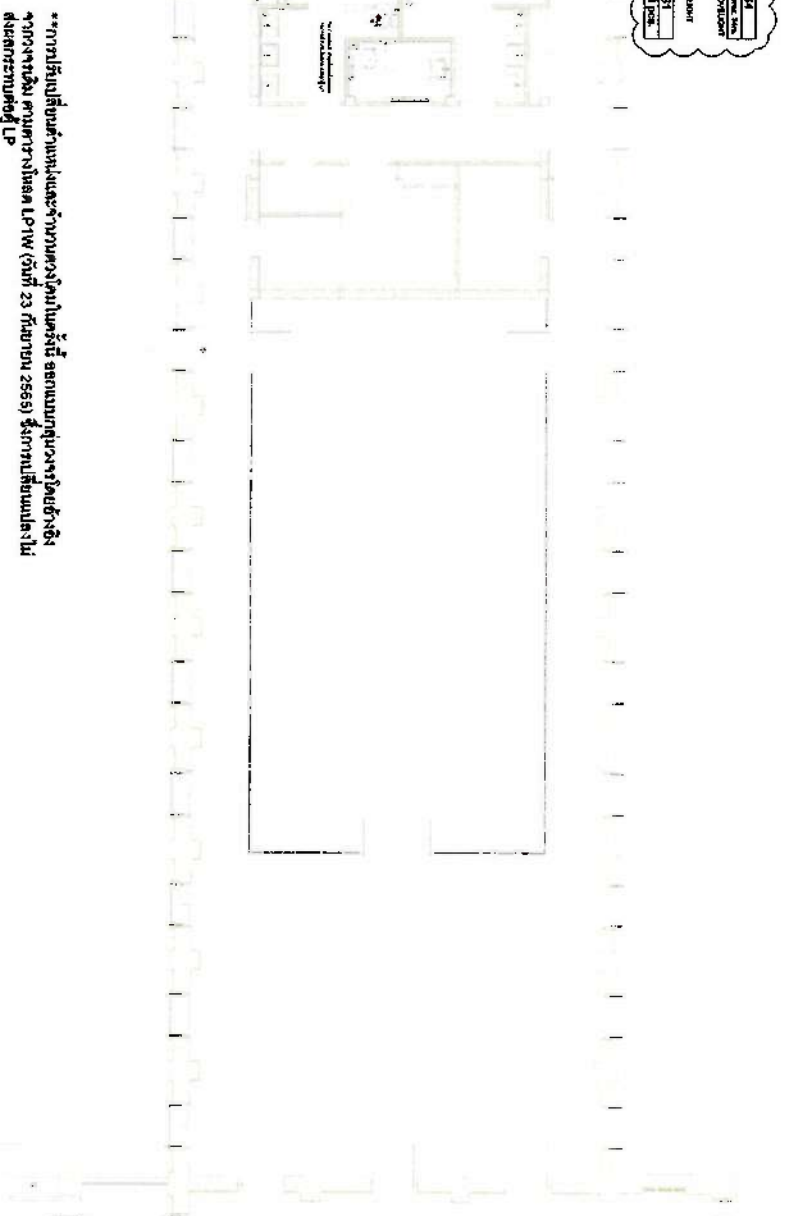

LIGHTING FIXTURE LEGEND		
Symbol	Qty.	Description
	over	
	40 pos.	Recessed downray - adjustable UGR 19 LED 15W, 650lm, CRI90 Color temp. 4000K, beam angle: fixed 60° Dimensions: Ø232mm, 40mm high Order with: #220 Downrout Trim
	34	LED SPC with stainless steel trim Color temp. 4000K, beam: 60° up Dimensions: 812mm H x 125mm W

[illegible]


100


--	--

4

21

JOB NO. :	CHECKED :
SCALE :	DATE :
DRAWING :	DRAWING NO. :
	EE.A-01

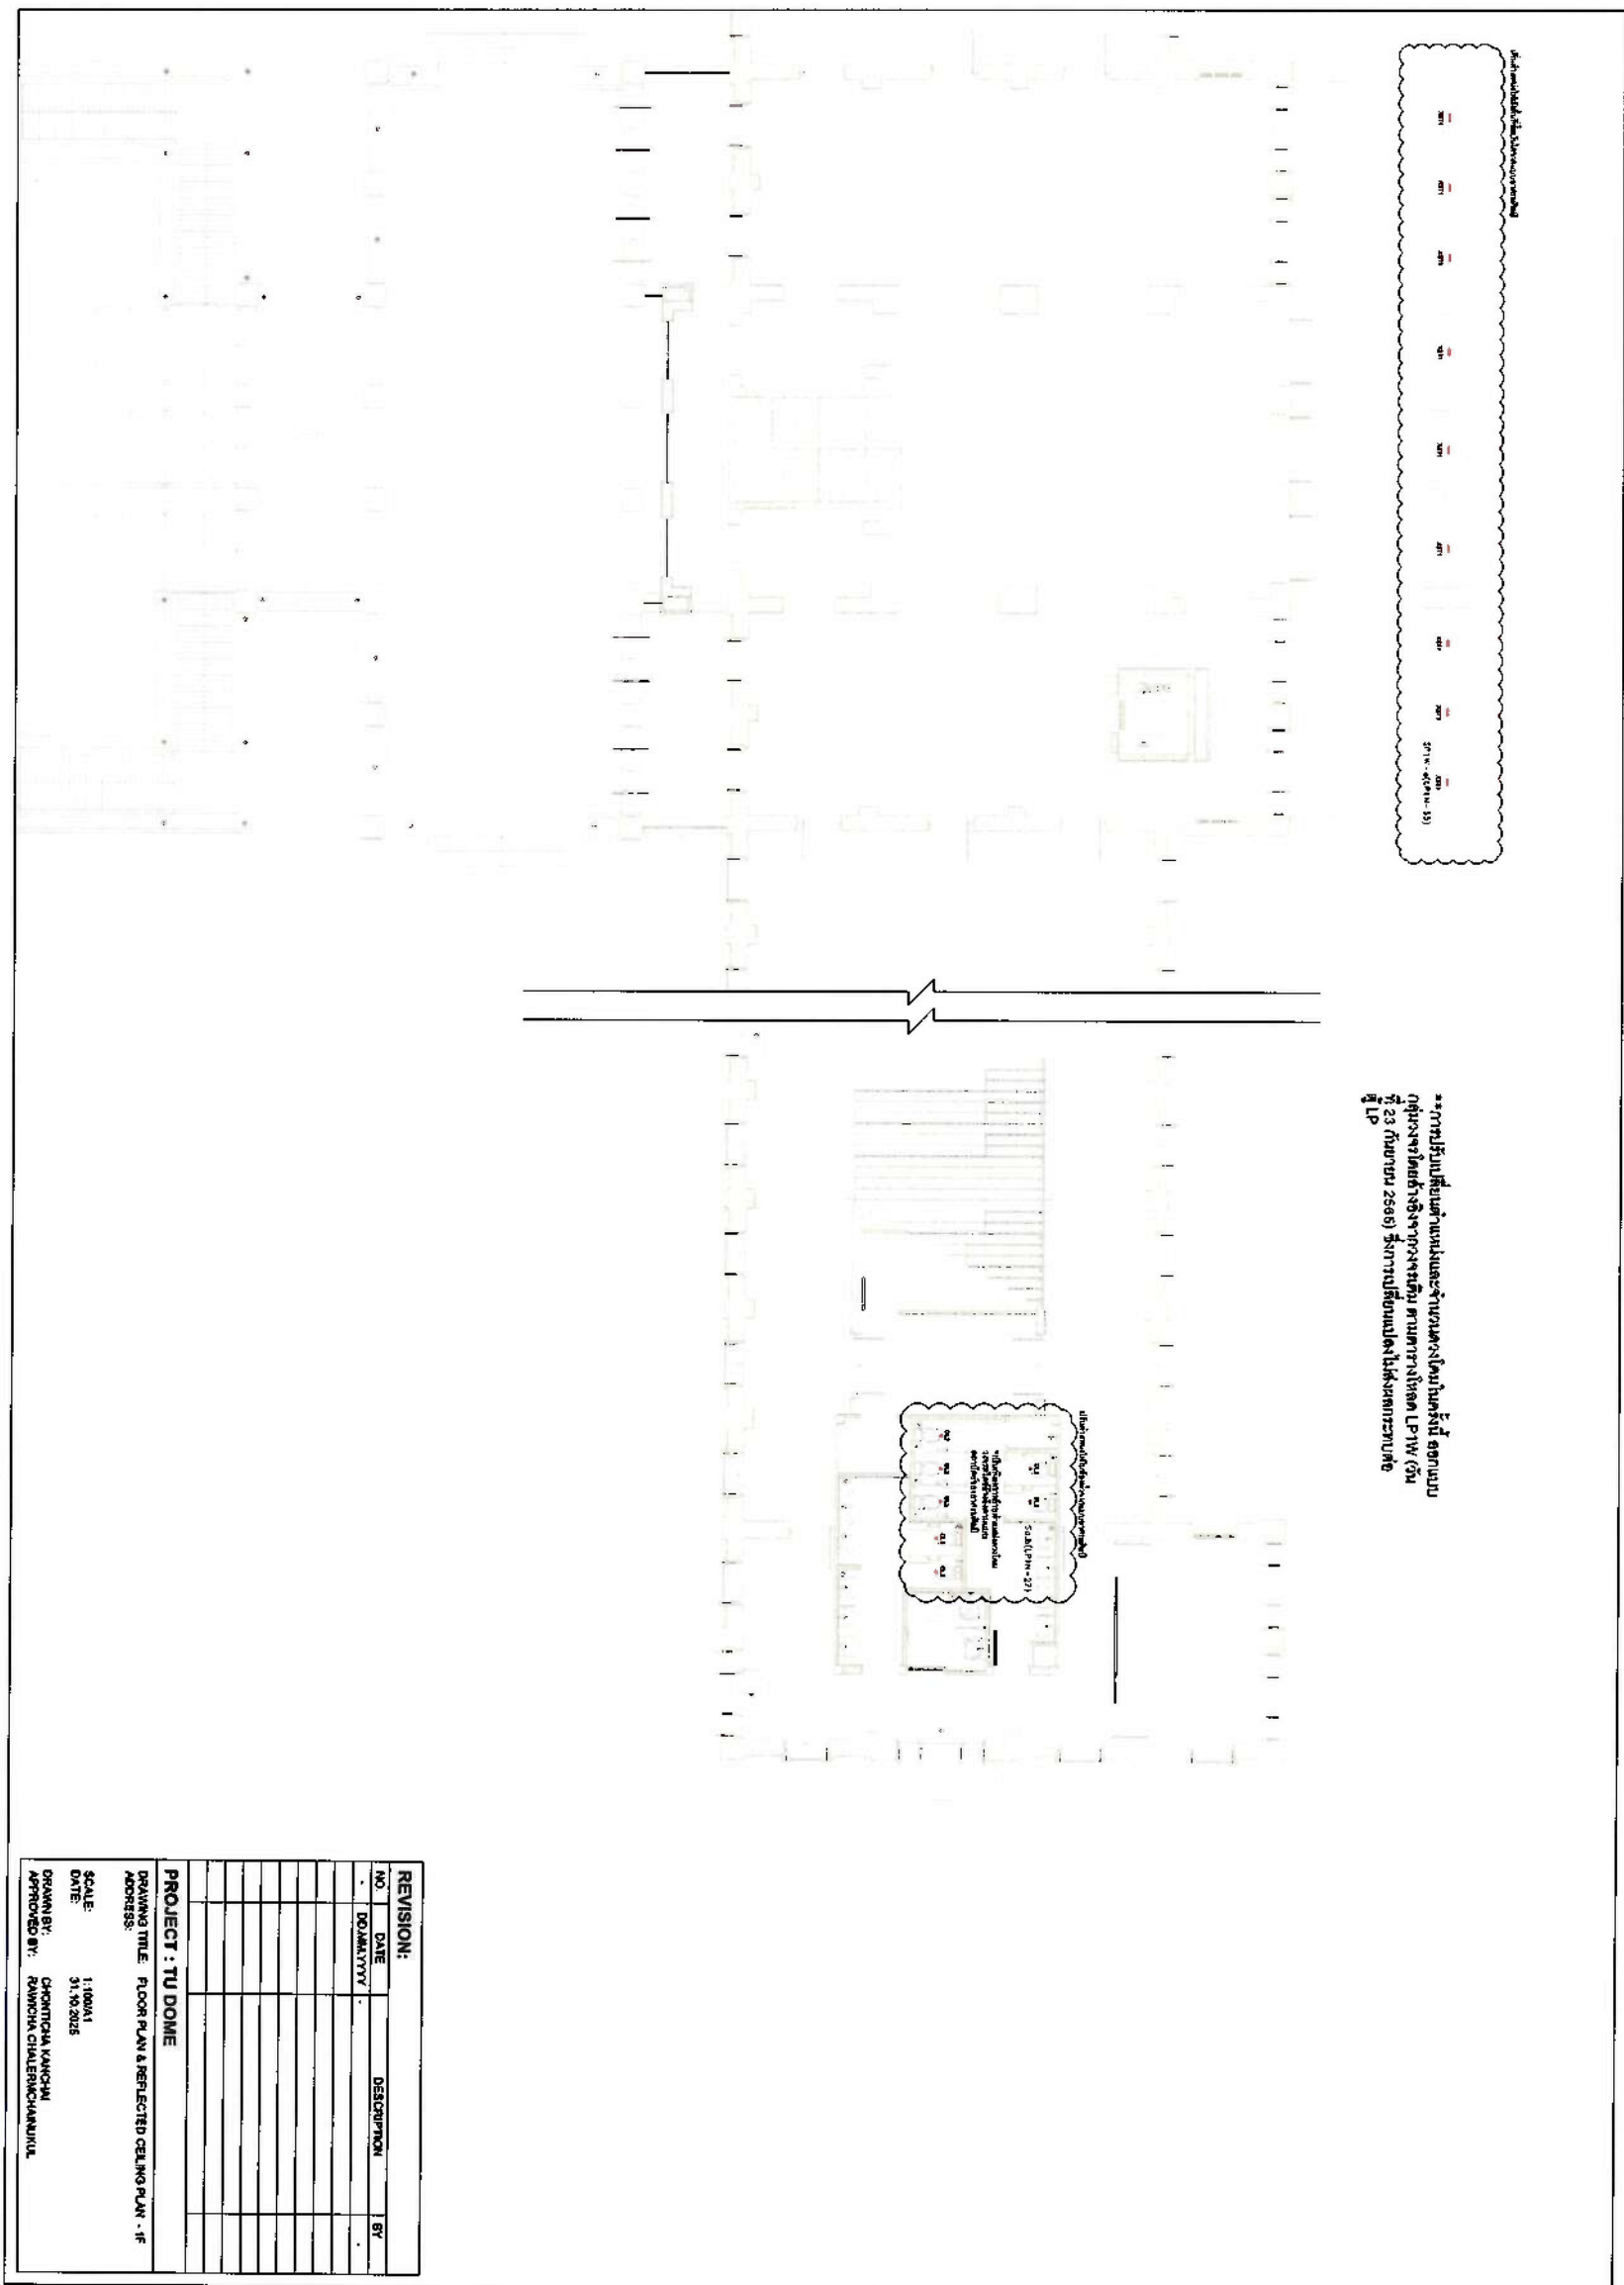[illegible]

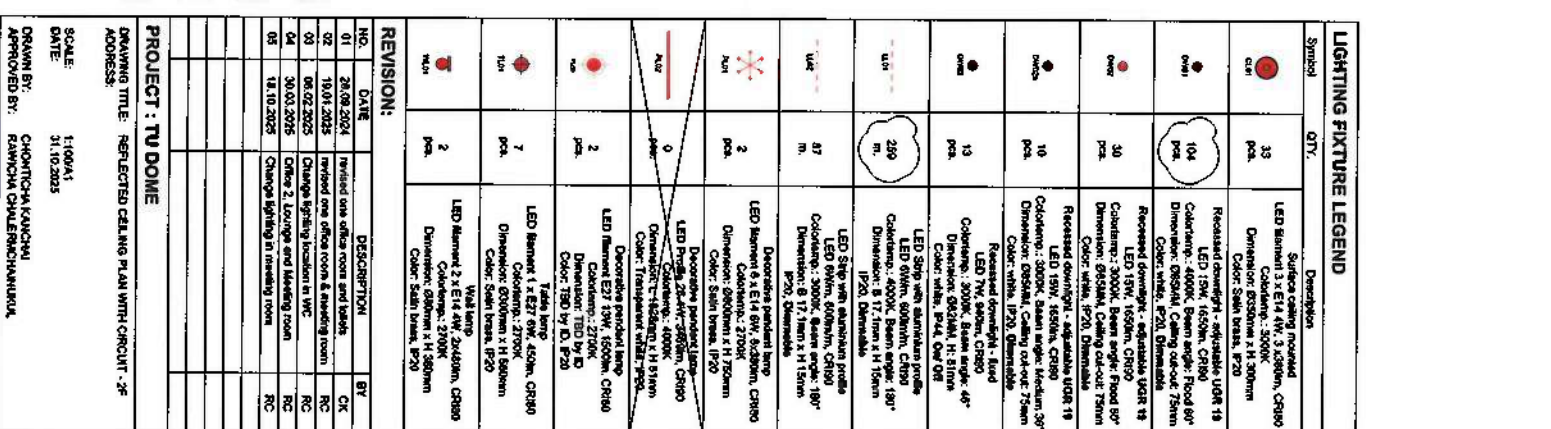


Symbol	QTY.	Description
 CR11	33 pck.	Super output mounted LED standard 3 x E14 4W, 3.550mm, CR800 Casting: 3000K Diameter: 85mm max. x 14mm Color: 2500mK, P20
 CR11	104 pck.	Recessed downlight - adjustable UGR 19 LED 15W, 4500K, Beam angle: Flood 60° Casting: 4000K, Beam angle: Flood 60° Diameter: Ø85x140, Ceiling cut-out: 75mm Color: white, P20, Dimmable
 CR11	30 pck.	Recessed downlight - adjustable UGR 19 LED 15W, 4500K, CR800 Casting: 3000K, Beam angle: Flood 60° Diameter: Ø85x140, Ceiling cut-out: 75mm Color: white, P20, Dimmable
 CR11	10 pck.	Recessed downlight - adjustable UGR 19 LED 15W, 4500K, CR800 UGR 19 Casting: 3000K, Beam angle: Flood 60° Diameter: Ø85x140, Ceiling cut-out: 75mm Color: white, P20, Dimmable
 CR11	13 pck.	Recessed downlight - fixed LED 7W, 4500K, CR800 Casting: 3000K, Beam angle: 40° Diameter: Ø65x100, Ceiling cut-out: 60mm Color: white, P14, CR 012
 CR11	230 m.	LED strip with standard profile LED 0400m, 50000lm, CR191 Casting: 3000K, Beam angle: 180° Diameter: Ø 17, trim x 14mm IP20, Dimmable

REVISION:			
NO.	DATE	DESCRIPTION	BY
01	28/09/2024	Issued take off's note and take	CR
02	19/01/2025	Revised one office room & meeting room	RS
03	06/02/2025	Change lighting location in WC	RS
04	30/03/2025	Office 2, Lounge and Meeting room	RS
05	14/10/2025	Change lighting at meeting room	RS

PROJECT : TV DOME	
DRAWING TITLE :	REFLECTED CEILING PLAN WITH CIRCUIT -2F
ADDRESS:	
SCALE:	1:1000A1
DWG DATE:	31.07.2023
DRAWN BY:	CHHOTIKHA KANCHAN
APPROVED BY:	RAVIPRAKASH CHAKRABARTI

 [illegible]



ELECTRICAL FIXTURE LEGEND			
Symbol	QTY.	Description	
	4 pts.	Double power outlets L.I.A.N. CASE (wiring to router)	
	20 pts.	Double power outlets	
	2 pts.	Double power outlet (Floor mounted)	
	1 pts.	Access point (Ceiling mounted)	